


NOTES:

- Customers are responsible for confirming mounting heights, fixture suspension types/ lengths, color temperature, CRI, linear fixture lengths, pole lengths, and bollard heights/ lengths prior to ordering.
- Mounting height (MH) is measured from the bottom of the fixture to the floor.
- This Lighting layout assumes the following unless values are specified and must be confirmed by the customer prior to ordering.
  - Color Temperature is 4000K
  - Room reflectance of 80, 50, 20 for standard ceilings and 50, 50, 20 for exposed ceilings
  - Wall sconces are mounted at 7 feet for calculations.



Label	Qty	Arrangement	LUF	Tag	Description	Lum. Watts	Total Watts	Lum. Lumens
OW	28	SINGLE	0.900	TRUSS	1800000K/30W	2800	25200	18000
OW	8	SINGLE	0.900	TRUSS	1800000K/30W	800	7200	5400
OW	30	SINGLE	0.900	TRUSS	1800000K/30W	3000	27000	18000
OW	12	SINGLE	0.900	TRUSS	1800000K/30W	1200	10800	8100

Label	Calculation Summary	UnitType	Units	Avg	Max	Min	Angle	MaxMin
NORTH BLDG PLAZA EAST Top	Illuminance	FC	1.12	10.88	0.00	N/A	N/A	N/A
NORTH BLDG PLAZA WEST Top	Illuminance	FC	0.88	2.12	0.00	N/A	N/A	N/A
PRELIMINARY PROPERTY LINE	Illuminance	FC	0.55	0.40	0.00	N/A	N/A	N/A
SOUTH BLDG PLAZA WEST Top	Illuminance	FC	0.85	2.15	0.00	N/A	N/A	N/A
NORTH PARKING	Illuminance	FC	1.37	2.33	0.53	2.87	1.53	17.62
NORTH PARKING ENTRY	Illuminance	FC	1.40	2.33	0.11	3.24	17.62	
SOUTH ENTRY	Illuminance	FC	1.14	2.89	0.28	3.83	19.28	

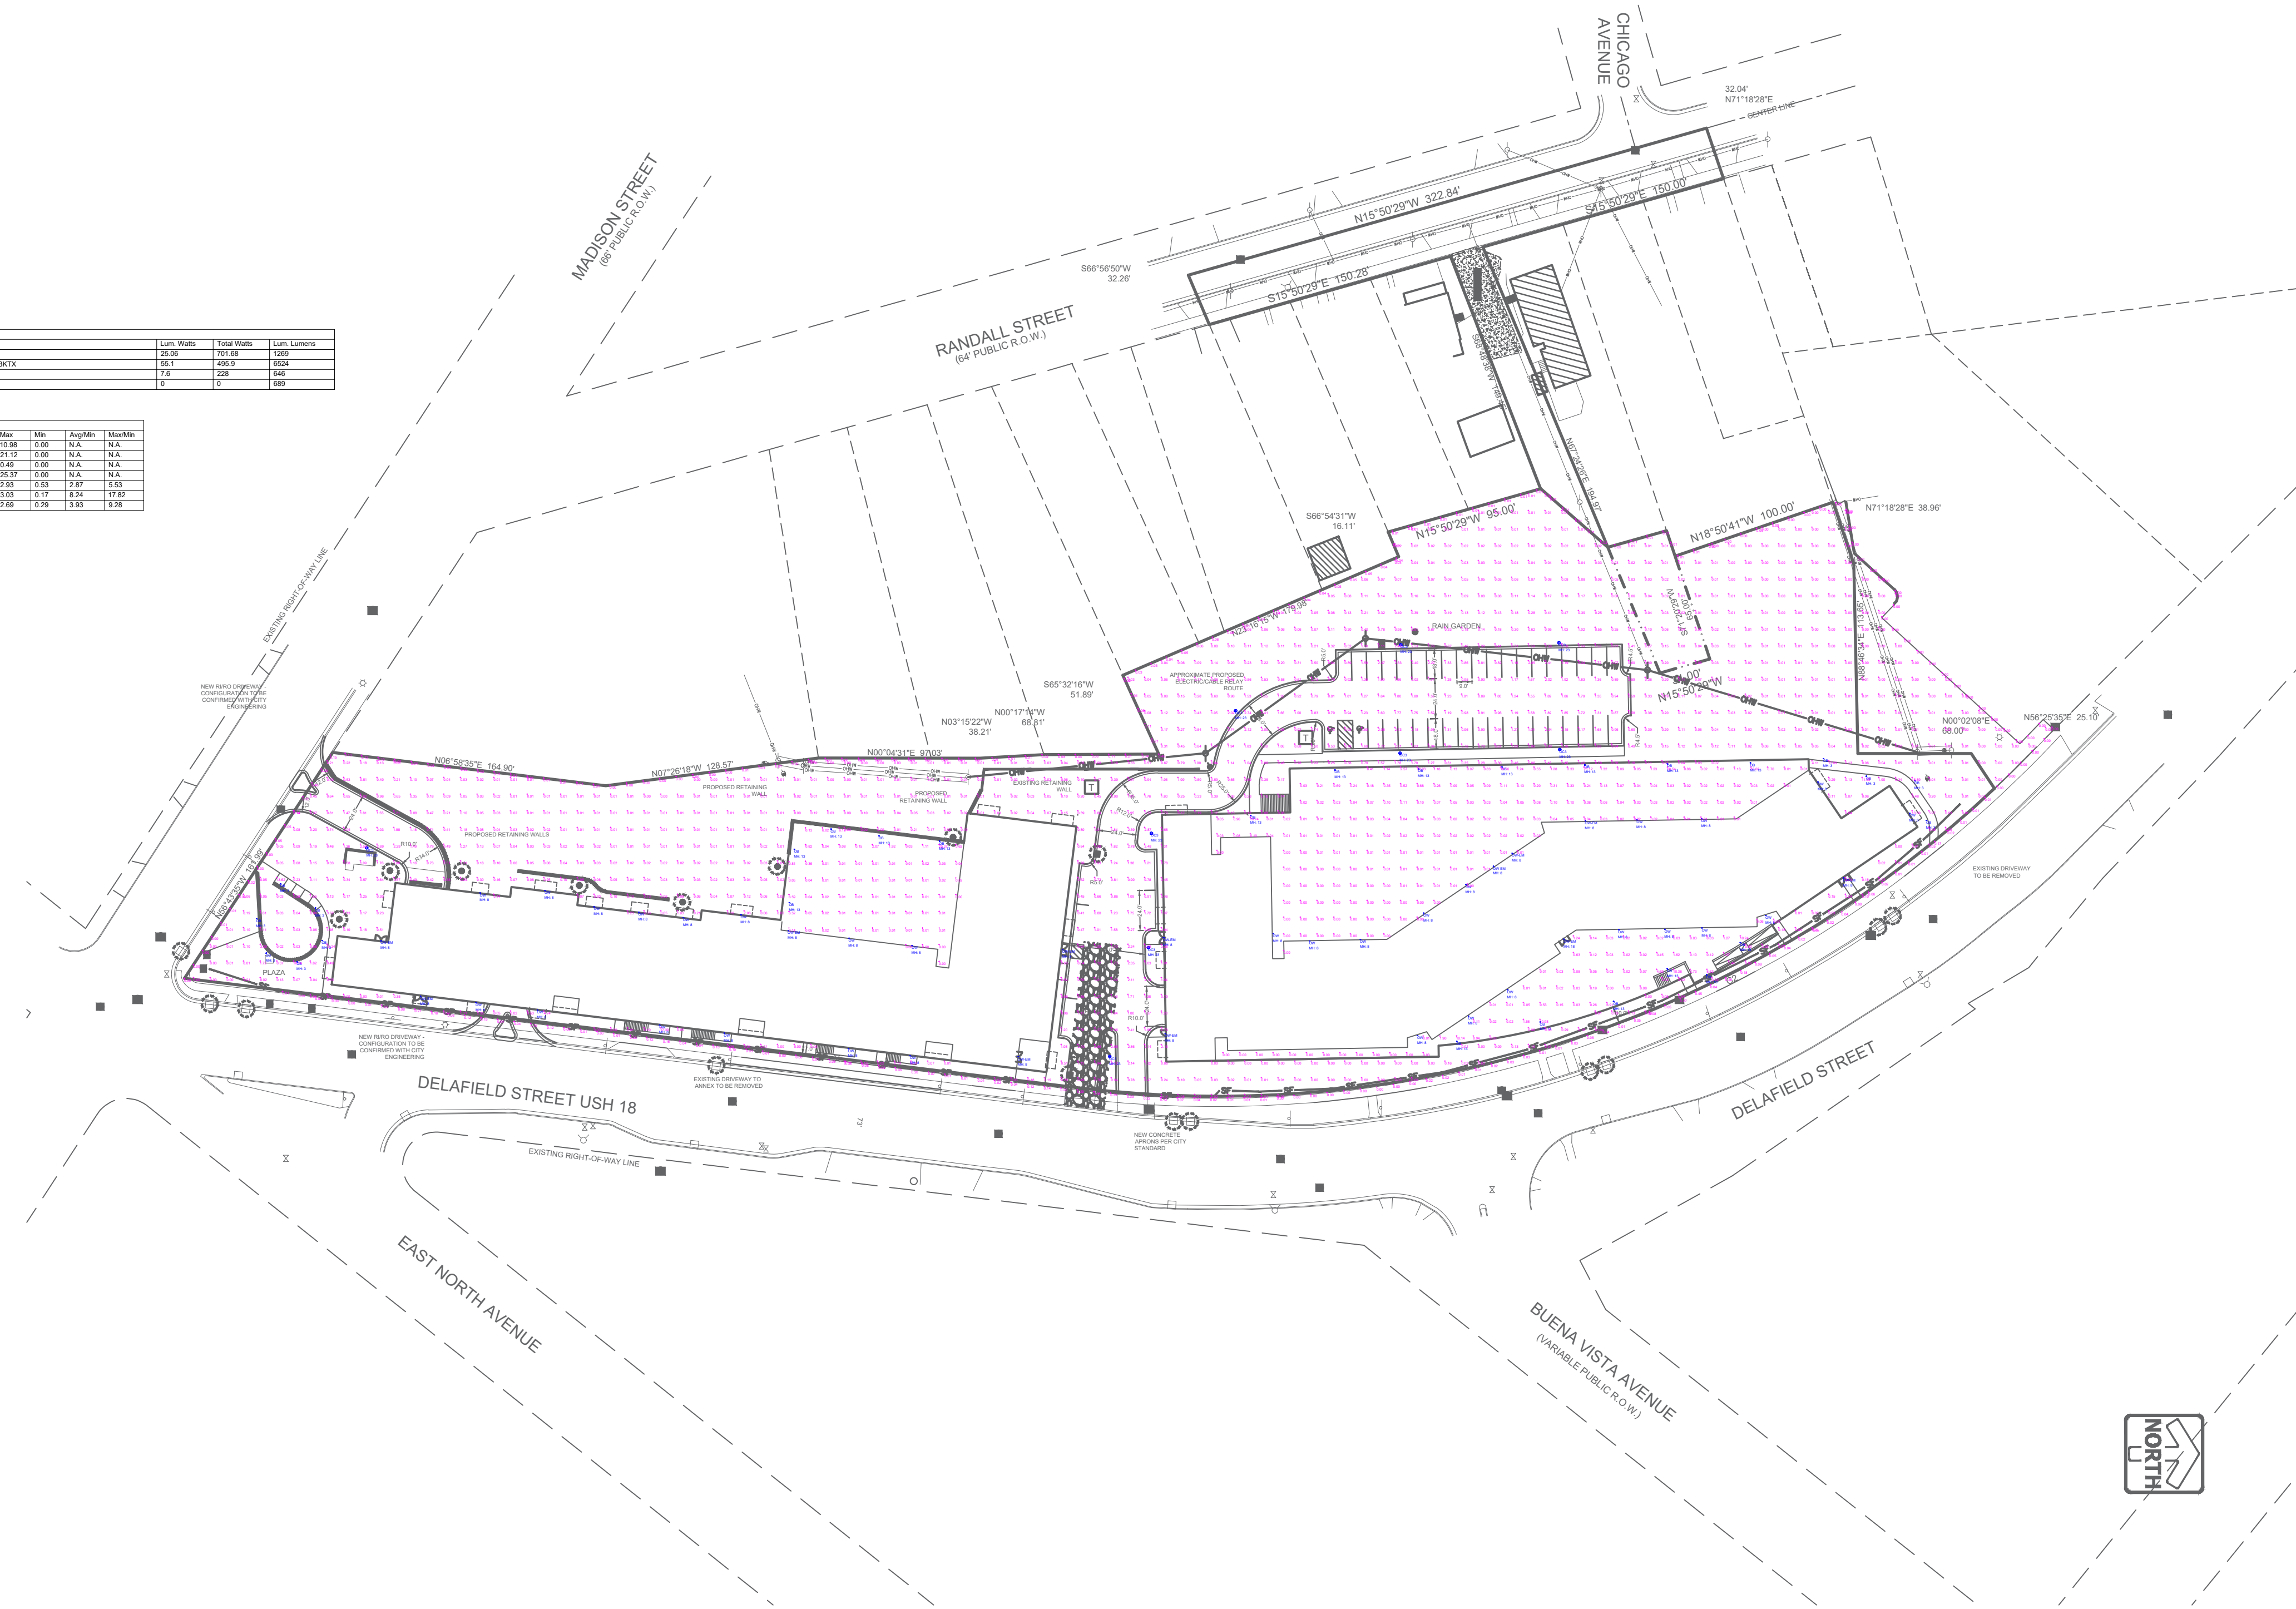

#	DATE	COMMENTS
REVISIONS		

DRAWN BY : LB	DATE : JUN 26, 2024	SCALE : 1/64" = 1'-0"
---------------	---------------------	-----------------------

DELAFIELD STREET APARTMENTS	WAUKESHA, WISCONSIN	SITE LIGHTING
-----------------------------	---------------------	---------------