

LEGEND:

- 896 --- - EXISTING MINOR CONTOUR.
- 895 --- - EXISTING MAJOR CONTOUR.
- OHEL — - OVERHEAD ELECTRIC LINE.
- BuEl — - BURIED ELECTRIC LINE.
- BuTel — - BURIED TELEPHONE LINE.
- FO — - FIBER OPTIC LINE.
- GAS — - GAS LINE.
- SAN — - SANITARY SEWER MAIN OR LATERAL.
- WAT — - WATER MAIN OR SERVICE.
- - STORM SEWER LINE.
- ELECTRIC METER.
- GAS METER.
- GAS VALVE.
- FIRE HYDRANT.
- POWER POLE.
- SANITARY SEWER MANHOLE.
- STORM SEWER MANHOLE.
- STORM SEWER INLET.
- TELEPHONE PEDESTAL.
- TRANSFORMER.
- WATER VALVE.

EXISTING BUILDING
FFE=809.75

REVISIONS:	
NO.	DESCRIPTION
1	XX-XX-XX XXXXXXXXXXXXXXXXXXXX

PSE

PARISH SURVEY & ENGINEERING
122 Wisconsin Street, West Bend, WI 53095
262.346.7800 www.parishse.com

PROJECT TITLE:
**RESOURCE RECYCLING LLC
220 SOUTH PRAIRIE AVENUE
WAUKESHA, WI 53186**

PLAN TITLE:
**EXISTING CONDITIONS/
DEMOLITION
PLAN**

DRAWN BY:
KJP

DESIGNED BY:
KJP


CHECKED BY:
KJP

PLAN DATE:
2/27/2024

PROJECT NO:
\PC-10-24

FINAL

SHEET NO:
C1.01

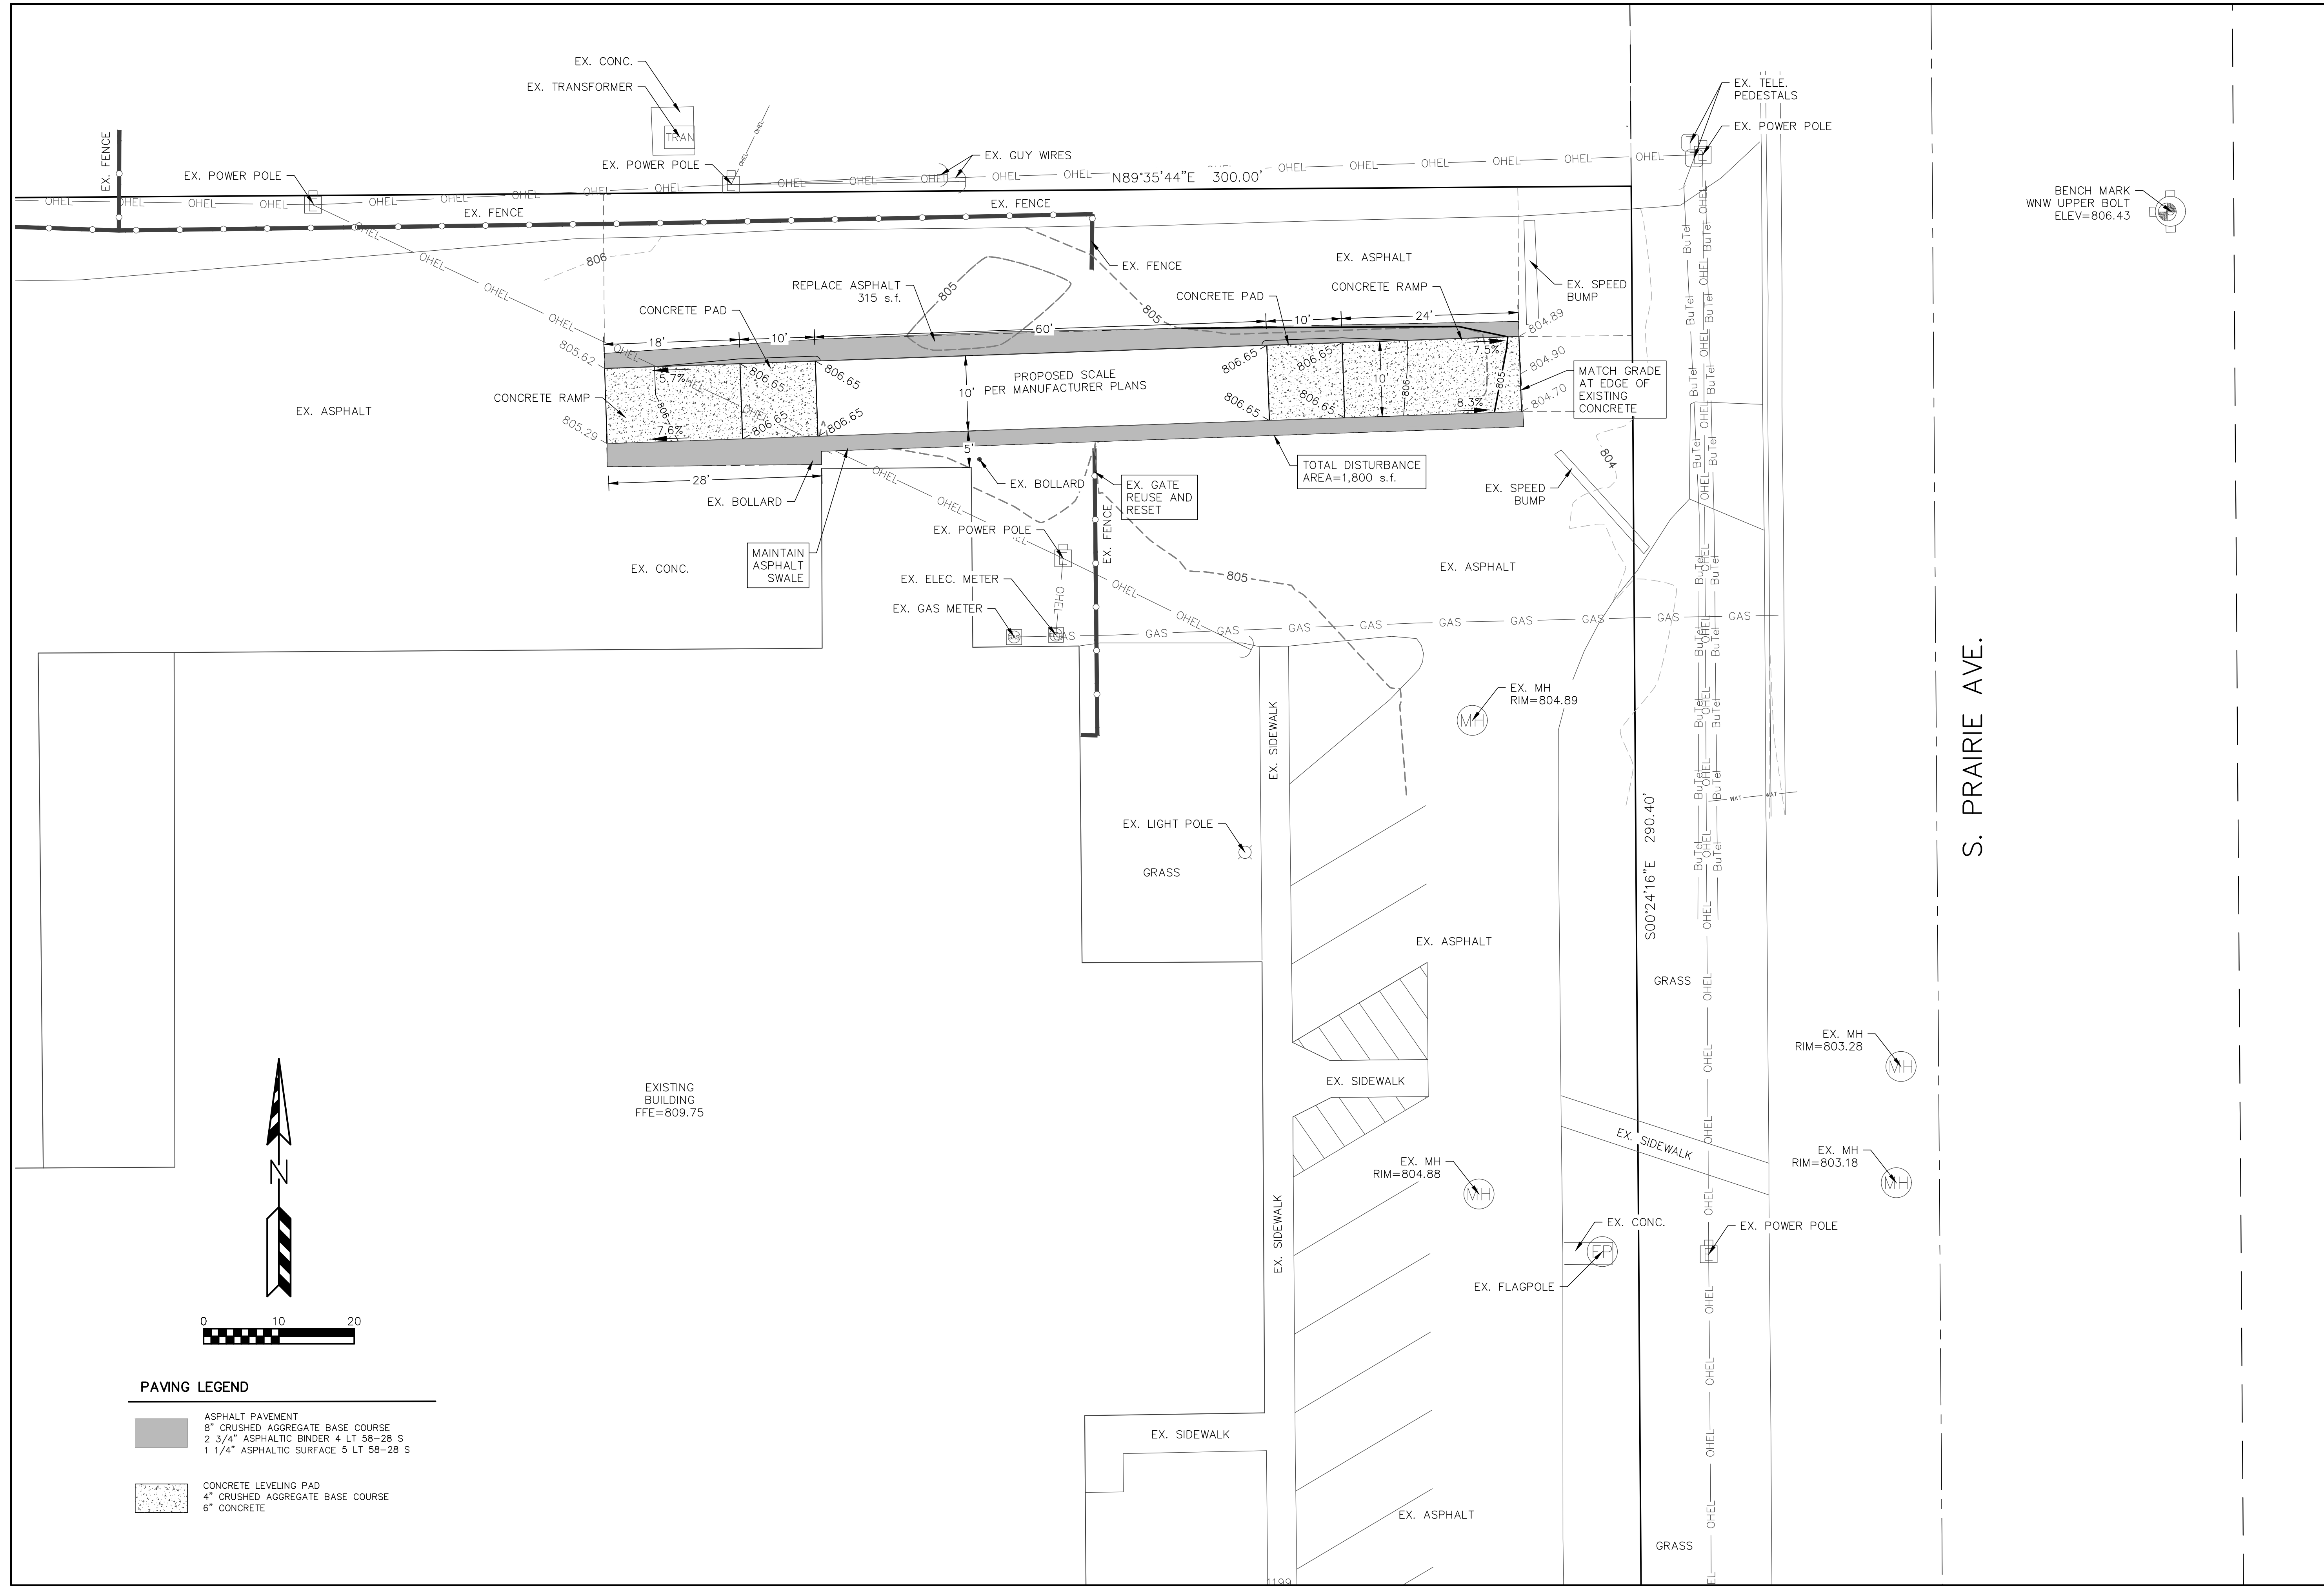

REVISIONS:	
NO.	DATE DESCRIPTION
1	XX-XX-XX XXXXXXXXXXXXXXXXXXXX

PSE
 PARISH SURVEY & ENGINEERING
 122 Wisconsin Street, West Bend, WI 53095
 262.346.7800
 www.parishse.com

PROJECT TITLE:
**RESOURCE RECYCLING LLC
 220 SOUTH PRAIRIE AVENUE
 WAUKESHA, WI 53186**

PLAN TITLE:
**PROPOSED
 SITE PLAN**

DRAWN BY:
KJP
 DESIGNED BY:
KJP
 CHECKED BY:
KJP

PLAN DATE:
2/27/2024

PROJECT NO:
\PC-10-24

FINAL

SHEET NO:
C1.02