


- DEMOLITION NOTES:**
- ▽ REMOVE EXISTING WALLS & PATCH FLOOR
  - ▽ REMOVE WALL AREA FOR NEW DOORS
  - ▽ REMOVE CARPETING/VINYL FLOORING
  - ▽ REMOVE EXISTING WINDOWS/KNEE WALL
  - ▽ REMOVE DOOR AND FRAME
  - ▽ REMOVE EXISTING HANDRAIL
  - ▽ REMOVE EXISTING CABINETS
  - ▽ REMOVE EXISTING CONCRETE STOOP
  - ▽ REMOVE EXISTING PLUMBING FIXTURES
  - ▽ REMOVE EXISTING COLUMNS
  - ▽ REMOVE EXISTING DECK
  - ▽ REMOVE EXISTING WINDOWS
  - ▽ REMOVE EXISTING EXITING CEILING/FRAMING
  - ▽ REMOVE EXISTING DUCT

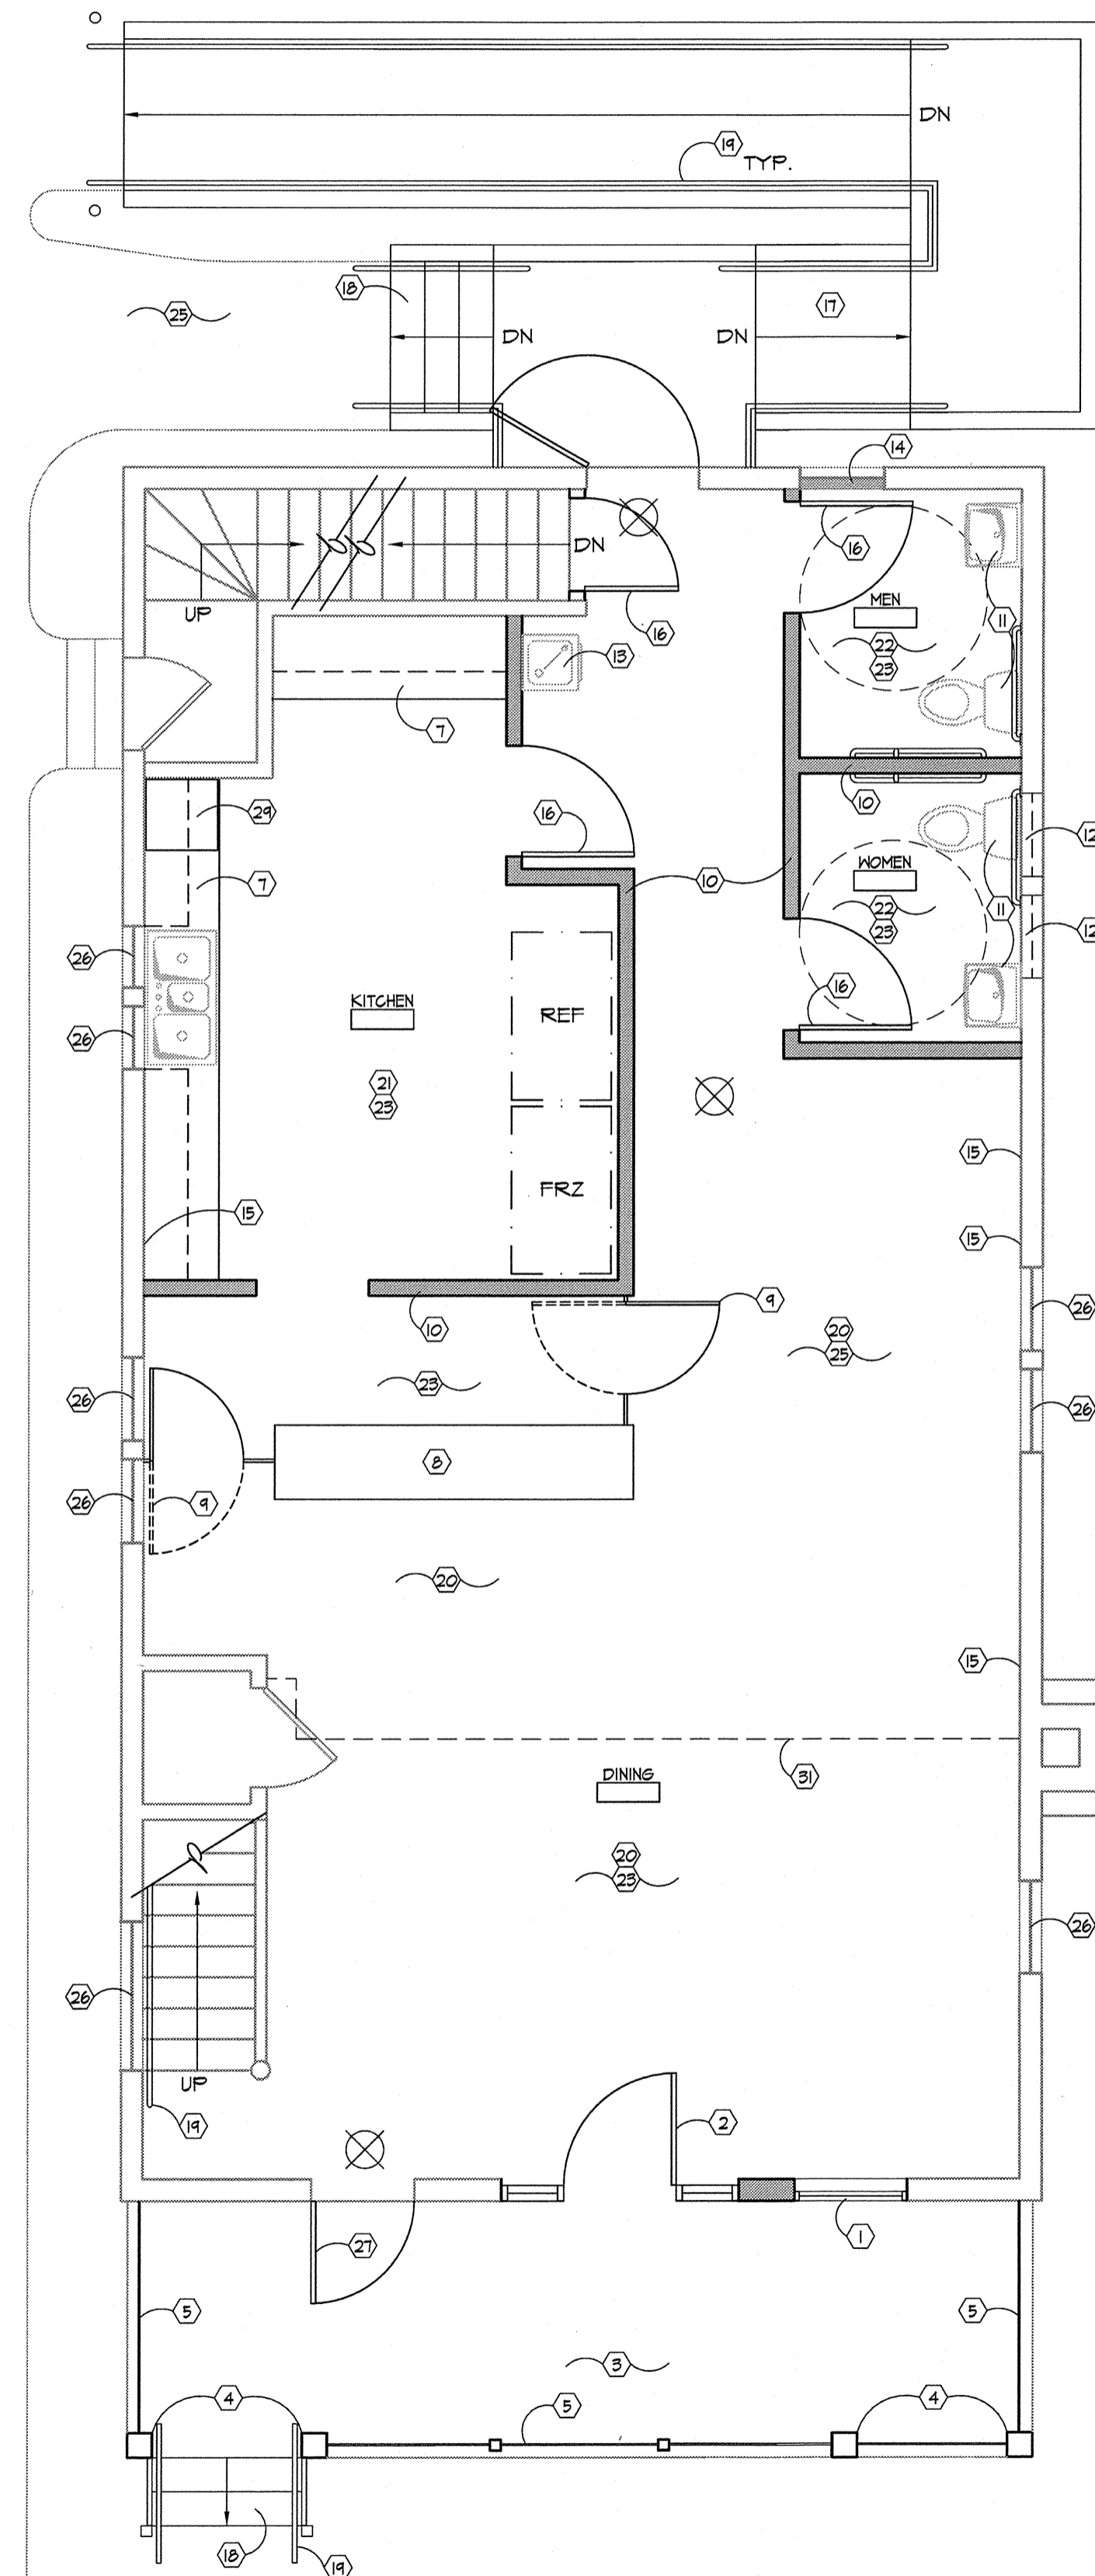

- CONSTRUCTION NOTES:**
- ① NEW WINDOW
  - ② NEW ALUMINUM DOOR / STOREFRONT
  - ③ NEW WOOD OR COMPOSITE DECK
  - ④ NEW WOOD COLUMNS
  - ⑤ NEW CABLE RAIL HANDRAIL
  - ⑥ PATCH EXISTING WOOD FLOORS
  - ⑦ NEW CABINETS
  - ⑧ NEW BAR
  - ⑨ NEW 3'-6" SWING DOOR
  - ⑩ NEW WALLS
  - ⑪ NEW ADA PLUMBING FIXTURES
  - ⑫ CLOSE EXISTING WINDOWS
  - ⑬ NEW ADA DRINKING FOUNTAIN
  - ⑭ ADD WINDOW FILM
  - ⑮ NEW INSULATION / GNB
  - ⑯ NEW DOOR/FRAME
  - ⑰ NEW ADA RAMP
  - ⑱ NEW WOOD STEPS/HANDRAIL
  - ⑲ NEW 1-1/2" DIA WOOD HANDRAIL
  - ⑳ REFINISH EXISTING FLOORS OR NEW WOOD FLOORS
  - ㉑ NEW VGT FLOOR
  - ㉒ NEW CT FLOOR
  - ㉓ NEW FLOOR FRAMING
  - ㉔ NEW CEILING
  - ㉕ ASPHALT WALK
  - ㉖ REPLACE EXISTING WINDOWS
  - ㉗ NEW 3'-0" x 6'-6" DOOR
  - ㉘ 3-1/2" DIAMETER CONCRETE FILLED BOLLARD
  - ㉙ DISHWASHER
  - ㉚ 3 1/2" DIAMETER CONCRETE FILLED POST
  - ㉛ BALCONY ABOVE

COPYRIGHT Keller Architectural Design, LLC. 2012  
ALL RIGHTS RESERVED  
THIS DRAWING IS NOT TO BE REPRODUCED, CHANGED,  
COPIED OR ASSIGNED TO ANY THIRD PARTY IN ANY  
FORM OR MANNER WITHOUT FIRST OBTAINING THE  
EXPRESSED WRITTEN PERMISSION OF Keller  
Architectural Design, LLC. THE CLIENT AGREES TO  
INDEMNIFY AND HOLD THE ARCHITECT HARMLESS  
FROM ANY DAMAGES, LIABILITY, OR COST, INCLUDING  
ATTORNEY'S FEES AND COSTS OF DEFENSE ARISING  
FROM ANY CHANGES OR ALTERATIONS MADE BY  
ANYONE OTHER THAN THE ARCHITECT, OR FROM ANY  
REUSE OF THE DRAWINGS OR DATA WITHOUT THE  
PRIOR WRITTEN CONSENT OF THE ARCHITECT.

Revisions:

| Date | Number | Description |
|------|--------|-------------|
|      |        |             |
|      |        |             |
|      |        |             |
|      |        |             |
|      |        |             |
|      |        |             |

Sheet Title:  
**FIRST FLOOR DEMOLITION AND  
FLOOR PLAN**

Project No.: 18.1

Date: March 12, 2018

Sheet No.: