


# Waukesha Residences, LLC by T. Wall Enterprises, LLC Fox Head Residences - Plan Commission Submittal

Maple Avenue, Waukesha, Wisconsin

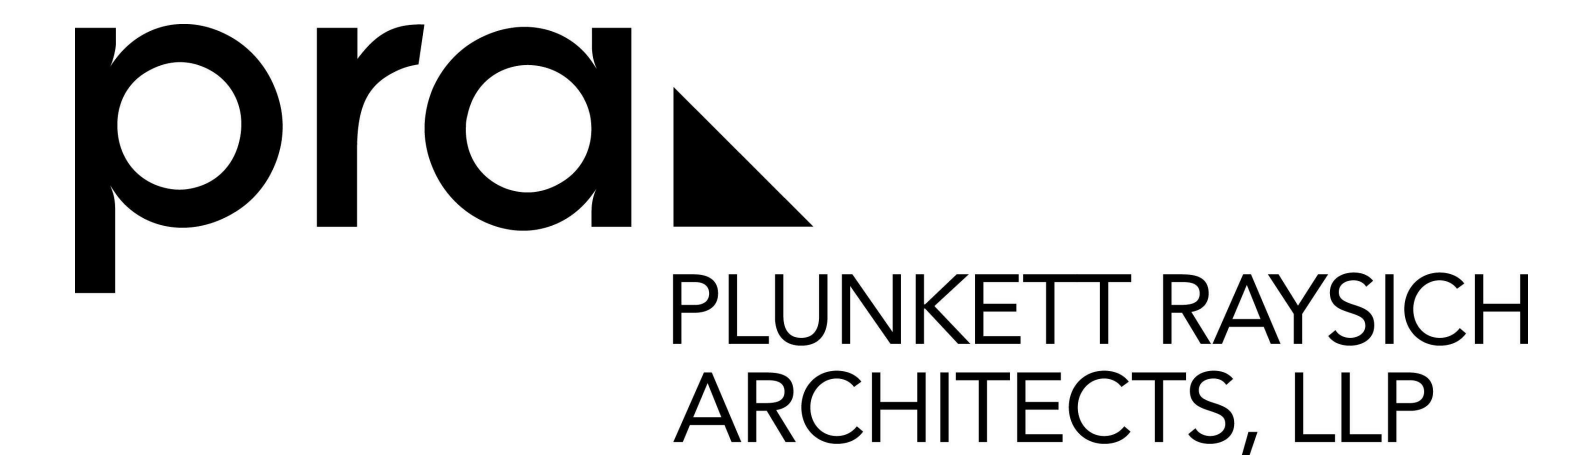

11000 west park place milwaukee, wisconsin 53224 t 414 359 3060  
2310 crossroads drive suite 2000 madison, wisconsin 53718 t 608 240 9900  
1613 fruitville road suite 3 sarasota, florida 34236 t 941 348 3618

intelligent designs. inspired results. | [www.prarch.com](http://www.prarch.com)

## Sheet Index

### Architectural

- A000 - Title Sheet
- A001 - Exterior Perspective
- A002 - Existing Aerial Site Plan
- A003 - Proposed Aerial Site Plan
- A201 - Site Plan / First Floor Plan
- A202 - Lower Parking Plan
- A203 - Second and Third Floor Plans
- A204 - Fourth Floor Plan
- A205 - Fifth Floor Plan
- A206 - Sixth Floor Plan
- A232 - Unit Layouts
- A233 - Unit Layouts
- A401 Exterior Elevations
- A401 Exterior Elevations

### Landscape

- L1 - Landscape Plan

### Site Civil

- S554 - Draft ALTA/ACSM Land Title Survey 1 of 2
- S554 - Draft ALTA/ACSM Land Title Survey 2 of 2
- C100 - Existing Conditions
- C200 - Demolition Plan
- C300 - Site Plan
- C400 - Grading and Erosion Control Plan
- C500 - Utility Plan
- C600 - Plan and Profile - Watermain Easement
- C601 - Plan and Profile - Watermain Easement

### Site Lighting

- E1 - Site Lighting Layout Plan


### Additional Information

- R.A Smith National - Memo

## Project Information

Project Date: 12/30/14  
PRA Project Number: 140243-02

## Project Location

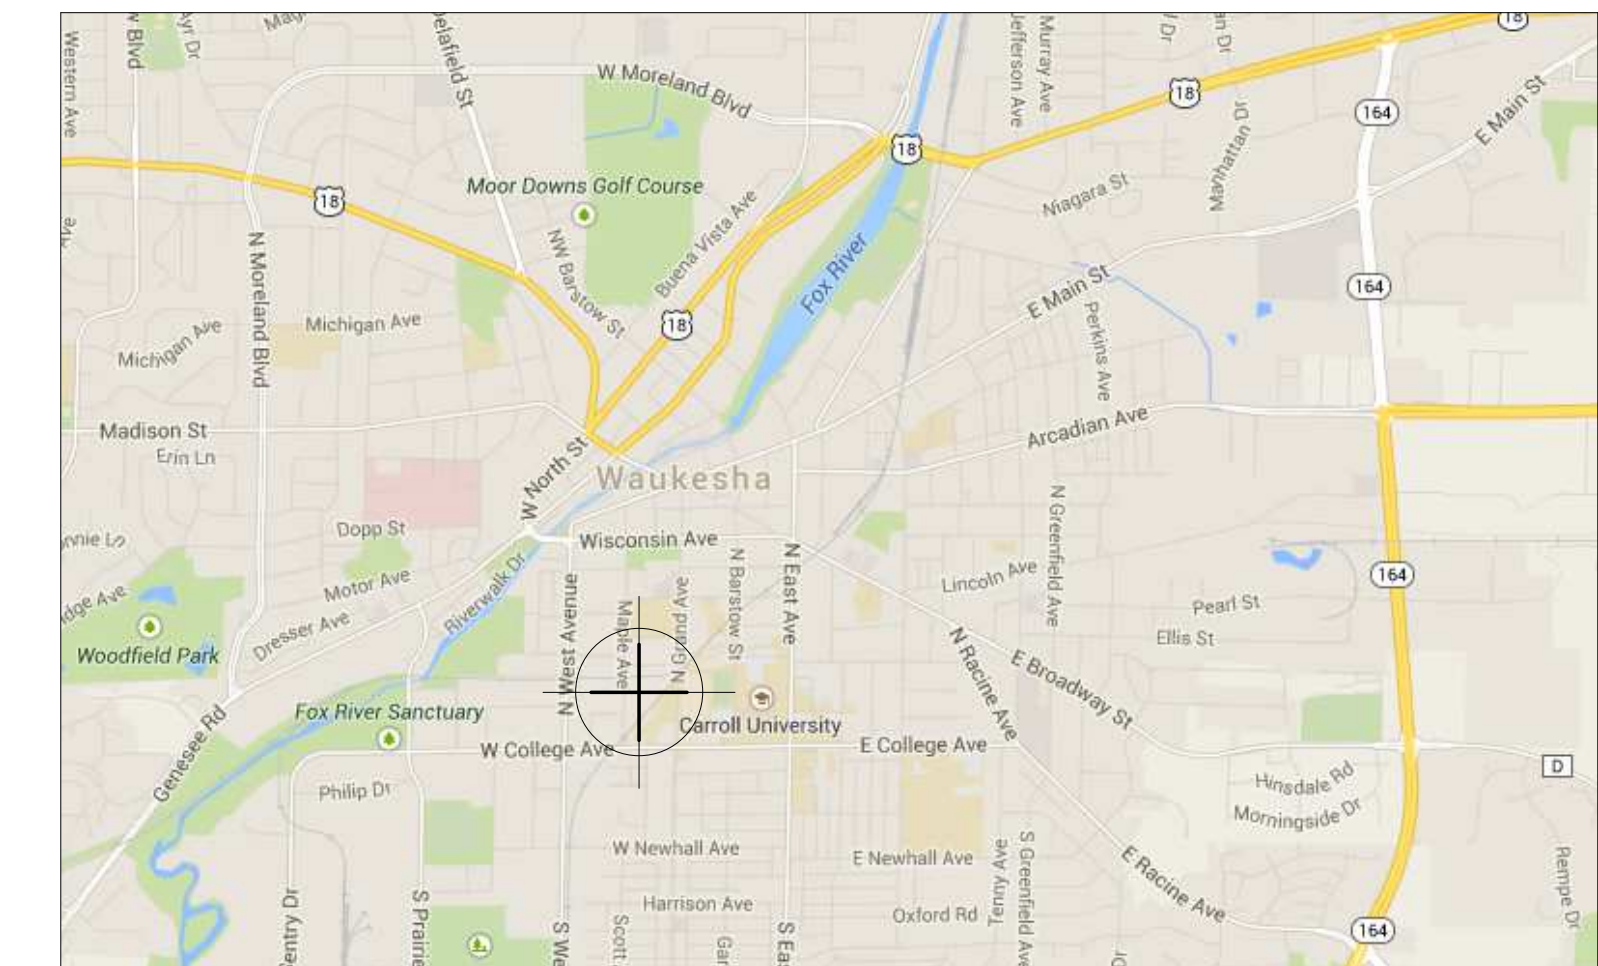

## Project Team



### Owner

Waukesha Residences, LLC  
T Wall Enterprises, LLC

Tel 608 575-1018

### Architectural

Plunkett Raysich Architects, LLP

Tel 414 359-3060  
Fax 414 359-3070

### Landscape

Bruce Compay

Tel 608 826-0532  
Fax 608 831-4236

### Site Civil

Vierbicher

Tel 414 555-1234  
Fax 608 826-0532

### Site Lighting

Powrtek Engineering, Inc

Tel 262 827-9575  
Fax 262 827-9615



NOT FOR CONSTRUCTION

© Plunkett Raysich Architects, LLP

Drawn By:	MT, NU, MR
Date:	12/30/14
Job No.:	140243-02
Sheet No.:	A 001

Fox Head Residences - Plan Commission Submittal

Maple Avenue, Waukesha, Wisconsin

Revisions



PLUNKETT RAYSICH ARCHITECTS, LLP

11000 west park place milwaukee, wisconsin 53224 1-414-359-3060  
 2310 crossroads drive suite 2000 madison, wisconsin 53718 1-608-240-9900  
 1613 fruitville road suite 3 sarasota, florida 34236 1-941-348-3618

intelligent designs. inspired results. | www.prch.com