



- SHEET INDEX**
1. FRONT ELEVATION
  2. FIRST FLOOR PLAN
  3. BASEMENT PLAN
  4. SIDE ELEVATION
  5. REAR ELEVATION & DETAILS
  6. FIRST FLOOR ELECTRICAL PLAN

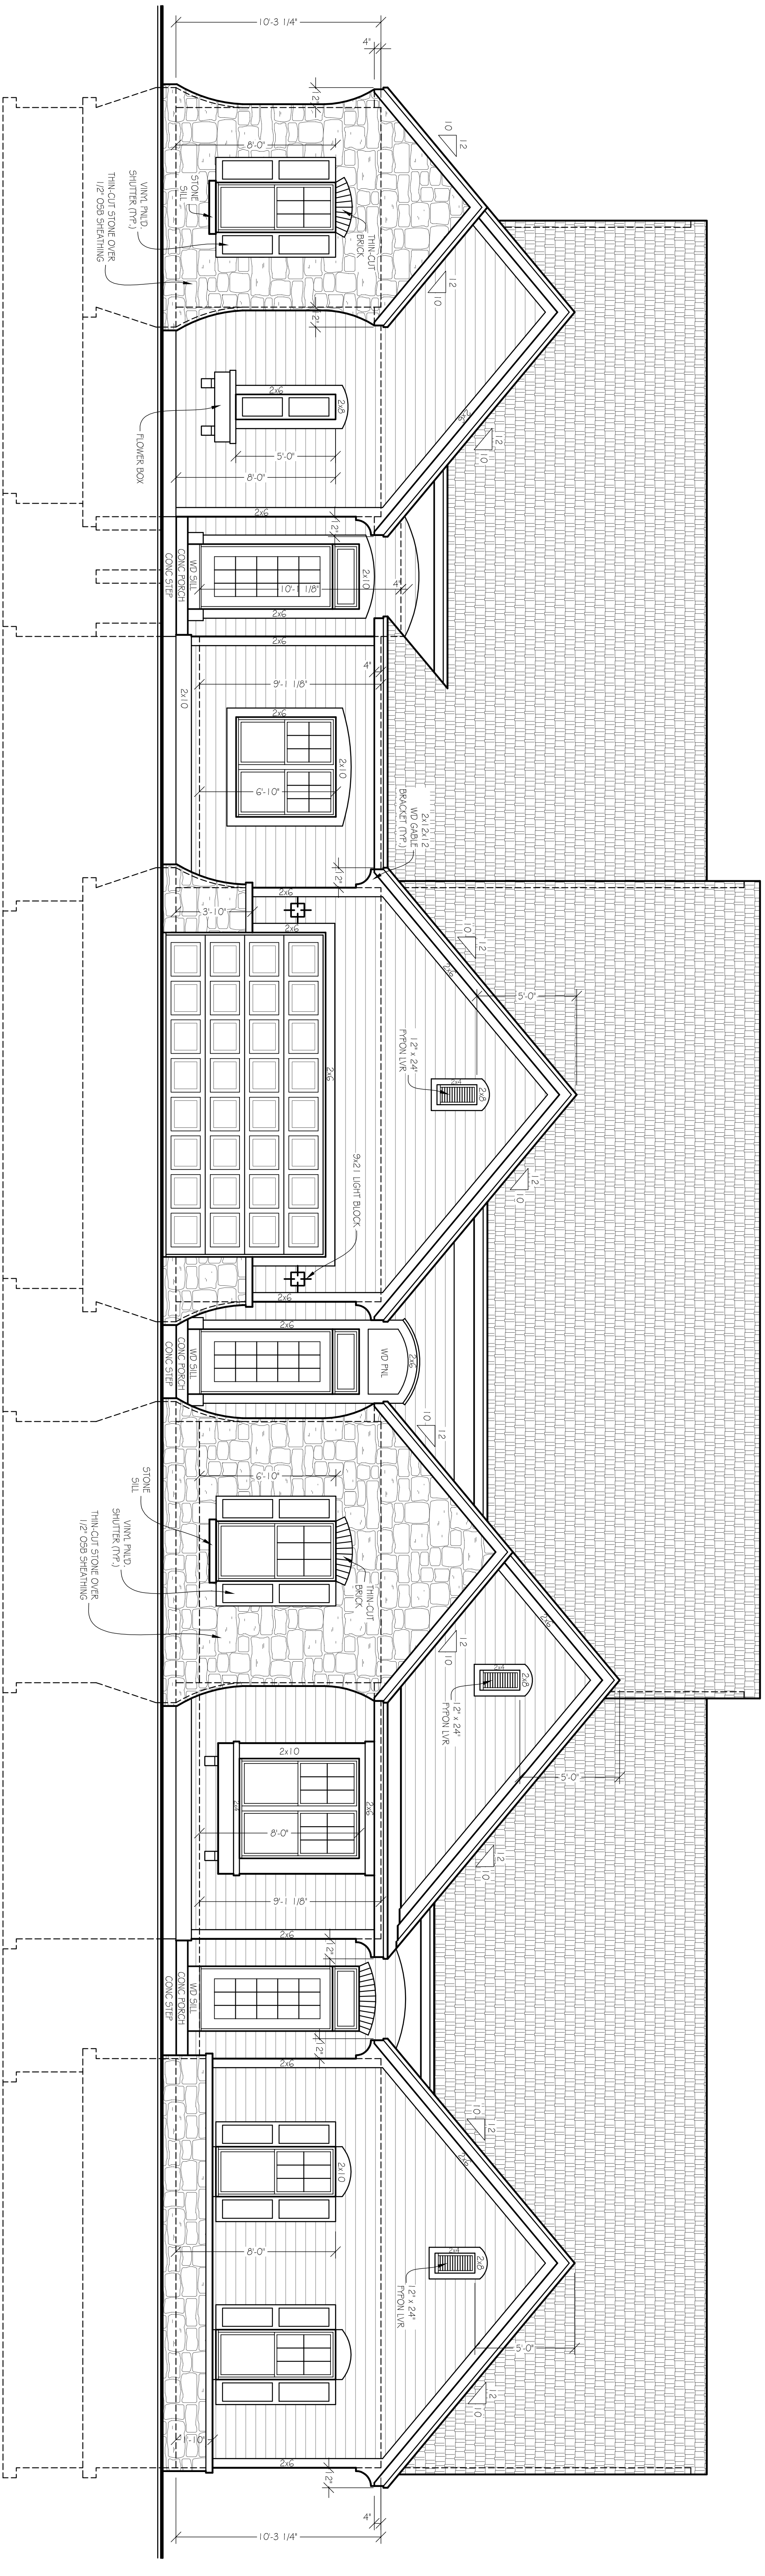

**FRONT ELEVATION**


SCALE: 1/4" = 1'-0"

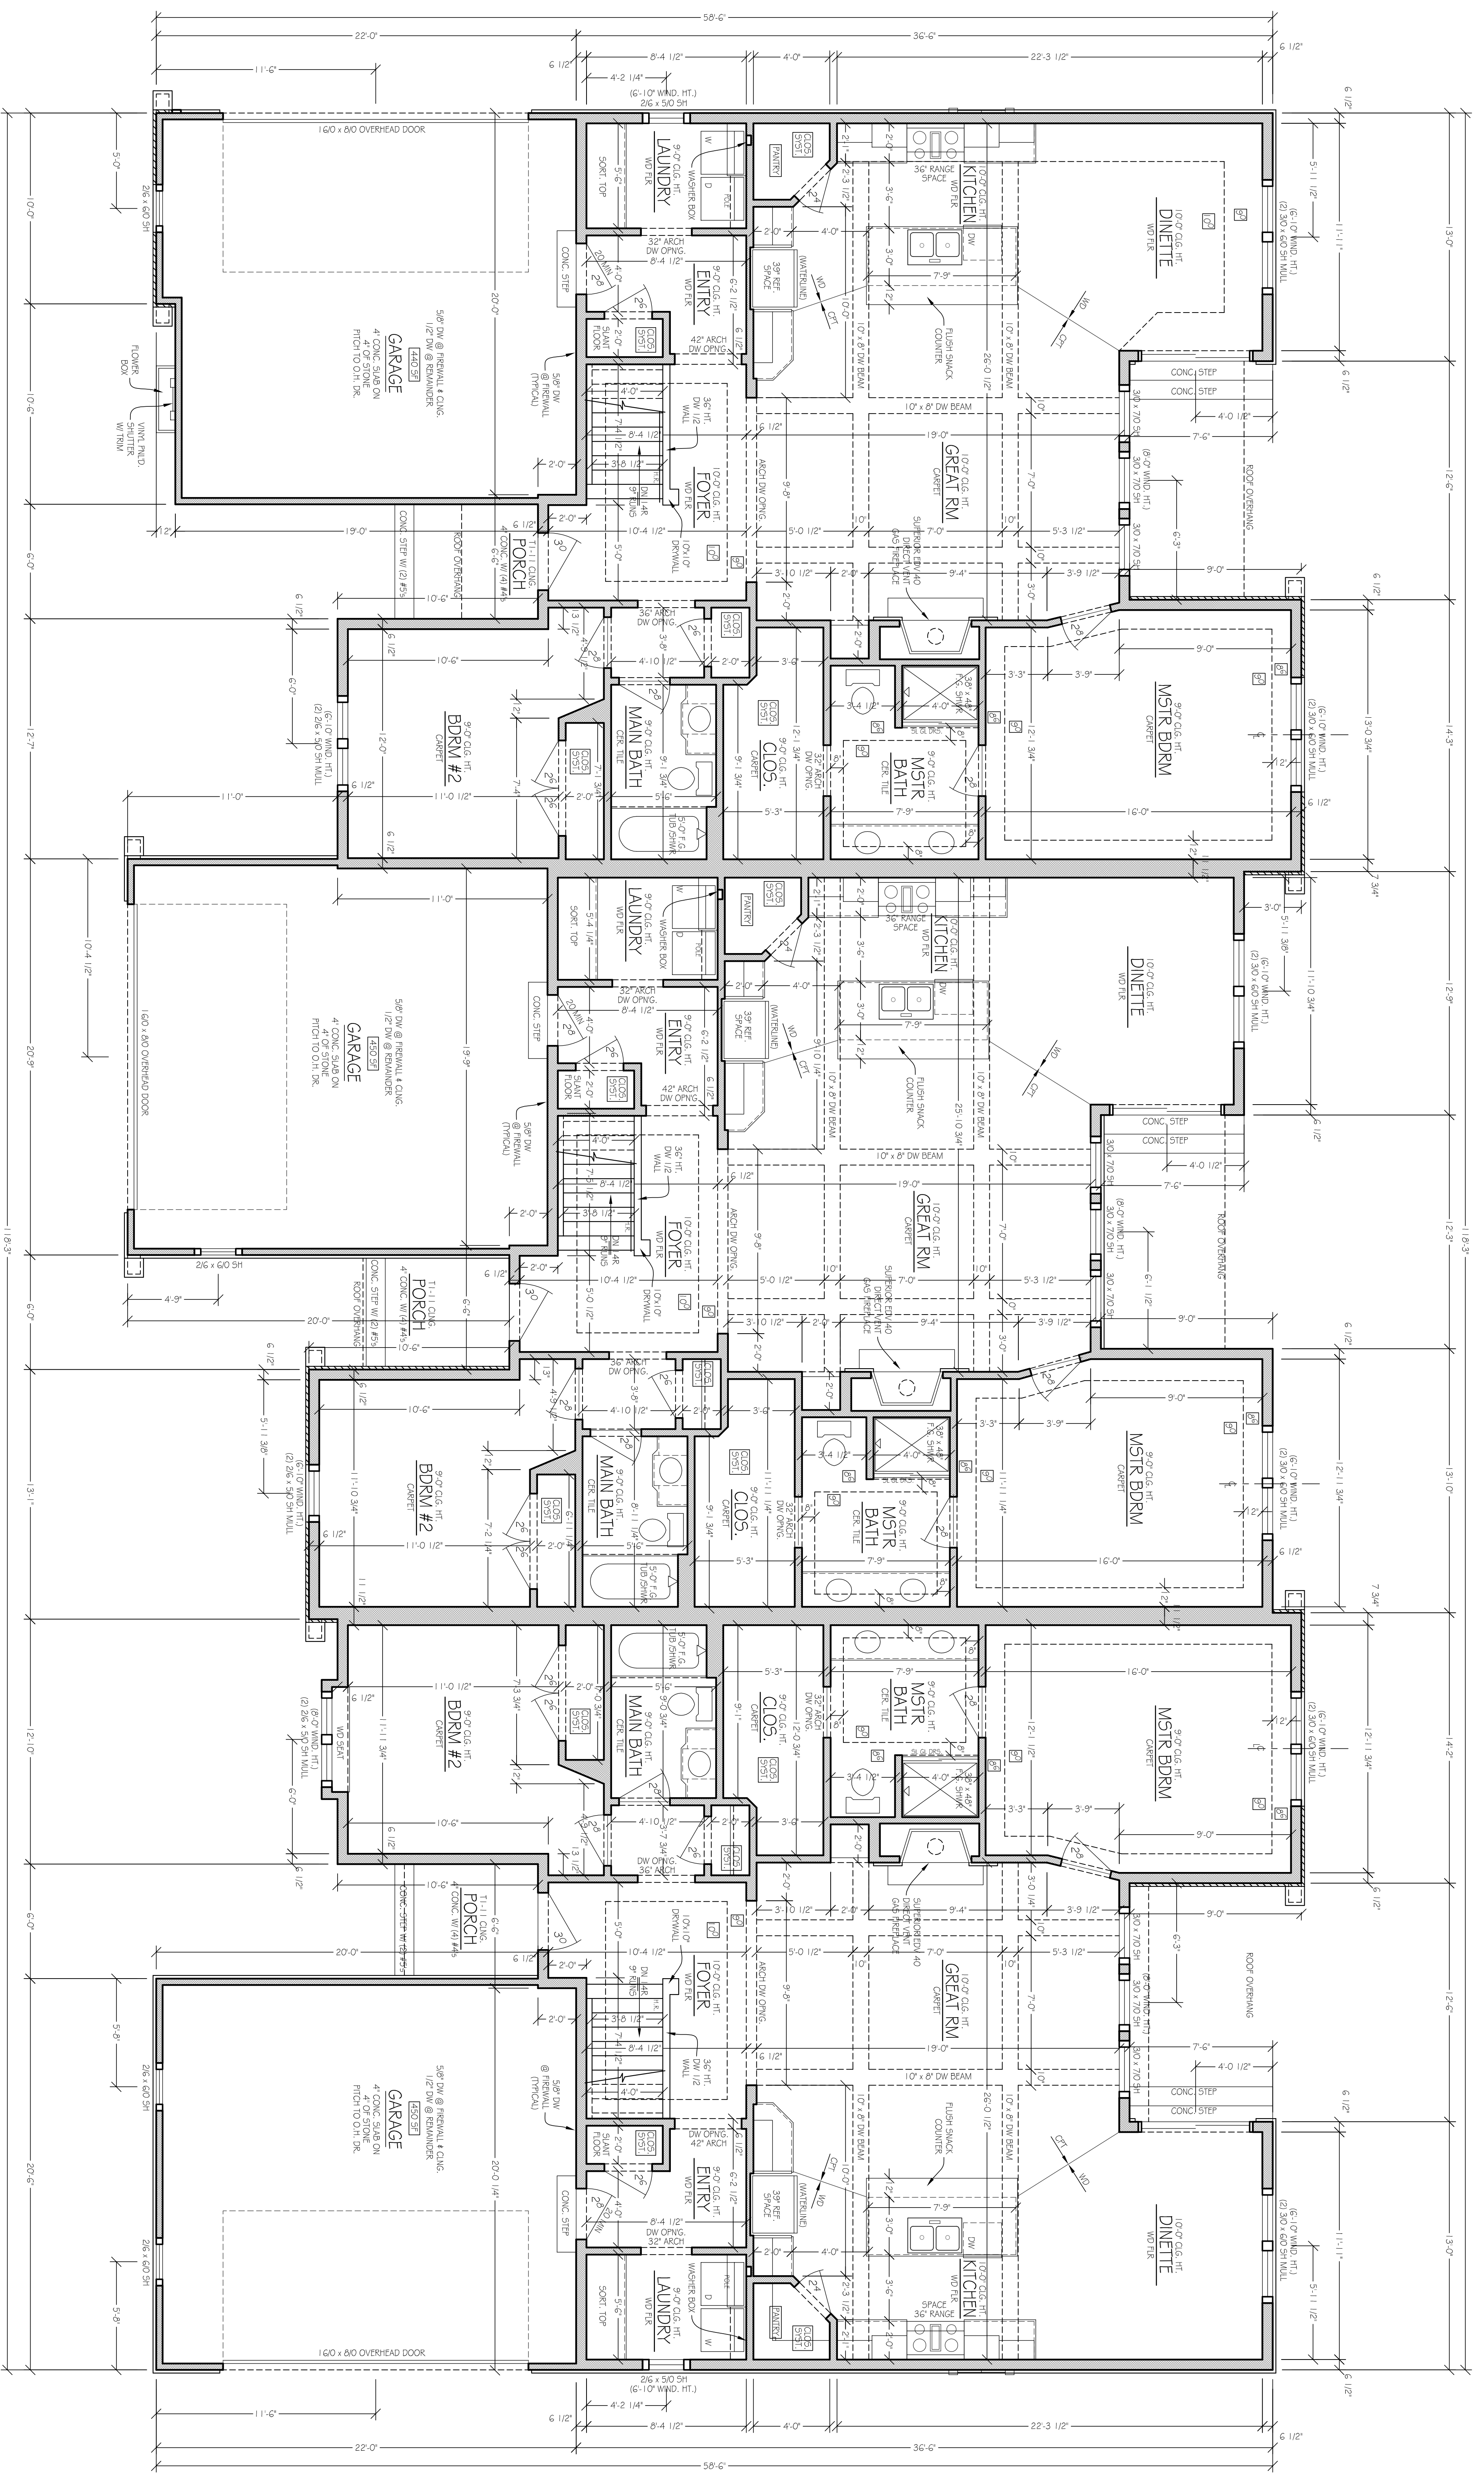

1 549 5 . F.  
UNIT 1  
SCALE: 1/4" = 1'-0"


1 533 5 . F.  
UNIT 2  
SCALE: 1/4" = 1'-0"

1 545 5 . F.  
UNIT 3  
SCALE: 1/4" = 1'-0"

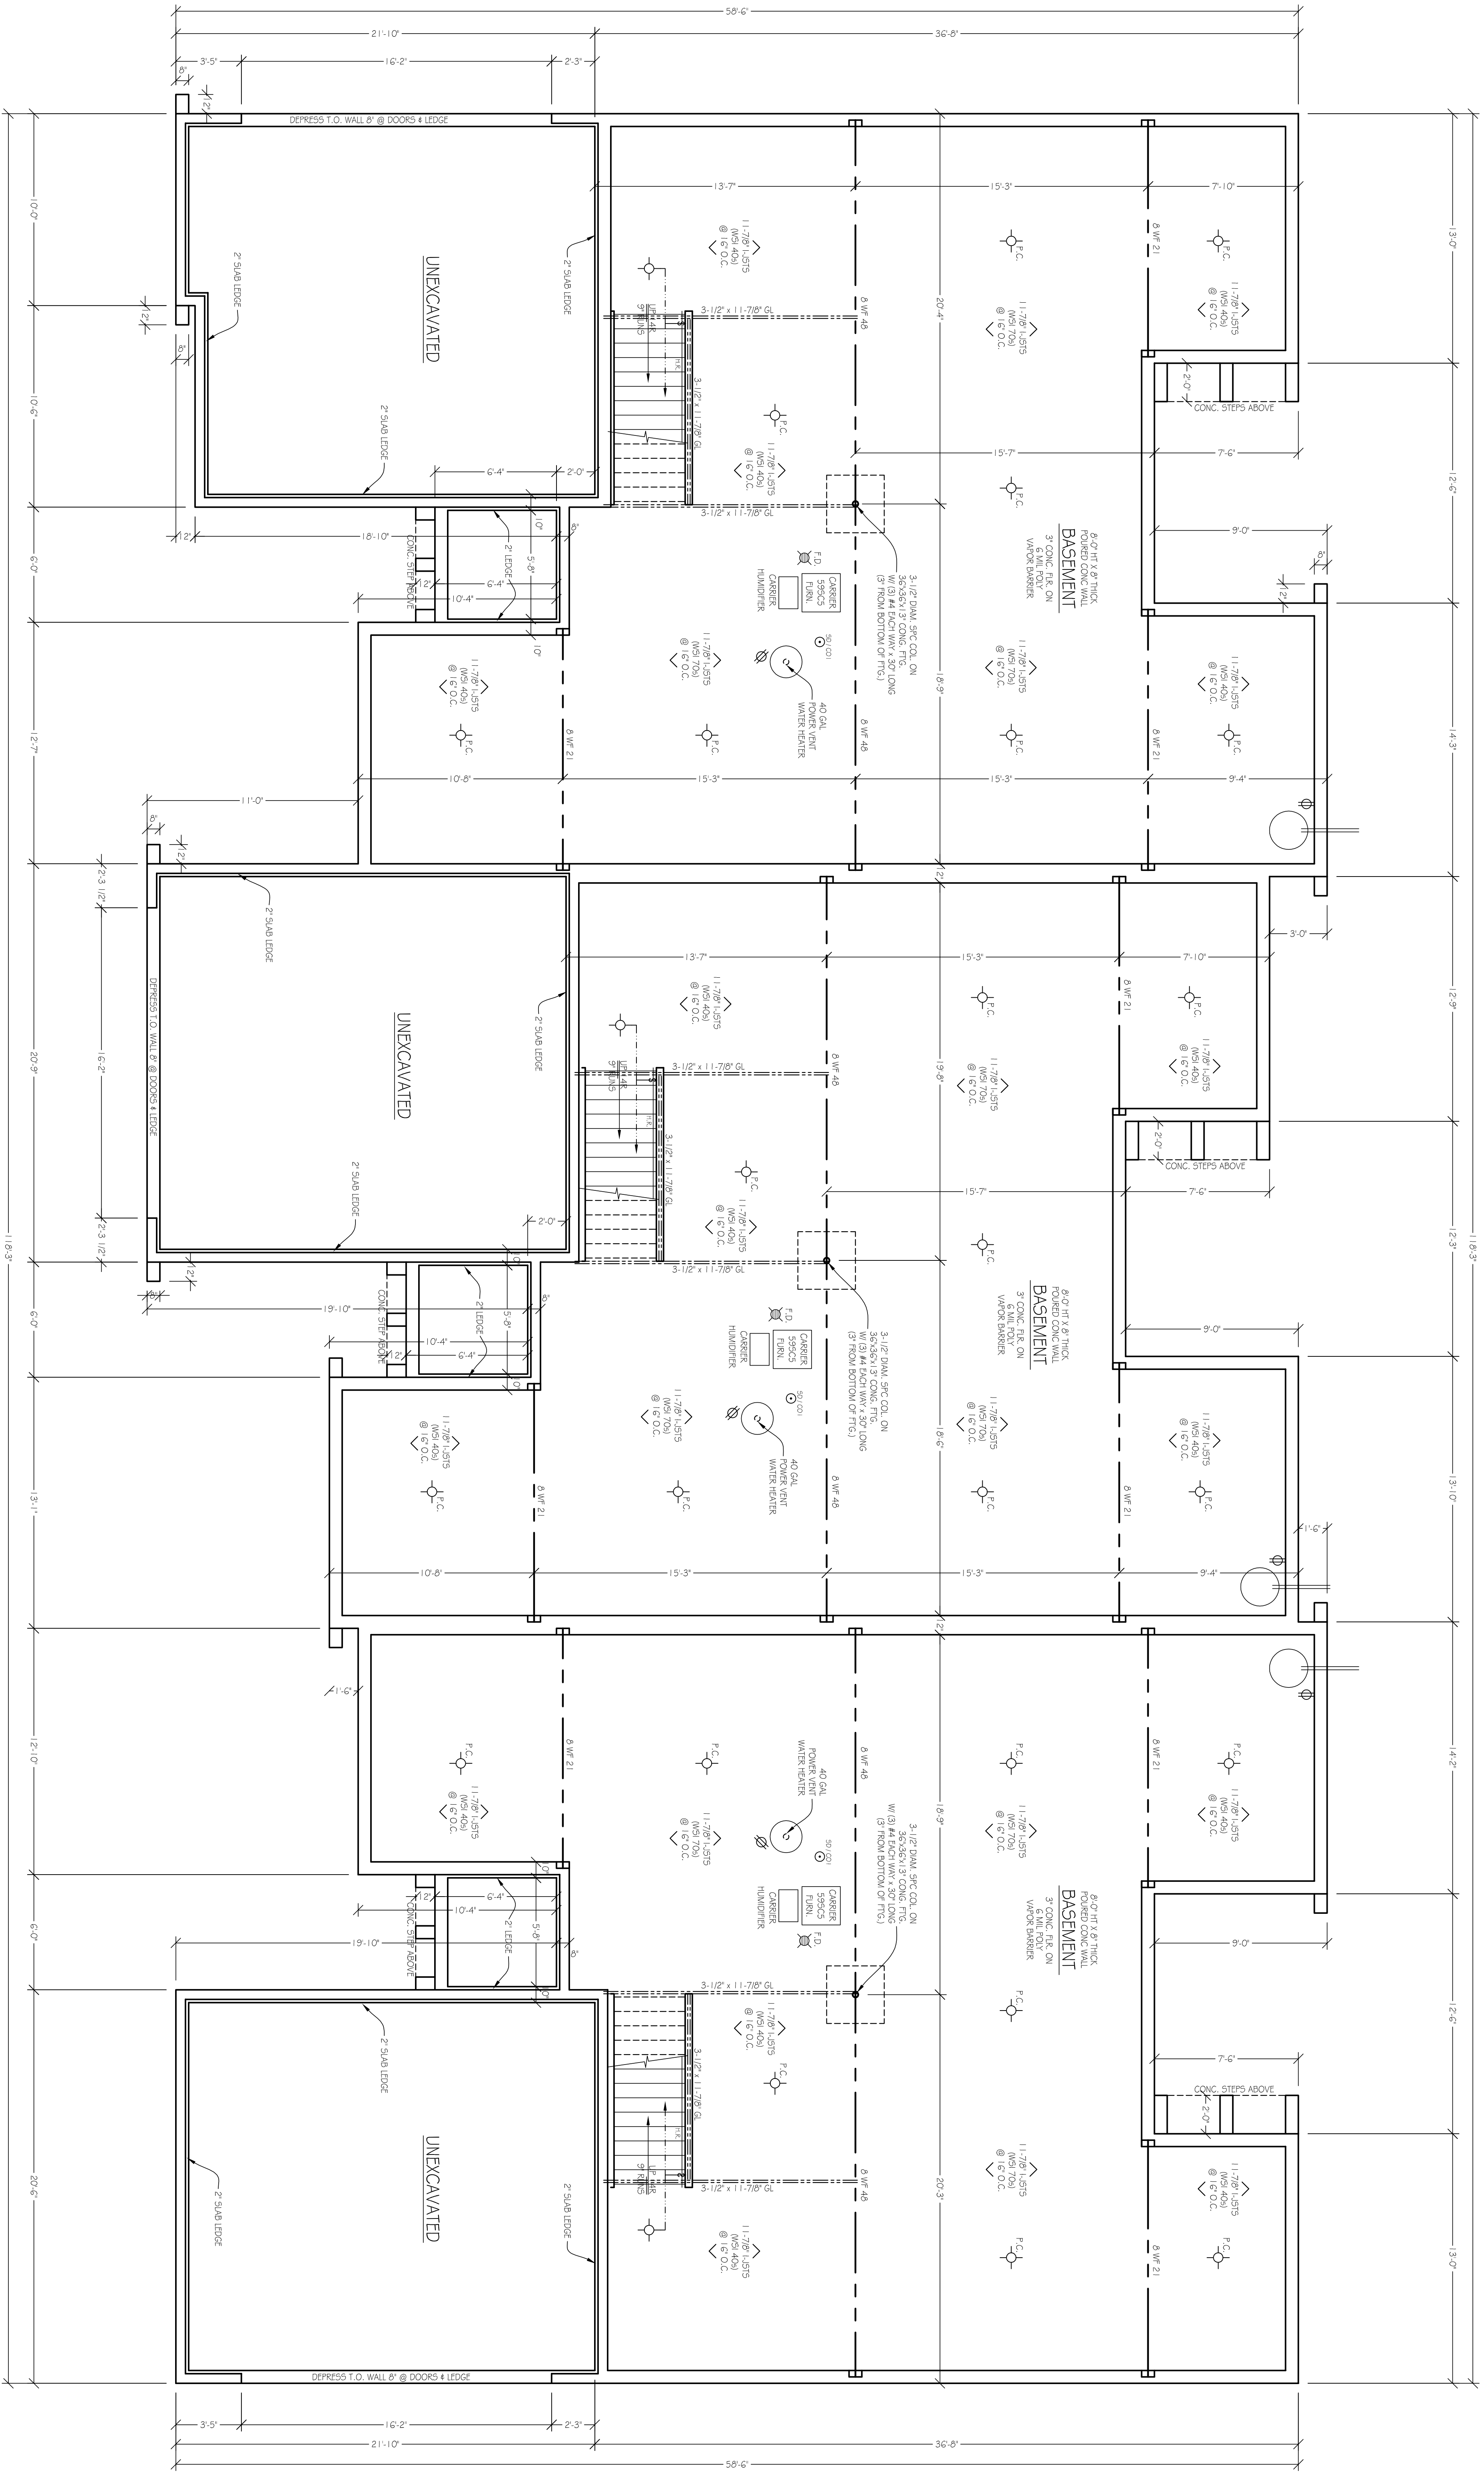


**BASEMENT PLAN**

SCALE: 1/4" = 1'-0"

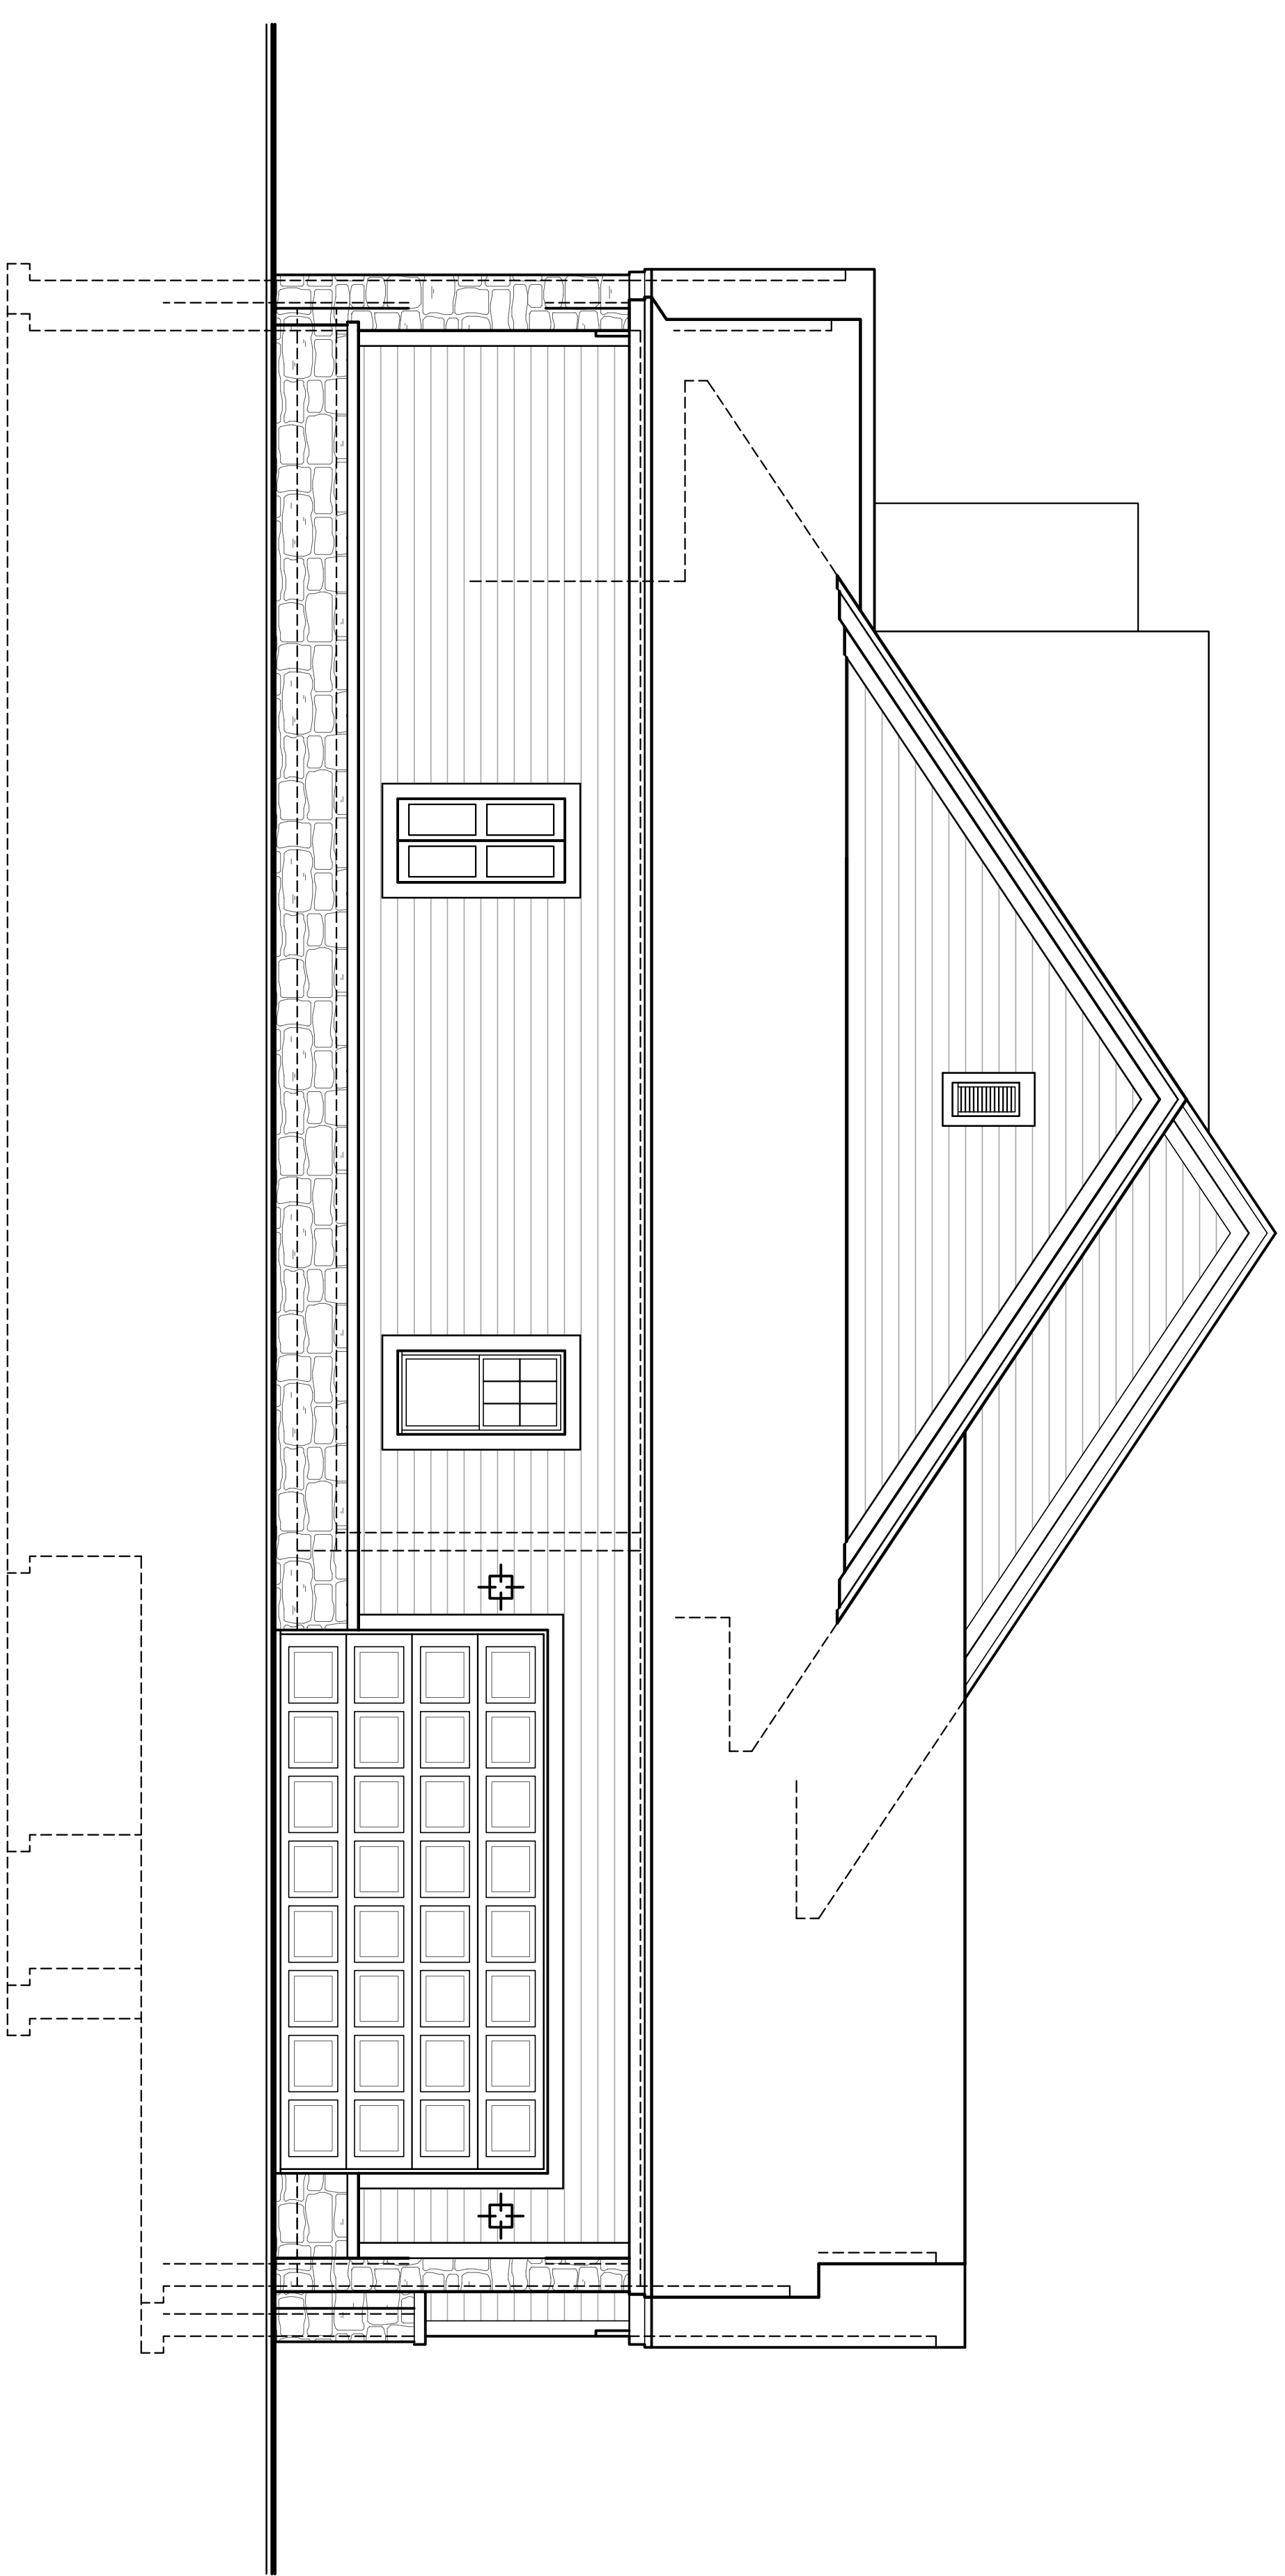


LEFT SIDE ELEVATION

SCALE: 1/4" = 1'-0"

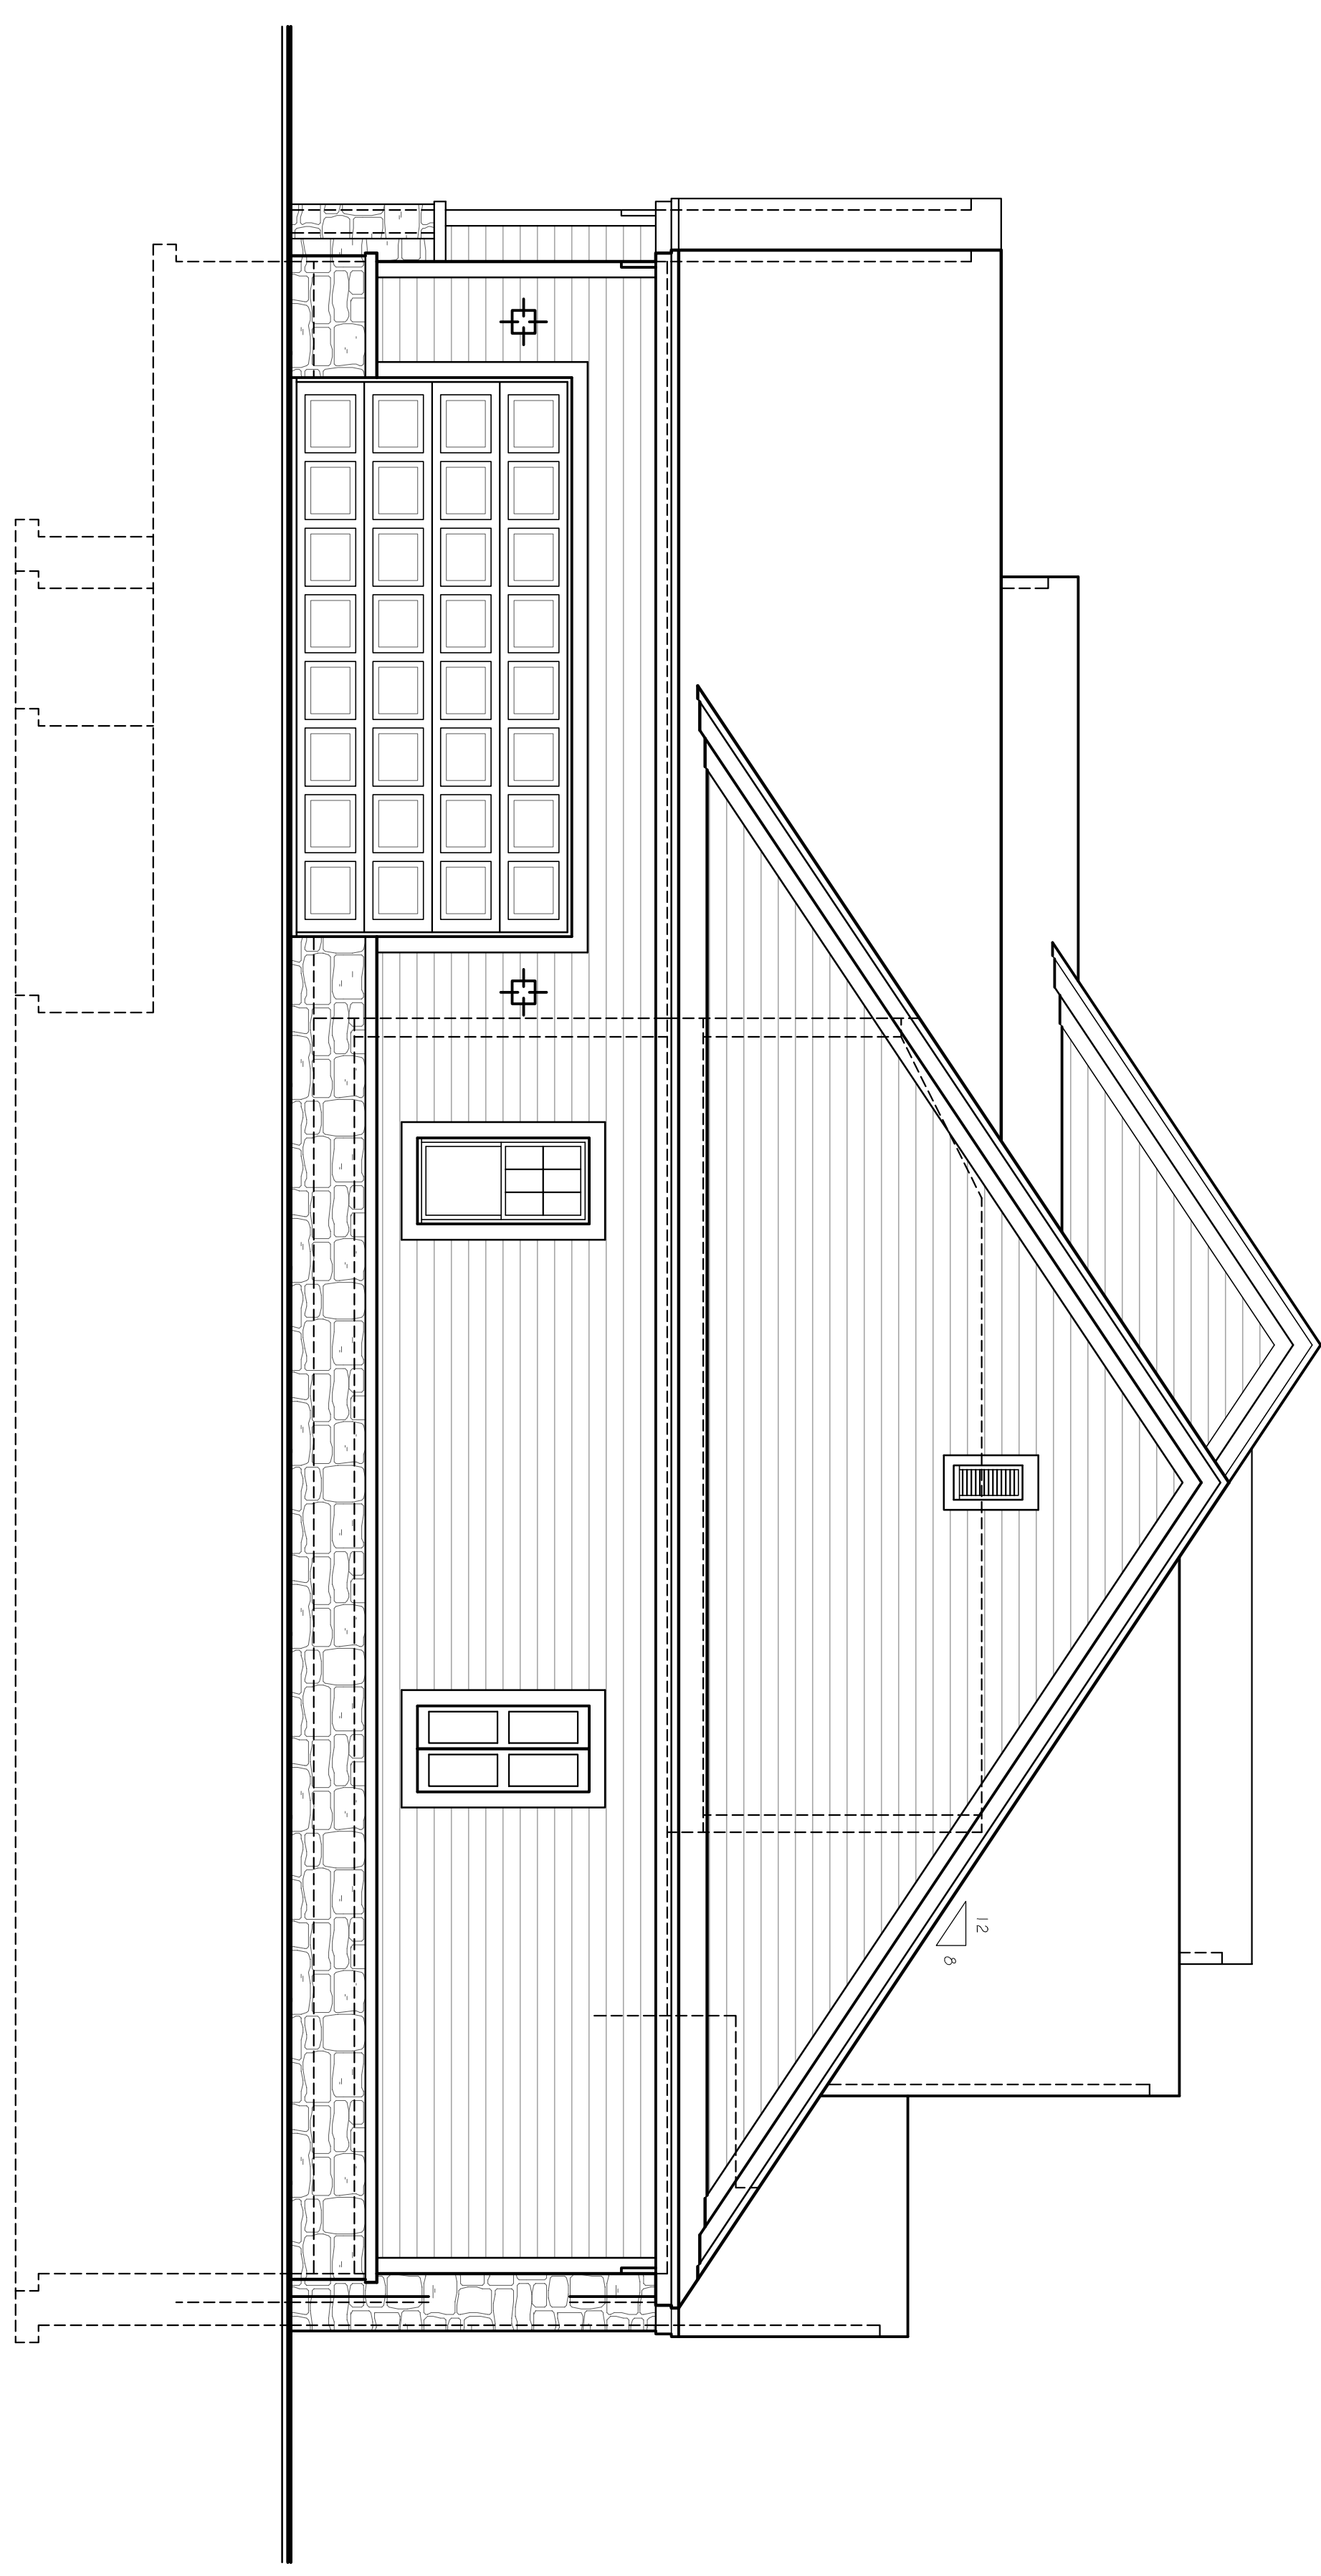


RIGHT SIDE ELEVATION

SCALE: 1/4" = 1'-0"

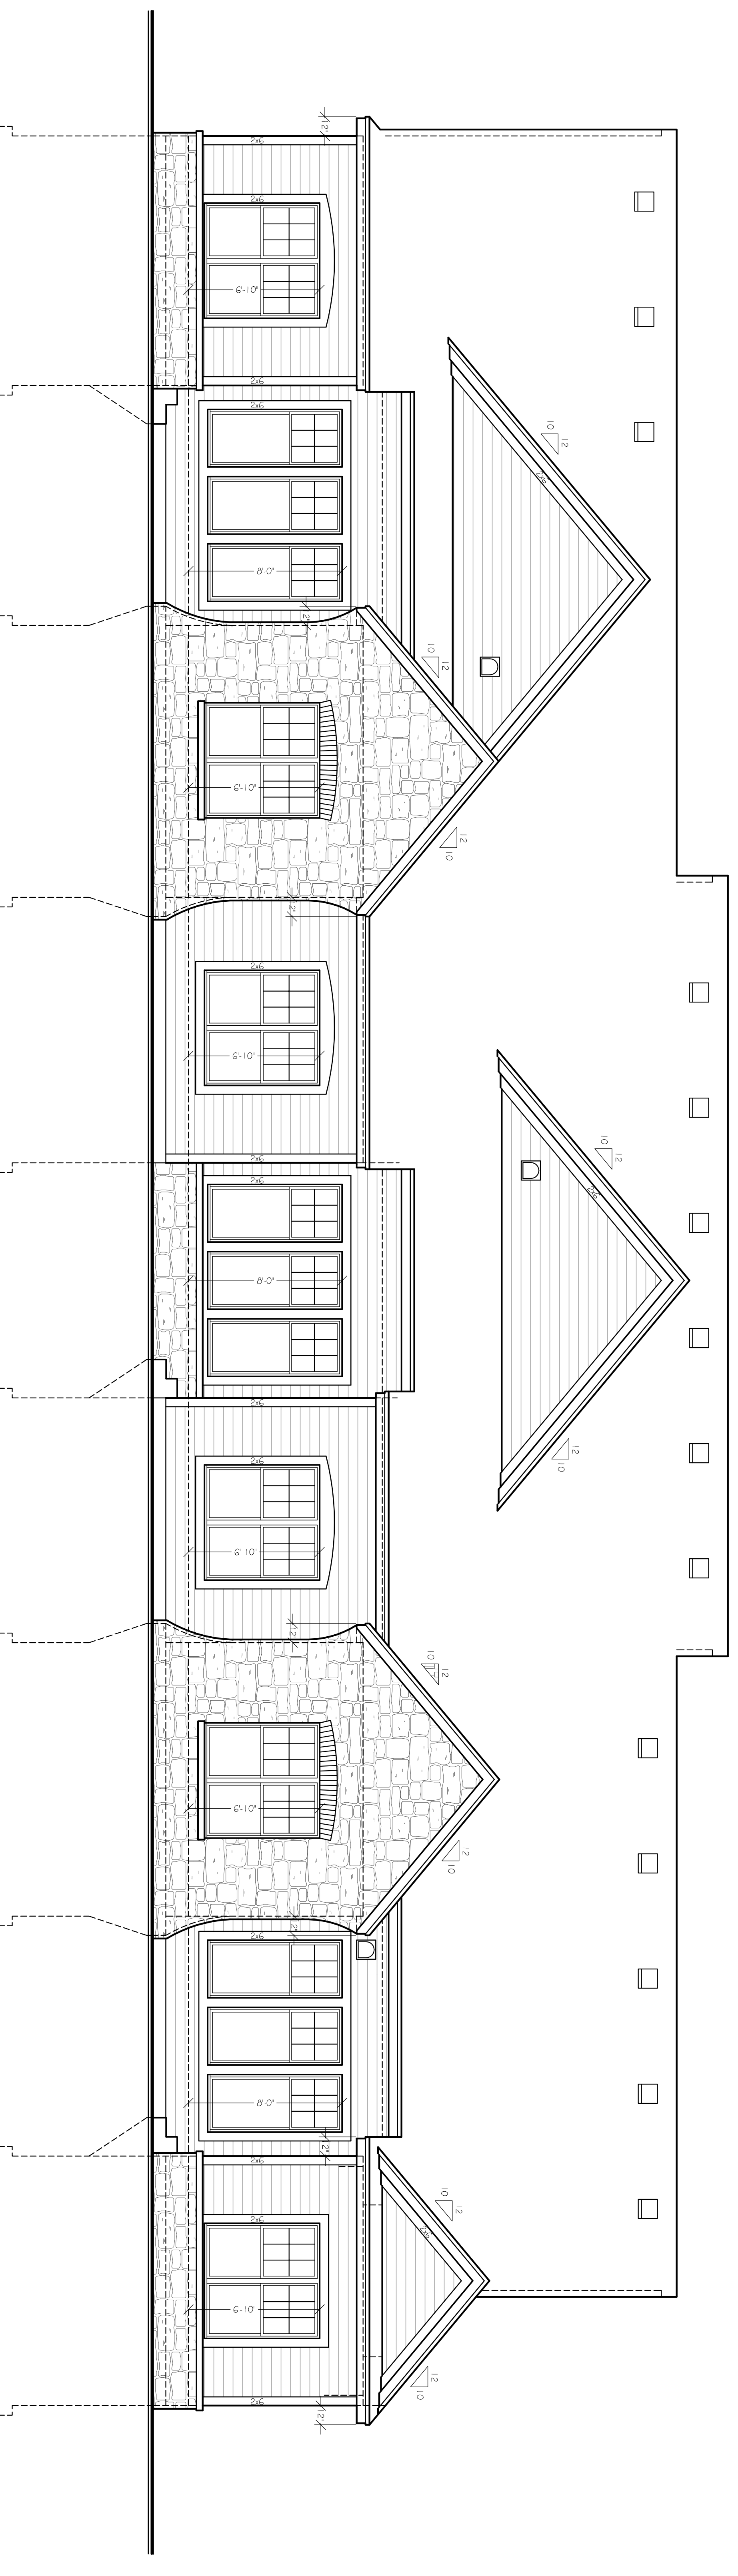


REAR ELEVATION

SCALE: 1/4" = 1'-0"

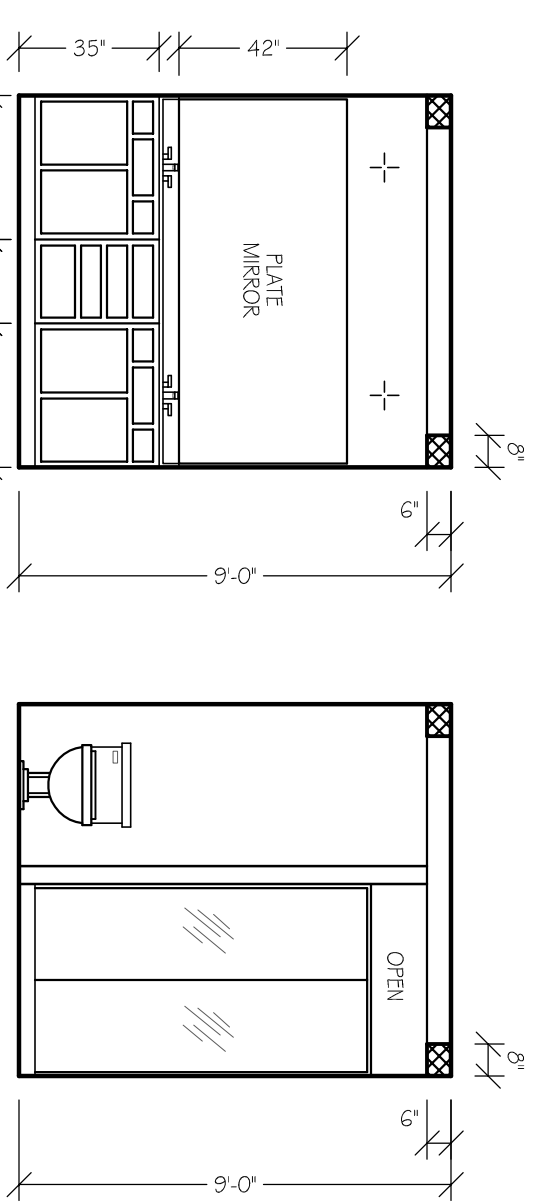


MASTER BATH

SCALE: 1/4" = 1'-0"

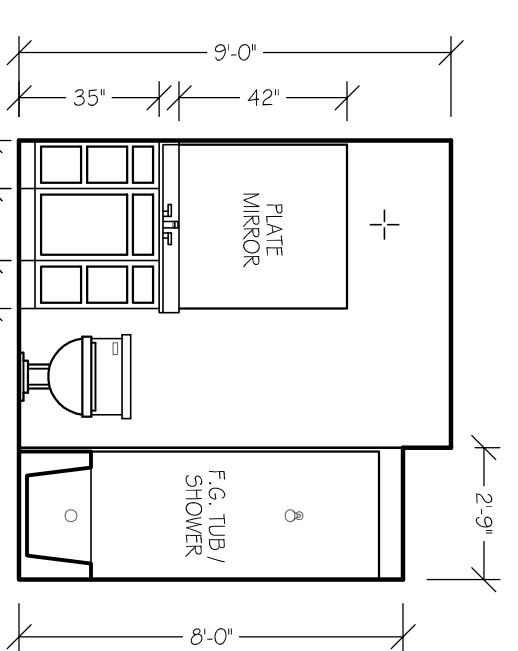


MAIN BATH

SCALE: 1/4" = 1'-0"

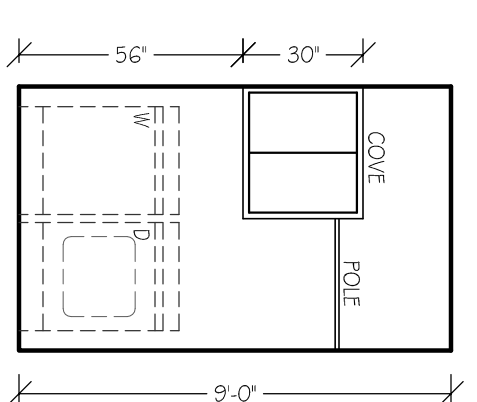


LAUNDRY

SCALE: 1/4" = 1'-0"

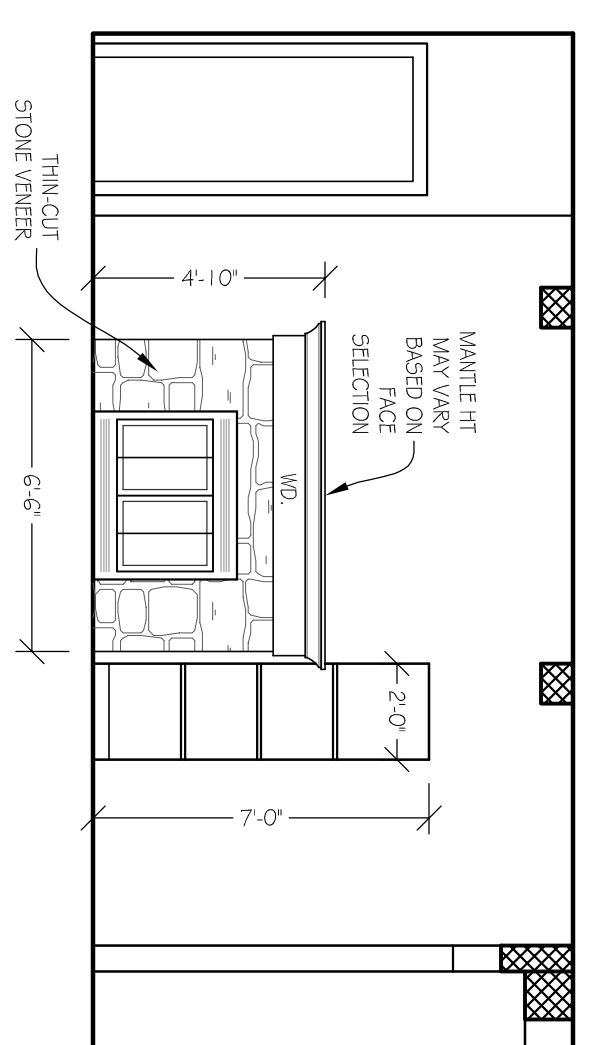


GREAT RM

SCALE: 1/4" = 1'-0"

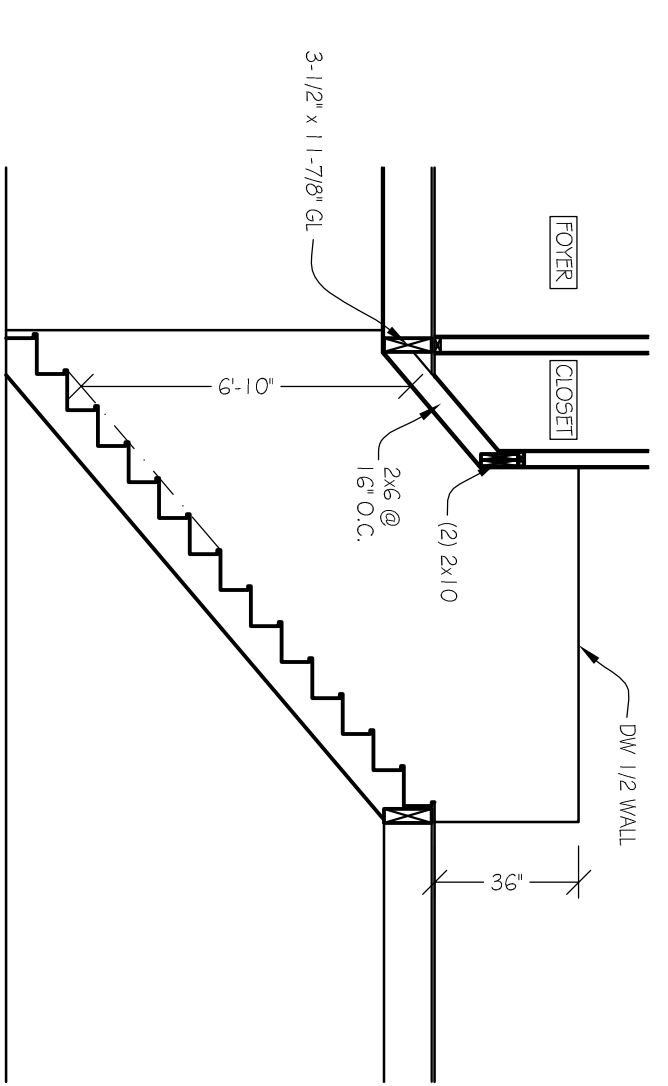




STAIR SECTION

SCALE: 1/4" = 1'-0"

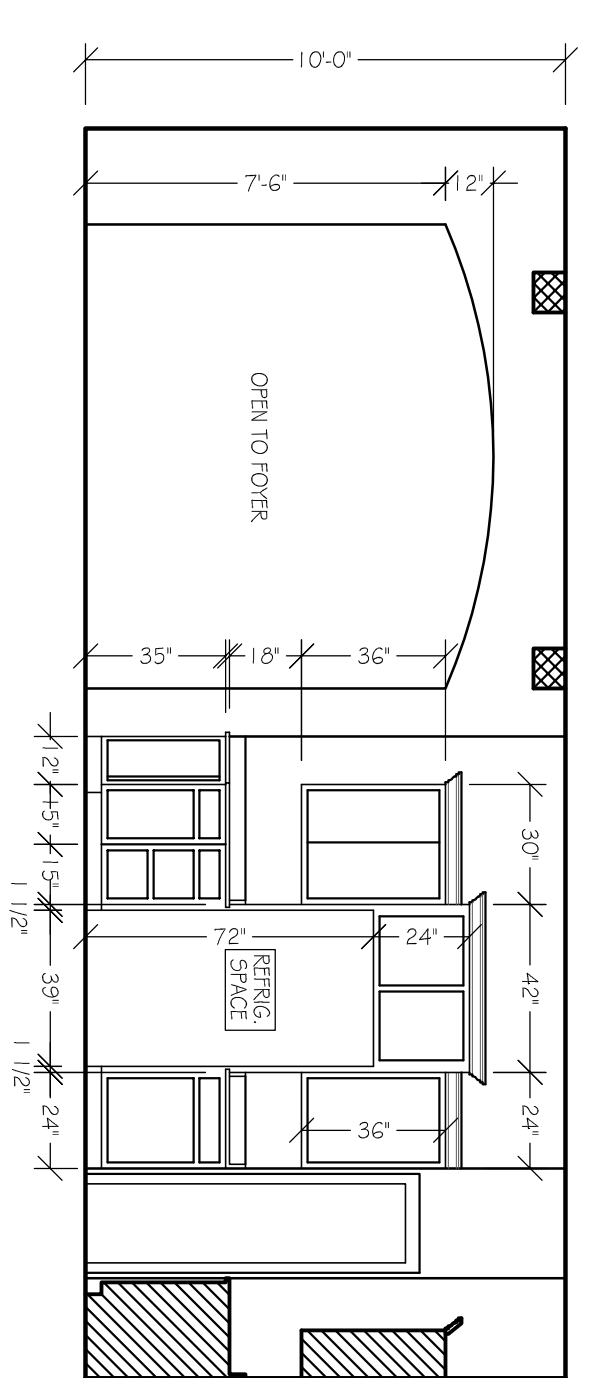


KITCHEN CABINET ELEVATIONS

SCALE: 1/4" = 1'-0"

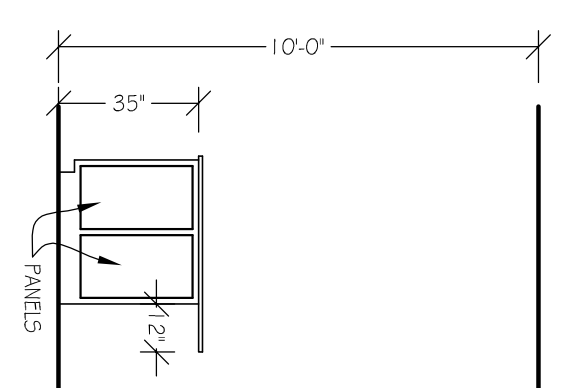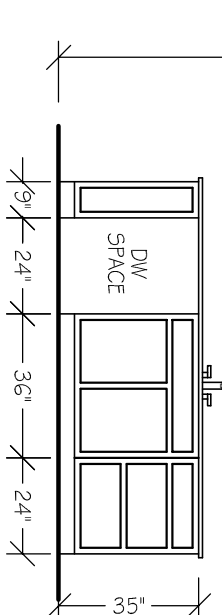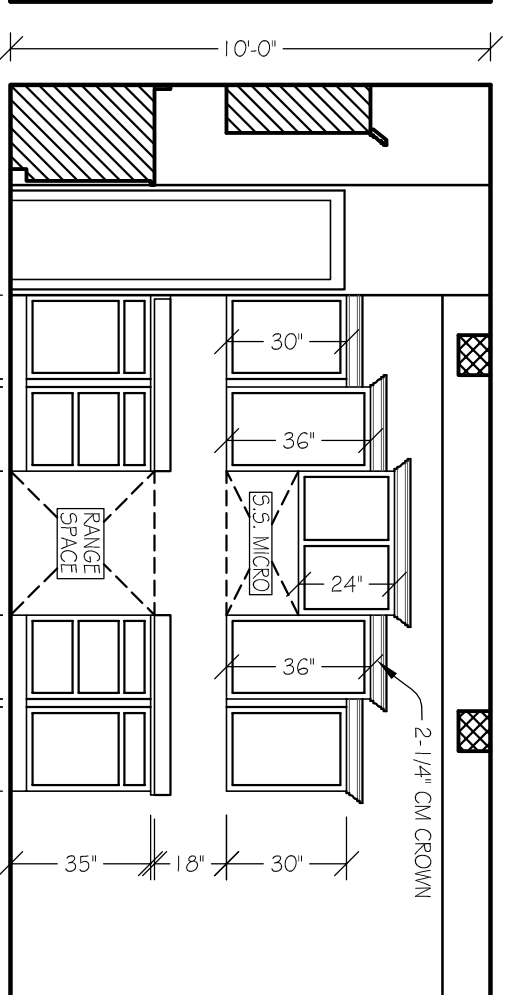


UNIT 1 CABINET ELEVATIONS




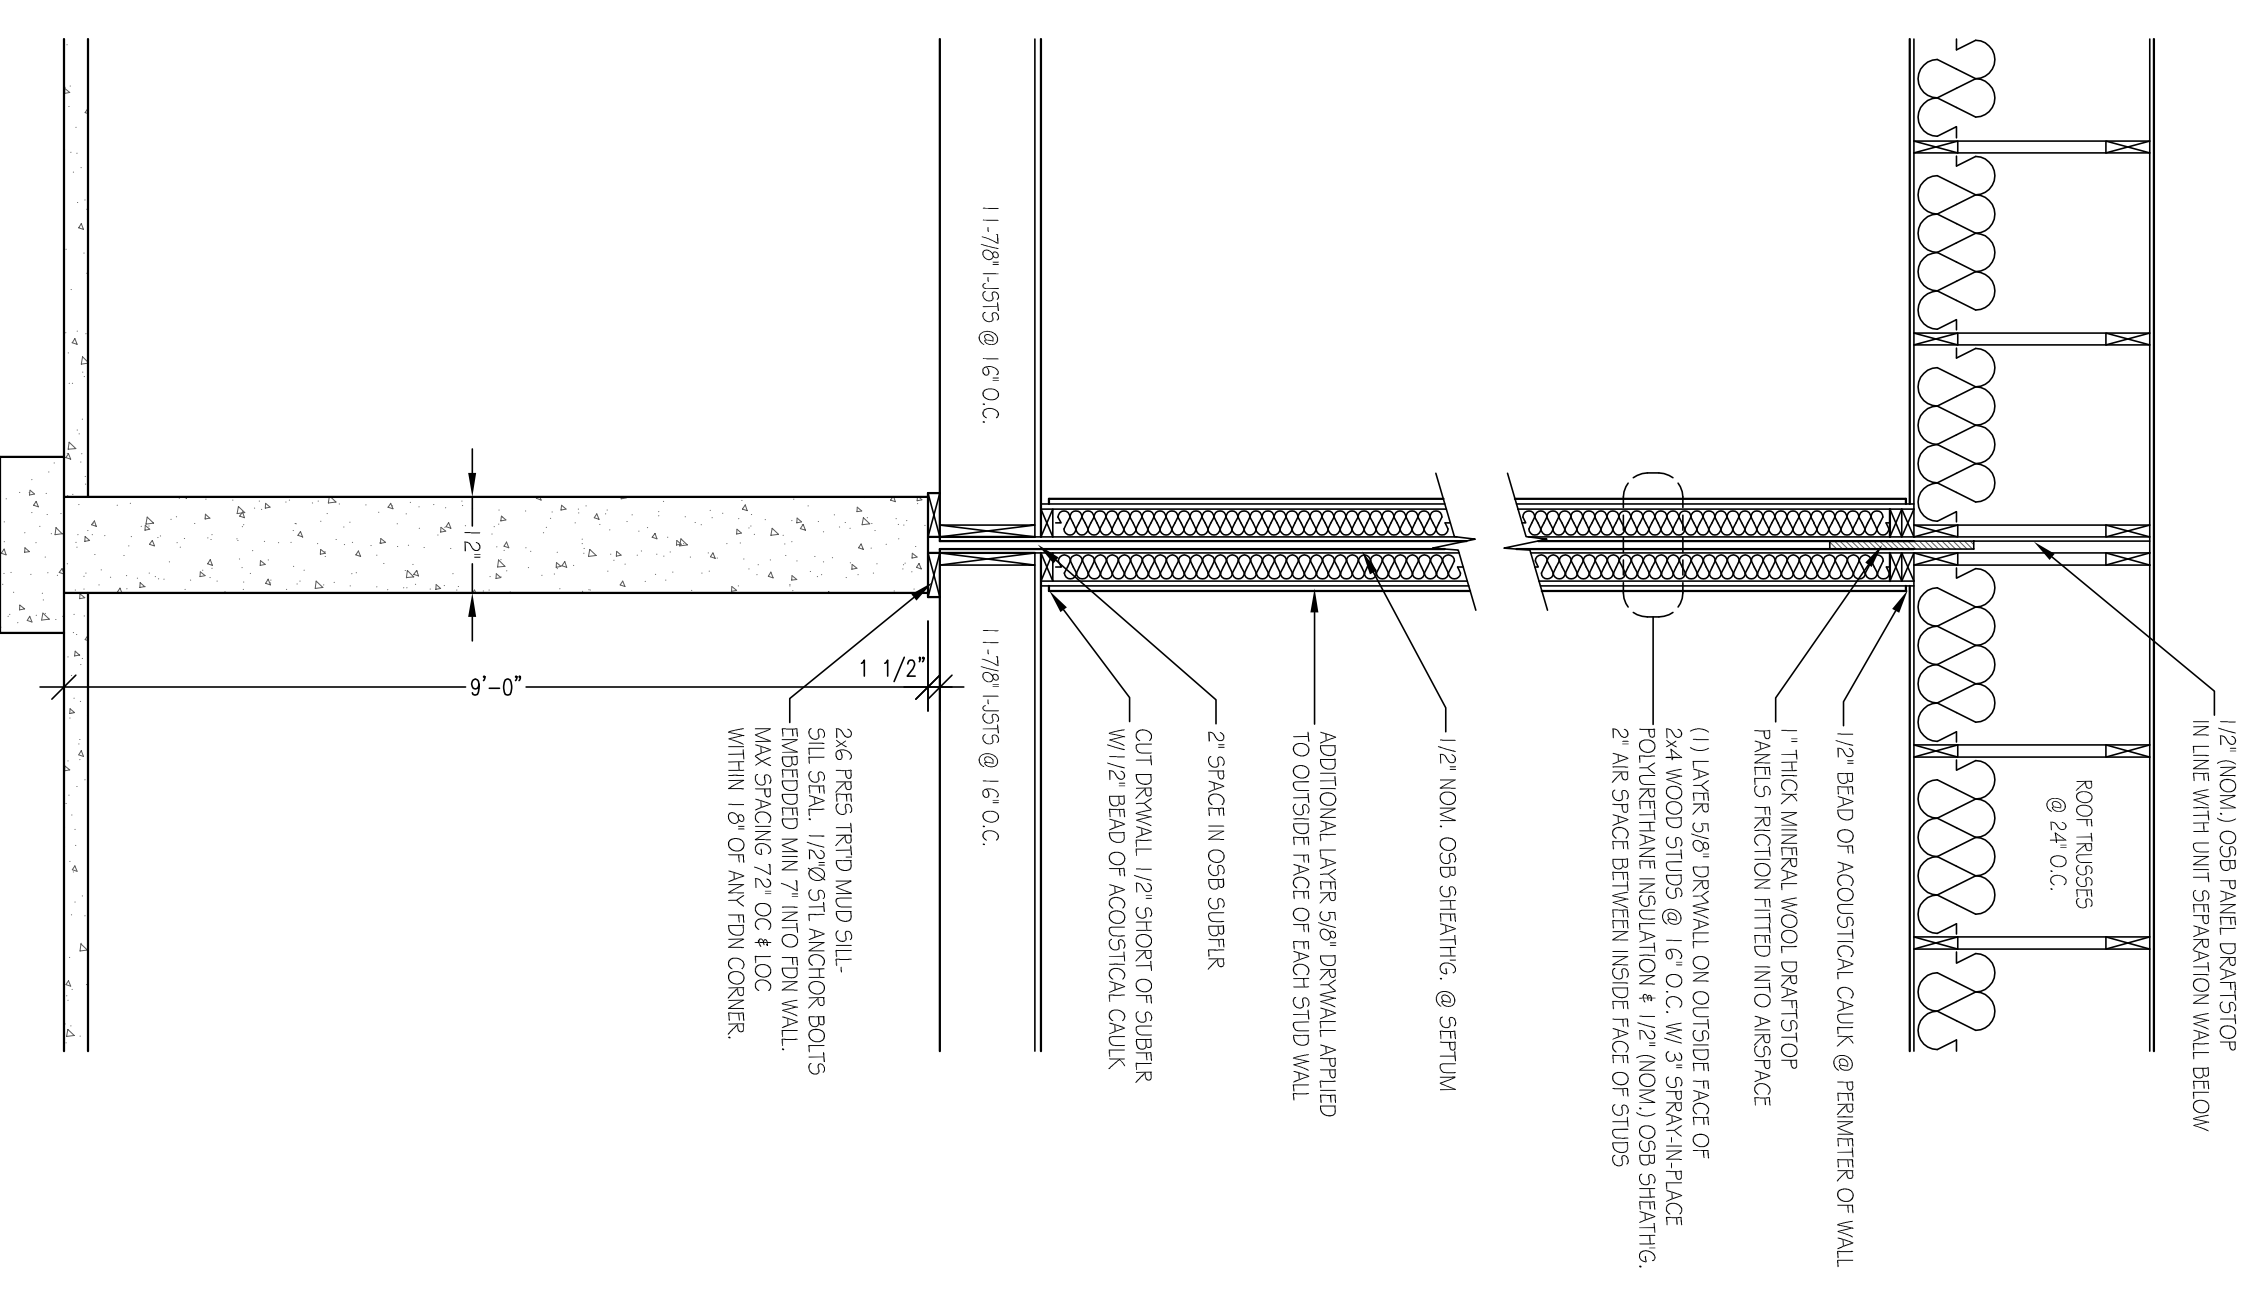

**UNIT SEPARATION ASSEMBLY**  
SCALE: 1/2" = 1'-0"

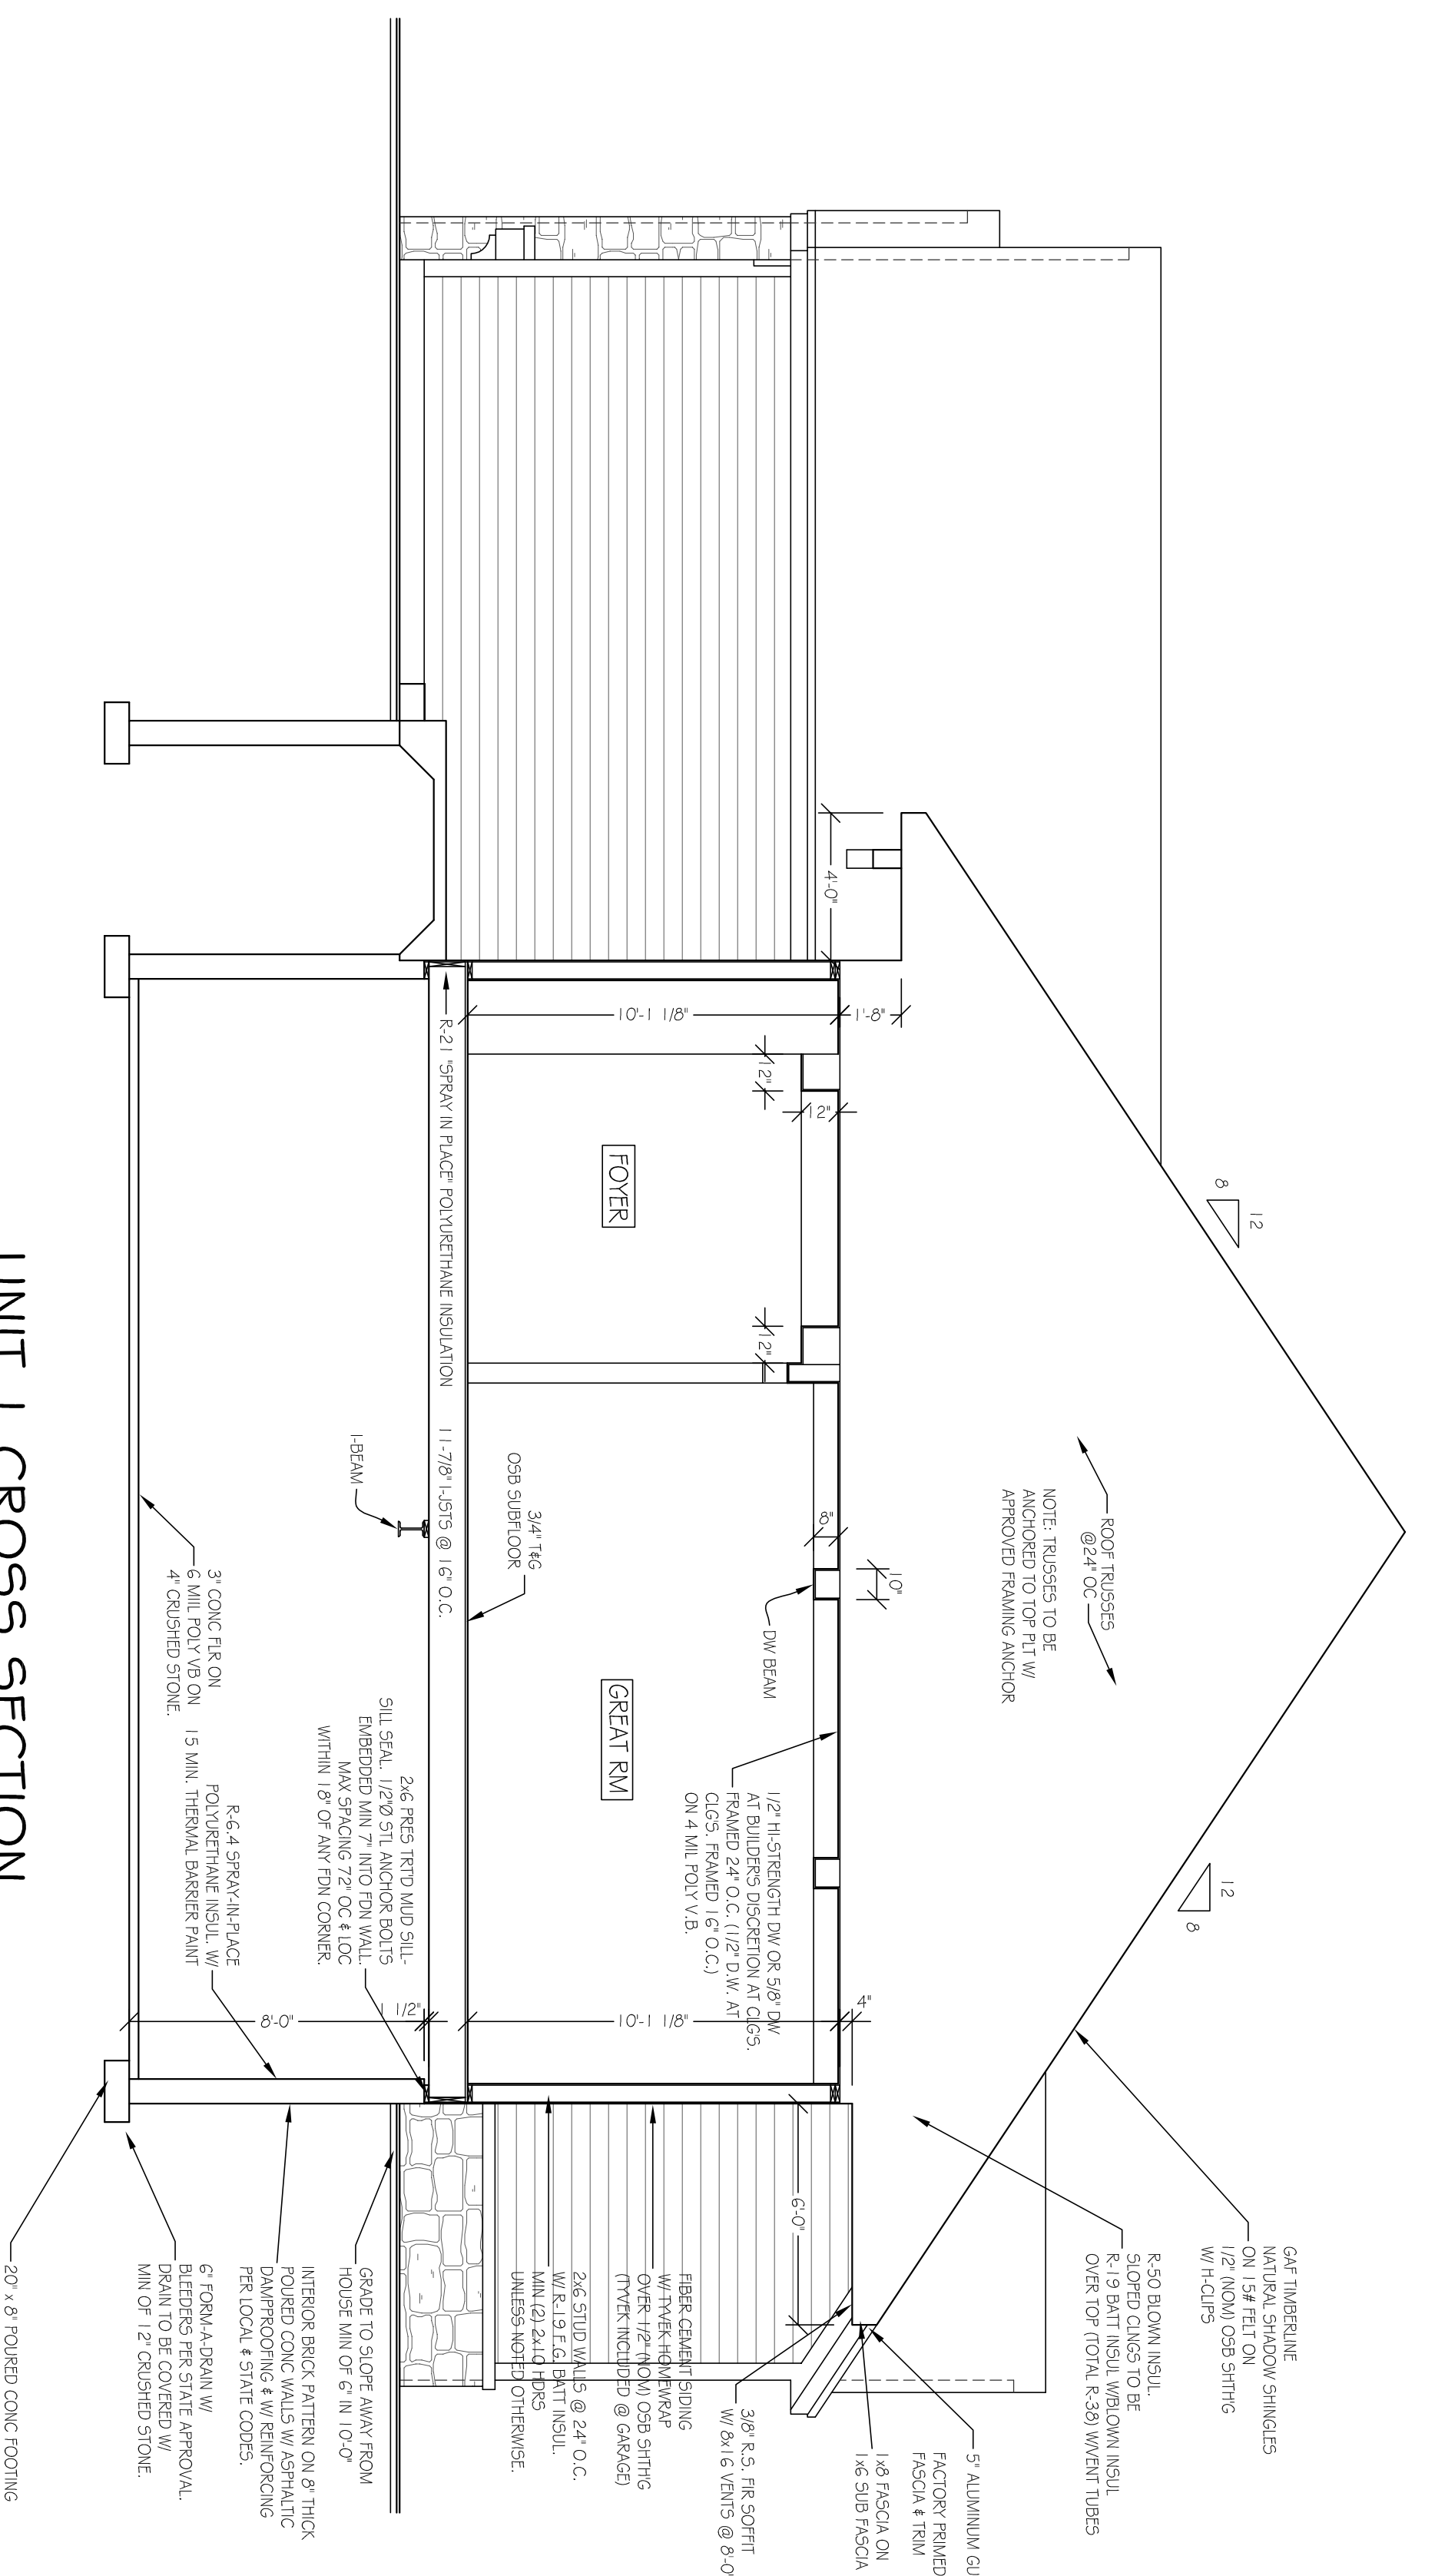

**UNIT 1 CROSS SECTION**  
SCALE: 1/4" = 1'-0"

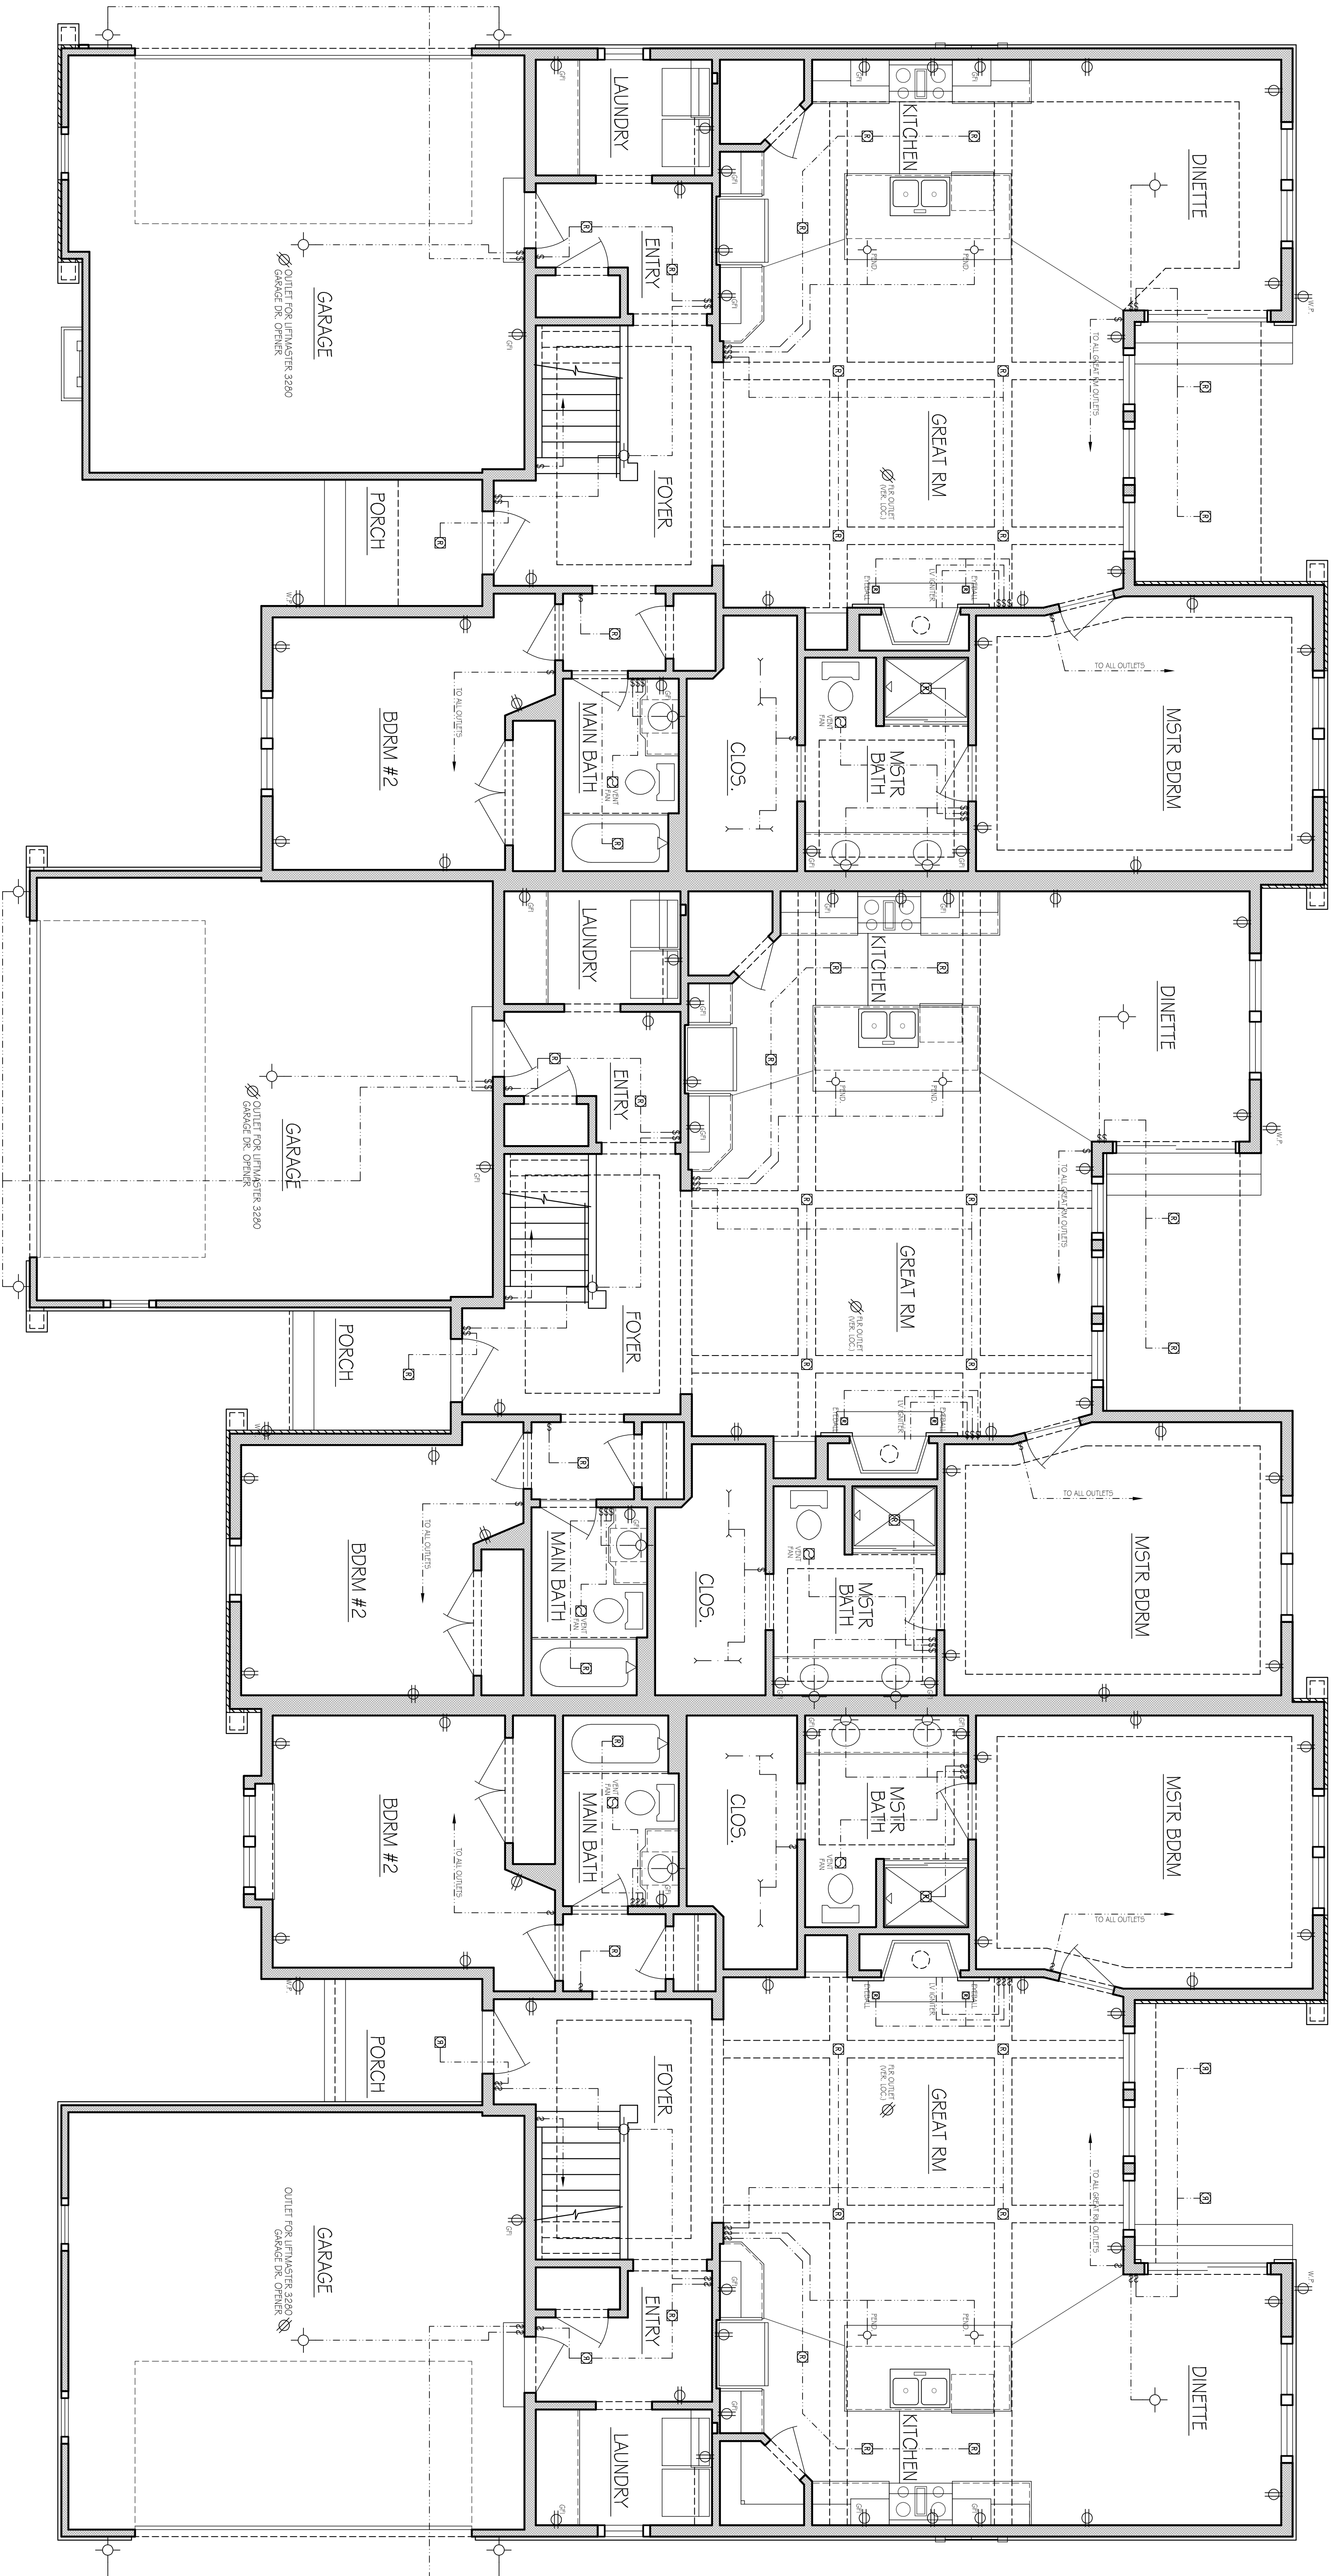

**UNIT 1 ELECTRICAL PLAN**

SCALE: 1/4" = 1'-0"

**UNIT 2 ELECTRICAL PLAN**

SCALE: 1/4" = 1'-0"

**UNIT 3 ELECTRICAL PLAN**

SCALE: 1/4" = 1'-0"