



NOTES:

ALTHOUGH EVERY EFFORT HAS BEEN MADE IN PREPARING THESE CONTRACT DOCUMENTS AND ALL DETAILS ARE DIMENSIONED AND BE RESPONSIBLE FOR SAME. THE CONTRACTOR SHALL BE RESPONSIBLE FOR VERIFYING THAT ALL WORK IS DONE IN ACCORDANCE WITH ALL STATE AND LOCAL CODES. THE CONTRACT DOCUMENTS UTILIZE A METHOD CALLED FREE DESIGN OR DESIGN BUILD FOR CODE. WINDOW, PLUMBING, ELECTRICAL, HVAC DETAILS, AND ARE RESIGNATED IN THE SPECIFICATION AS TO BE COMPLETED BY A DESIGNATED SUB. THIS MEANS THAT THE CONTRACT DOCUMENTS DO NOT INCLUDE ALL REQUIRED DETAILS AND THAT THE CONTRACTOR SHALL OBTAIN THEIR OWN SET OF QUALIFIED SUBCONTRACTORS, DESIGN AND BUILD THE FREE PORTIONS OF THE WORK. THE CLIENT IS DIRECTLY CONTRACTING WITH THE CONTRACTOR AND THEREFOR THE CLIENT AND THE CONTRACTOR ARE ASSUMING THE DESIGN AND BUILD RESPONSIBILITY FOR THE FREE DESIGN AND DESIGNABLE PORTIONS OF THE PROJECT. LEX DESIGN GROUP LLC IS NOT RESPONSIBLE FOR INSPECTING ANY ASPECT OF THE CONTRACTOR'S WORK, OR FOR OBSERVATIONS OF THE CONTRACTOR'S WORK FOR COMPLIANCE WITH THE CONTRACT DOCUMENTS.

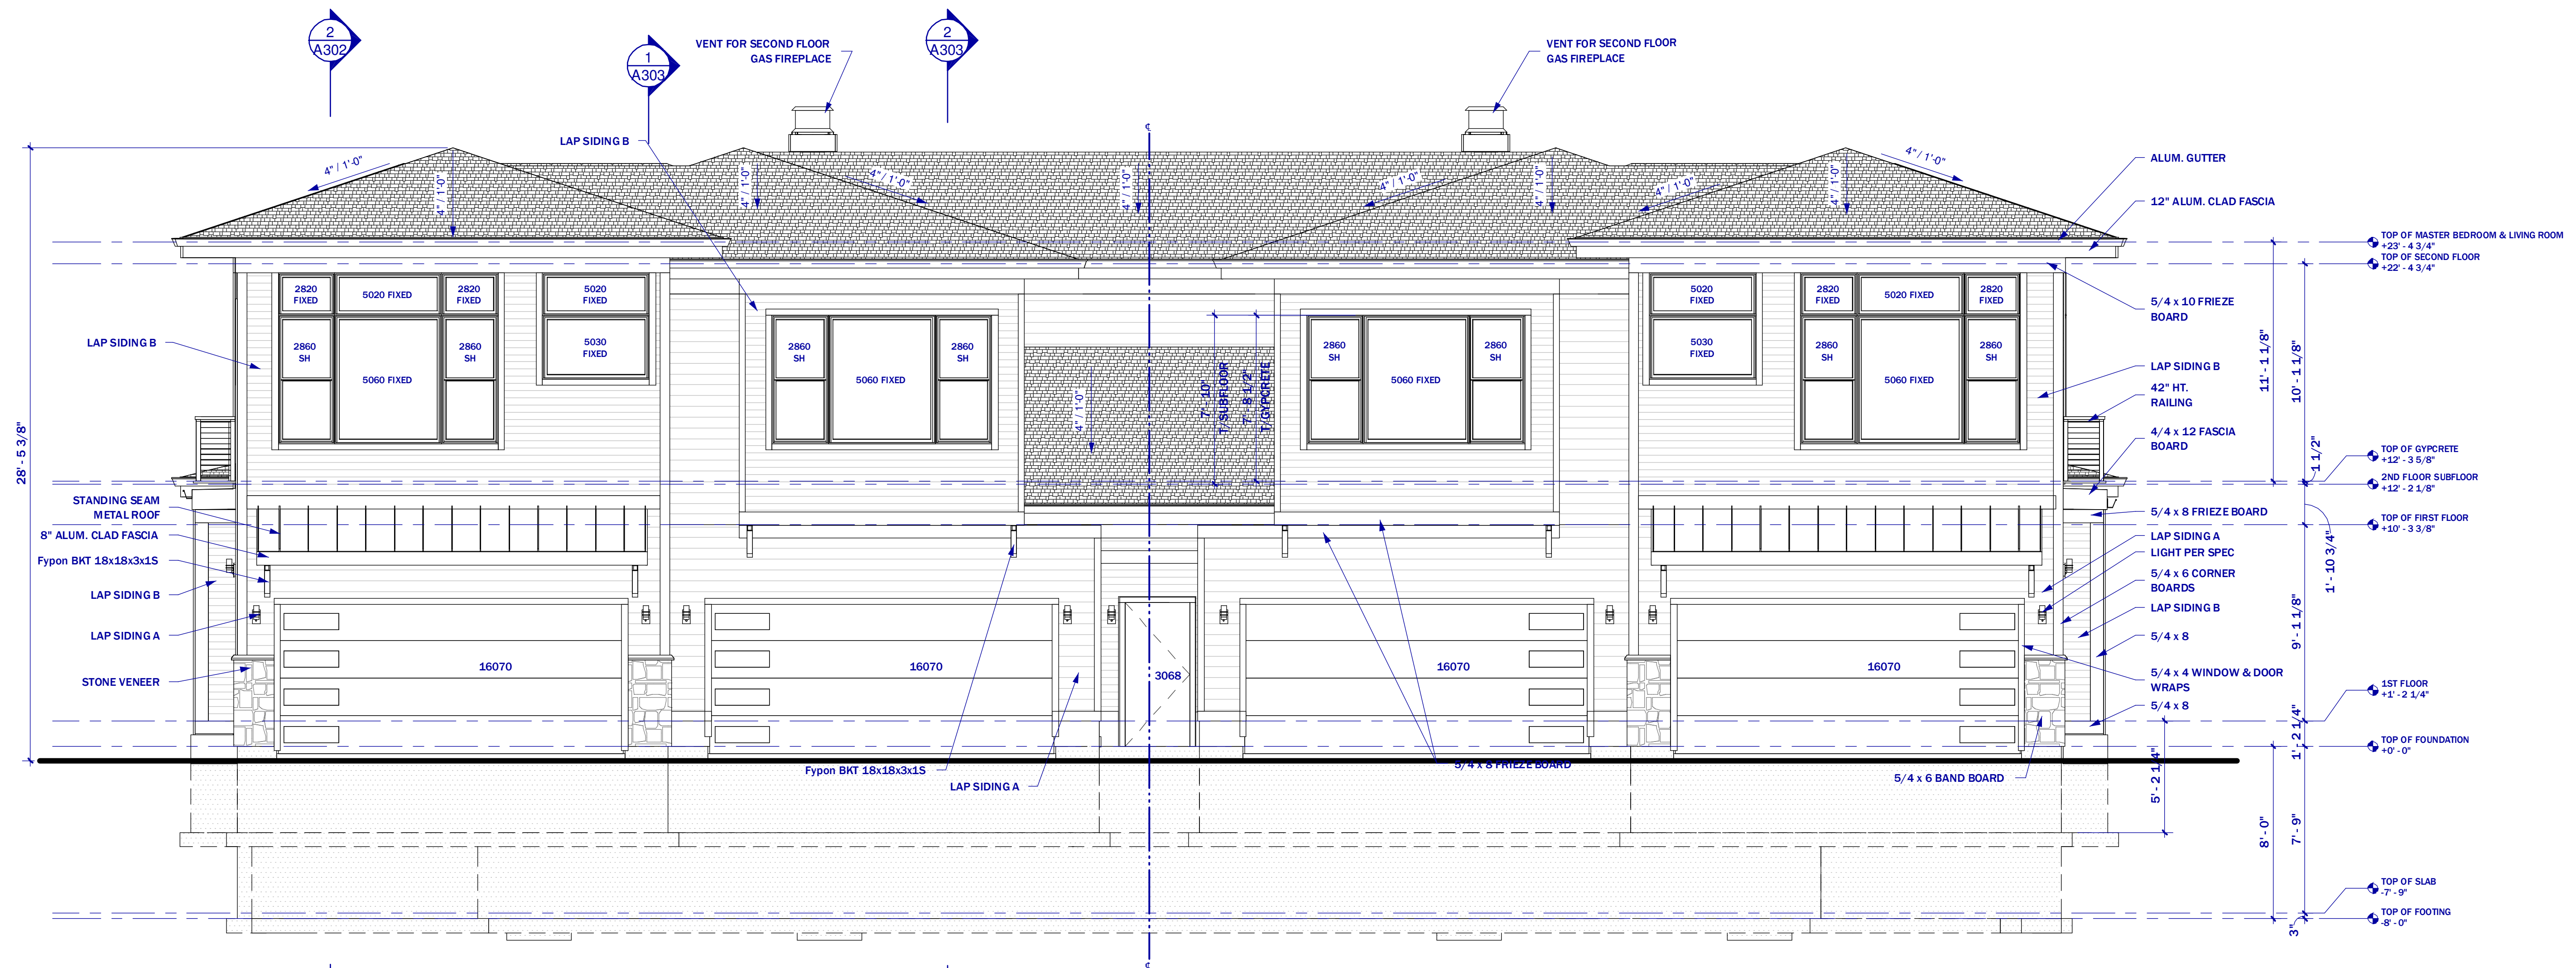

**1 FRONT ELEVATION**  
SCALE: 1/4" = 1'-0"

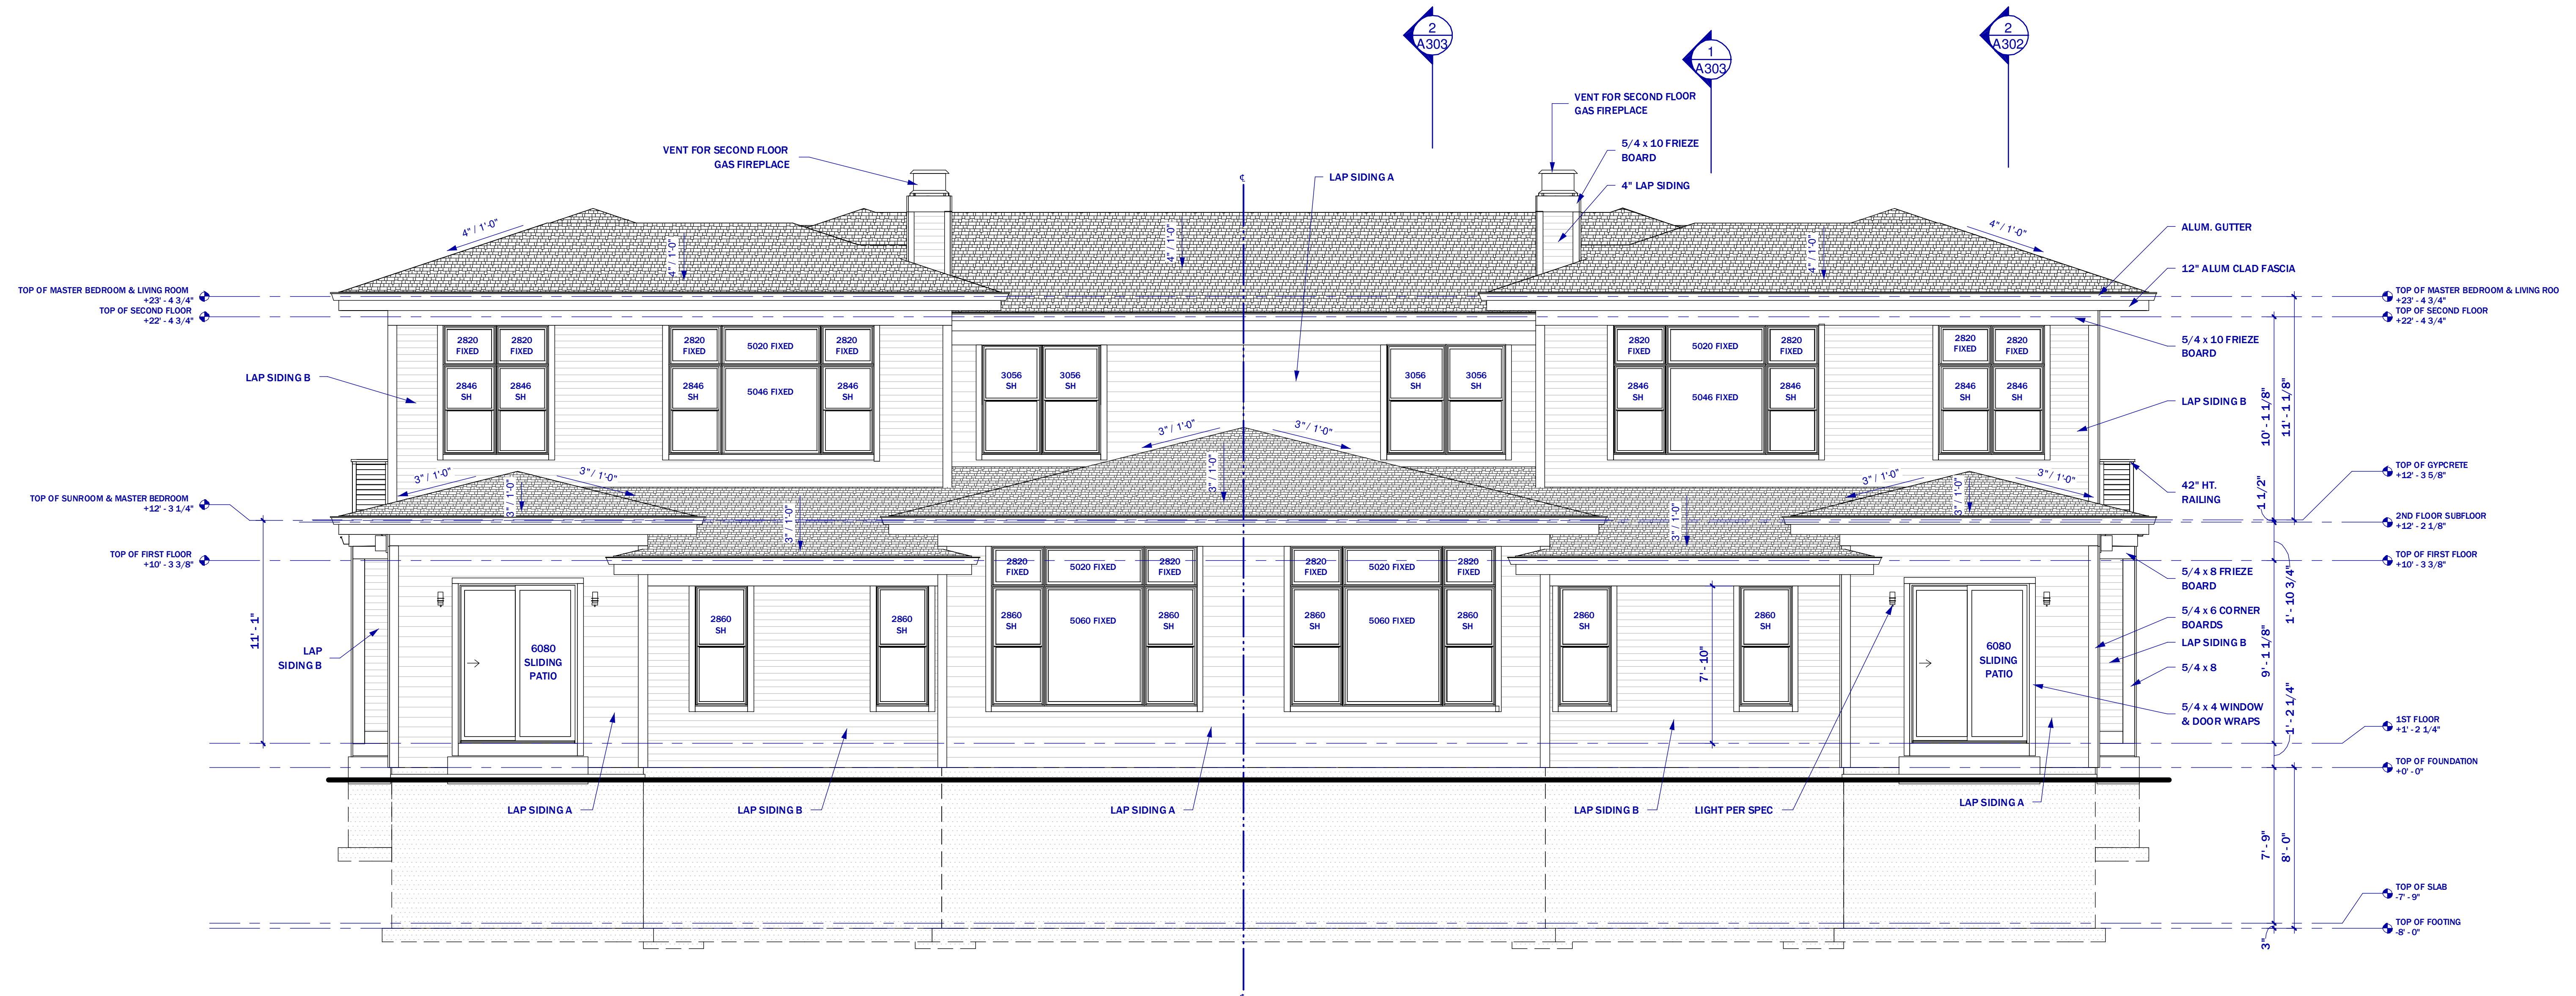


**2 REAR ELEVATION**  
SCALE: 1/4" = 1'-0"

NOT FOR CONSTRUCTION


EXTERIOR  
ELEVATIONS

SCALE: 1/4" = 1'-0"


A201

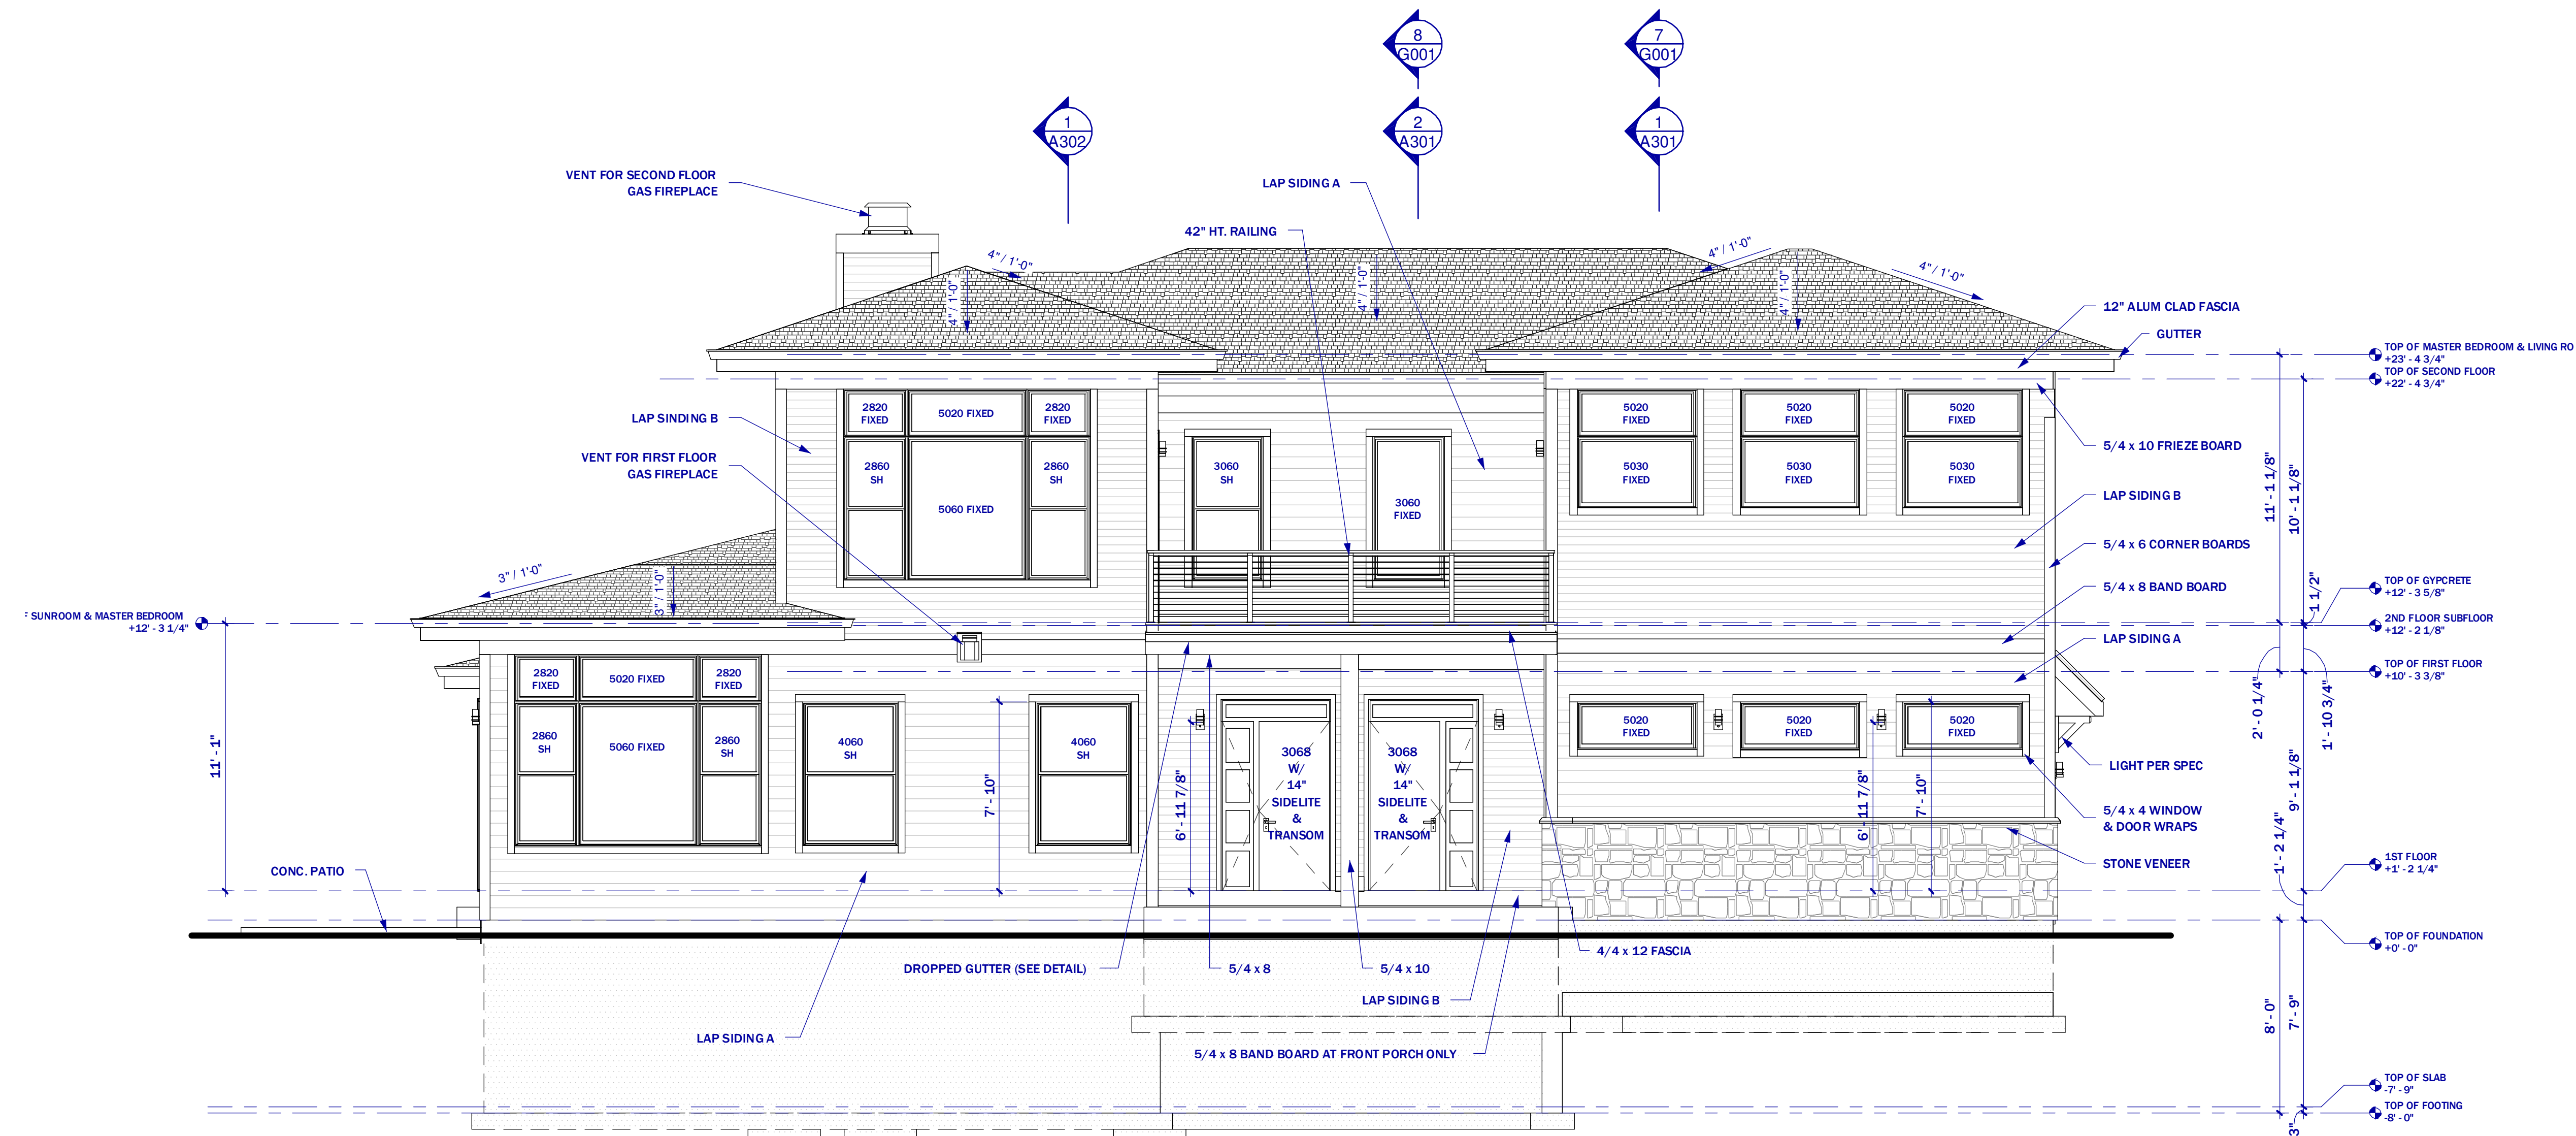


**1 LEFT ELEVATION**  
SCALE: 1/4" = 1'-0"

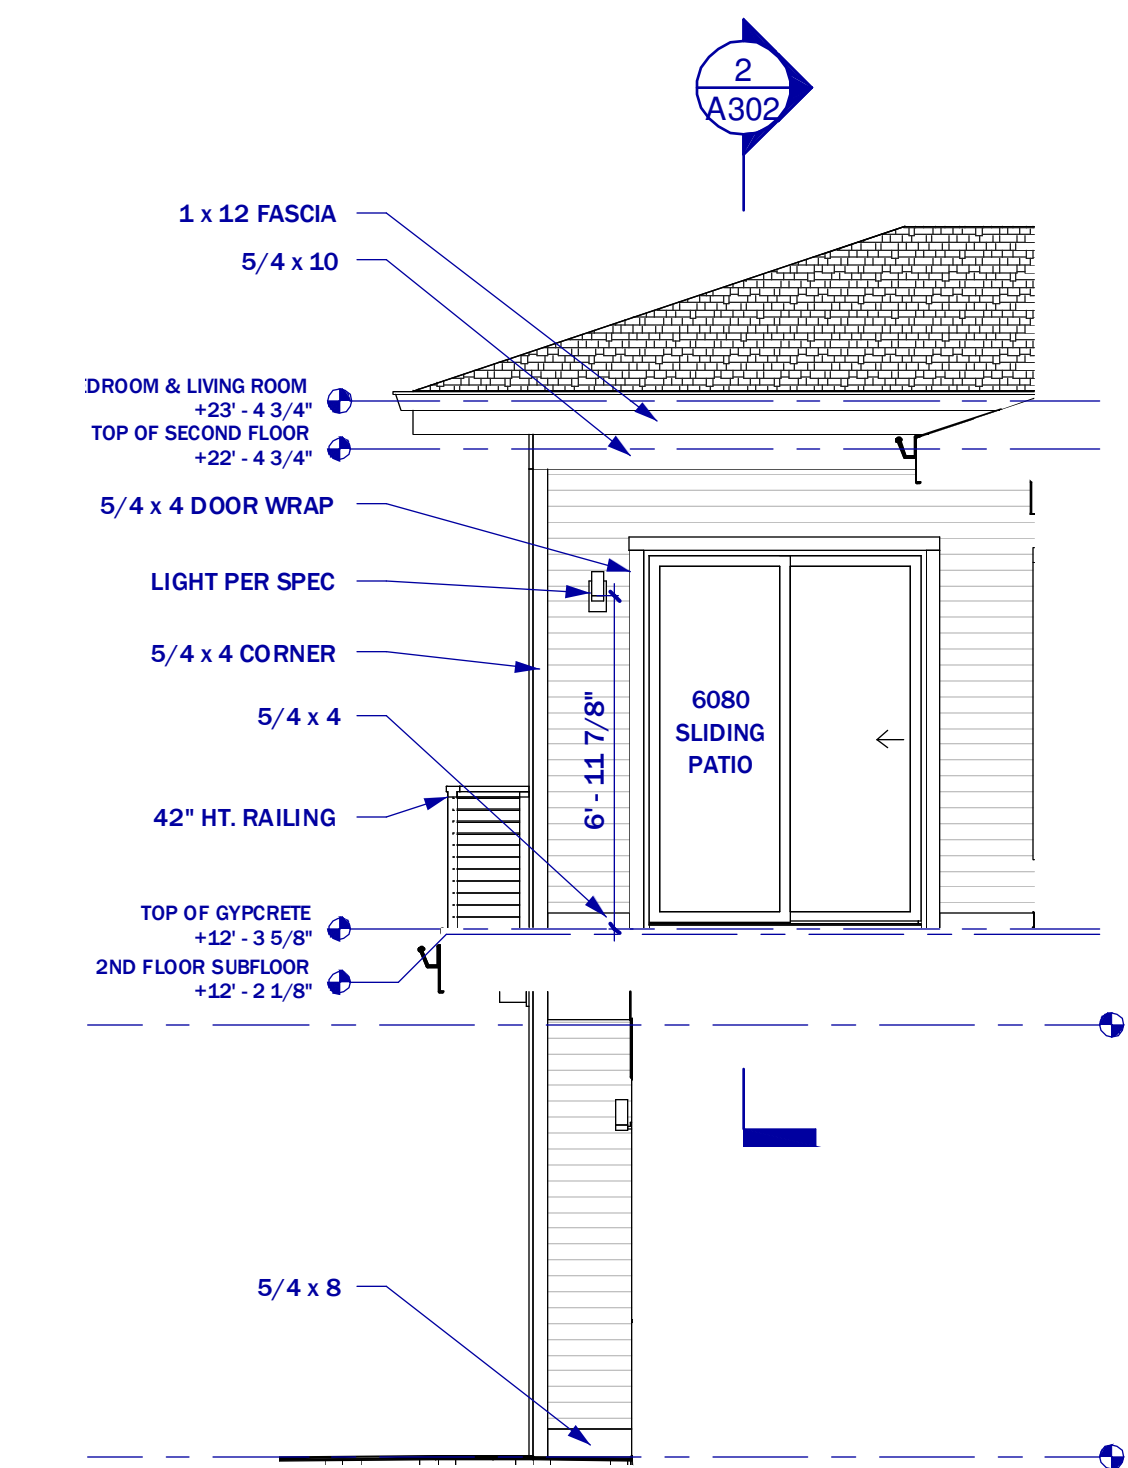

**3 LEFT ELEVATION - 1**  
SCALE: 1/4" = 1'-0"

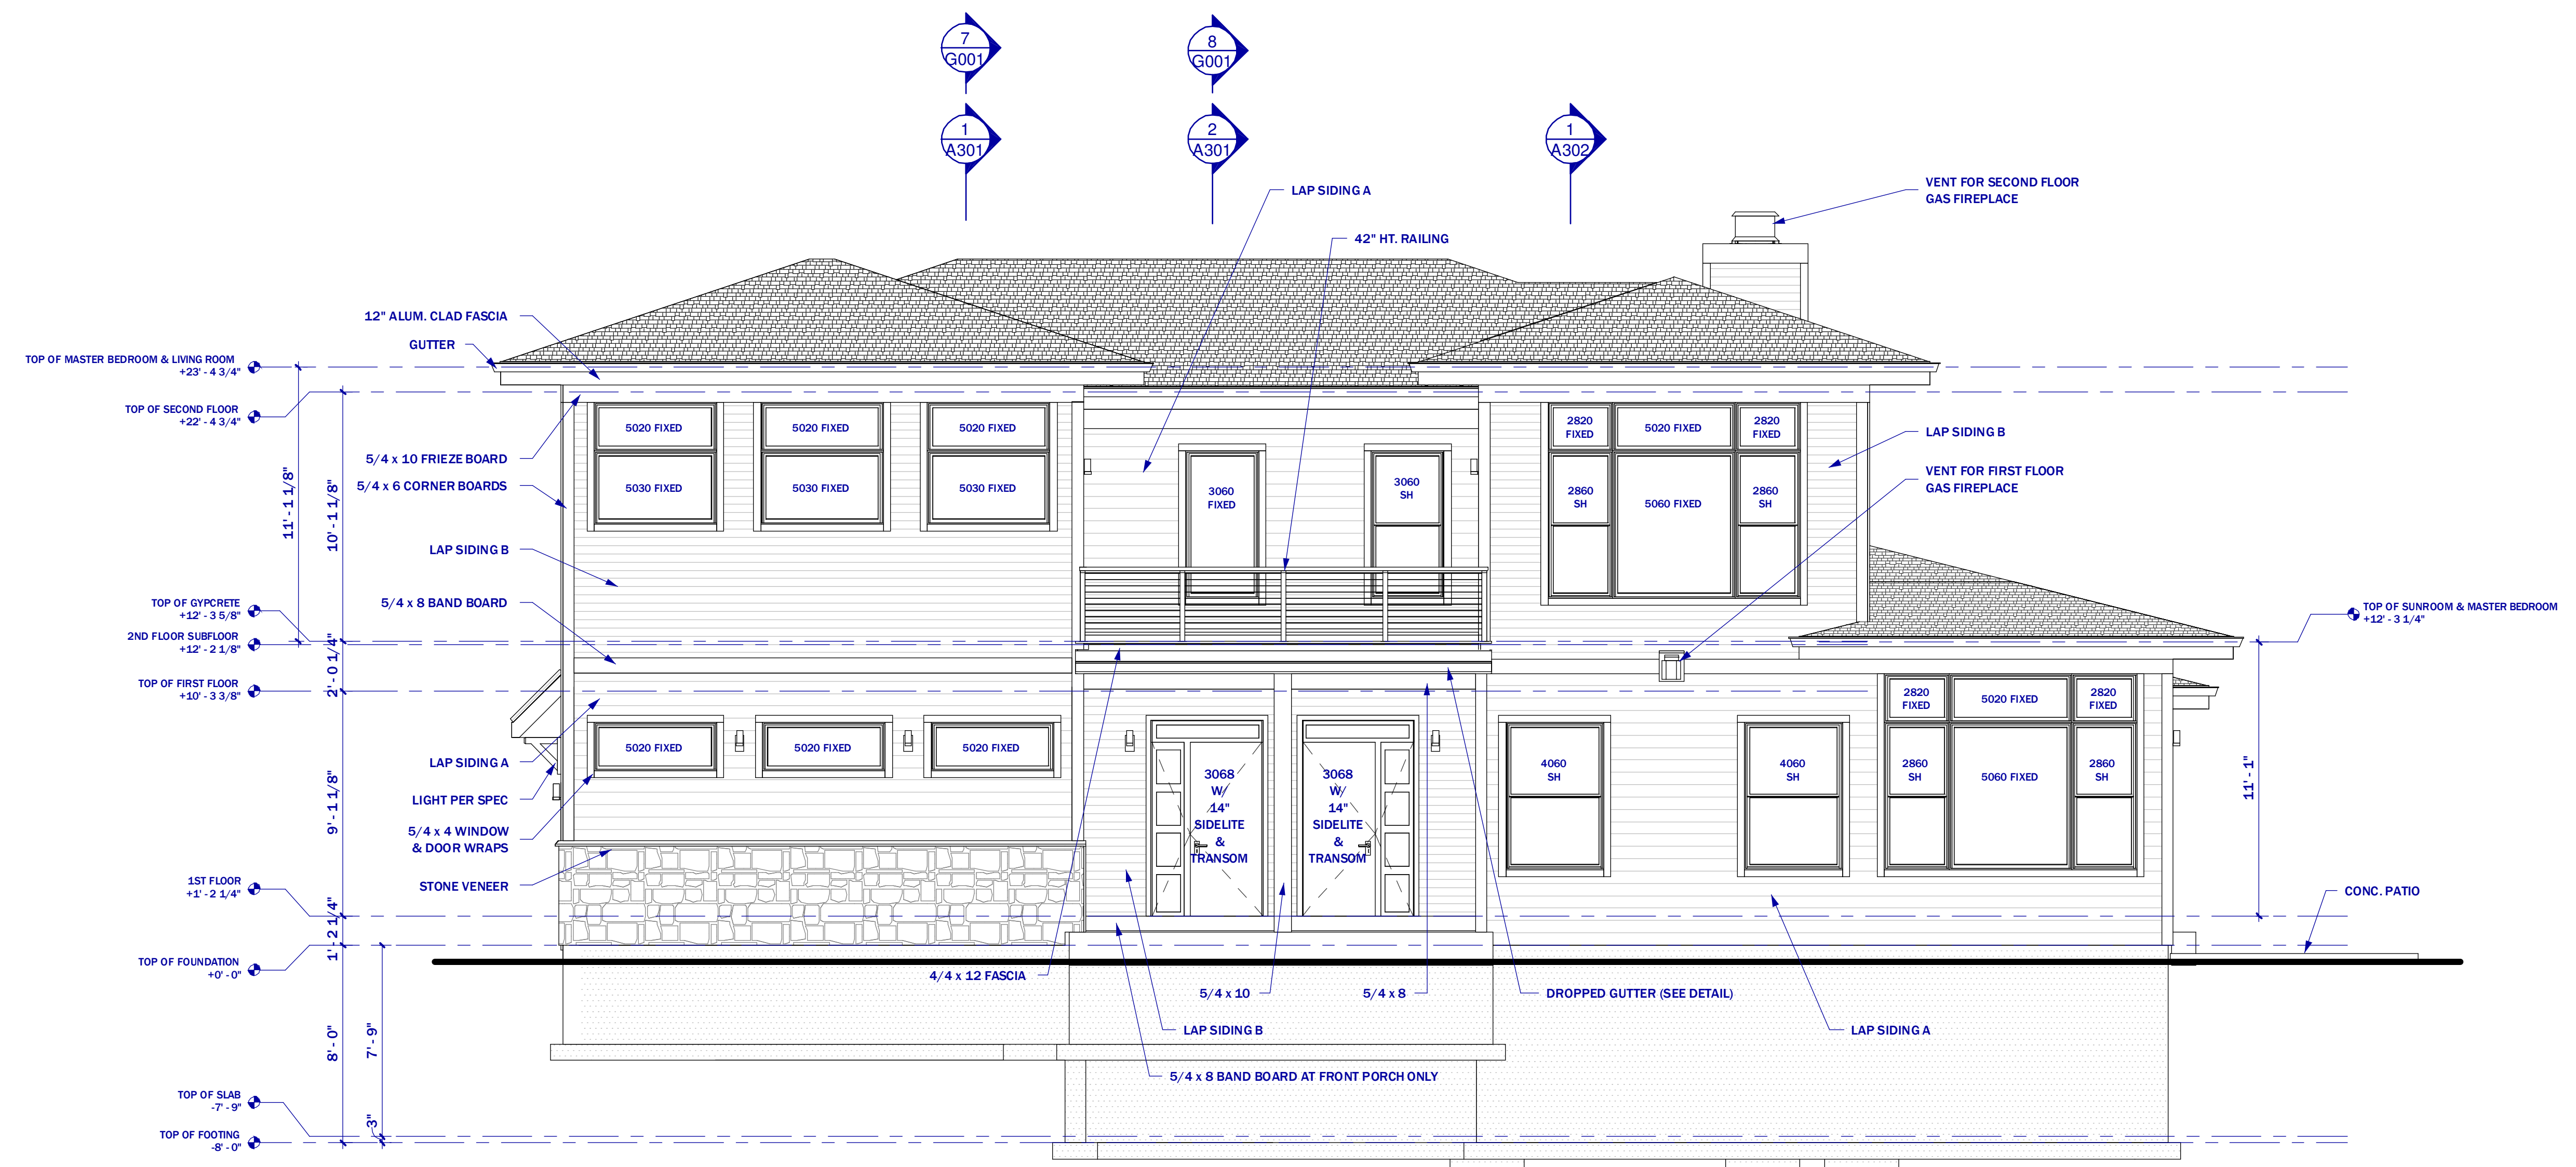

**2 RIGHT ELEVATION**  
SCALE: 1/4" = 1'-0"

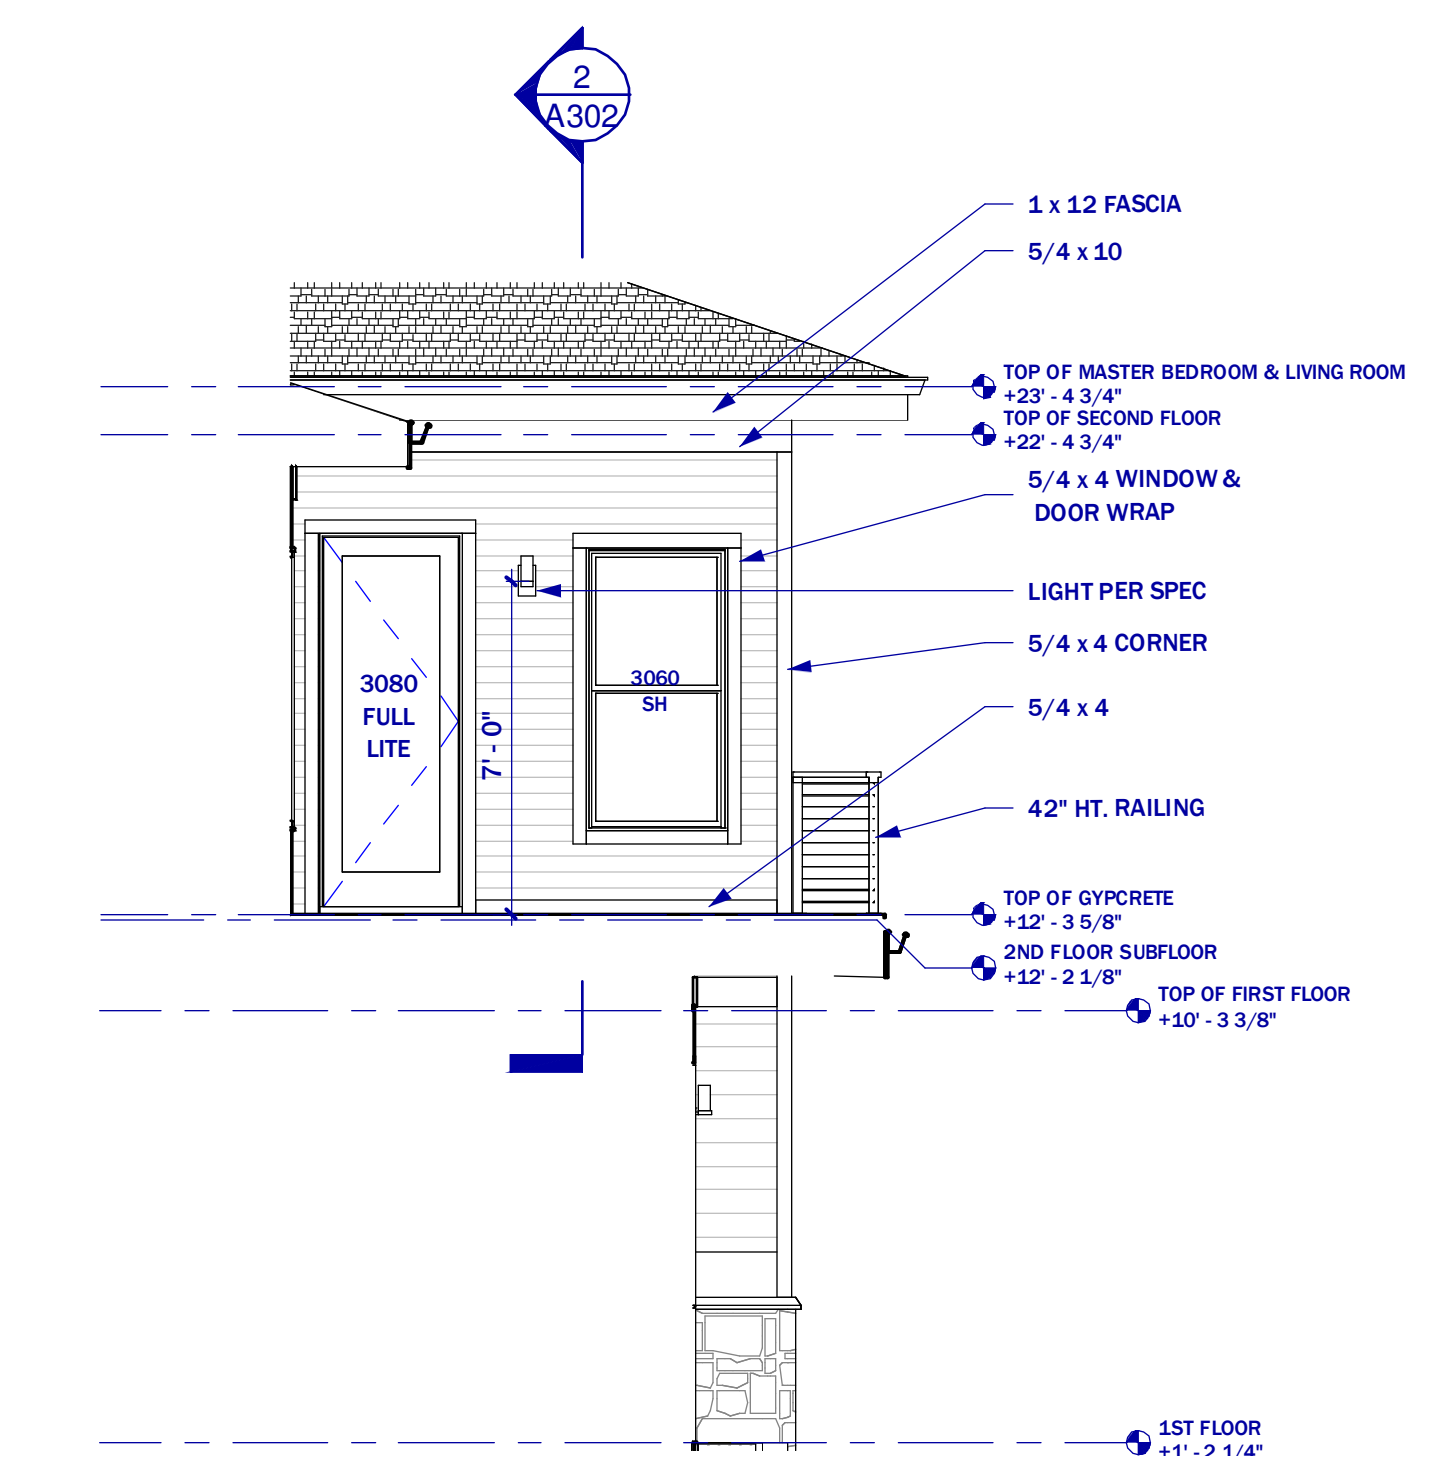

**4 LEFT ELEVATION - 2**  
SCALE: 1/4" = 1'-0"

**NOT FOR CONSTRUCTION**

**EXTERIOR  
ELEVATIONS**

SCALE: 1/4" = 1'-0"