


SITE PLAN - PHOTOMETRIC
 Scale: 1" = 30'-0"
 PLAN NORTH

LES PAUL MIDDLE SCHOOL SITE FIXTURE SCHEDULE							
TYPE	DESCRIPTION	LAMP TYPE	VOLT	WATTS	MANUFACTURER	CATALOG NUMBER	NOTE
H1	SIZE 1 LED WALL PACK - FULL CUTOFF - TYPE 2 SHORT - 1530 LUMENS	5000K LED	120-277	13	LITHONIA	DSXW1LED-10C-350-50K-T2S-MVOLT	1
H2	SIZE 1 LED WALL PACK - FULL CUTOFF - TYPE 3 MEDIUM - 2774 LUMENS	5000K LED	120-277	26	LITHONIA	DSXW1LED-10C-700-50K-T3M-MVOLT	1
H3	SIZE 1 LED WALL PACK - FULL CUTOFF - TYPE 3 MEDIUM - 5487 LUMENS	5000K LED	120-277	46	LITHONIA	DSXW1LED-20C-700-50K-T3M-MVOLT	1
H4	SIZE 1 LED WALL PACK - FULL CUTOFF - TYPE 4 MEDIUM - 5376 LUMENS	5000K LED	120-277	46	LITHONIA	DSXW1LED-20C-700-50K-T4M-MVOLT	1
H5	SIZE 2 LED WALL PACK - FULL CUTOFF - TYPE 3 MEDIUM - 6507 LUMENS	5000K LED	120-277	54	LITHONIA	DSXW2LED-30C-630-50K-T3M-MVOLT	1
K1	6" LED RECESSED DOWNLIGHT - 1000 LUMENS	5000K LED	120-277	10.4	LITHONIA	LDN6-60/10-LO6-AR-LSS-MVOLT	1
Y1	LED AREA FIXTURE - TYPE 2 MEDIUM - 14,716 LUMENS	5000K LED	120-277	125	LITHONIA	DSX1LED-P4-50K-T2M-MVOLT-SPA	1
Y5	LED AREA FIXTURE - TYPE 2 SHORT - 14,641 LUMENS	5000K LED	120-277	125	LITHONIA	DSX1LED-P4-50K-T2S-MVOLT-SPA	1
Y6	LED AREA FIXTURE - TYPE 3 SHORT - 14,252 LUMENS	5000K LED	120-277	125	LITHONIA	DSX1LED-P4-50K-T3S-MVOLT-SPA	1
LP1	20'-0" STRAIGHT SQUARE STEEL 6" POLE - SINGLE	-	-	-	LITHONIA	SSS-20-5C-DM19AS-IC	1
LP2	20'-0" STRAIGHT SQUARE STEEL 6" POLE - 2 @ 180°	-	-	-	LITHONIA	SSS-20-5C-DM28AS-IC	1

GENERAL NOTES:
 1. SEE SPECIFICATIONS FOR FIXTURE REQUIREMENTS.
 2. NO ALTERNATE FIXTURES.
 3. ALL INTERIOR LED FIXTURES TO HAVE A MINIMUM CRI OF 80+. ALL EXTERIOR LED FIXTURES TO HAVE A MINIMUM CRI OF 70+.
 4. MOUNT FIXTURES AT HEIGHT INDICATED ON DRAWINGS UNLESS NOTED OTHERWISE.

PLAN NOTES:
 1. ARCHITECT TO SELECT STANDARD COLOR AND FINISH.

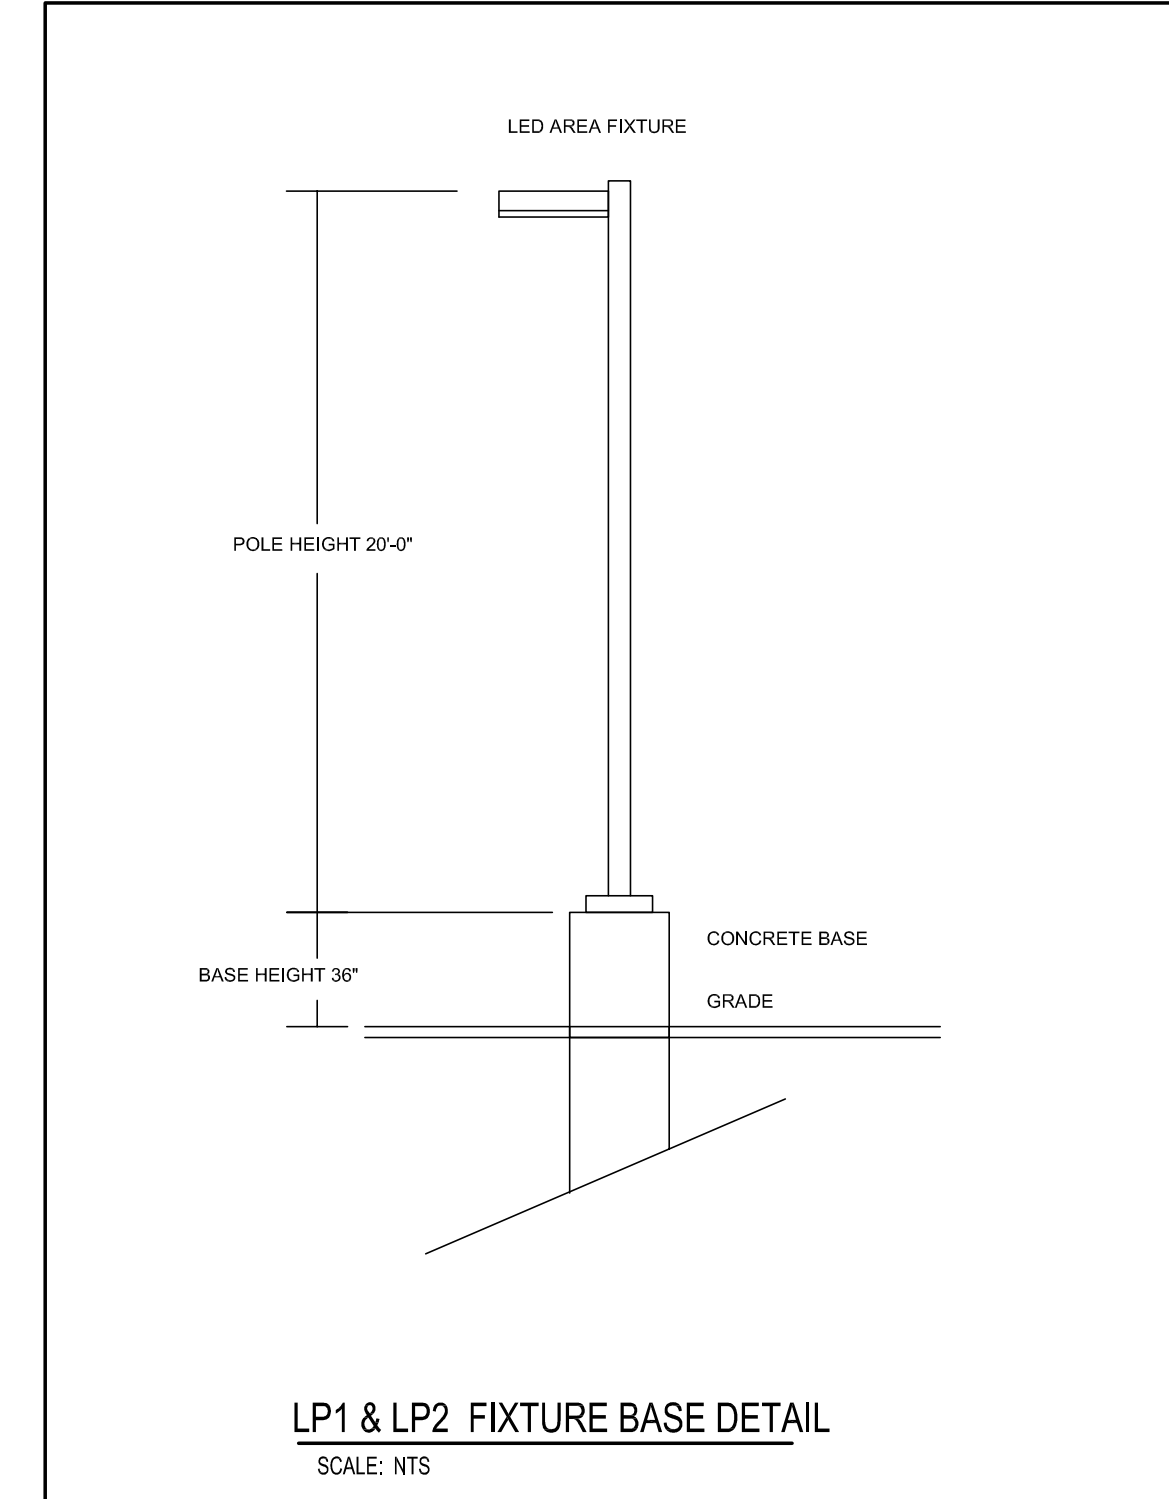

GENERAL NOTES:
 1. SITE LIGHTING CALCULATED AT GRADE.



Office Locations:
Milwaukee
 829 S. 1st Street
 Milwaukee, Wisconsin 53204
 T: 414.226.0200
Sheboygan
 1227A North 8th Street
 PO Box 955
 Sheboygan, Wisconsin
 53082
 T: 920.459.4200
 www.brayarch.com



Project Title:
**ADDITION AND REMODELING TO:
 LES PAUL MIDDLE SCHOOL
 WAUKESHA SCHOOL DISTRICT
 325 CARROLL STREET, WAUKESHA, WI 53186**

REVISIONS:

DATE	DESCRIPTION

Project Number:
3353

Issued For:
CITY SUBMITTAL

11/06/2019
 Sheet Title:
**SITE PLAN -
 PHOTOMETRIC**

Sheet Number:
E0.00