
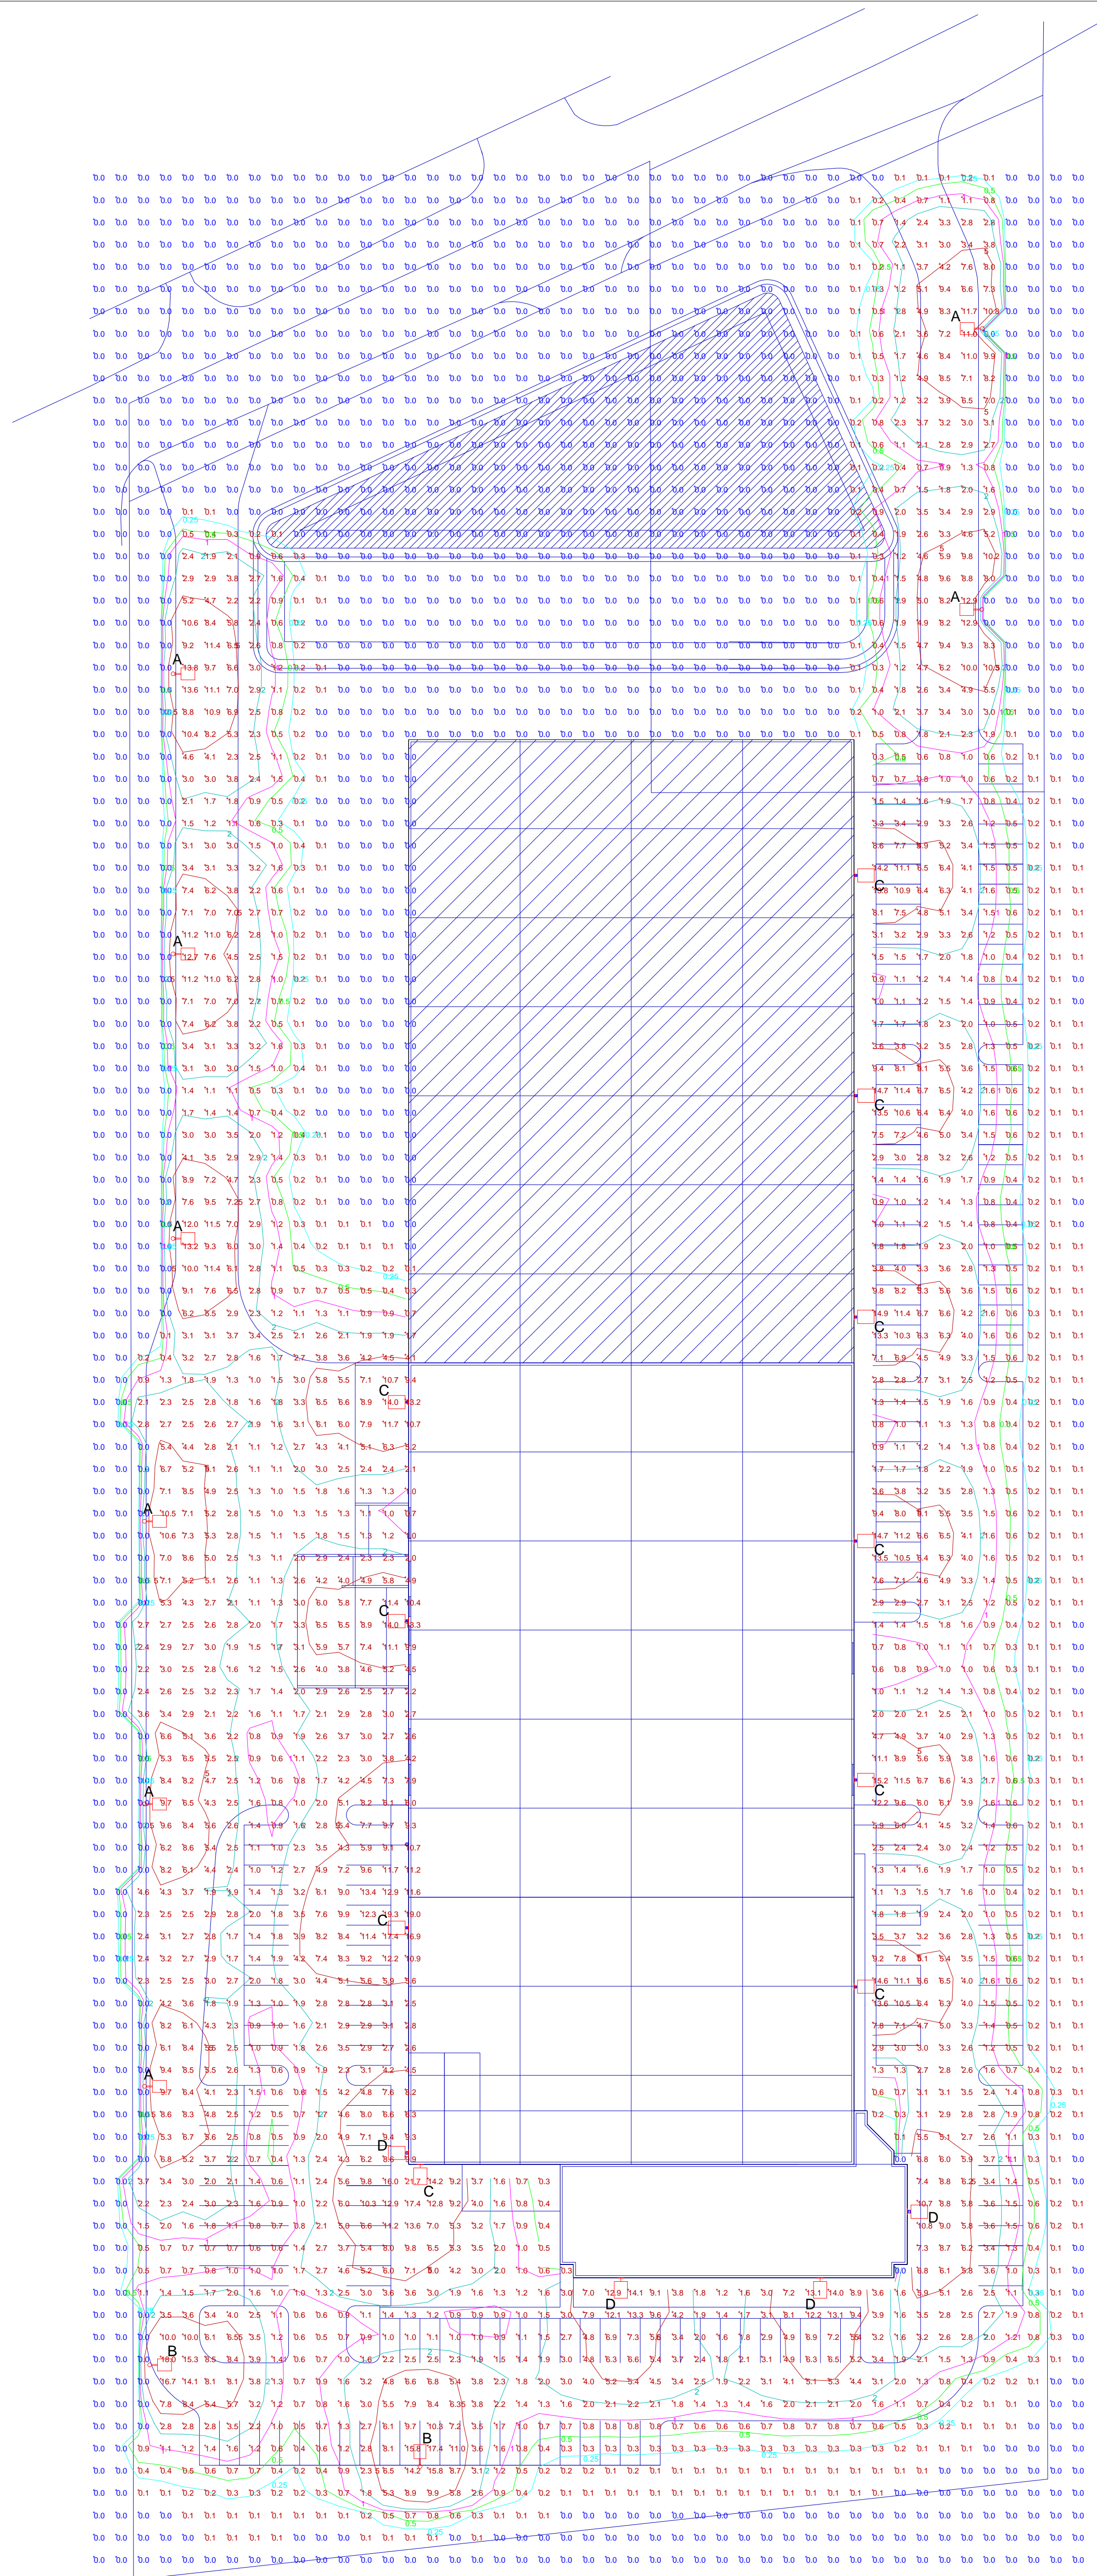


LUMINAIRE SCHEDULE					
Symbol	Label	Qty	Catalog Number	Description	Lamp
	A	8	Ruud PR2540	16' Parking/Roadway with back light shield 20' pole on 6 2 base	400 WATT HPS
	B	2	Ruud AC2540	16' Area Cutoff with back light shield 20' pole on a 2 base	400 WATT HPS
	C	10	Ruud AC2540	16' AREA CUTOFF Building mounted at 24'	400 WATT HPS
	D	4	Ruud PR2540	16' PARKING/ROADWAY Building mounted at 24'	400 WATT HPS

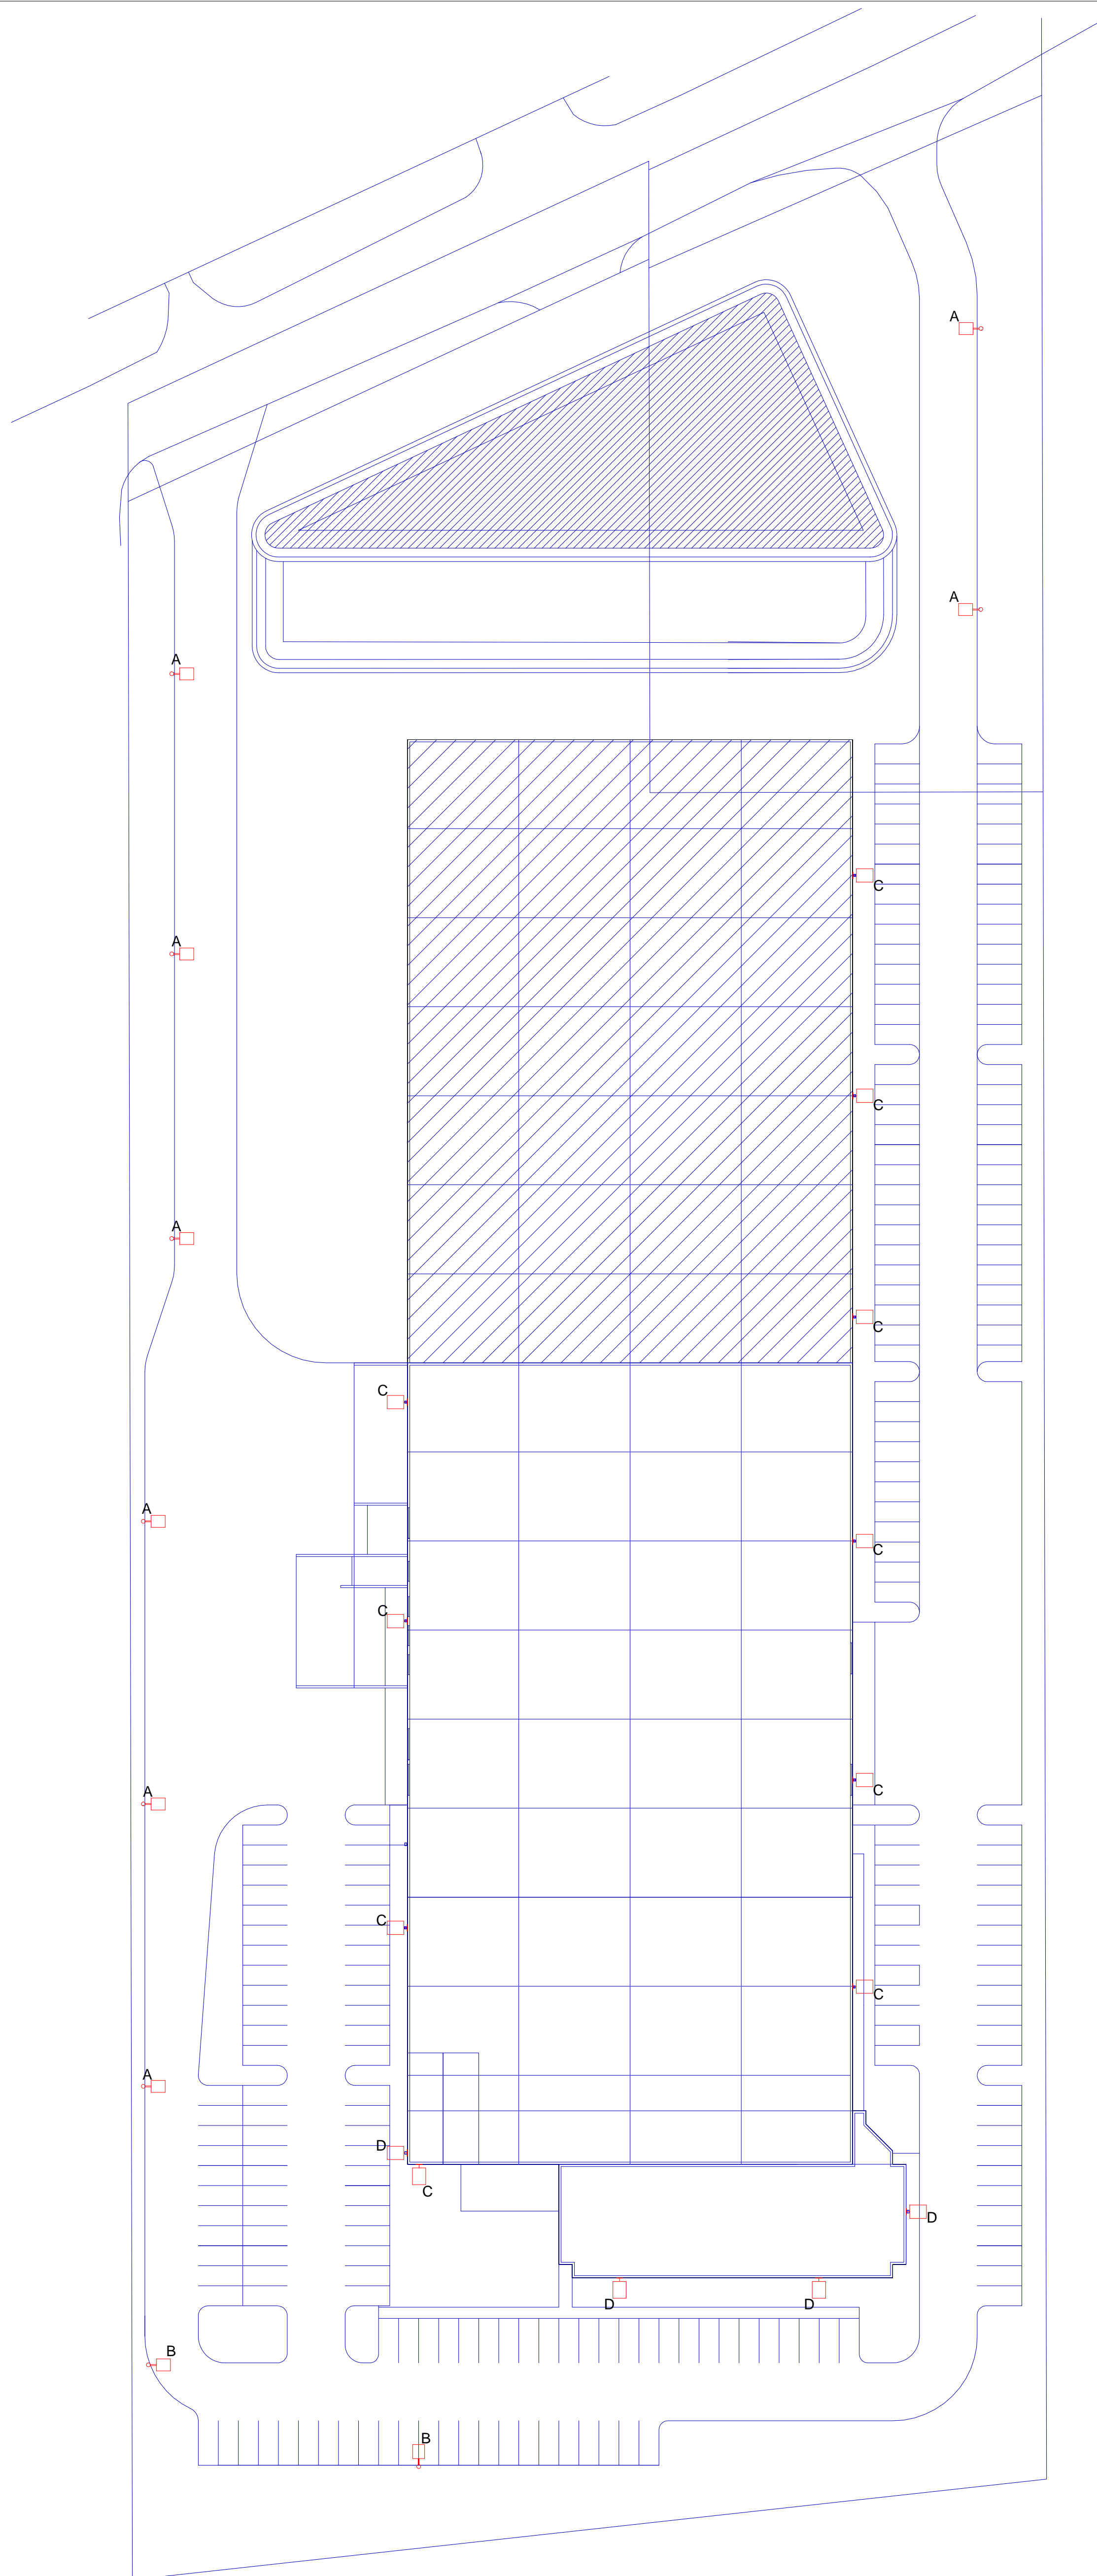

Design Title

Project Information

Oberlin Filter  
Exterior Photometric Drawing

Designer

Date

Scale

Drawing No.