



E

D

C

B

A

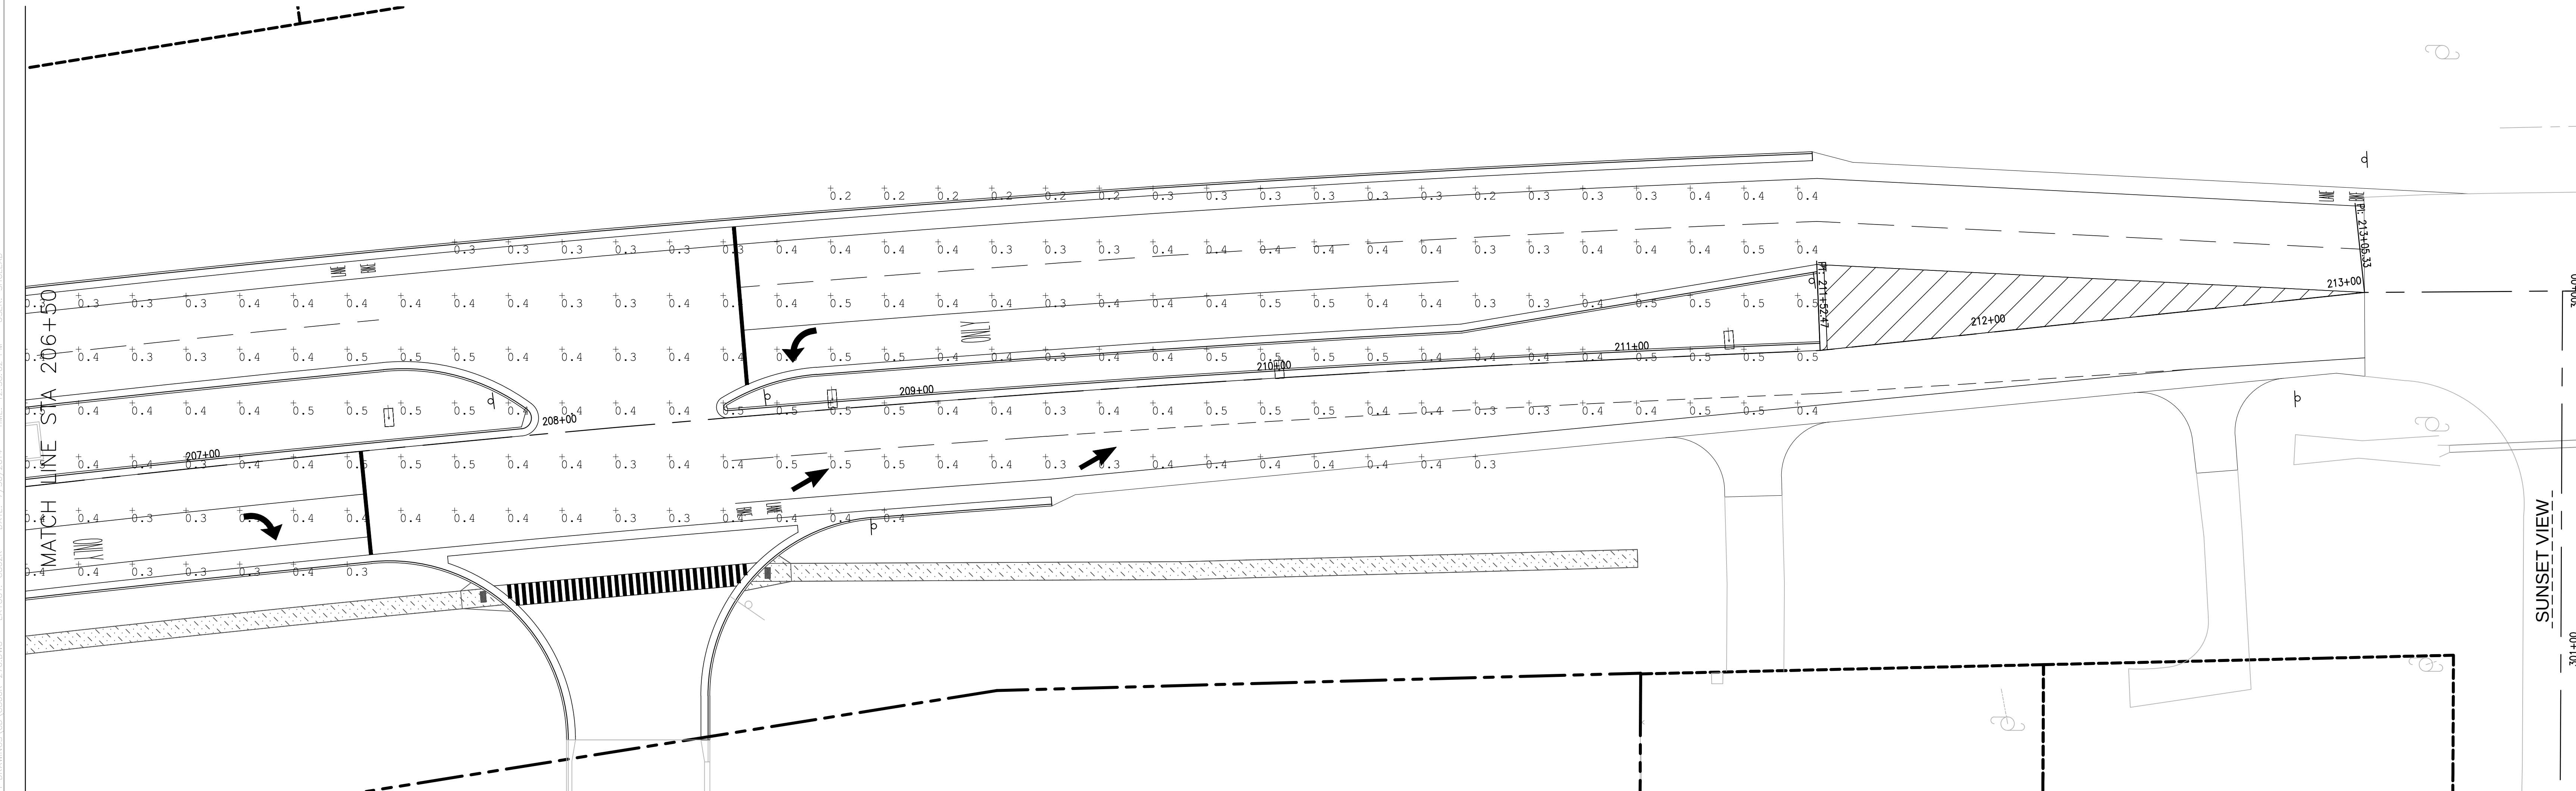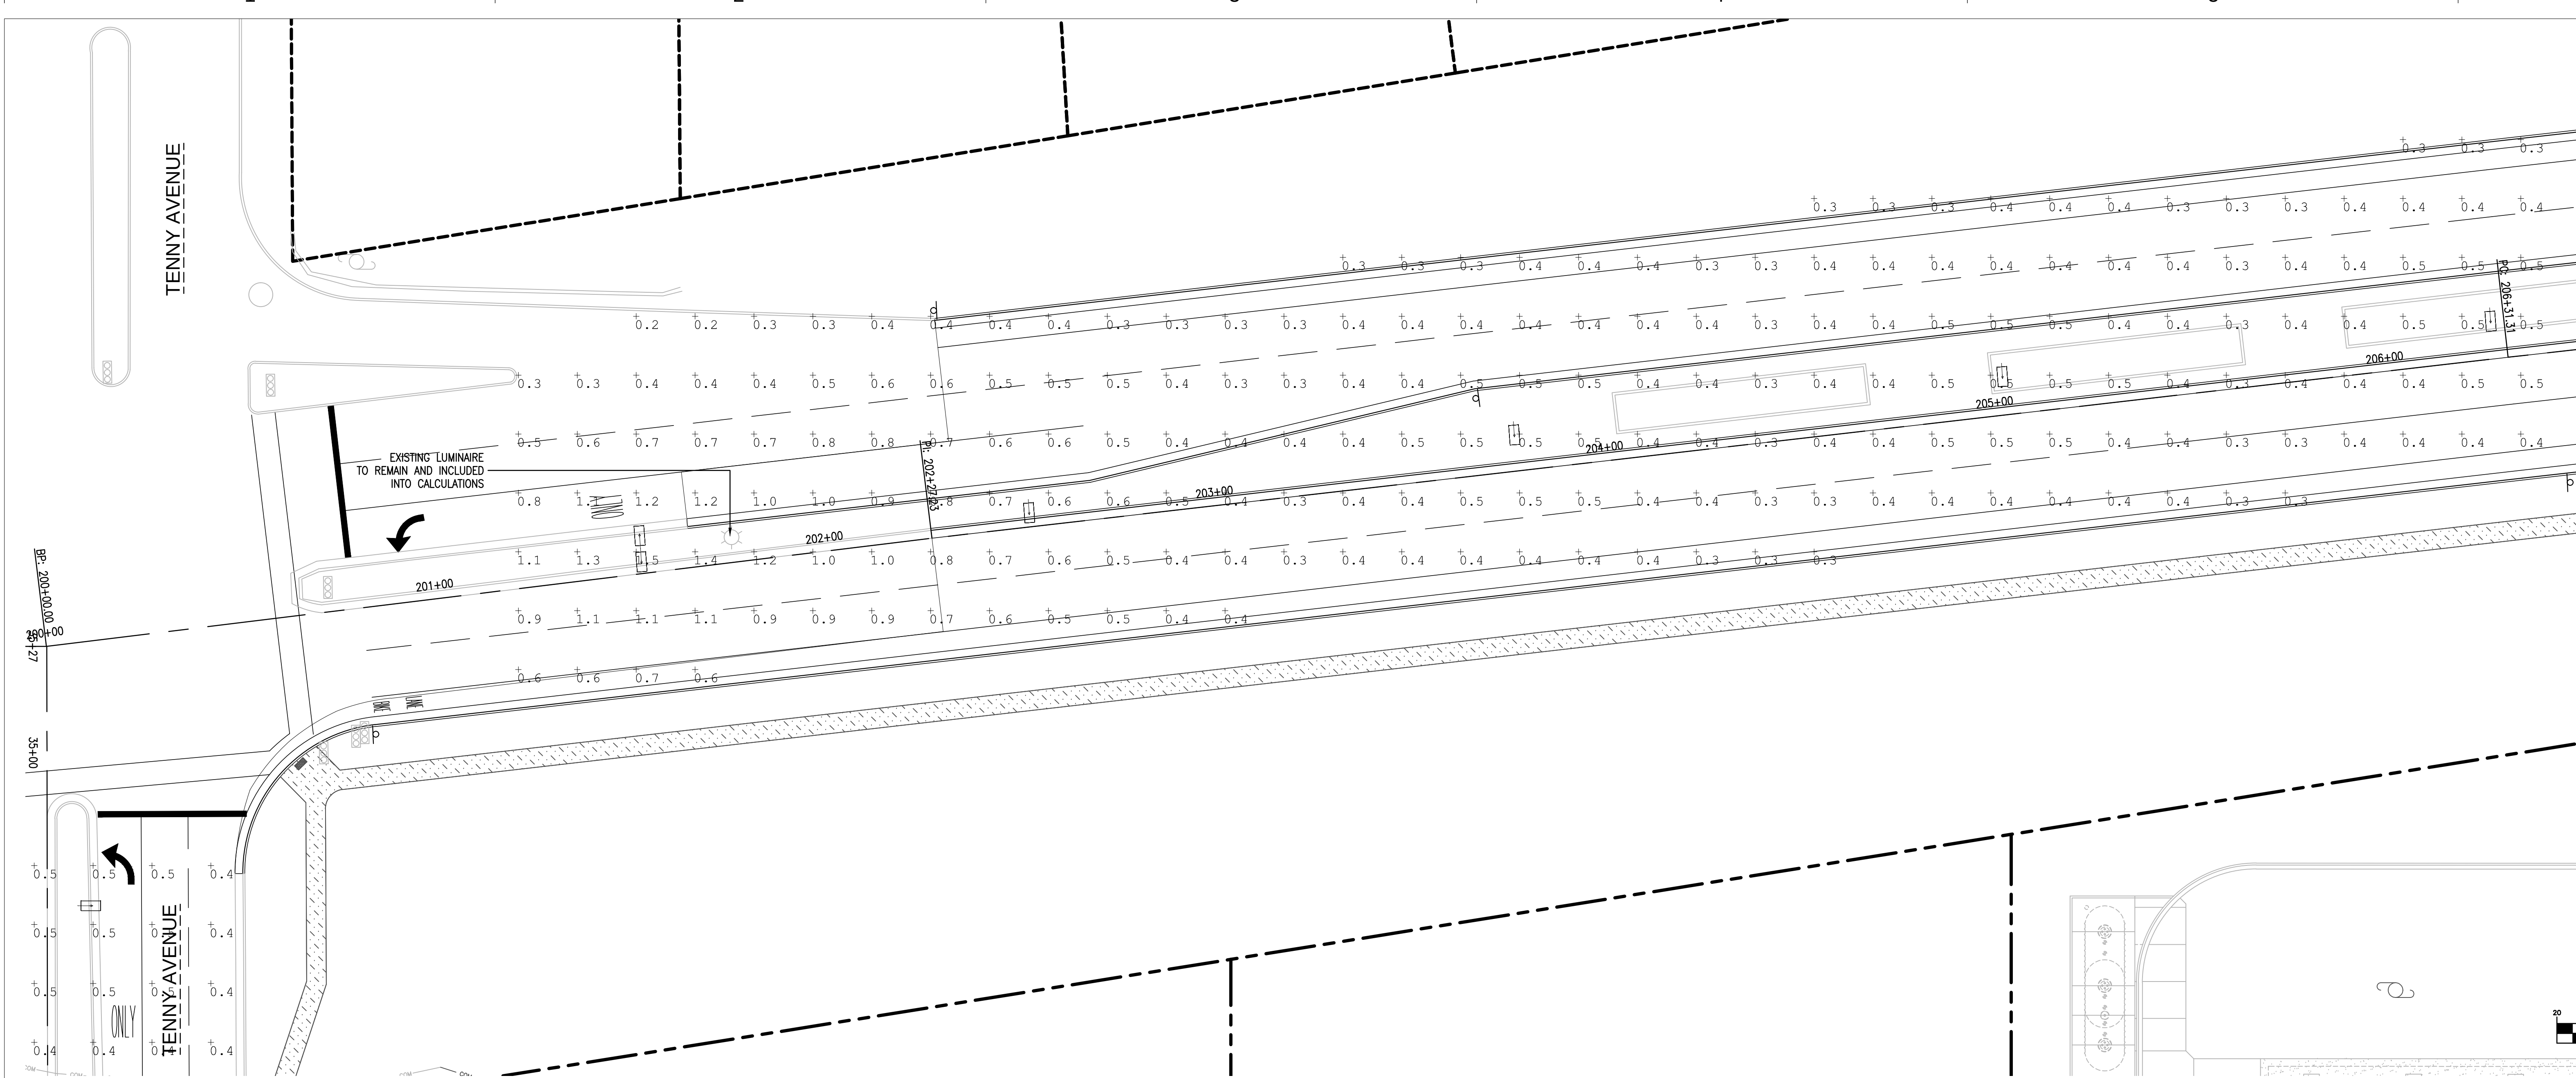

Luminaire Schedule							
Symbol	Qty	Label	Arrangement	Total Lamp Lumens	LLF	Description	
	3	SL	SINGLE	N.A.	0.900	LDRC-T3-B03-E	
	1	2EX-SL	BACK-BACK	N.A.	0.900	LDRC-T3-B03-E	
	16	LDRC-5MQ-B03-E	SINGLE	N.A.	0.900	LDRC-5MQ-B03-E	

Calculation Summary								
Label	CalcType	Units	Avg	Max	Min	Avg/Min	Max/Min	
Sunset Drive (Residential)	Illuminance	Fc	0.44	1.5	0.2	2.20	7.50	
Tennay (Residential N)	Illuminance	Fc	0.39	0.5	0.2	1.95	2.50	
Tennay (Residential S)	Illuminance	Fc	0.44	0.7	0.2	2.20	3.50	

A1

SCALE: 1"=20' H

PHOTOMETRIC PLAN - SUNSET DRIVE

GreenbergFarrow

21 S. Evergreen Ave., Suite 200
Arlington Heights, Illinois 60005
T. 847.788.9200 F. 847.788.9536

Store: 276
801 EAST SUNSET DRIVE
(SEQ) TENNY AVE & SUNSET DR
WAUKESHA, WISCONSIN

meijer

PROFESSIONAL IN CHARGE
MATTHEW H. BUDDÉ, P.E.
PROFESSIONAL ENGINEER
LICENSE NO. E-37992

07/30/14 FINAL PLAN - RESUBMITTAL
09/25/13 CITY SUBMITTAL

Drawn By M. BUDDÉ, P.E.
Reviewer P. PHILLIPS, P.E.
Manager K. WILLIAMS, P.E.
Prof in Charge M. BUDDÉ, P.E.

Hard copy is intended to be
30"x42" when plotted. Scale(s)
indicated and graphic quality may
not be accurate for any other size.

PROJECT NO.
J120944276

SHEET NO.

C802R

©Copyright 2012
All Rights Reserved

GreenbergFarrow Project No. 20110540.0