

meijer

PROFESSIONAL IN CHARGE
MATTHEW H. BUDDE, P.E.
PROFESSIONAL ENGINEER
LICENSE NO. E-37992

07/30/14	FINAL PLAN - RESUBMITTAL
09/25/13	CITY SUBMITTAL

Drawn By	M. BUDDE, P.E.
Reviewer	P. PHILLIPS, P.E.
Manager	K. WILLIAMS, P.E.
Prof in Charge	M. BUDDE, P.E.

Hard copy is intended to be 30"x42" when plotted. Scale(s) indicated and graphic quality may not be accurate for any other size.


PROJECT NO.

J120944276

SHEET NO.

C504R

©Copyright 2012
All Rights Reserved
enbergFarrow Project No. 20110540.0

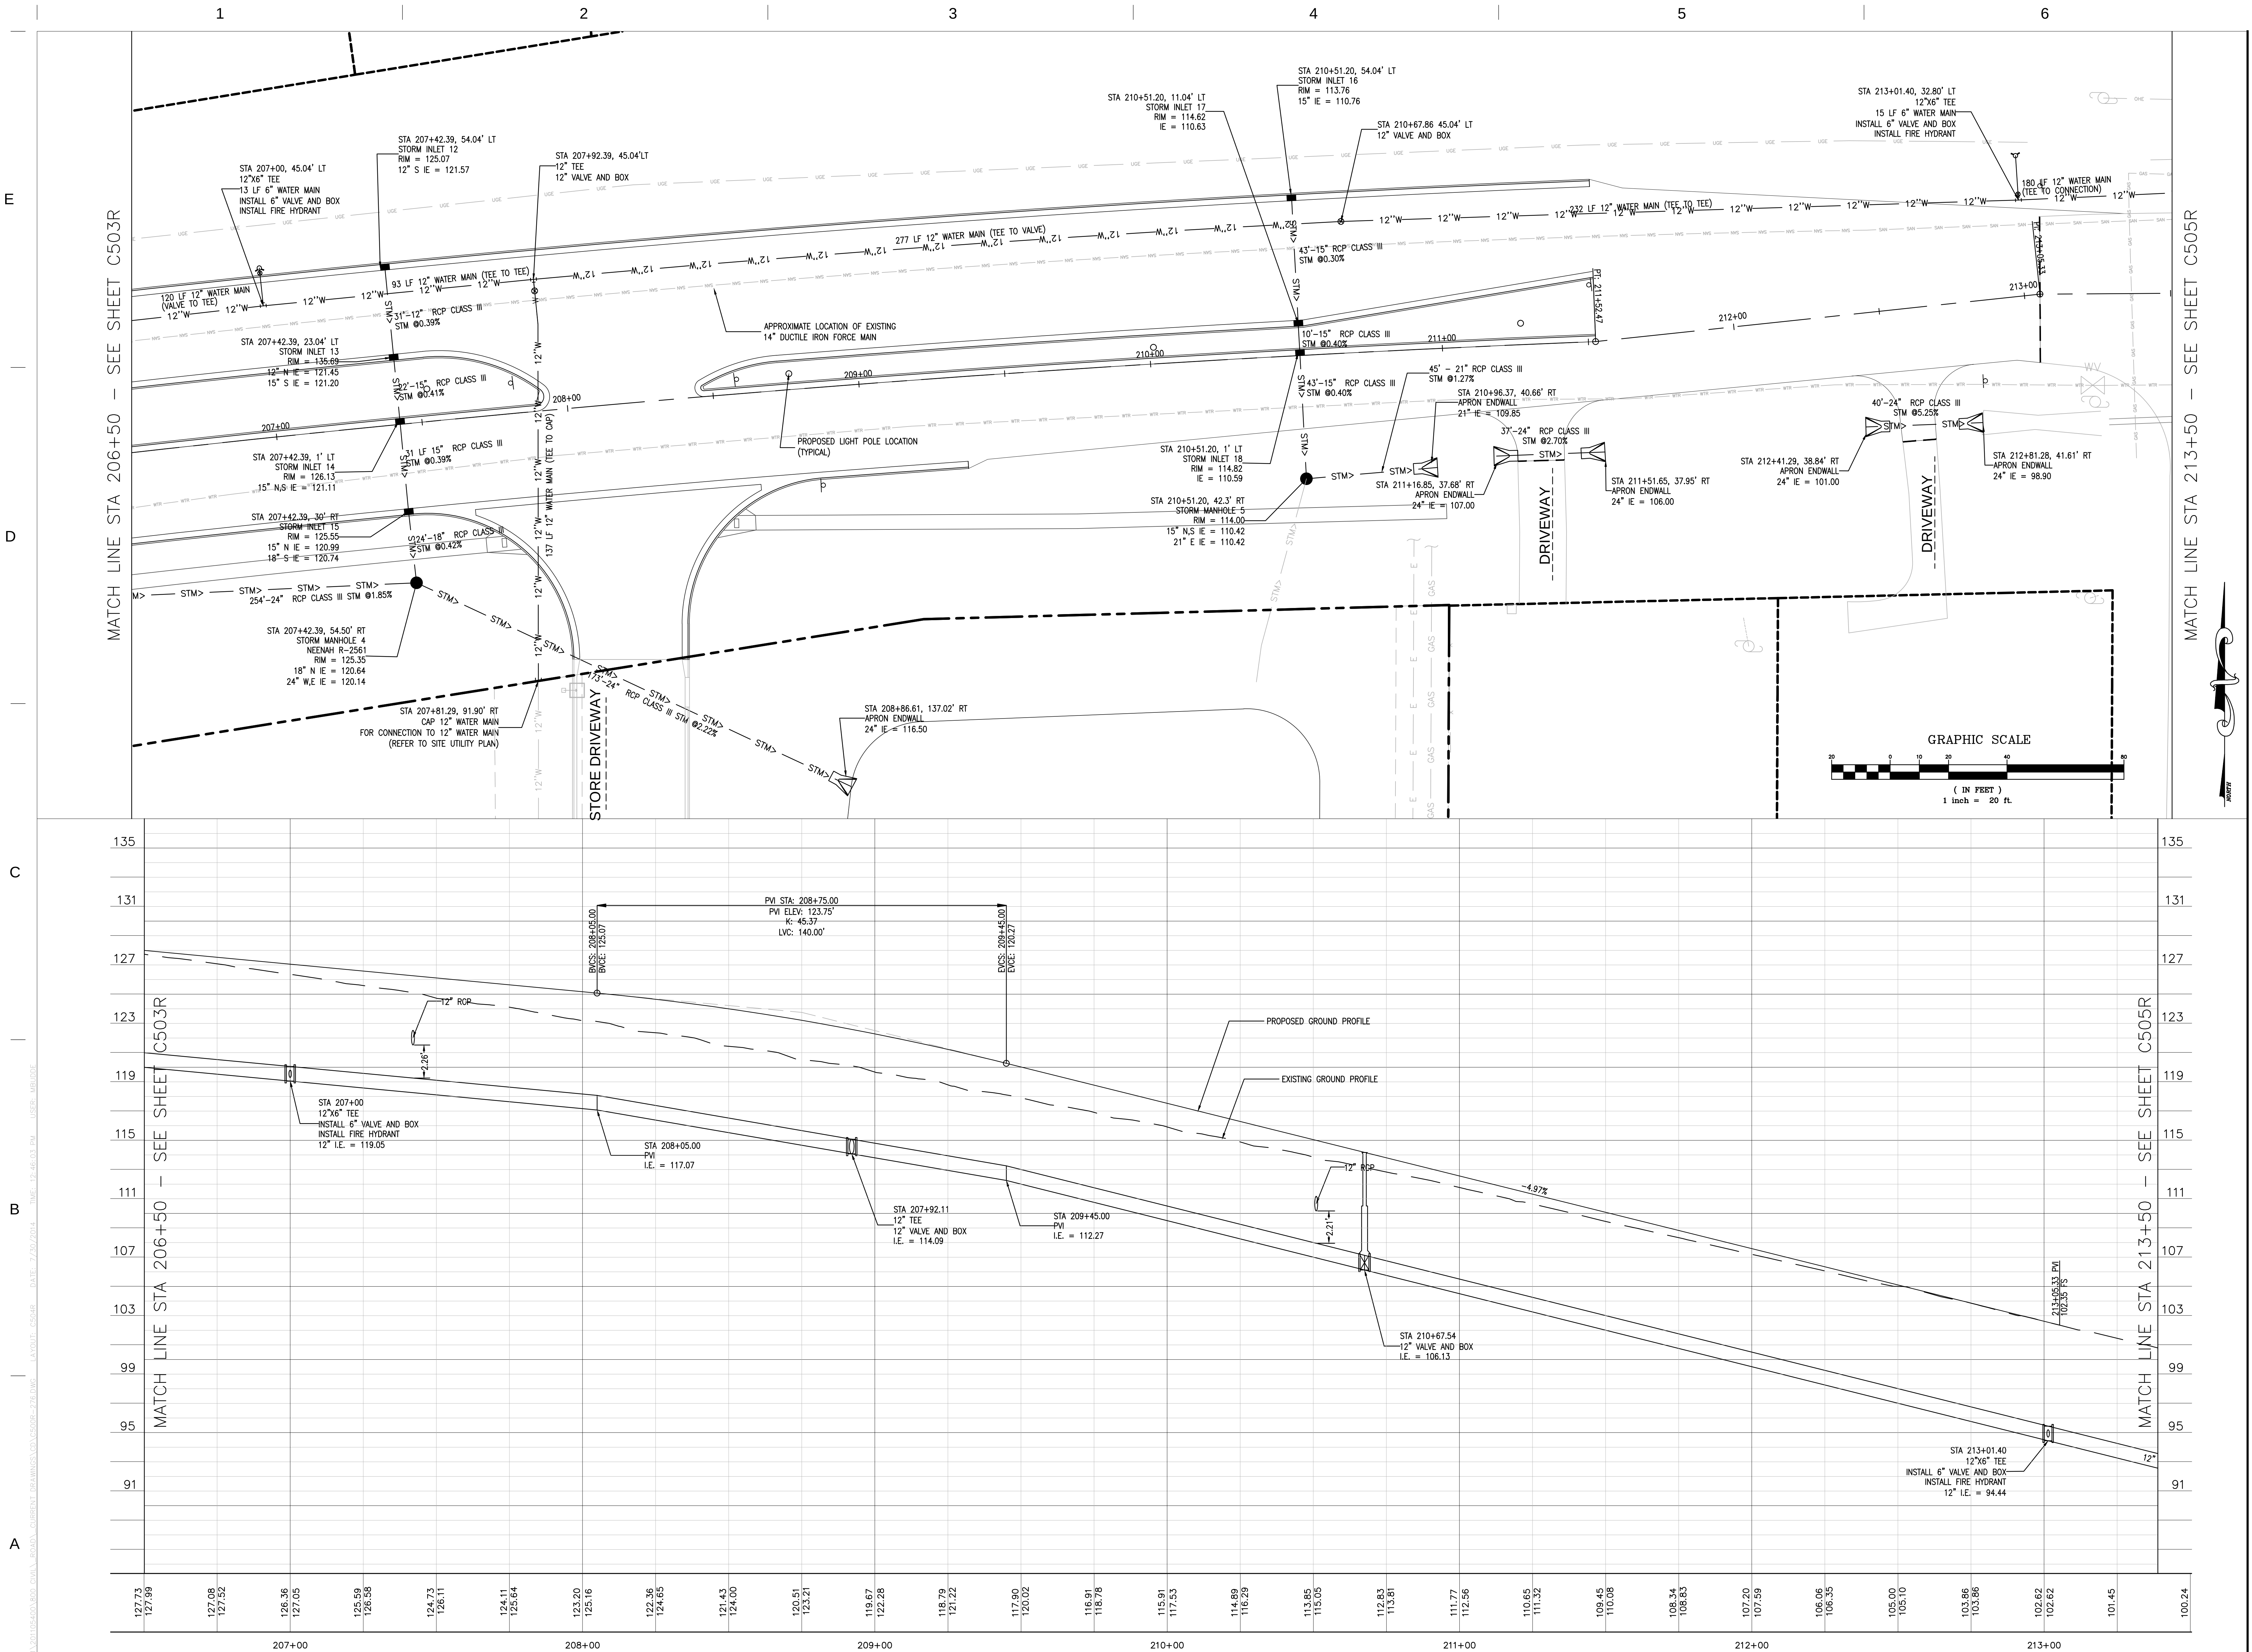

A1

PLAN AND PROFILE - SUNSET DRIVE

SCALE: 1"=20' H
SCALE: 1"=4' V