



PRELIMINARY
NOT FOR CONSTRUCTION

This document is partially complete. The information contained is not necessarily coordinated or correct. This drawing is for review purposes only.


16017R22003
TEMPLATE VERSION:
RELEASE 1.0
JULY 2015

REVISION:	Mark	Date	By

PROJECT TITLE
CD TEMPLATE
"K38 SERIES 6000
TO AMERICAN
SHOWMAN"

331 W. SUNSET DR.
WAUKESHA, WI 53189
STORE NO. **K071212**
ISSUE DATE **06/07/2022**
SHEET TITLE

SITE LIGHTING PLAN
SHEET NO. **SL101**

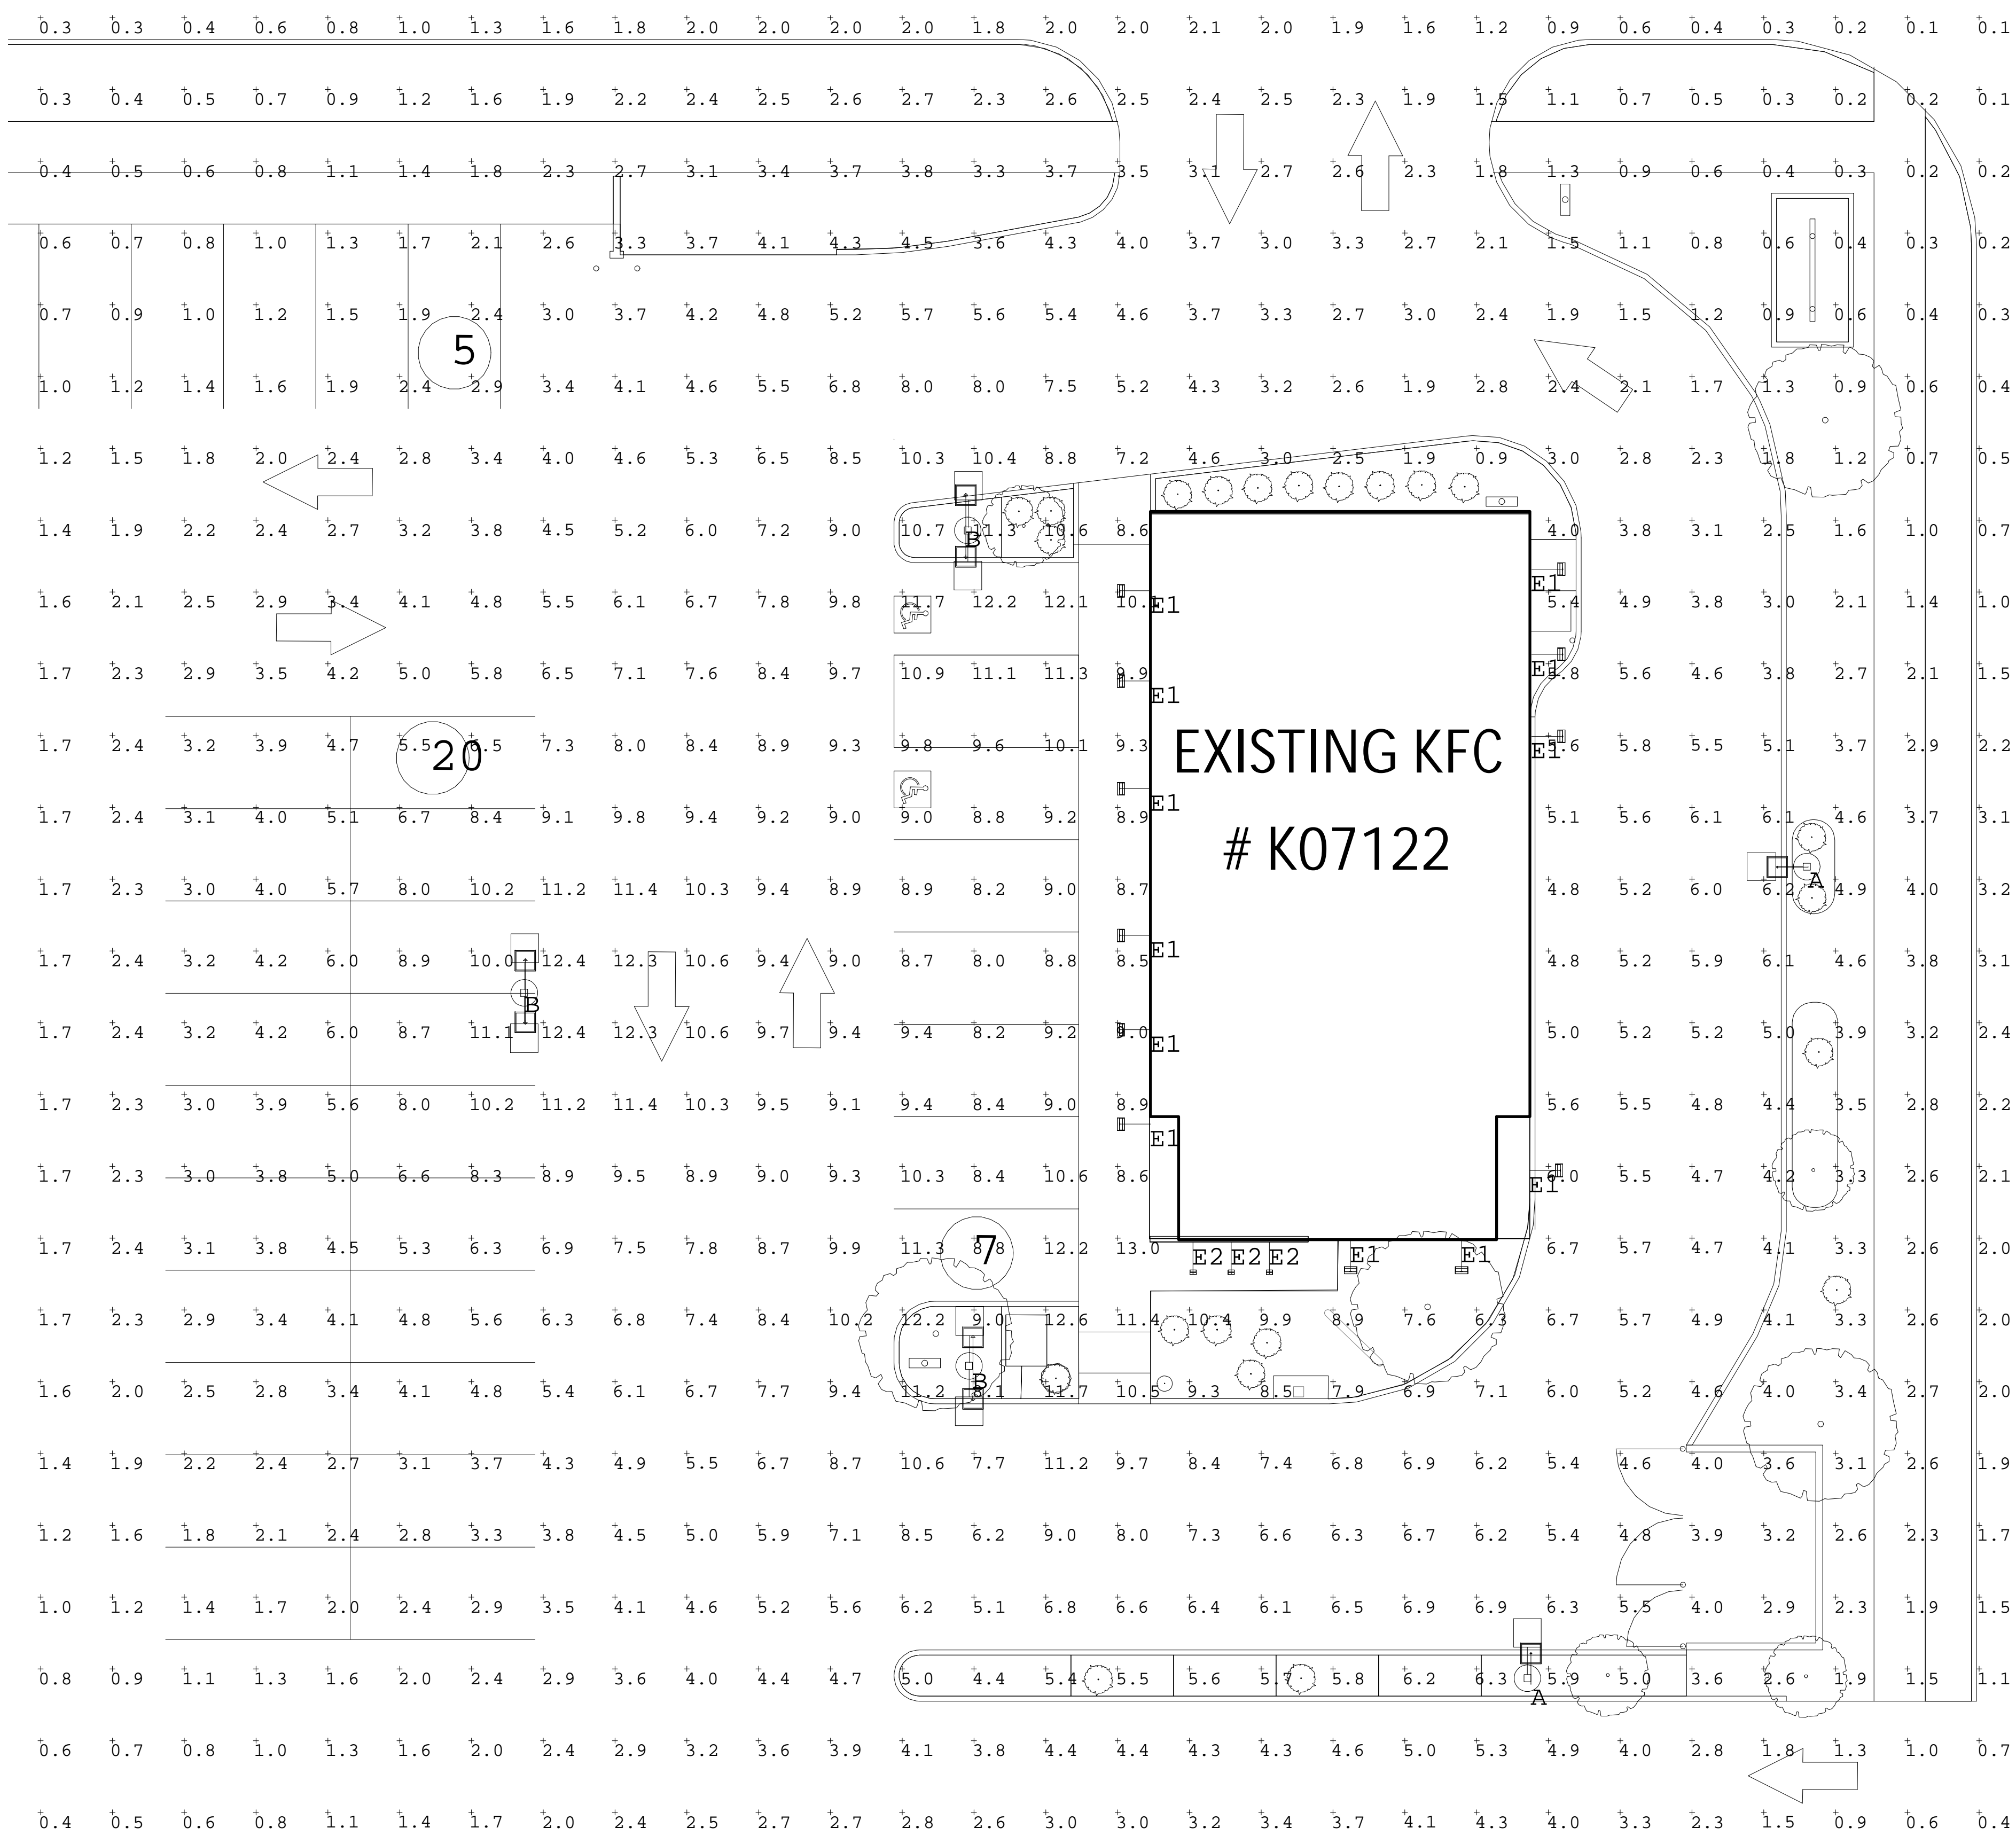


EXISTING KFC
K07122

PREPARED BY: PAUL MILLER
CAPITOL LIGHT
www.capitolight.com
814-312-7505
paul.miller@capitolight.com
12 JULY 2022

Luminaire Schedule			
Symbol	Qty	Label	Description
	2	A	EXISTING SITE LIGHT
	3	B	SLM-LED-24L-SIL-FT-40-70CRI MOUNTED AT 25'
	12	E1	RFL2-44L-25-3K7-M
	3	E2	RFL2-44L-25-3K7-W

1 SITE LIGHTING
1" = 10'-0"

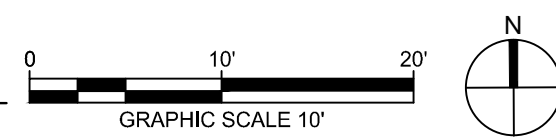

THIS DOCUMENT IS THE PROPERTY OF KFC. NEITHER THE DOCUMENT NOR THE INFORMATION IT CONTAINS MAY BE COPIED OR USED FOR OTHER THAN THE SPECIFIC PROJECT FOR WHICH IT WAS PREPARED WITHOUT THE EXPRESS CONSENT OF KFC. PLOT FILE: lumina_07_12_2022_10:06:19.dwg