




4 - DRIVE-THRU ELEVATION
Scale: 1/4" = 1'-0"

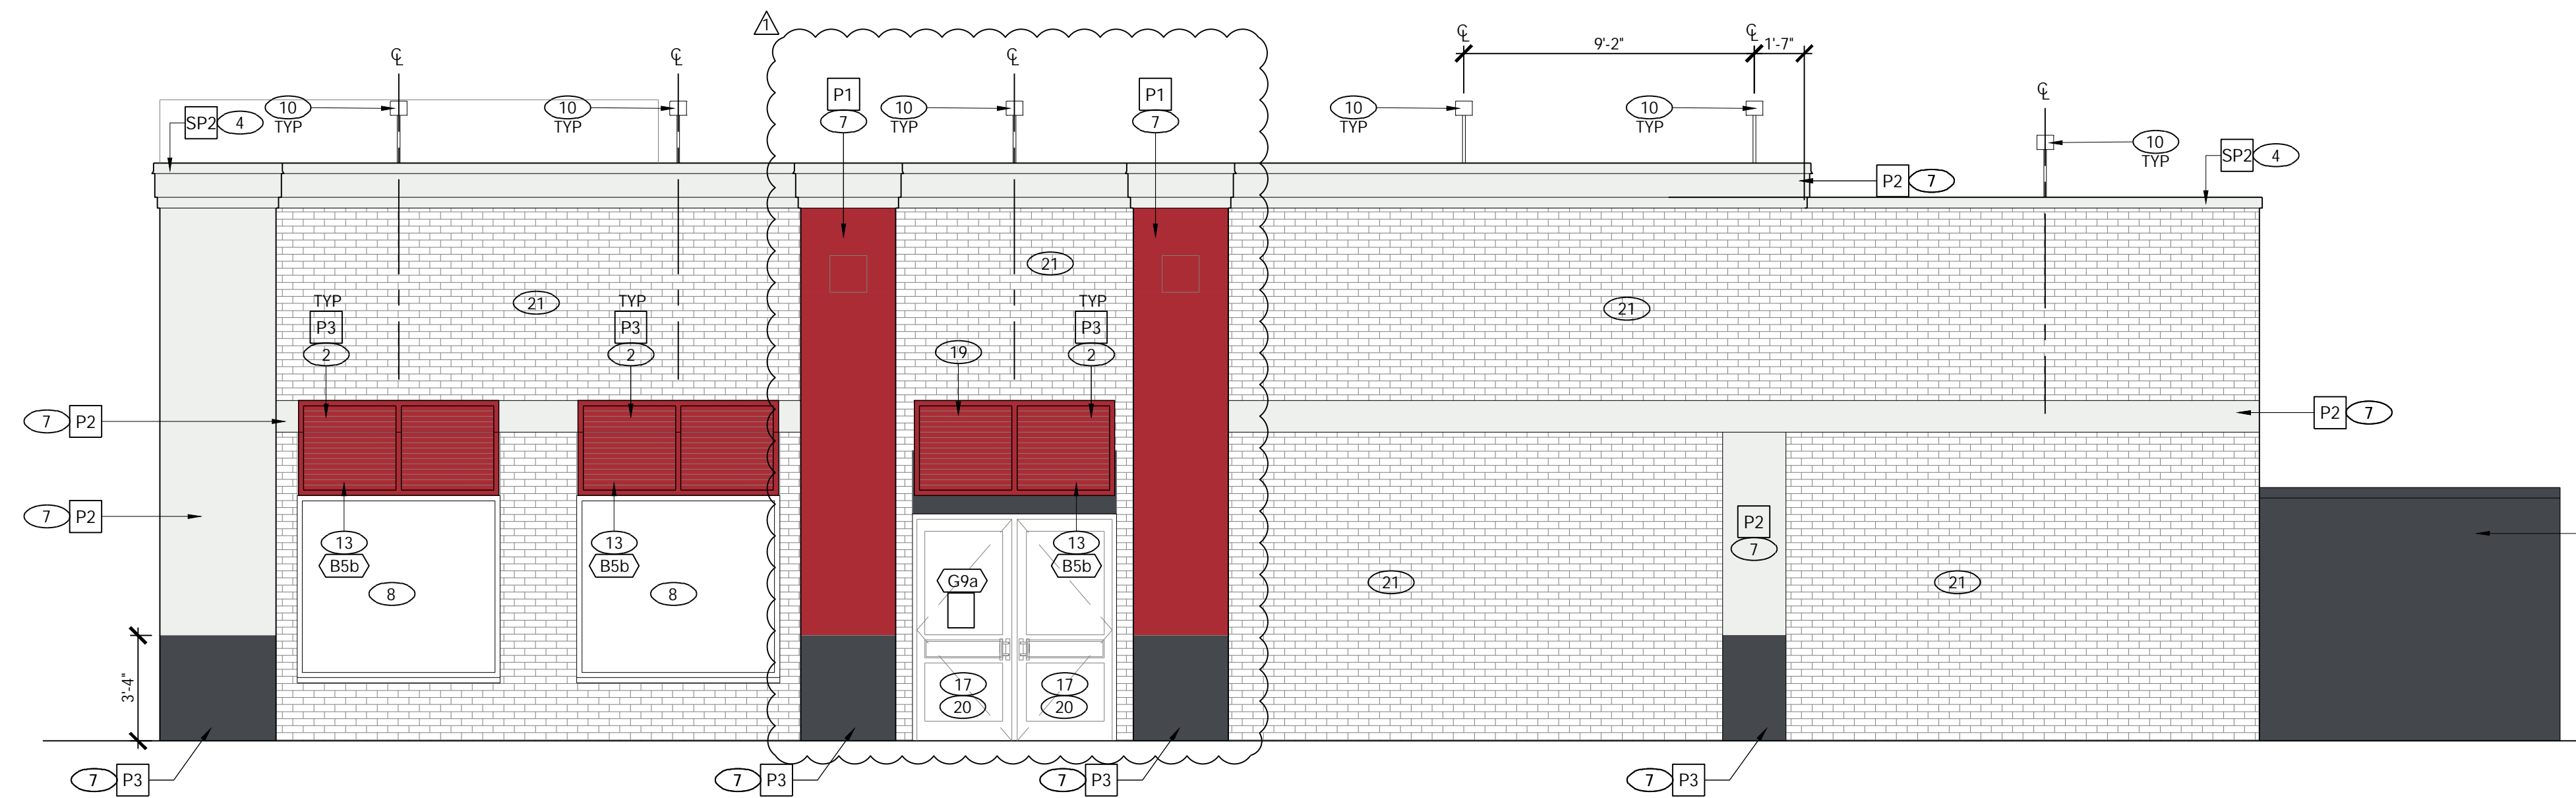

3 - ENTRY ELEVATION
Scale: 1/4" = 1'-0"

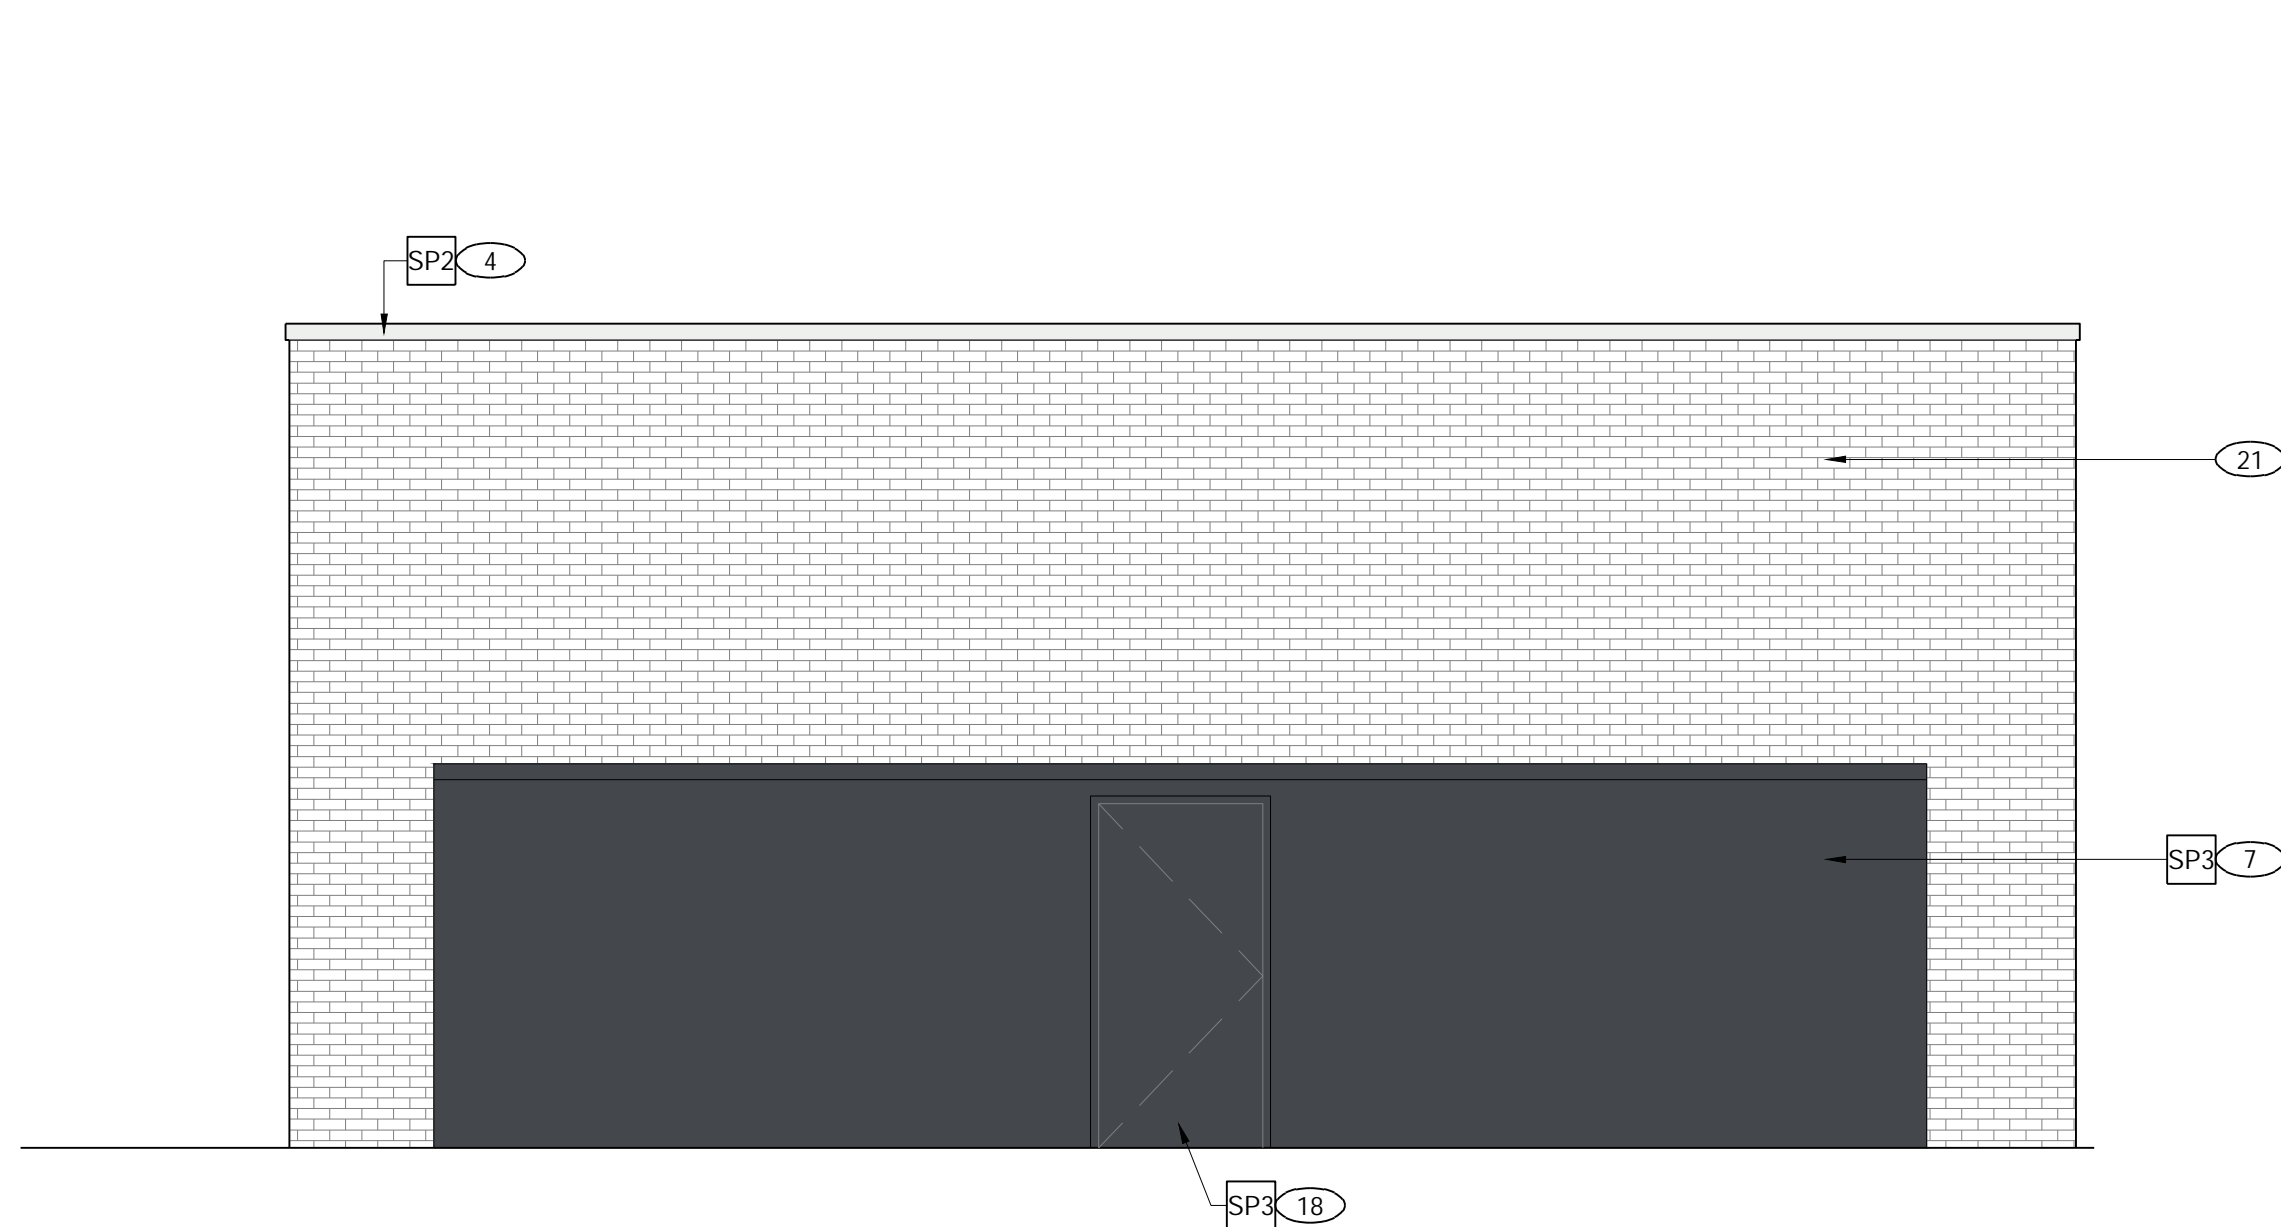

2 - REAR ELEVATION
Scale: 1/4" = 1'-0"

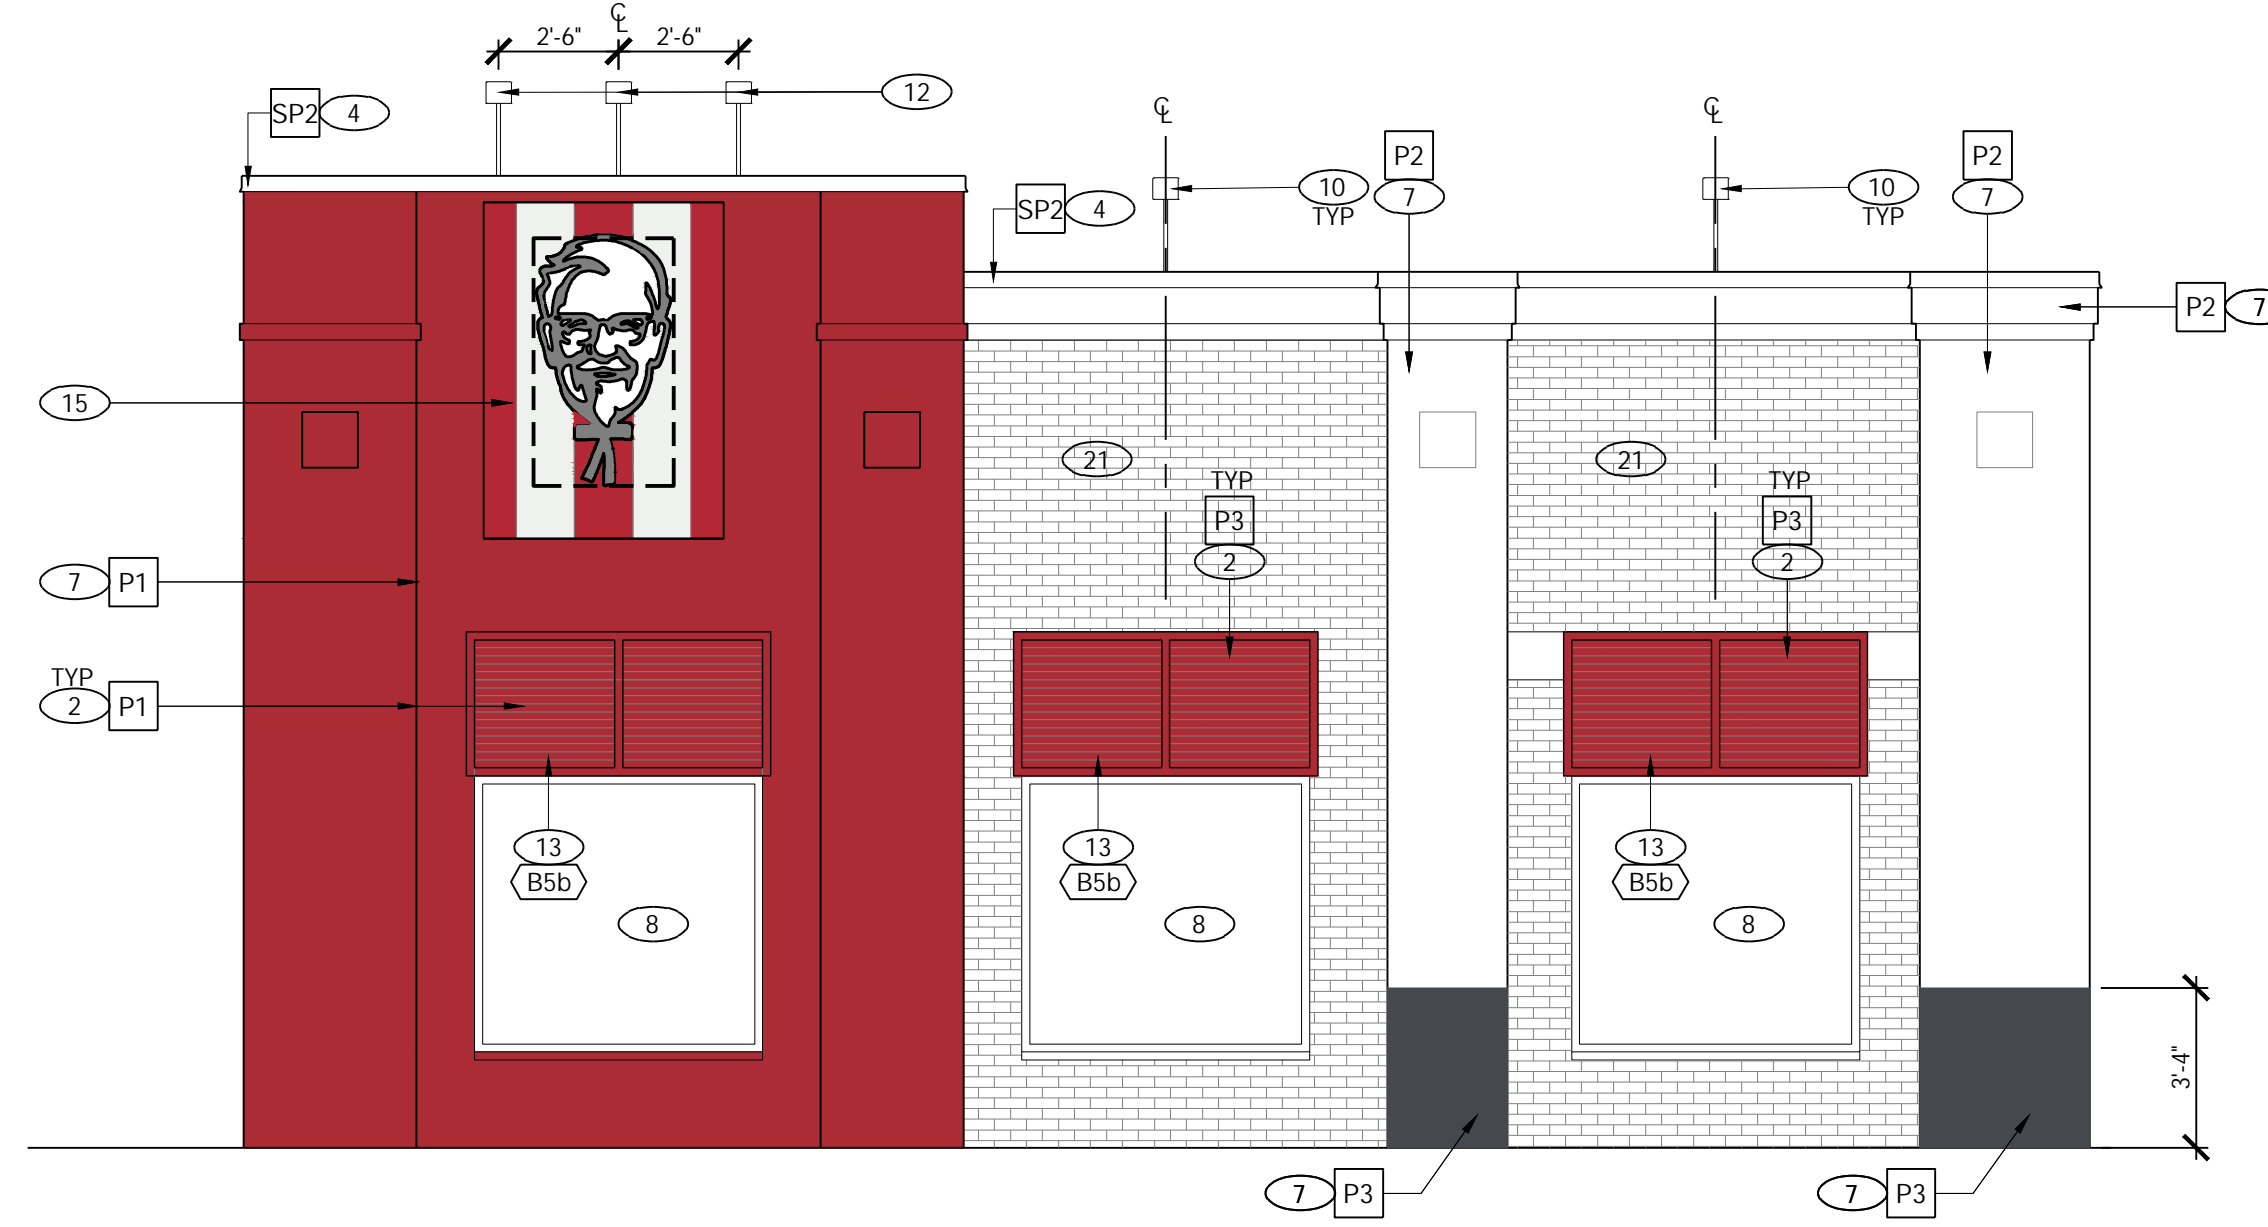

1 - FRONT ELEVATION
Scale: 1/4" = 1'-0"

GENERAL NOTES

G.C. TO PROVIDE VERIFICATION OF EXISTING STRUCTURAL ATTACHMENTS FOR NEW BUILDING ELEMENTS. IF REQUIRED PROVIDE ADDITIONAL BLOCKING PER VENDOR'S RECOMMENDATION

EXTERIOR ELEVATION NOTES

SEE MASTER SCHEDULE (SCHD-1) FOR ALL LIGHTING, FINISH, AND COMPONENT TAGS

- 1 NEW SIGNAGE
- 2 PAINT WALL SURFACE BEHIND NEW AWNINGS
- 3 PAINT 4" WIDE BORDER WINDOW SURROUND AS INDICATED
- 4 EXISTING PARAPET COPING TO BE REPAIRED, SEALED AND PAINTED
- 5 NOT USED.
- 6 NOT USED.
- 7 NEW EXTERIOR PAINT TREATMENT
- 8 EXISTING WINDOWS
- 9 NOT USED
- 10 NEW EXTERIOR LIGHT FIXTURE CENTERED ON WINDOW AND/OR GRAPHIC, OTHERWISE AS INDICATED IN ELEVATION. PATCH AND REPAIR ROOF MEMBRANE AT FIXTURE ATTACHMENT POINT
- 11 NOT USED
- 12 NEW ACCENT LIGHT FIXTURE, REFER TO LIGHT FIXTURE SCHEDULE
- 13 NEW PRE-FINISHED METAL LOUVERED AWNINGS (AWNINGS ABOVE DOORS TO HAVE RAIN DIVERTERS)
- 14 NEW DRIVE-THRU CANOPY
- 15 EXISTING SIGN CABINET REFACED WITH NEW KFC 2020 SIGN PANEL.
- 16 NOT USED.
- 17 NEW ALUMINUM INFILL IN DOOR PANEL. INFILL TO MATCH FRAME.
- 18 PAINT EXISTING EXTERIOR DOOR AND FRAME
- 19 NEW EXTERIOR WALL LIGHT, M-3
- 20 EXISTING STOREFRONT
- 21 EXISTING BRICK SHALL NOT BE PAINTED.

SIGNAGE AREA CALCULATIONS

FRONT ELEVATION
TOTAL SIGN SF = 35 SF PROVIDED / 57.75 SF ALLOWABLE

DRIVE THRU ELEVATION
TOTAL SIGN SF = 21 SF PROVIDED / 99.9 SF ALLOWABLE



16017R22003
TEMPLATE VERSION:
RELEASE 1.0
JULY 2015

REVISION:	Mark	Date	By
		06.23.2022	MEM

BRAND COMMENTS

PROJECT TITLE
CD TEMPLATE
"K38 SERIES 6000
TO AMERICAN
SHOWMAN"

INCENTIVE SCOPE
331 W. SUNSET DR.
WAUKESHA, WI 53189

STORE NO. K071212
ISSUE DATE 06/07/2022

SHEET TITLE
EXTERIOR
ELEVATIONS

SHEET NO.
A-2.0

THIS DOCUMENT IS THE PROPERTY OF KFC. NEITHER THE DOCUMENT NOR THE INFORMATION IT CONTAINS MAY BE COPIED OR USED FOR OTHER THAN THE SPECIFIC PROJECT FOR WHICH IT WAS PREPARED WITHOUT THE EXPRESS CONSENT OF KFC. PLOT FILE: Monday, June 20, 2022 10:41:17 AM