

E

D

C

B


A

Plot: 1000 - P:\2011\2011050405\800\DWG\A - PHOTOMETRIC PLAN - TENNY AVENUE - 276.DWG DATE: 7/25/2014 TIME: 12:36:16 PM USER: SPOLAD

A1
SCALE: 1"=20' H


PHOTOMETRIC PLAN - TENNY AVENUE

MATCH LINE STA 31+50 — SEE SHEET C200R

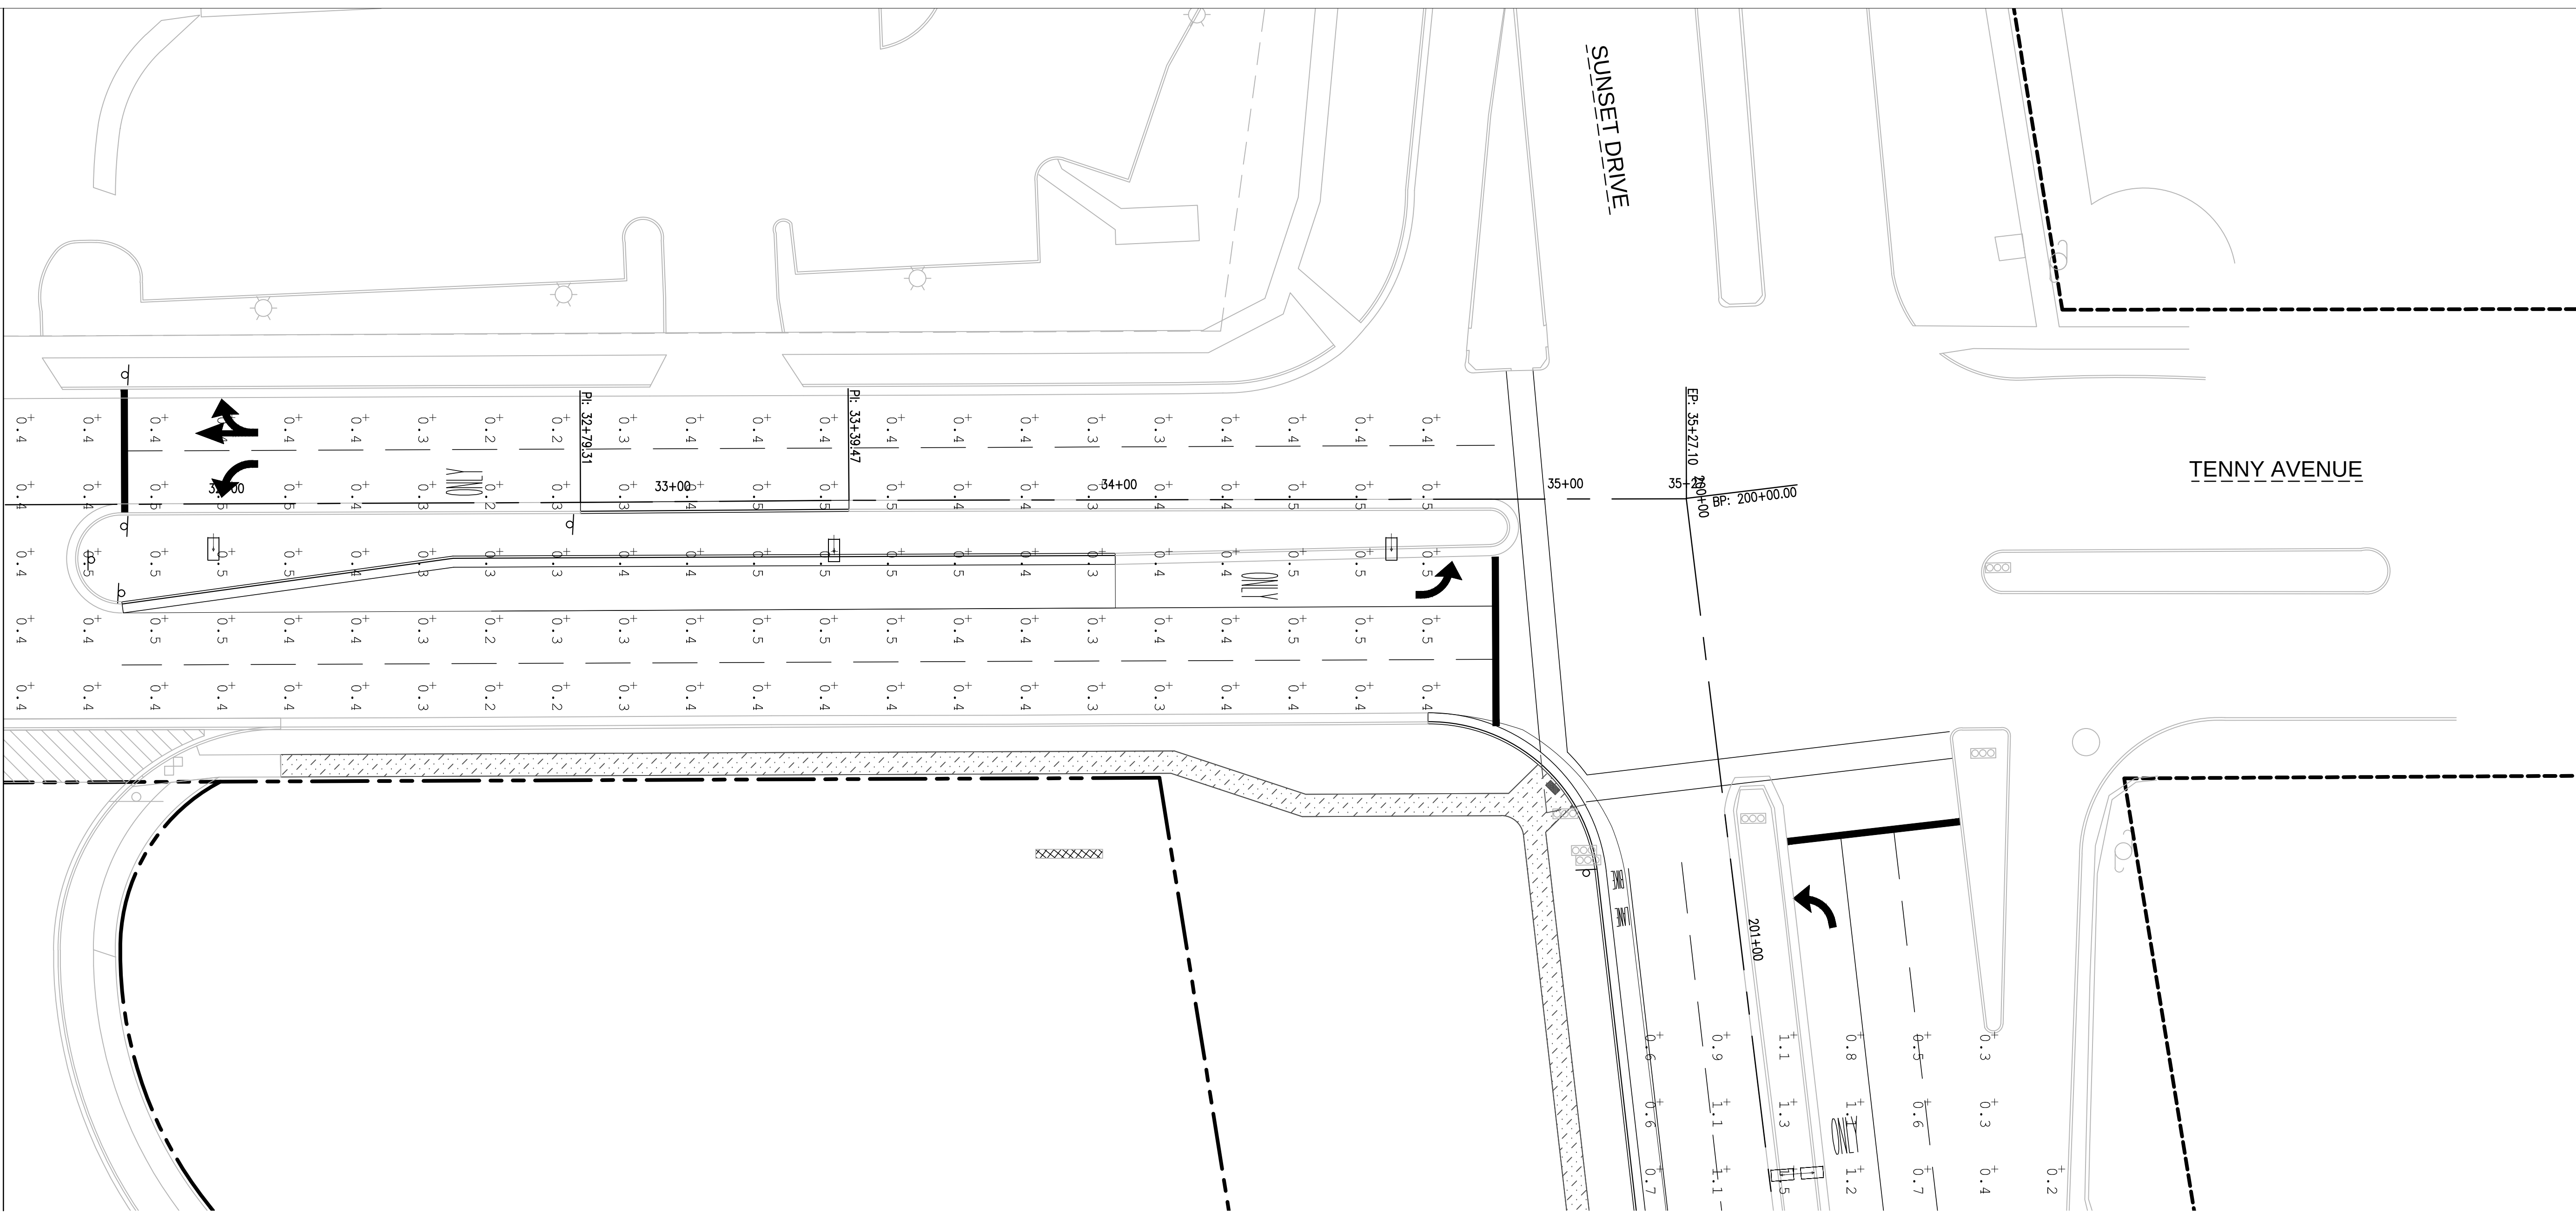

Luminaire Schedule						
Symbol	Qty	Label	Arrangement	Total Lamp Lumens	LLF	Description
	3	SL	SINGLE	N.A.	0.900	LDRC-T3-B03-E
	1	2EX-SL	BACK-BACK	N.A.	0.900	LDRC-T3-B03-E
	16	LDRC-5MQ-B03-E	SINGLE	N.A.	0.900	LDRC-5MQ-B03-E

Calculation Summary									
Label	CalcType	Units	Avg	Max	Min	Avg/Min	Max/Min		
Sunset Drive (Residential)	Illuminance	Fc	0.44	1.5	0.2	2.20	7.50		
Tennay (Residential N)	Illuminance	Fc	0.39	0.5	0.2	1.95	2.50		
Tennay (Residential S)	Illuminance	Fc	0.44	0.7	0.2	2.20	3.50		

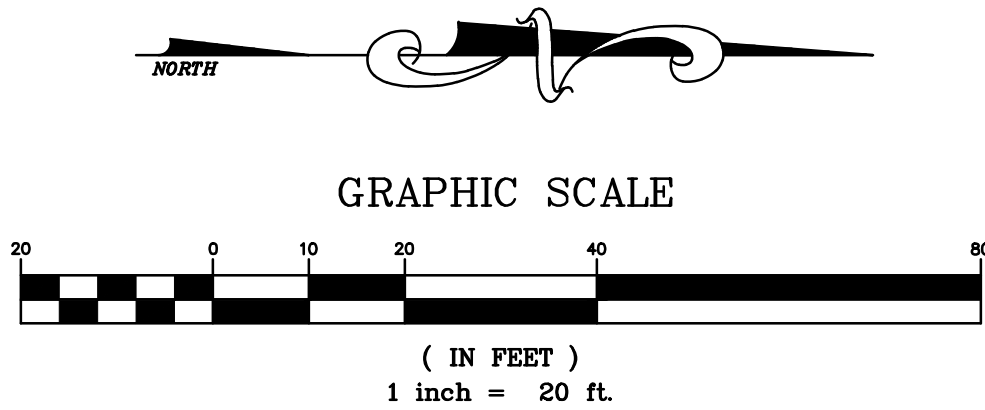

Store: 276
801 EAST SUNSET DRIVE
(SEQ) TENNY AVE & SUNSET DR
WAUKESHA, WISCONSIN

meijer

PROFESSIONAL IN CHARGE
MATTHEW H. BUODE, P.E.
PROFESSIONAL ENGINEER
LICENSE NO. E-37992

07/30/14 FINAL PLAN - RESUBMITTAL
09/25/13 CITY SUBMITTAL

Drawn By M. BUODE, P.E.
Reviewer P. PHILLIPS, P.E.
Manager K. WILLIAMS, P.E.
Prof in Charge M. BUODE, P.E.

Hard copy is intended to be 30"x42" when plotted. Scale(s) indicated and graphic quality may not be accurate for any other size.

PROJECT NO.
J120944276
SHEET NO.

C801R