


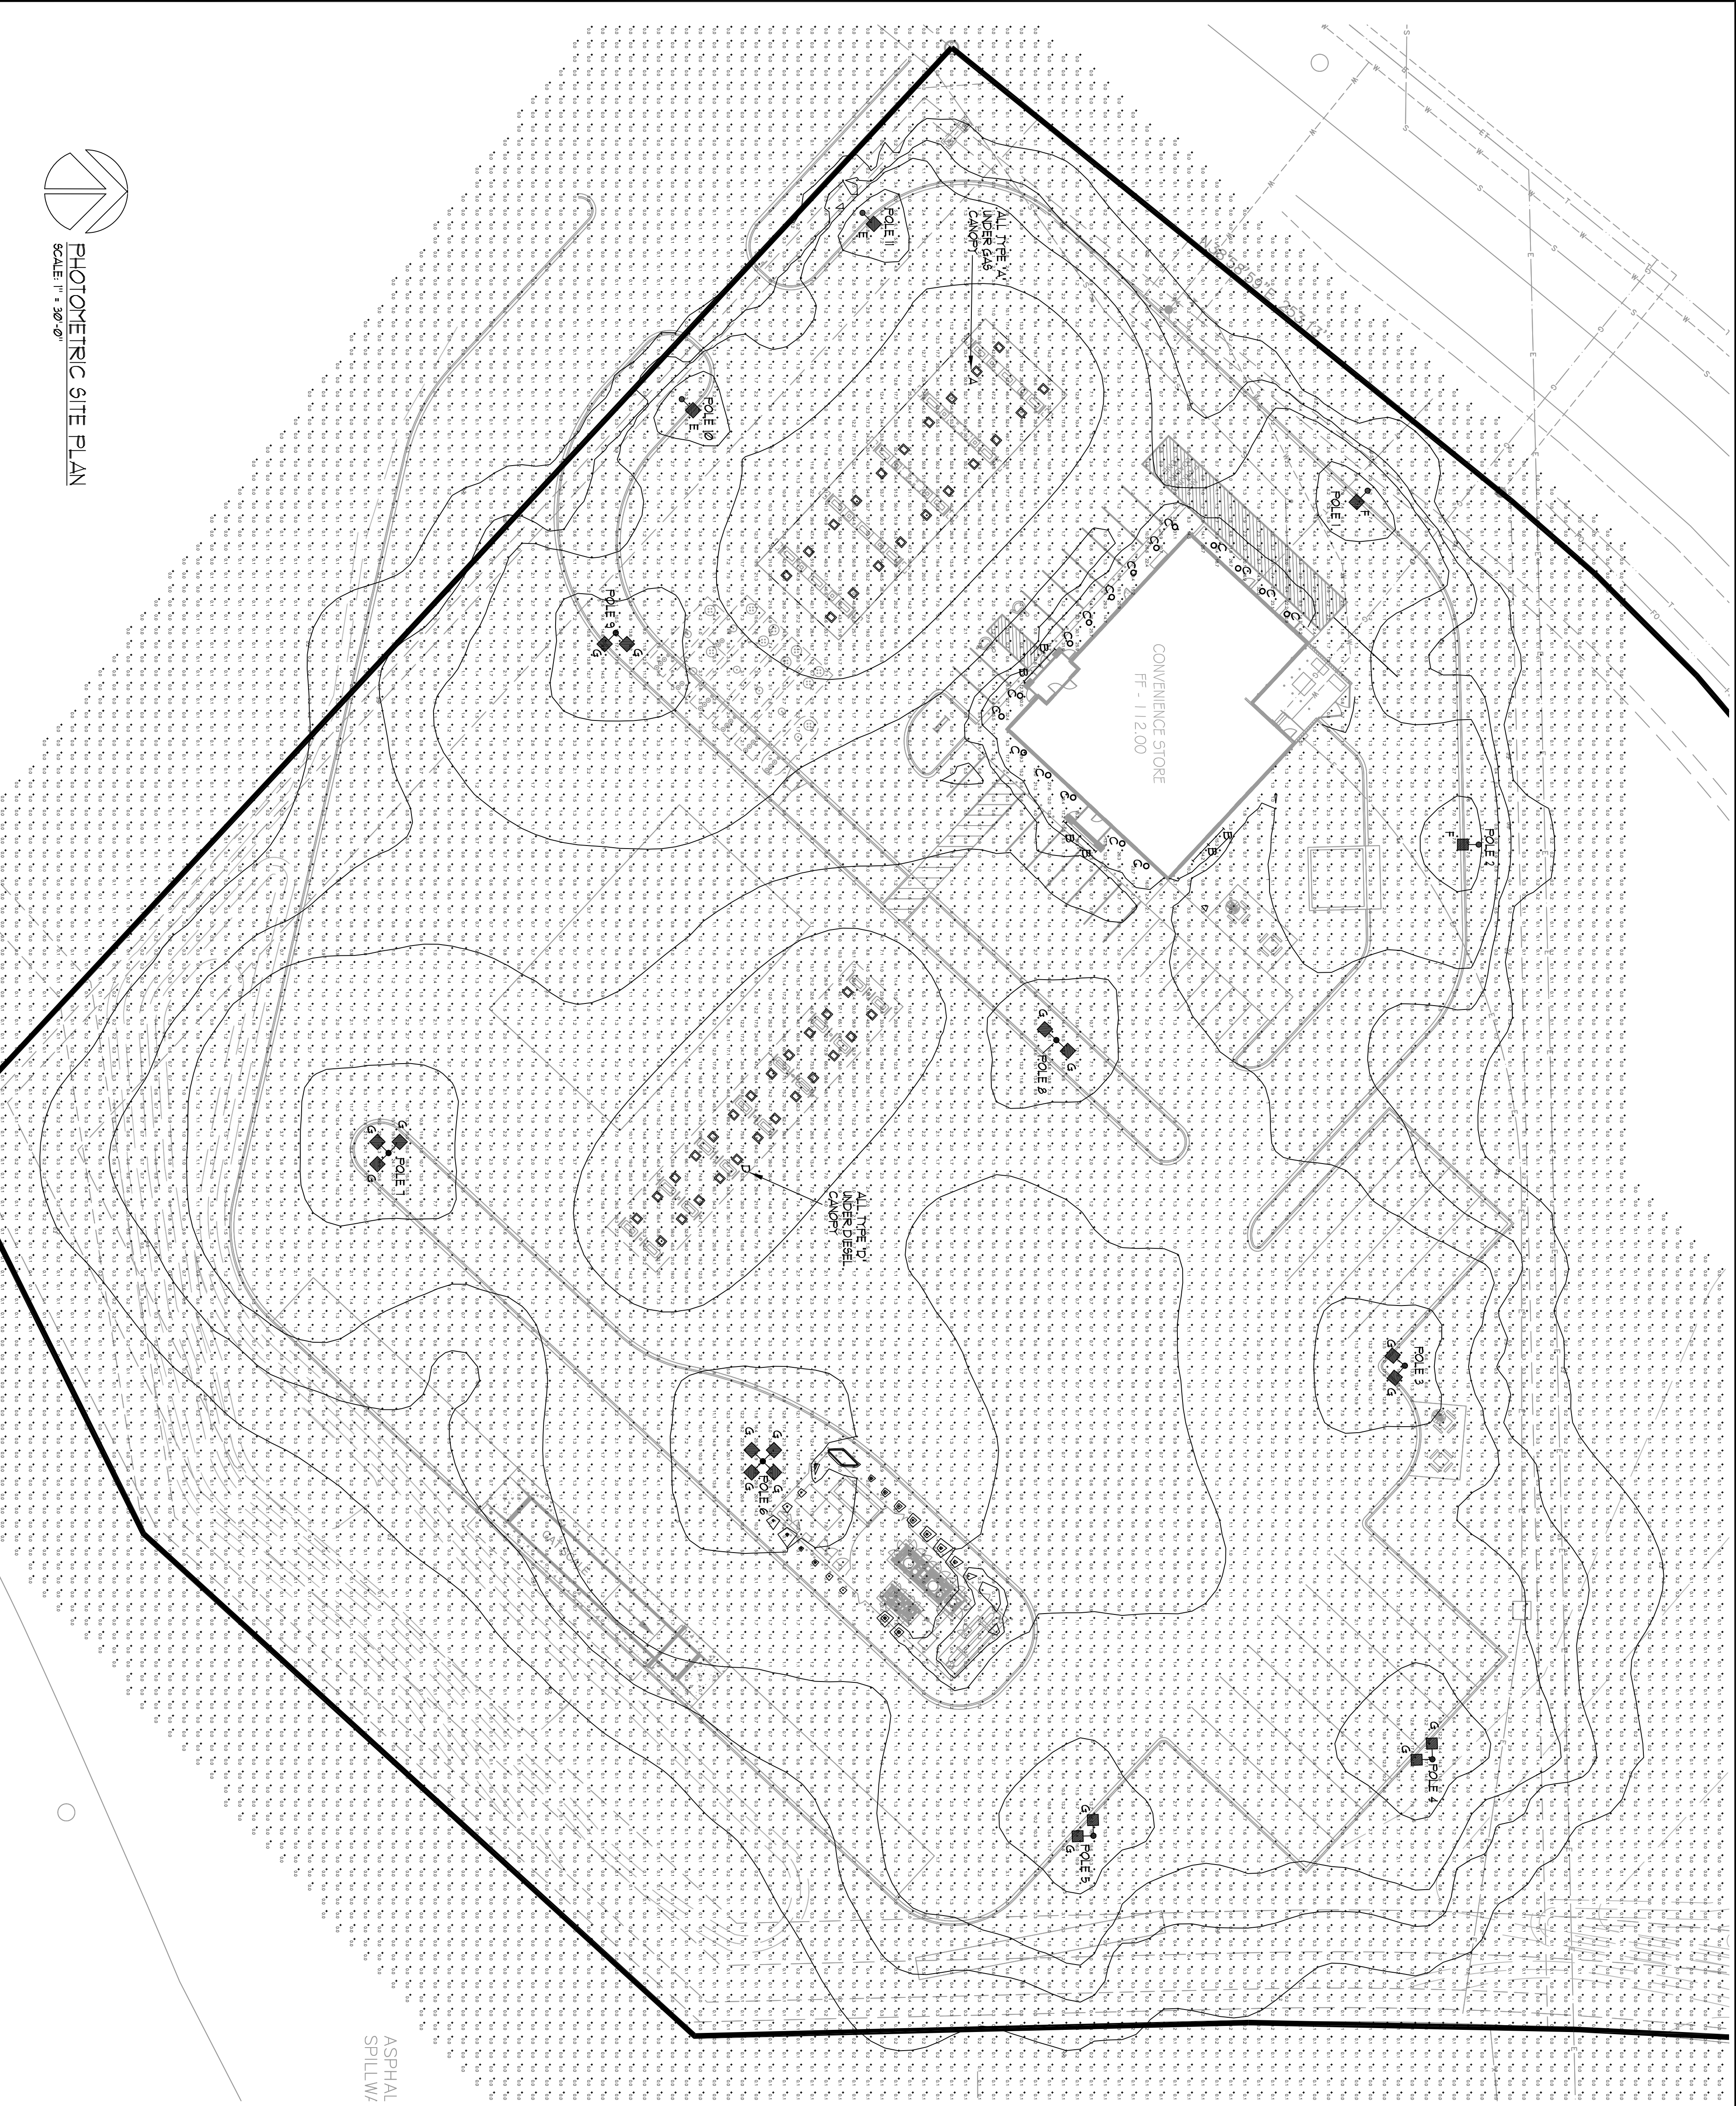

PHOTOMETRIC SITE PLAN
SCALE: 1" = 30'-0"

FIXTURE QUANTITIES

A	- 20
B	- 6
C	- 11
D	- 24
E	- 7
F	- 1
G	- 11

PROVIDE (9) 21' POLES FOR POLES 1 THRU 11
PROVIDE (7) 9' POLES FOR POLES 8 THRU 11

CALCULATION STATISTICS


AVERAGE: 211c
MAXIMUM: 1631c
MINIMUM: 0071c

FIXTURE SYMBOLS:

- A 1 D REC. LED LIGHT W/IND UNDER CANOPY
- B LED STRIP LIGHT
- C O RECESSED LED DOWNLIGHT
- E F 1 G POLE MOUNTED LED FIXTURE

FIXTURE TYPES:

- A - L81 LIGHTING, CBI-SC-LED-40-CU-IE-LI-UNT UNDER GAS CANOPY, LED FIXTURE - WHITE MOUNTING HEIGHT - 16'-0"
- B - LED STRIP LIGHT LITHONIA - 211L159-ALB40 MOUNTING HEIGHT - SEE ARCH. ELEVATIONS
- C - RECESSED LED DOWNLIGHT GOLIATH EVO 41/23-BAR-100-TSU
- D - L81 LIGHTING, CBI-SC-LED-88-CU-IE-BLK UNDER DIESEL CANOPY, LED FIXTURE - BLACK MOUNTING HEIGHT - 16'-0"
- E - L81 LIGHTING, XLC3-FI-LED-88-CU-IE-LI-UNT
- F - L81 LIGHTING, XLC1-FI-LED-88-CU-IE-LI-UNT
- G - L81 LIGHTING, XLC1-FI-LED-88-CU-IE-LI-UNT

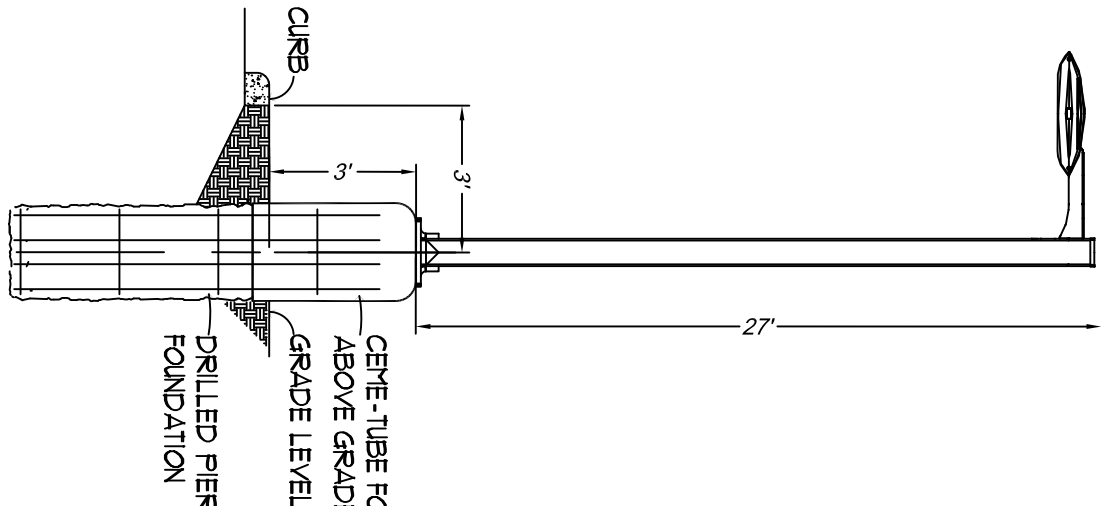

LOT LIGHT ELEVATION DETAIL
NOT TO SCALE
DETAIL APPLIES TO POLES 1 THRU 9
FOR POLES 10 AND 11, PROVIDE 9' POLE ON 3' BASE.

CZARNIECKI
ENGINEERING
INCORPORATED
7100E 16015150000 9 1400 16021515000
EBS PAGES: waukesha.com

Kwik TRIP STORES

Kwik TRIP

STORES

Kwik TRIP, Inc.
P.O. BOX 2107
1626 OAK STREET
LA CROSSE, WI 54602-2107
PH. (608) 781-6988
FAX (608) 781-6960

R.A. Smith National
Beyond Surveying
and Engineering
1616 N. Belmont Road, Brookfield, WI 53005-0000
Madison, WI 53704
Green County, WI 53005-0000

PHOTOMETRIC SITE PLAN	
CONVENIENCE STORE 184 WITH DIESEL	
CITY OF WAUKESHA, WISCONSIN	
NO.	DATE
DESCRIPTION	
DESIGNED BY	CZE
SCALE	GRAPHIC
PROJECT NO.	210010
DATE	02-11-2016
SHEET	E1