


E

D


C

B

A

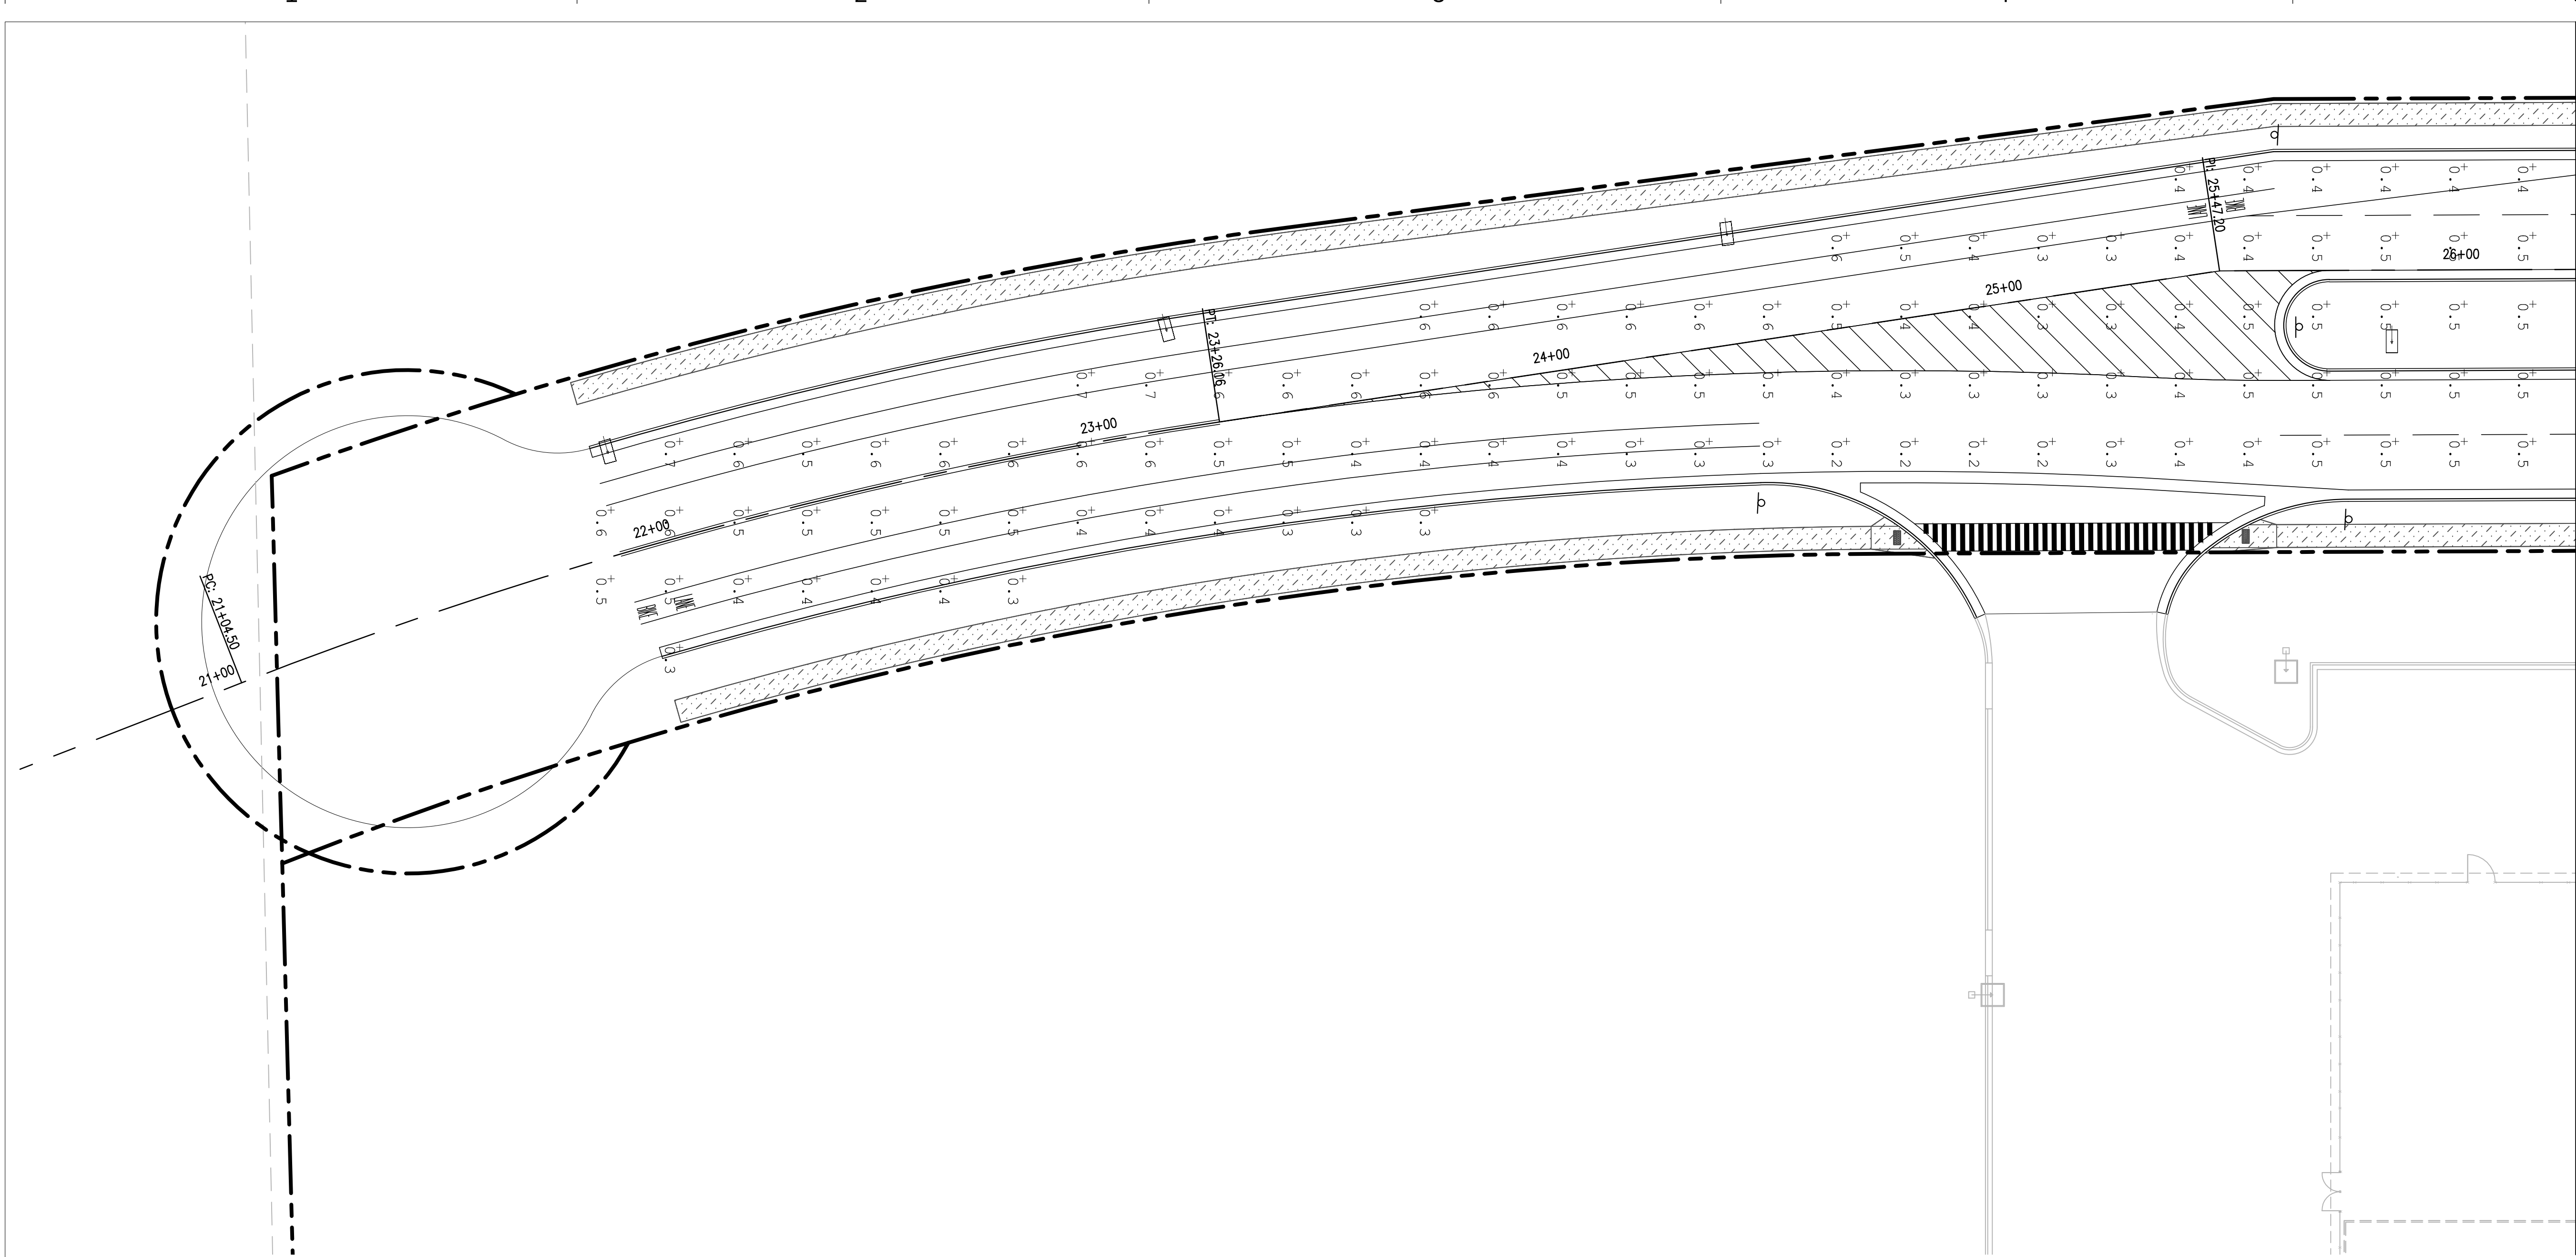


MATCH LINE STA 26+25

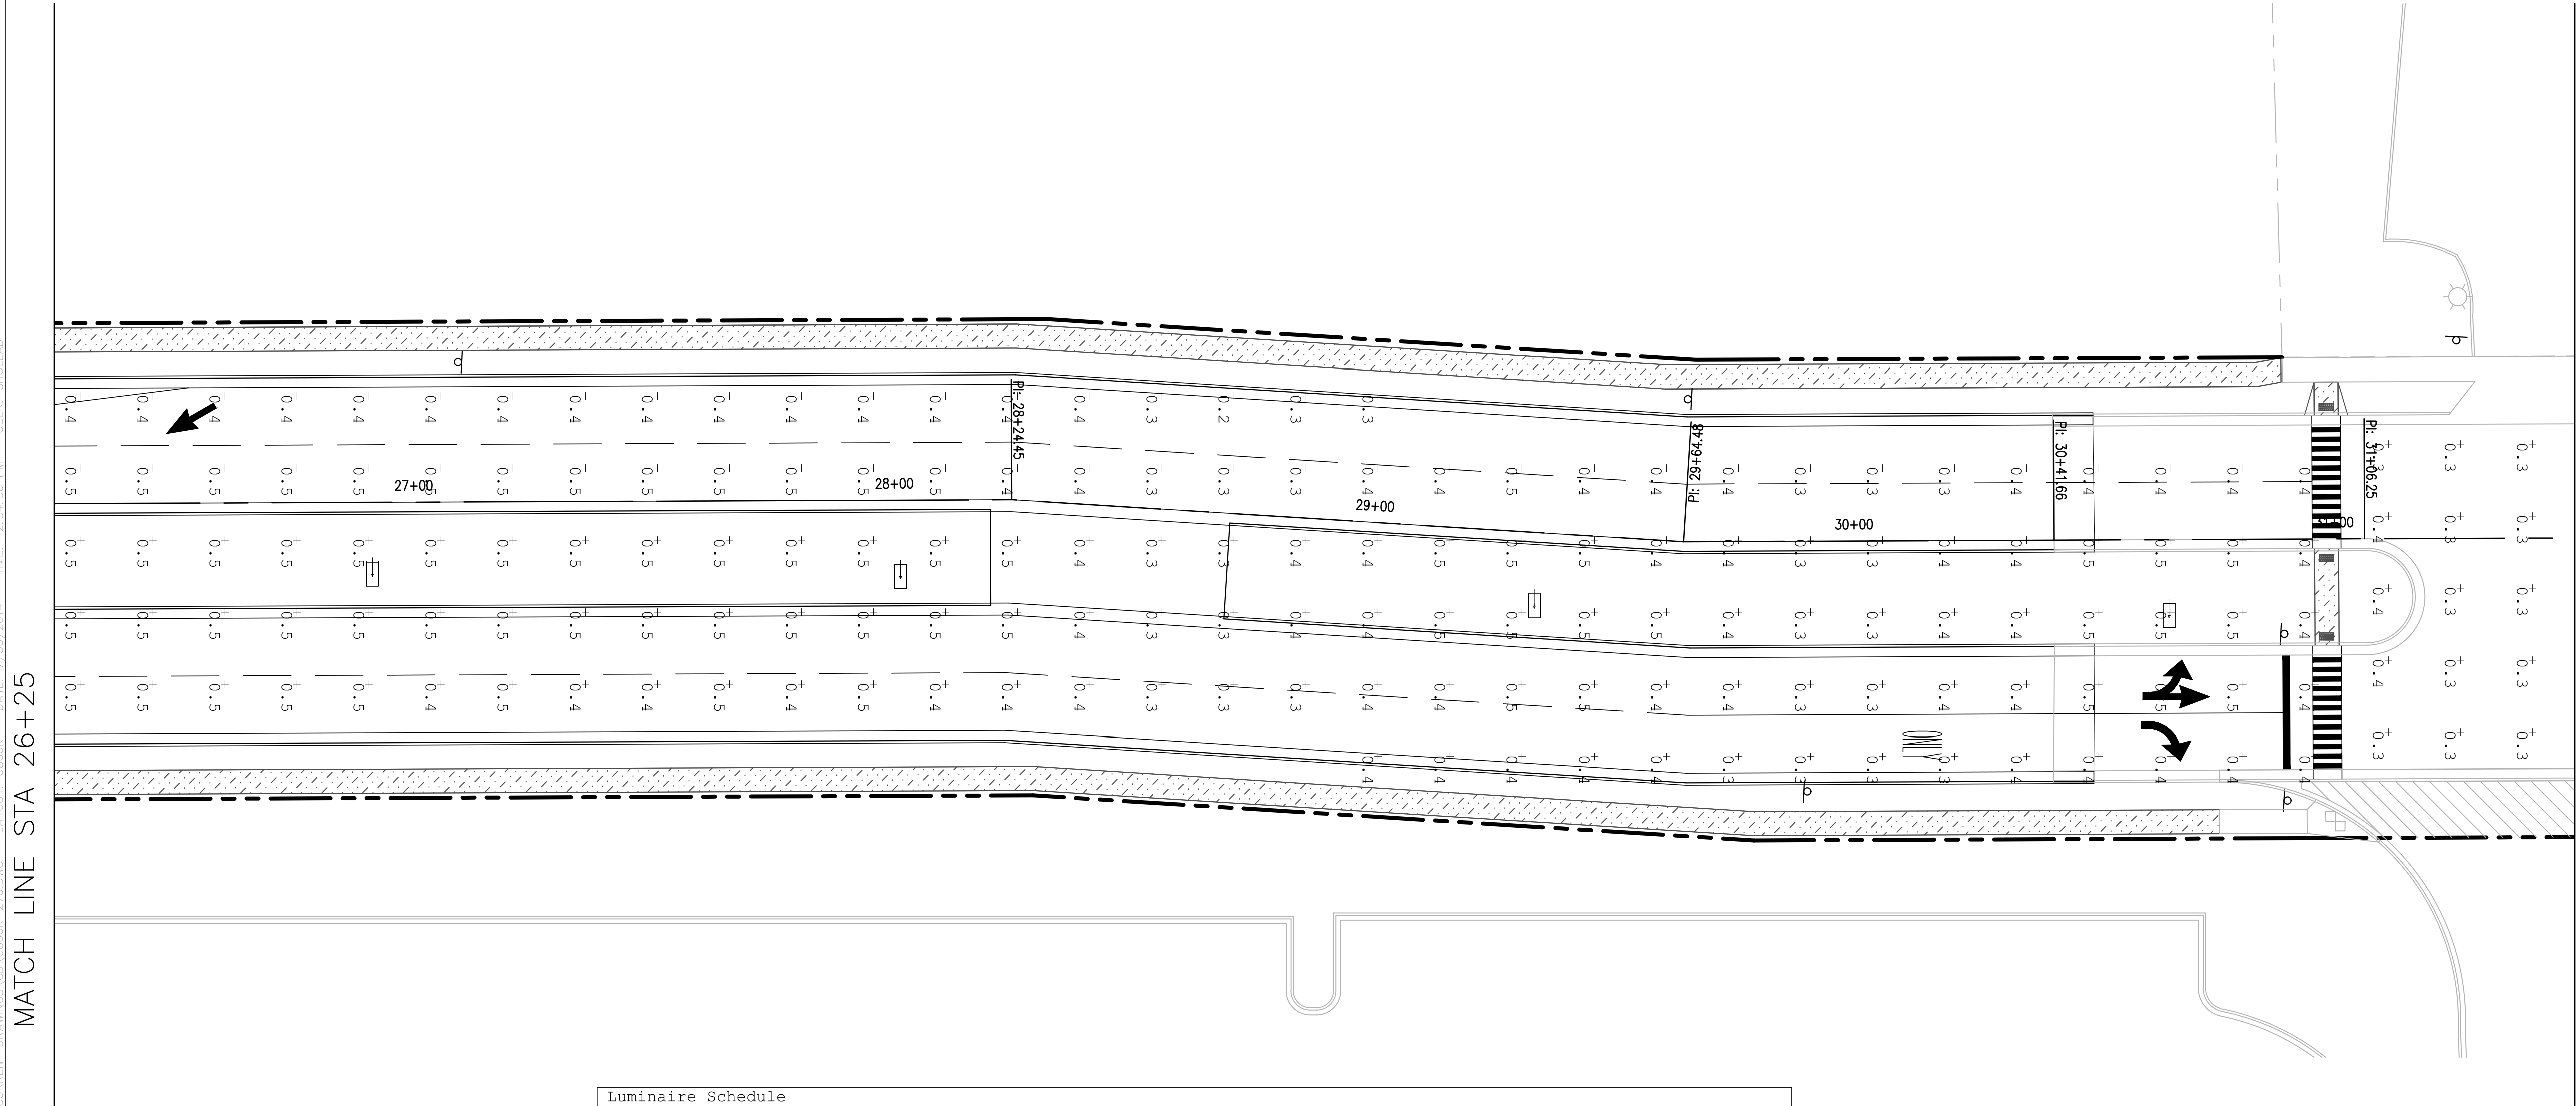

MATCH LINE STA 31+50 — SEE SHEET C201R

Luminaire Schedule							
Symbol	Qty	Label	Arrangement	Total Lamp Lumens	LLF	Description	
	3	SL	SINGLE	N.A.	0.900	LDRC-T3-B03-E	
	1	2EX-SL	BACK-BACK	N.A.	0.900	LDRC-T3-B03-E	
	16	LDRC-5MQ-B03-E	SINGLE	N.A.	0.900	LDRC-5MQ-B03-E	

Calculation Summary							
Label	CalcType			Units	Avg	Max	Min
Sunset Drive (Residential)	ILL	ILL	ILL	Fc	0.44	1.5	0.2
Tennay (Residential N)	ILL	ILL	ILL	Fc	0.39	0.5	0.2
Tennay (Residential S)	ILL	ILL	ILL	Fc	0.44	0.7	0.2

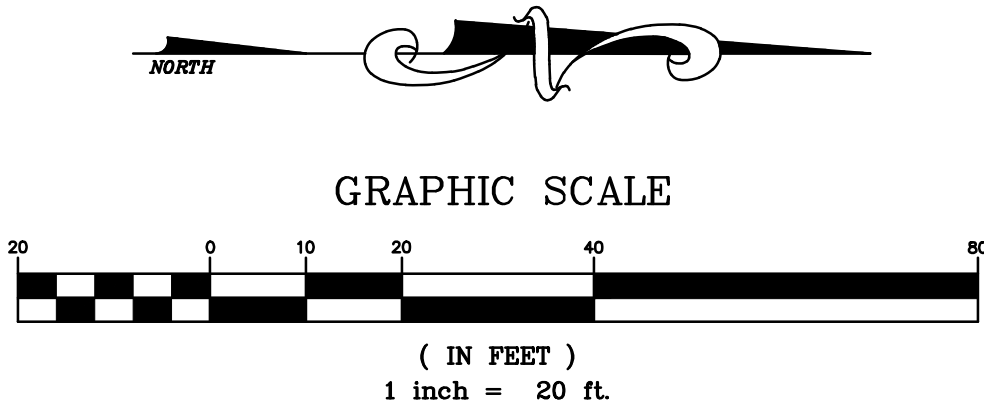

A1
SCALE: 1"=20' H

PHOTOMETRIC PLAN - TENNY AVENUE

Store: 276
801 EAST SUNSET DRIVE
(SEQ) TENNY AVE & SUNSET DR
WAUKESHA, WISCONSIN

meijer

PROFESSIONAL IN CHARGE
MATTHEW H. BUDDÉ, P.E.
PROFESSIONAL ENGINEER
LICENSE NO. E-37992

07/30/14 FINAL PLAN - RESUBMITTAL
09/25/13 CITY SUBMITTAL

Drawn By M. BUDDÉ, P.E.
Reviewer P. PHILLIPS, P.E.
Manager K. WILLIAMS, P.E.
Prof in Charge M. BUDDÉ, P.E.

Hard copy is intended to be 30"x42" when plotted. Scale(s) indicated and graphic quality may not be accurate for any other size.

PROJECT NO.
J120944276
SHEET NO.

C800R