

Keller

PLANNERS | ARCHITECTS | BUILDERS

FOX CITIES
 NE216 State Road 55
 P.O. Box 620
 Kaukauna, WI 54130
 PHONE (920) 766-5795 /
 1-800-236-2534
 FAX (920) 766-5004

MADISON
 711 Lodi Dr.
 Sun Prairie, WI 53590
 PHONE (608) 318-2336
 FAX (608) 318-2337

www.kellerbuilds.com

PROPOSED FOR:
THERMTECH
 WISCONSIN
 WAUKESHA,

"COPYRIGHT NOTICE"
 This design, drawing and detail is the copyrighted property of KELLER, INC. No part hereof shall be copied, duplicated, distributed, disclosed or made available to anyone without the expressed written consent of KELLER, INC.

PRELIMINARY - NOT FOR CONSTRUCTION

REVISIONS		
1	12.16.2021	C. TEAFOE
2		
3		
4		
5		
6		

PROJECT MANAGER:
M. QUEOFF

DESIGNER:
T. TISLAU

DRAWN BY:
C. TEAFOE

EXPEDITOR:


SUPERVISOR:

PRELIMINARY NO:
P21284

CONTRACT NO:

DATE:
09.21.2021

SHEET:
A2.0

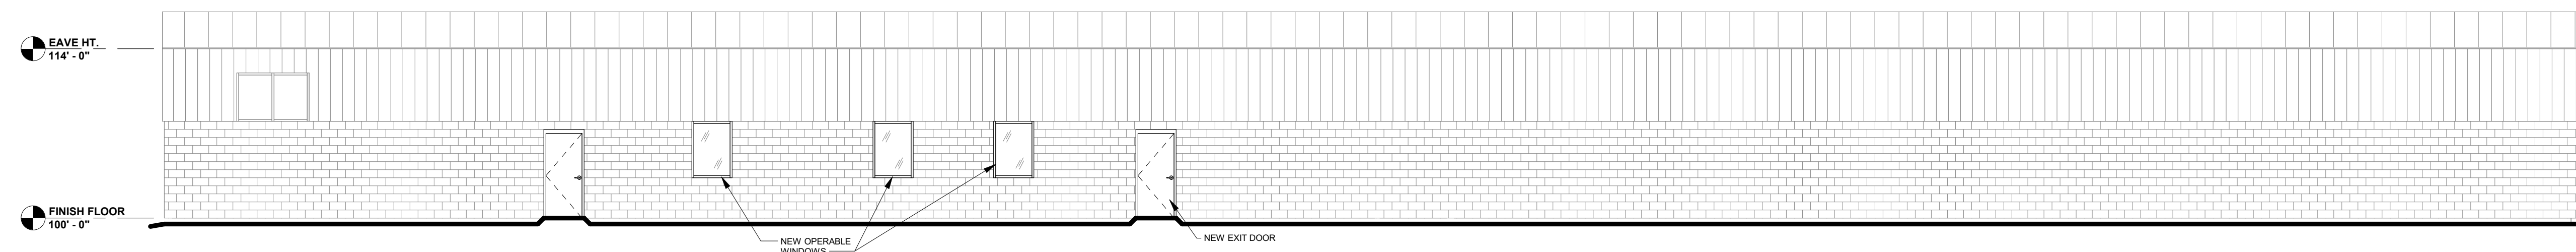

EAST ELEVATION
1/8" = 1'-0"