



Calculation Summary						
Label	Units	Avg	Max	Min	Avg/Min	Max/Min
parking 1	Fc	4.53	13.6	0.3	15.10	45.33
parking 2	Fc	4.02	13.7	0.5	8.04	27.40
parking 3	Fc	4.03	13.5	0.2	20.15	67.50
parking 4	Fc	1.77	12.9	0.1	17.70	129.00
roadway	Fc	2.84	13.5	0.0	N.A.	N.A.

Luminaire Schedule						
Symbol	Tag	Qty	Lum. Watts	Lum. Lumens LLF	Description	
	P1	1	189.98	25303	0.920	ESX1 LED P4 50K R3 / HAPCO SSS 28 B 4 4 BM D190
	P1-LL	1	189.98	25303	0.700	ESX1 LED P4 50K R3 / ON EX. 15' POLE
	P2	3	189.98	25303	0.920	ESX1 LED P4 50K R3 / HAPCO SSS 28 B 4 4 BM D218
	P3	1	189.98	25303	1.000	ESX1 LED P4 50K R3 / HAPCO SSS 28 D 4 4 BM D490
	P1-L	1	189.98	25303	0.920	ESX1 LED P4 50K R3 / HAPCO SSS 28 D 4 4 BM D490
ON CERTAIN POLES UTILIZE						
HAPCO BOLT CIRCLE ADAPTER BASE 10.5" TO 14.5" BOTTOM 7.5" TO 12" TOP.						
PROVIDE IN DARK BRONZE TO MATCH POLE COLOR.						

#	Date	Comments
1	4/12/21	UPDATED LAYOUTS
Revisions		

Drawn By: ERIC SVOBODA
Checked By: TC LYONS
Date: 4/12/2021
Scale: 1"=30' 0"




Calculation Summary						
Label	Units	Avg	Max	Min	Avg/Min	Max/Min
parking 1	Fc	4.53	13.6	0.3	15.10	45.33
parking 2	Fc	4.02	13.7	0.5	8.04	27.40
parking 3	Fc	4.03	13.5	0.2	20.15	67.50
parking 4	Fc	1.77	12.9	0.1	17.70	129.00
roadway	Fc	2.84	13.5	0.0	N.A.	N.A.

Luminaire Schedule						
Symbol	Tag	Qty	Lum. Watts	Lum. Lumens LLF	Description	
[Symbol]	P1	1	189.98	25303	0.920	ESX1 LED P4 50K R3 / HAPCO SSS 28 B 4 4
[Symbol]	P1-LL	1	189.98	25303	0.700	ESX1 LED P4 50K R3 / ON EX. 15" POLE
[Symbol]	P2	3	189.98	25303	0.920	ESX1 LED P4 50K R3 / HAPCO SSS 28 B 4 4
[Symbol]	P3	1	189.98	25303	1.000	ESX1 LED P4 50K R3 / HAPCO SSS 28 D 4 4
[Symbol]	P4	12	189.98	25303	0.920	ESX1 LED P4 50K R3 / HAPCO SSS 28 D 4 4

Drawn By: ERIC SVOBODA
Checked By: TC LYONS
Date: 4/12/2021
Scale: 1"=30' 0"

WESTBROOK PARKING
MOORHEAD WAUKESHA

Revisions		
#	Date	Comments
1	4/12/21	UPDATED LAYOUTS

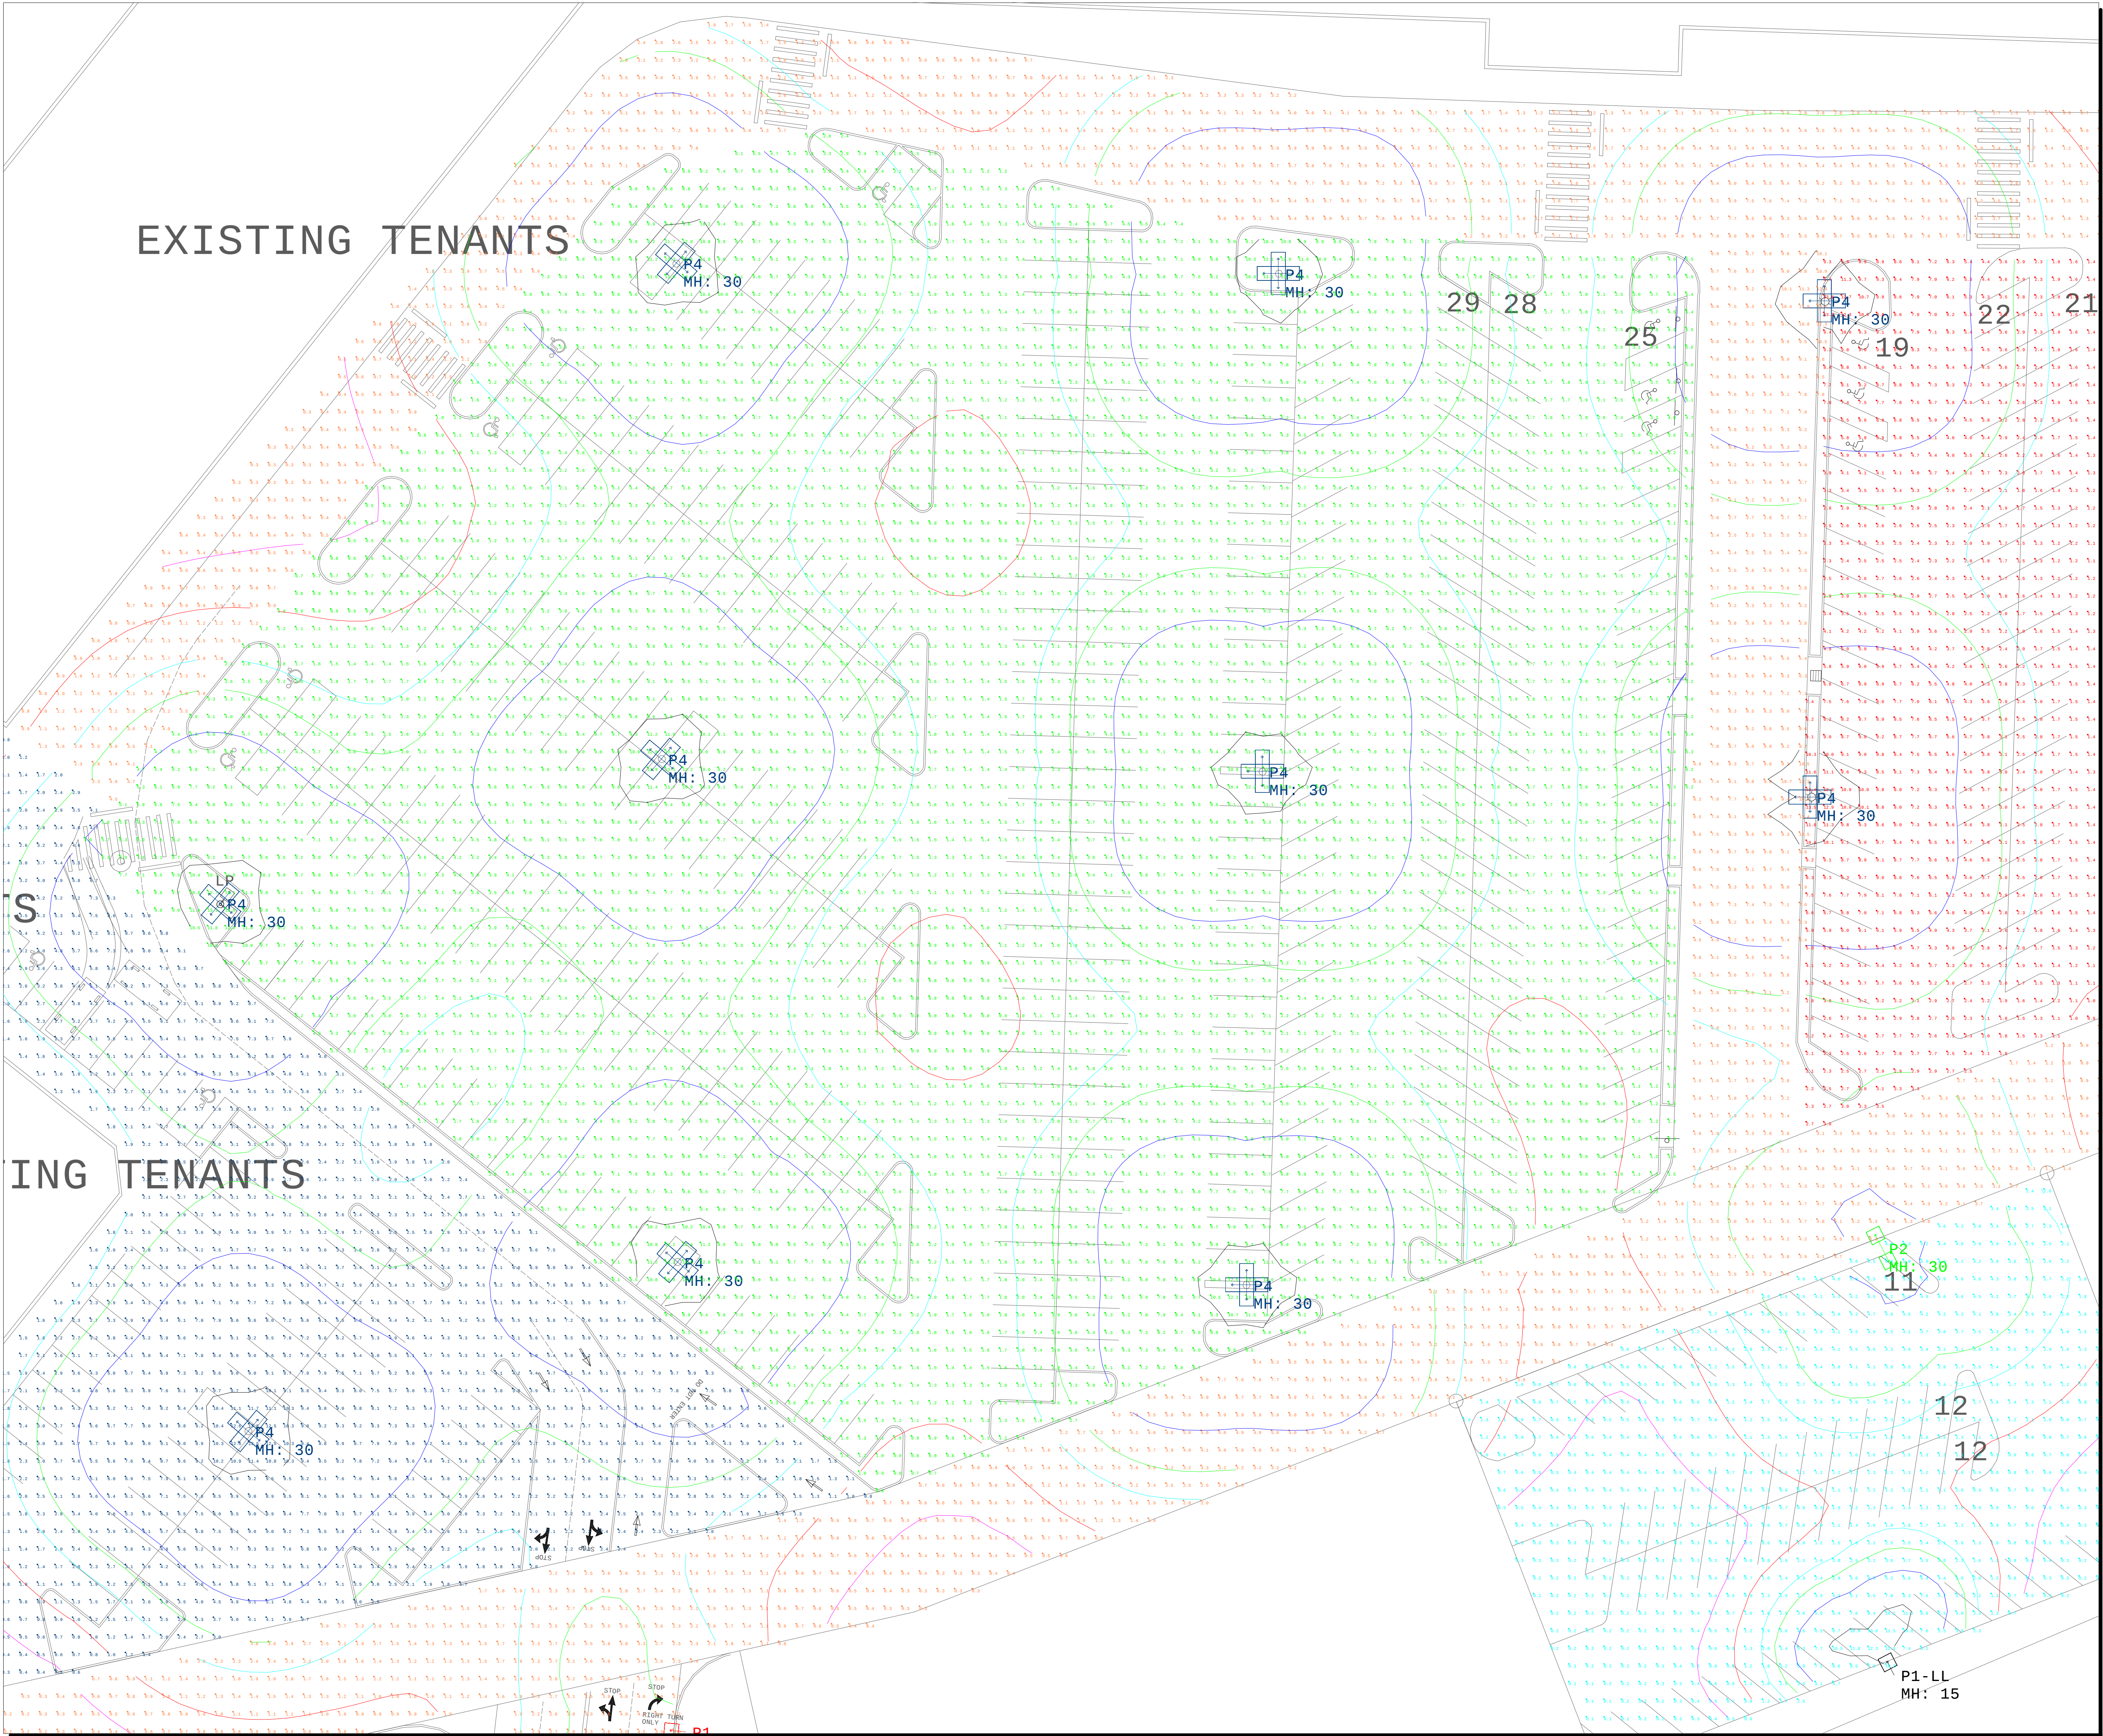


EXISTING TENANTS

ING TENANTS

Calculation Summary						
Label	Units	Avg	Max	Min	Avg/Min	Max/Min
parking 1	Fc	4.53	13.6	0.3	15.10	45.33
parking 2	Fc	4.02	13.7	0.5	8.04	27.40
parking 3	Fc	4.03	13.5	0.2	20.15	67.50
parking 4	Fc	1.77	12.9	0.1	17.70	129.00
roadway	Fc	2.84	13.5	0.0	N.A.	N.A.

Luminaire Schedule						
Symbol	Tag	Qty	Lum. Watts	Lum. Lumens LLF	Description	
	P1	1	189.98	25303	0.920	ESX1 LED P4 50K R3 / HAPCO SSS 28 B 4 4
	P1-LL	1	189.98	25303	0.700	ESX1 LED P4 50K / ON EX. 15' POLE
	P2	3	189.98	25303	0.920	ESX1 LED P4 50K R3 / HAPCO SSS 28 B 4 4
	P3	1	189.98	25303	1.000	ESX1 LED P4 50K R3 / HAPCO SSS 28 D 4 4
	P4	12	189.98	25303	0.920	ESX1 LED P4 50K R3 / HAPCO SSS 28 D 4 4

Revisions		Comments
#	Date	
1	4/12/21	UPDATED LAYOUTS

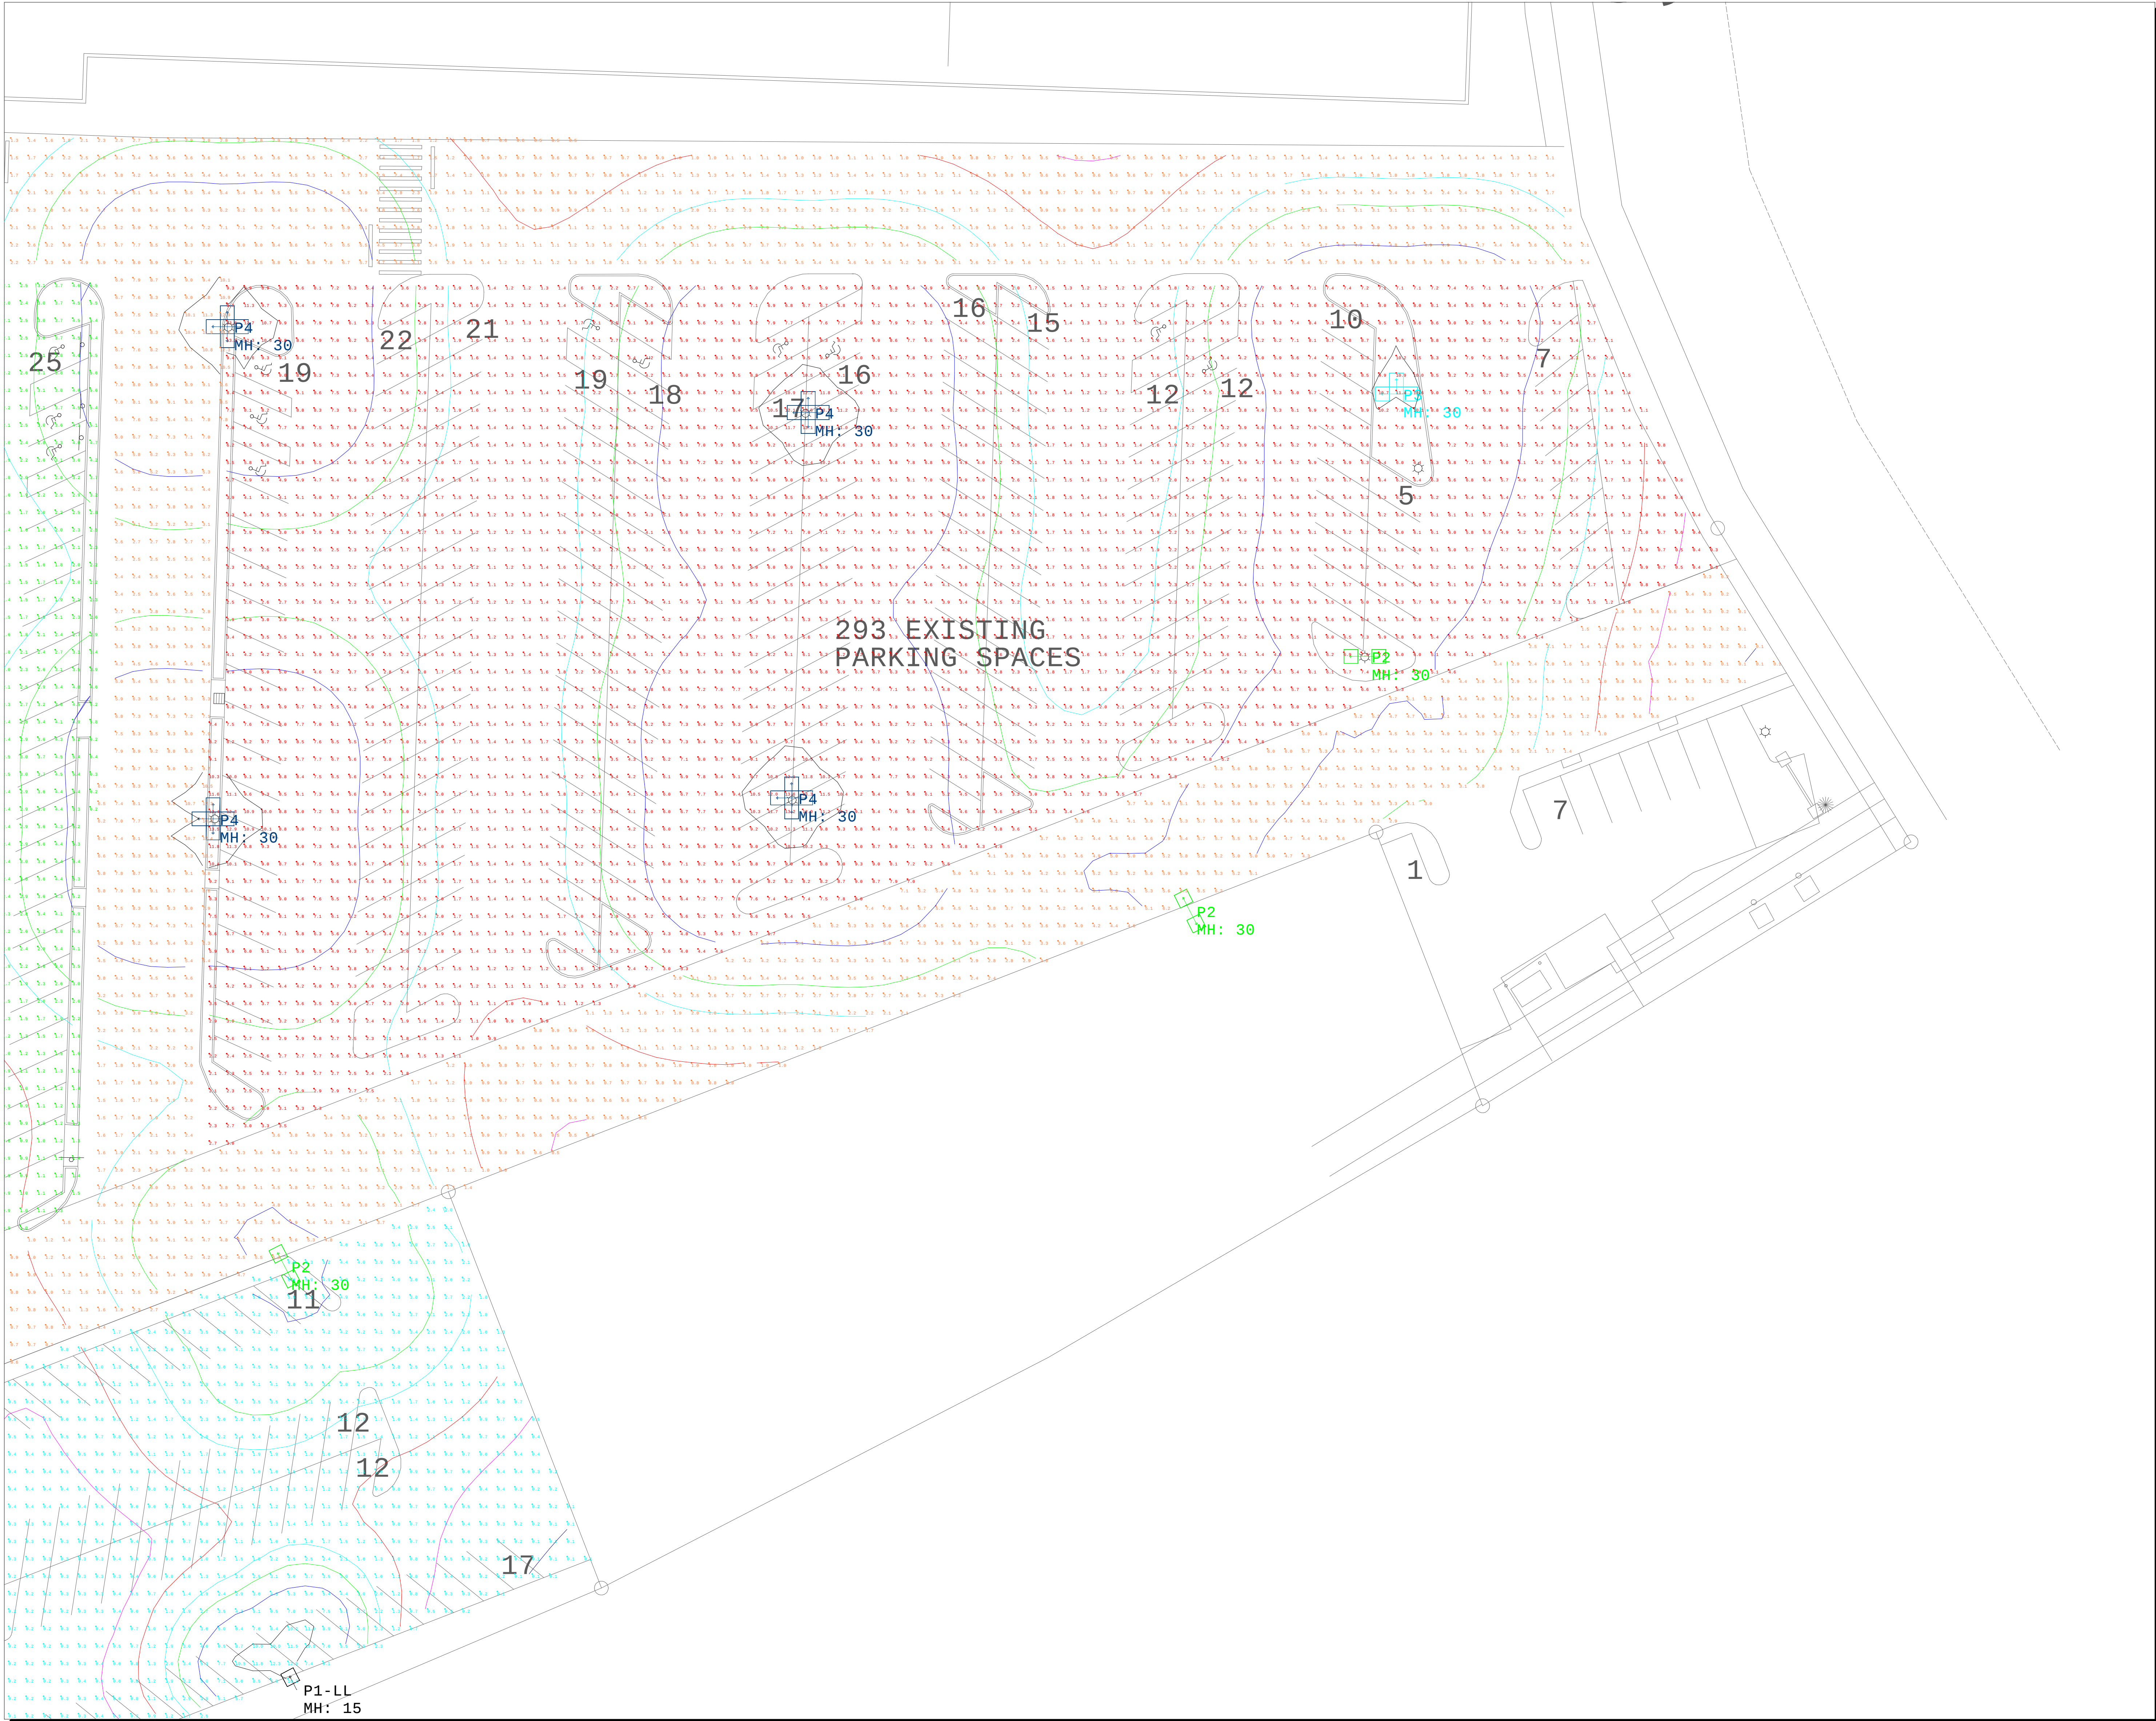

Calculation Summary						
Label	Units	Avg	Max	Min	Avg/Min	Max/Min
parking 1	Fc	4.53	13.6	0.3	15.10	45.33
parking 2	Fc	4.02	13.7	0.5	8.04	27.40
parking 3	Fc	4.03	13.5	0.2	20.15	67.50
parking 4	Fc	1.77	12.9	0.1	17.70	129.00
roadway	Fc	2.84	13.5	0.0	N.A.	N.A.

Luminaire Schedule						
Symbol	Tag	Qty	Lum. Watts	Lum. Lumens LLF	Description	
[Symbol]	P1	1	189.98	25303	0.920	ESX1 LED P4 50K R3 / HAPCO SSS 28 B 4 4
[Symbol]	P1-LL	1	189.98	25303	0.700	ESX1 LED P4 50K R3 / ON EX. 15' POLE
[Symbol]	P2	3	189.98	25303	0.920	ESX1 LED P4 50K R3 / HAPCO SSS 28 B 4 4
[Symbol]	P3	1	189.98	25303	1.000	ESX1 LED P4 50K R3 / HAPCO SSS 28 D 4 4
[Symbol]	P4	12	189.98	25303	0.920	ESX1 LED P4 50K R3 / HAPCO SSS 28 D 4 4

Drawn By: ERIC SVOBODA
Checked By: TC LYONS
Date: 4/12/2021
Scale: 1"=30' 0"

WESTBROOK PARKING
MOORHEAD WAUKESHA

Revisions		
#	Date	Comments
1	4/12/21	UPDATED LAYOUTS