


PROJECT :

RUSS DARROW KIA OF WAUKESHA

2141 EAST MORELAND BLVD
WAUKESHA, WI


CONSTRUCTION MANAGER :

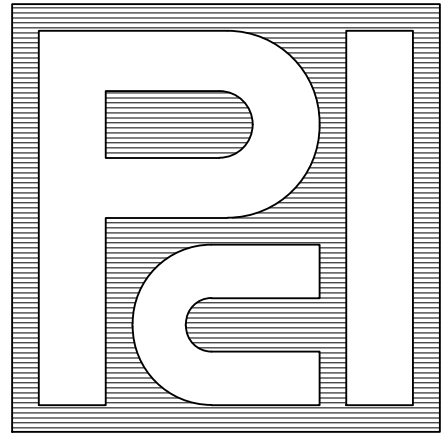

PROFESSIONAL CONSULTANTS, INC.

133 HILL STREET
HARTLAND, WISCONSIN
(414) 367-6080

ARCHITECT :

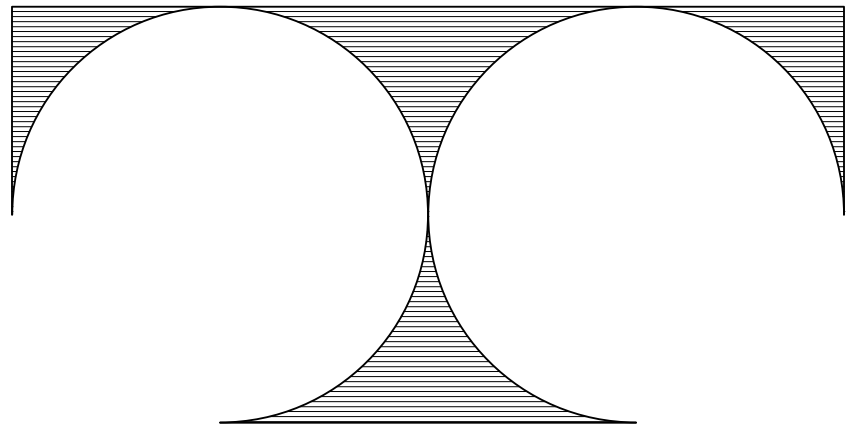

TDI ASSOCIATES, INC.

ARCHITECTURE & PLANNING
25217 SOUTH WIND LAKE ROAD
WIND LAKE, WISCONSIN
TEL: (262) 409-2530

GENERAL NOTES:

1. THE ARCHITECT/ENGINEER MAINTAINS NO RESPONSIBILITY FOR THE GENERAL CONTRACTOR, SUBCONTRACTORS, OR THOSE WORKING IN SUCH CAPACITIES, FOR THE METHODS USED, OR LACK THEREOF, IN THE EXECUTION OF THE WORK AND SAFETY PROCEDURES AND PRECAUTIONS TAKEN AT THE PROJECT SITE.
2. CONTRACTORS SHALL ASSUME FULL RESPONSIBILITY - UNRELIEVED BY REVIEW OF SHOP DRAWING NOR BY SUPERVISION OR PERIODIC OBSERVATION OF CONSTRUCTION FOR COMPLIANCE WITH THE CONTRACT DOCUMENTS - FOR DIMENSIONS TO BE CORRELATED ON THE JOB SITE AND BETWEEN INDIVIDUAL DRAWINGS OR SETS OF DRAWINGS, FOR FABRICATION PROCESSES AND CONSTRUCTION TECHNIQUES (INCLUDING EXCAVATION, SHORING AND SCAFFOLDING, BRACING, ERECTION, FORMWORK, ETC.), FOR COORDINATION OF THE VARIOUS TRADES, FOR SAFE CONDITIONS ON THE JOB SITE, AND FOR THE PROTECTION OF THE PEOPLE AND PROPERTY AT THE JOB SITE.
3. VARIATIONS IN FIELD CONDITIONS RELATIVE TO THE CONTRACT DOCUMENTS SHALL BE REPORTED TO THE ARCHITECT/ENGINEER WORK SHALL NOT PROGRESS UNTIL WRITTEN PERMISSION FROM THE ARCHITECT/ENGINEER IS OBTAINED.
4. THE INFORMATION CONTAINED ON THE DRAWINGS IS IN ITSELF INCOMPLETE, AND VOID UNLESS USED IN CONJUNCTION WITH ALL THE SPECIFICATIONS, TRADE PRACTICES, OR APPLICABLE STANDARDS, CODES, ETC., INCORPORATED THEREIN BY REFERENCE, OF WHICH THE CONTRACTOR CERTIFIES KNOWLEDGE BY SIGNING THE CONTRACT.
5. ARCHITECT/ENGINEER'S REVIEW OF DRAWINGS PREPARED BY THE CONTRACTORS, SUPPLIERS, ETC., ARE ONLY FOR CONFORMANCE WITH THE DESIGN CONCEPT. CONSTRUCTION SHALL NOT START WITHOUT SAID REVIEW, AND ONLY SHOP DRAWINGS STAMPED BY THE ARCHITECT/ENGINEER WILL BE ALLOWED AT THE JOB SITE.
6. DRAWINGS ARE NOT TO BE USED FOR SHOP DETAILING OR FOR CONSTRUCTION UNLESS SPECIFICALLY STAMPED BY THE ARCHITECT/ENGINEER ON THE DRAWINGS "FOR CONSTRUCTION". THESE DRAWINGS ARE TO BE REPRODUCED FOR THE PURPOSE OF USING THEM AS SHOP DRAWINGS.
7. UNLESS NOTED OTHERWISE, ALL DETAILS, SECTIONS, AND NOTES ON THE DRAWINGS ARE INTENDED TO BE TYPICAL FOR SIMILAR SITUATIONS ELSEWHERE.
8. ALL DIMENSIONS ON SUB-CONTRACTORS DRAWINGS ARE TO BE CHECKED BY THE CONTRACTOR AGAINST ARCHITECTURAL, MECHANICAL, AND ELECTRICAL DRAWINGS. CONTRACTOR SHALL BE FULLY RESPONSIBLE FOR CONFIRMING AND CORRELATING ALL DIMENSIONS ON THE JOB SITE AND BETWEEN INDIVIDUAL DRAWINGS AND TRADES.
9. SEE ARCHITECTURAL, MECHANICAL AND ELECTRICAL DRAWINGS FOR ADDITIONAL OPENINGS, SLEEVES, EQUIPMENT PADS, DEPRESSIONS, CURBS, FLOOR FINISHES, INSERTS, AND OTHER EMBEDDED ITEMS.
10. UNLESS OTHERWISE SHOWN OR NOTED, THE GENERAL CONTRACTOR SHALL BE RESPONSIBLE FOR COORDINATING THE LOCATION AND THE PLACEMENT OF ANY INSERTS, HANGARS, PIPE SLEEVES, HOLES OR ANCHORS BOLTS THAT ARE REQUIRED BY THE MECHANICAL OR ELECTRICAL EQUIPMENT.
11. THE CONTRACTOR SHALL COMPLY WITH THE LATEST OCCUPATIONAL SAFETY HEALTH ACT REQUIREMENTS.
12. ALL CONSTRUCTION SHALL BE PERFORMED IN STRICT CONFORMANCE WITH ALL APPLICABLE STATE AND LOCAL BUILDING CODES.



08.13.2025

DRAWING INDEX :

REVISION DATE

REV #3 08-06-2025 T1.0
REV #3 08-06-2025 T1.1

TITLE SHEET

LIFE SAFETY, PLAN SYMBOLS, & ACCESSIBLE MOUNTING DIAG.

CIVIL*:

C000 COVER SHEET
1 of 1 PLAT OF SURVEY
C100 EROSION CONTROL PLAN
C200 DEMOLITION PLAN
C300 OVERALL SITE & LANDSCAPE PLAN
C301 DETAILED SITE & LANDSCAPE PLAN
C400 GRADING PLAN
C500 SPECIFICATIONS

*CIVIL, DESIGN BY SEPARATE OWNER'S CONTRACT, WORK NOT COVERED BY THIS PROJECT'S SUPERVISING PROFESSIONAL

ARCHITECTURAL:

REV #3 08-06-2025 A1.1 DEMO PLAN
REV #3 08-06-2025 A1.1 FIRST FLOOR PLAN
REV #2 06-27-2025 A2.1 EXTERIOR ELEVATIONS
REV #2 06-27-2025 A2.2 EXTERIOR ELEVATIONS
REV #2 06-27-2025 A3.0 WALL TYPES & WALL SECTIONS
REV #2 06-27-2025 A3.1 WALL SECTIONS
REV #2 06-27-2025 A3.2 WALL SECTIONS
REV #2 06-27-2025 A3.3 WALL SECTIONS
REV #2 06-27-2025 A3.4 WALL SECTIONS
REV #3 08-06-2025 A4.1 WALL & FLOOR FINISH PLAN
REV #2 06-27-2025 A4.2 INTERIOR FINISH SCHEDULE
REV #2 06-27-2025 A4.3 INTERIOR FINISH SCHEDULE
REV #2 06-27-2025 A4.4 FURNITURE & FIXTURE PLAN
REV #2 06-27-2025 A4.5 FURNITURE SCHEDULE
REV #2 06-27-2025 A4.6 FIXTURE SCHEDULE
REV #3 08-06-2025 A6.1 REFLECTED CEILING PLAN
REV #2 06-27-2025 A6.2 LIGHT FIXTURE SCHEDULE
REV #3 08-06-2025 A7.1 DOOR SCHEDULE & DETAILS

STRUCTURAL:

REV #2 06-27-2025 S1.1 FOUNDATION PLAN
REV #3 08-06-2025 S2.1 ROOF FRAMING & PRECAST PLANK PLAN

BUILDING DATA :

OCCUPANCY:
(chapter 3)

GROUP B, BUSINESS
GROUP S-1, MODERATE - HAZZARD STORAGE

SPRINKLERS:

FULLY SPRINKLERD NFPA 13

CONSTRUCTION TYPE:
(per 602)

TYPE III B
TWO STORY
4 SIDES FIRE ACCESS

ALLOWABLE AREA:
(per table 503)

GROUP B 3 STORIES 19,000 SQ. FT.
GROUP S-1 2 STORIES 17,500 SQ. FT.

MOST RESTRICTIVE:
OPEN AREA INCREASE:

GROUP S-1 2 STORIES 17,500 SQ. FT.
13,125Q. FT.
TOTAL = 30,625 SQ. FT.


ACTUAL AREA:

EXISTING FIRST FLOOR: 17,083 SQ. FT.
FIRST FLOOR ADDITION 1: 1,803 SQ. FT.
FIRST FLOOR ADDITION 2: 1,043 SQ. FT.
TOTAL FIRST FLOOR AREA: 19,935 SQ. FT.

EXISTING SECOND FLOOR: 3,381 SQ. FT.
ALTERED FIRST FLOOR: 9,386 SQ. FT.


RATINGS REQUIRED:
(per table 601)

OCCUPANCY SEPARATION 3 HOUR RATING
STRUCTURAL FRAMING NC-0 HOUR RATING
BEARING WALL EXTERIOR 2 HOUR RATING
BEARING WALL INTERIOR NC-0 HOUR RATING
NON BEARING EXTERIOR („30') NC-0 HOUR RATING
NON BEARING INTERIOR 0 HOUR RATING
FLOOR CONSTRUCTION NC-0 HOUR RATING
ROOF CONSTRUCTION NC-0 HOUR RATING
ROOF COVERING CLASS - B

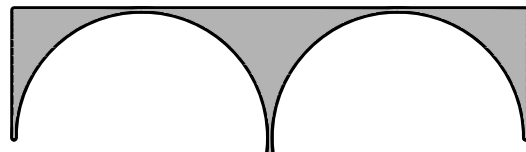

TDI ASSOCIATES, INC.
ARCHITECTURE & PLANNING

25217 SOUTH WIND LAKE ROAD
WIND LAKE, WISCONSIN 53185
PHONE 262-409-2530

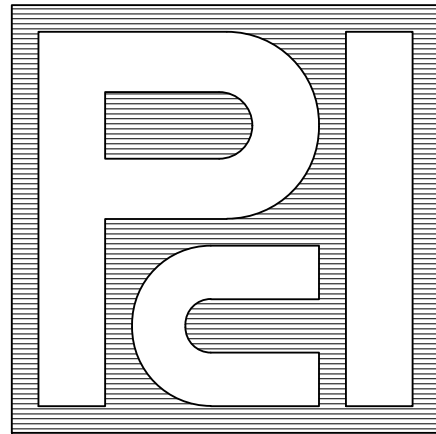

PROFESSIONAL
CONSULTANTS, INC.

300 COTTONWOOD AVE # 7
HARTLAND, WISCONSIN 53029
(262) 367-6080

RUSS DARROW
KIA OF WAUKESHA
2141 EAST MORELAND BLVD
WAUKESHA, WISCONSIN

TDI ASSOCIATES, INC.
All Rights Reserved

OWNERSHIP OF DOCUMENTS

This document, and the ideas and design incorporated herein, as an instrument of professional service, is the sole property of TDI Associates, Inc., and is not to be used in whole or in part for any other project or purpose without the expressed written authorization of TDI Associates, Inc.

Sheet Title
TITLE SHEET

Issued For: Date:
REV #1 09-03-2024
REV #2 06-27-2025
REV #3 08-06-2025

Date: 07-25-2024

Job NO.: 24103.000





Drawn By: LCC

Sheet No.





T1.0

ACT	Acoustic Tile	EA	Each
ADDN	Add	EF	Each Face
ADJ	Adjustable	EL	Elevation
AFF	Above Finish Floor	ELEG	Electrical
ALT	Alternate	ELVY	Elevator
ALUM	Aluminum	ENCL	Enclosure
APC	Acess Panel	EQ	Equip
ARCH	Architectural/Architect	EQUIP	Equipment
AVE	Avenue	ETR	Existing To Remain
		EH	Each Way
BESBD	Banished	EHAC	Electric/Natural Cooler
BET	Belted Board	EXH	Excavate
BL	Blumlines	EXHST	Exhaust
BL	Borrowed Lumber	EXIST	Existing
BLDG	Building	EXP	Expansion
BLK	Block	EXT	Exterior
BLDG	Blocking		
BLKT	Blanket	FA	Fire Alarm
BM	Bloom	FC	Fire Code
BH	Bench Mark	FD	Floor Drafting/Fire Door
BY	By Owner	FEN	Foundation
BOT	Bottom	FE	Fire Extinguisher
BRO	Bearing	FEIG	Fire Extinguisher Cabinet
BRK	Brick	FHC	Fire Hose Cabinet
BSMT	Basement	FINL	Finish
BTAN	Butt	FIX	Fixture
BU	Butt-Up	FLR	Floor
		FLRG	Flooring
C	Chisel	FLUOR	Fluorescent
CAB	Cabinet	FT	Feet
CPT	Capnet	FTG	Footing
CB	Chubbboard	FT	Footnote
CB	Catch Basin	F.F.	Finished Floor
CER	Ceramic	FOF	Face Of Foundation
CGR	Cornier Board	FOH	Face Of Wall
CI	Cast Iron		
CJ	Control/Construction Joint		
CL	Centerline	GA	Gauge
CL	Ceiling	GA/LV	Galvanized
CMU	Concrete Masonry Unit	GB	Garage Bar
COL	Column	GC	General Contractor
CONC	Concrete	GEN	General
CONF	Conference	GL	Galvanized Iron
CONST	Construction	GL	Glass
CONT	Continuous	GLB	Gypsum Wall Board
CONTR	Contractor	GPM	Gymnasium
CORR	Corrosion/Corrugated	GYP	Gypsum
CT	Ceramic Tile		
CTR	Center/Center	HD	Head
CU	Cable	HDW	Hardware
CFOI	Contractor Furnished, Owner Installed	HDWD	Hardwood
		HGT	Height
D	Depth	HM	Hot-Set Metal
DBL	Double	HCRZ	Horizontal
DEPT	Department	HR	Hour
DTL	Detail	HV	Heating / Ventilating
DT	Drafting	HVAC	Heating, Ventilating, & Air Conditioning
DH	Double Hung		
DIA	Diameter		
DIAG	Diagram/Diagonal		
DM	Dimension		
DIV	Division		
DMFPG	Dampproofing		
DN	Down		
DS	Down Spout		
DWS	Draining		
DML	Down		


Inside Diameter	PART	Partition	TB	Tackboard/Towel Bar
Insert Elevation	PL	Plaster	TBB	Top 4 Bottom
Inside Face	PL	Plaster/Piercing Line	TEL	Telephone
Inches	PNLG	Panelling	TEMP	Temperature
Include	PR	Pier	TER	Terrazzo
Insulation	PREFAB	Prefabricated	THRESH	Threshold
Interior	PREFIN	Prefinished	TIG	Tongue & Groove
Invert	PRELIM	Preliminary	TQB	Top Of Beam
	PRESS	Pressure	TOD	Top Of Deck
Joint	PSF	Pounds Per Square Foot	TOT	Top Of Footing
Joint	PT	Pipe	TOJ	Top Of Joint
Knocked Down	FLYWD	Flywood	TOS	Top Of Slab/Steel
One Thousand Pounds	PROP	Prop	TOW	Top Of Wall
Knock Out	P45	Pipe 1/2 Shell	TPG	Topping
	PLAS	Plaster	TRANS	Transformer
	PLBG	Pumbing	TTP	Typical
	PNL	Panel		
Laboratory			UL	Underlayment/Laboratories
Laminated			UNEX	Unexcavated
Lavatory			UNFIN	Unfinished
Pound	QT	Quarry Tile	Unfil	Unfil
Pounds				
Locker	R	Ribber/Radius	VB	Vinyl Base
Lowers	RB	Rubber Base	VCT	Vinyl Composite Tile
Low Point	RD	Rod Drain	VERT	Vertical
Long Span Joist	REC	Recessed	VOLUME	Volume
Light	RFP	Refringent	VNF	Vinyl Nail Fabric
	REINF	Reinforcing		
Masonry	READ	Required		
Materials	RES	Resilient		
Maximum	RET	Return	W	Width
Mechanical			WC	Water Closet
Membrane	REV	Revised	WO	Wood
Mezzanine	RFG	Roofing	WF	Wide Flange
Model	RH	Room	WFF	Welded Rein Fabric
Manufacturer	RI	Rough In	W/O	Without
Marble	RM	Room		
Middle	RO	Rough Opening		
Minimum	RT	Rubber Tile		
Mirror				
Miscellaneous	SGH	Schedule		
Moulding	SECT	Section		
Masonry Opening	SEN	Sewer		
Mounting	SGL	Single		
Metal	SH	Sheet		
	SH	Similar		
Not In Contract	STL-JST	Slide Joint		
Number	SOC	Slide On Grade		
Nominal	SPEC	Specifications		
Not To Scale	SQ	Square		
	S/S	Stainless Steel		
On Center	STD	Standard		
Outside Diameter	STL	Steel		
Owner Furnished, Contractor Installed	STM	Storm		
Owner Furnished, Owner Installed	STO	Storage		
Overlaid Scaffop	STRUCT	Structural/Structure		
Opening	SUSP	Suspended		
Opposite	SW	Switch		
Once	SYM	Symetrical		

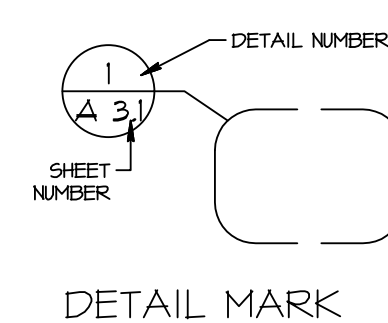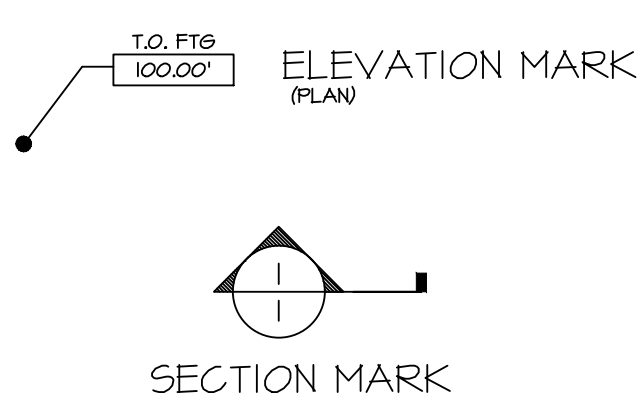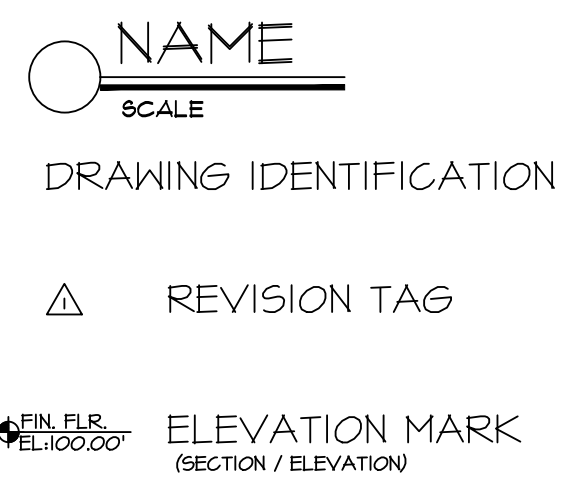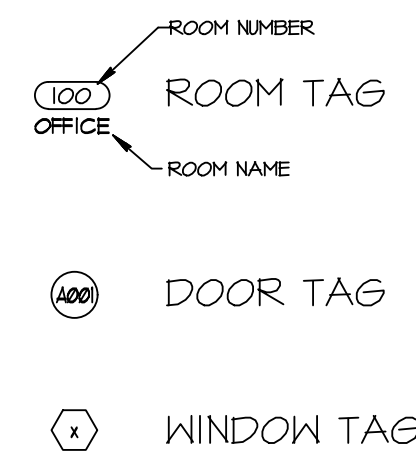

- = SINGLE DIRECTION EXIT SIGN
EXIT SIGN FACES INDICATED WITH A LINE
- = BUILDING EXIT
- = FIRE EXTINGUISHER CABINET
- = PATH OF EGRESS
- = "5-1" OCCUPANCY
- = "B" OCCUPANCY

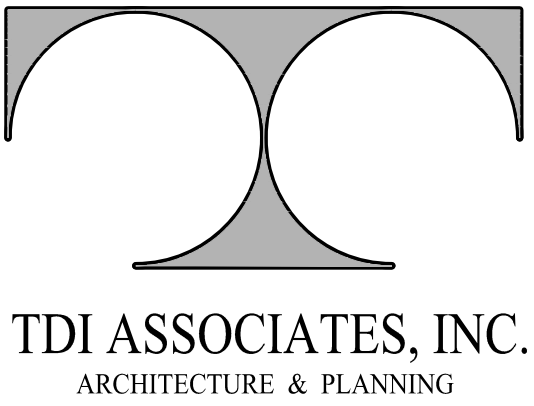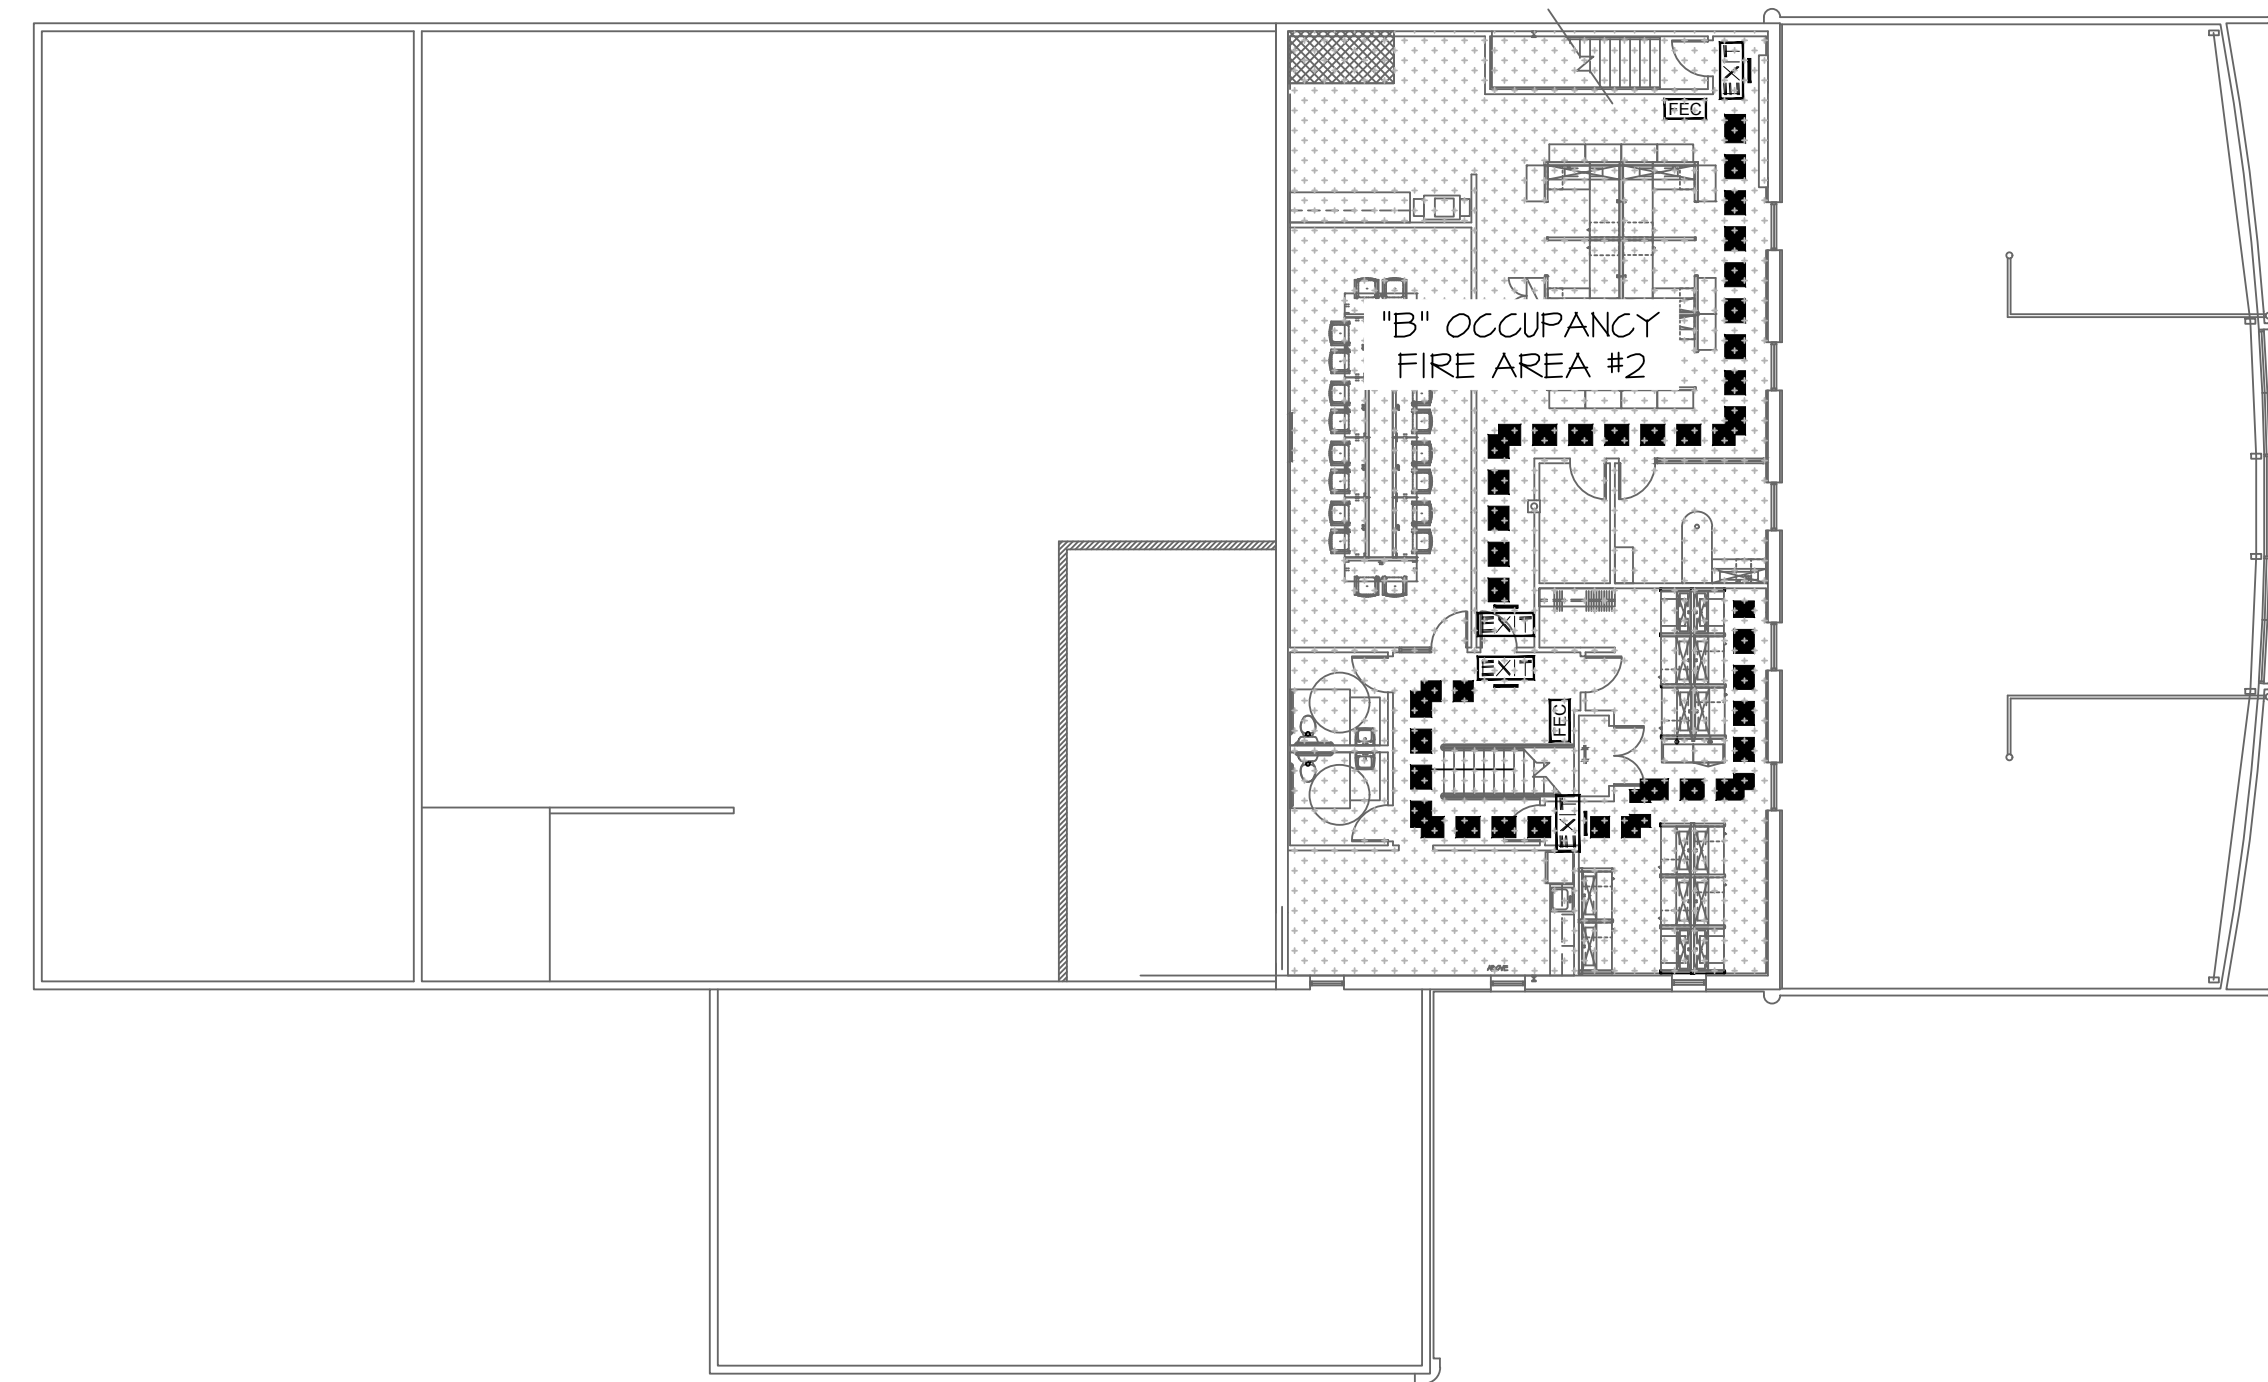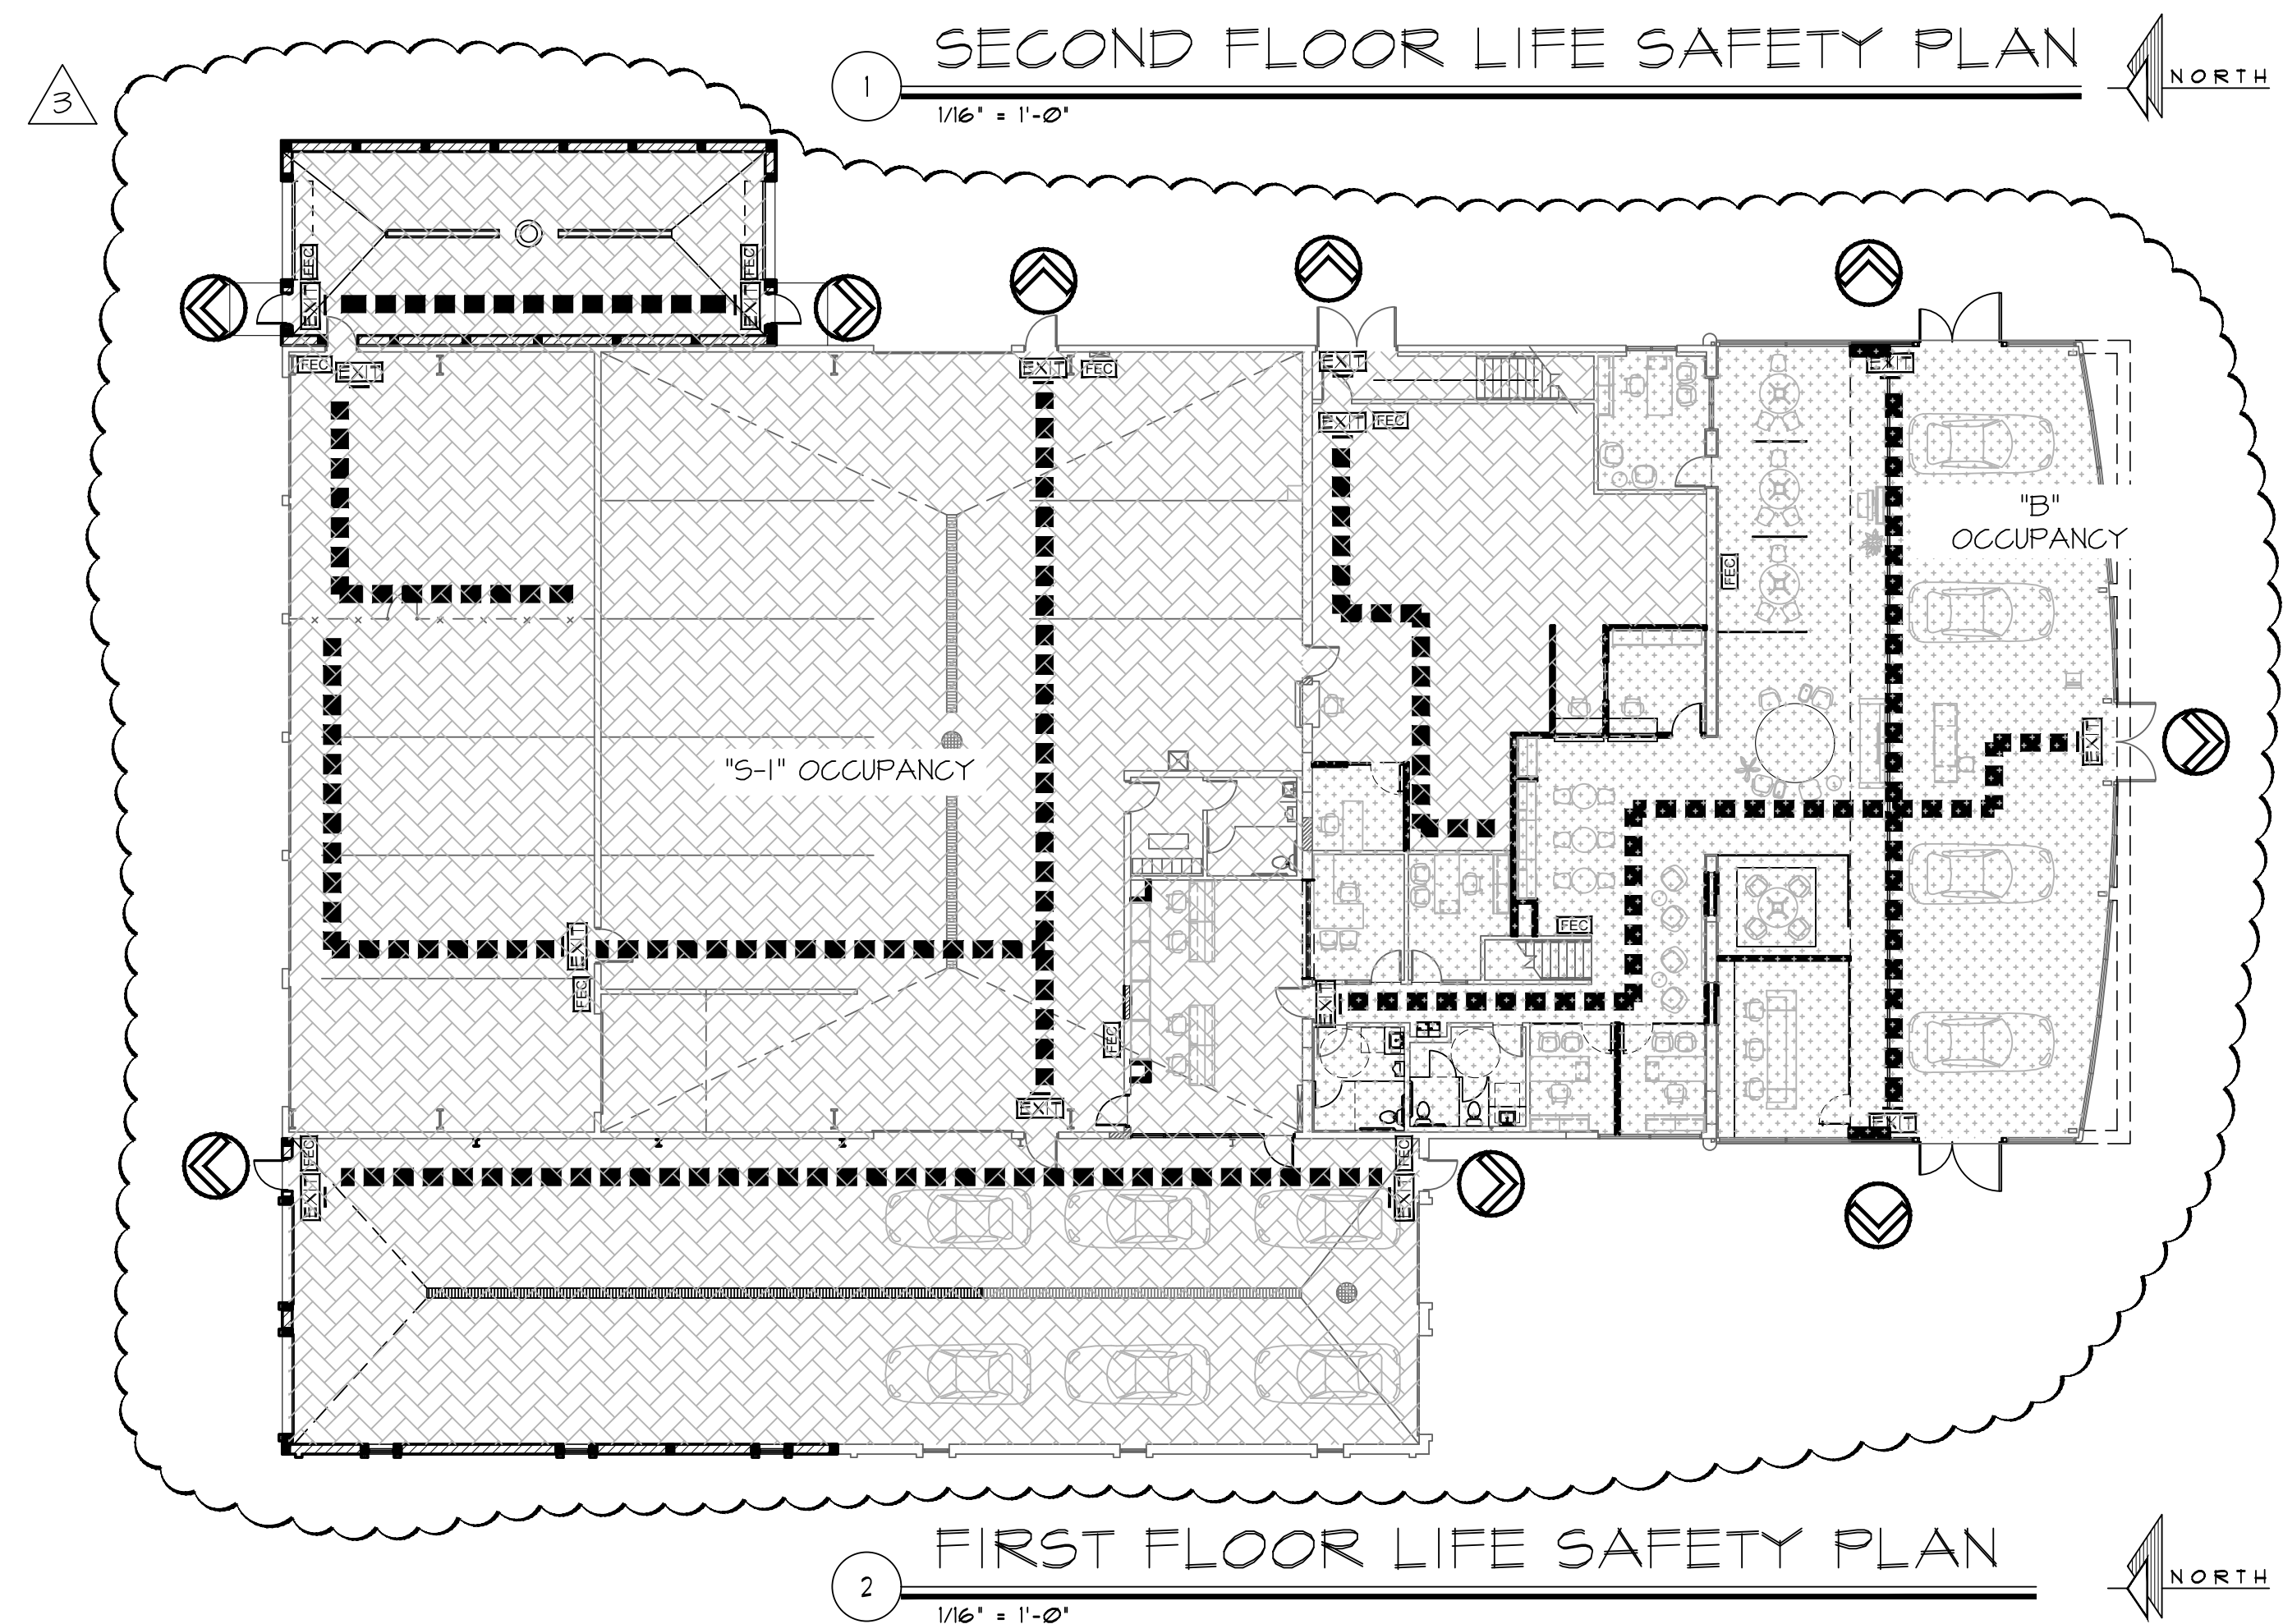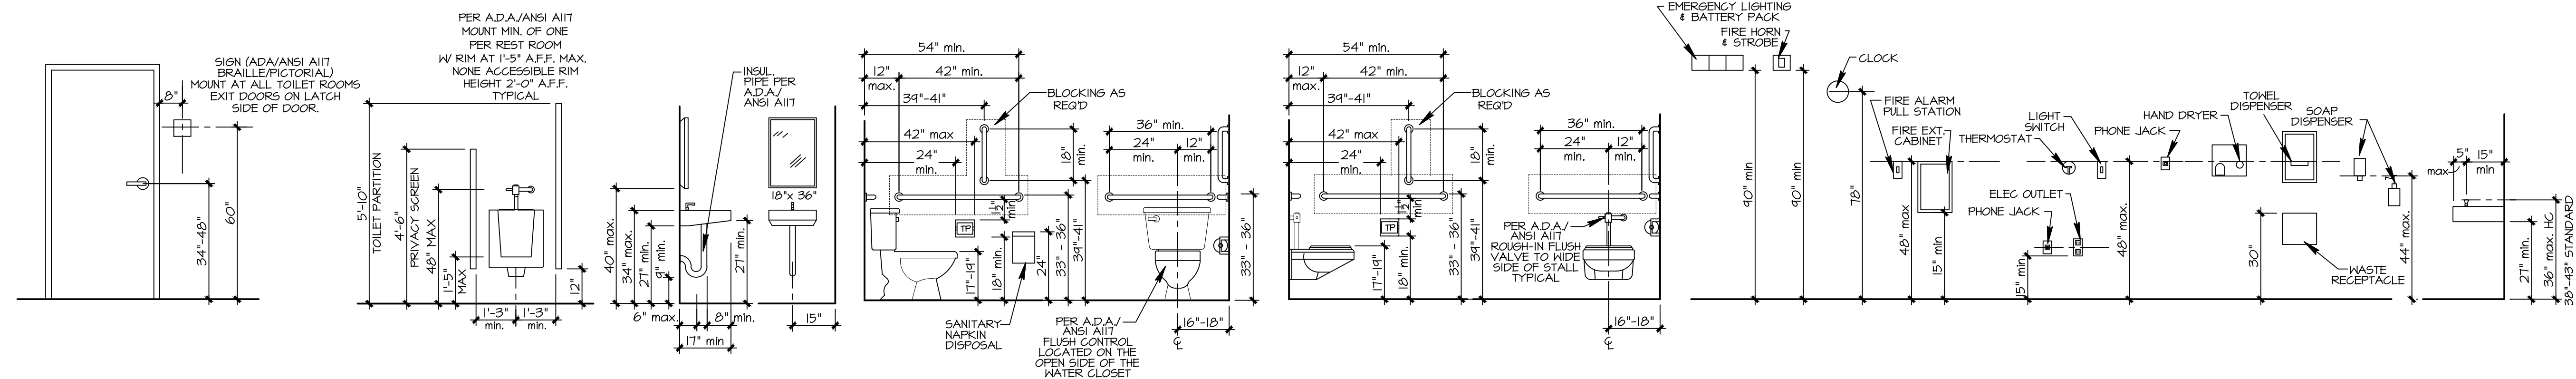

25217 SOUTH WIND LAKE ROAD
WIND LAKE, WISCONSIN 53185
PHONE 262-409-2530

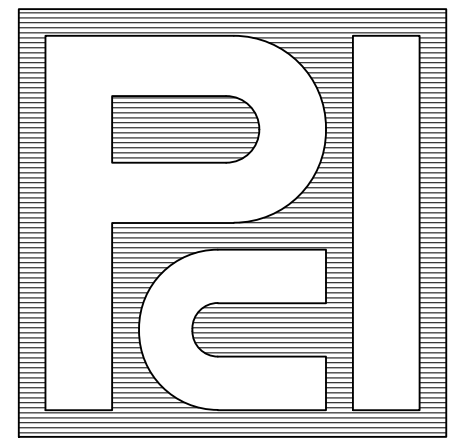

PROFESSIONAL
CONSULTANTS, INC.
300 COTTONWOOD AVE # 7
HARTLAND, WISCONSIN 53029
(262) 367-6080

RUSS DARROW
KIA OF WAUKESHA
2141 EAST MORELAND BLVD
WAUKESHA, WISCONSIN

TDI ASSOCIATES, INC
All Rights Reserved

OWNERSHIP OF DOCUMENTS

This document, and the ideas and design incorporated herein, as an instrument of professional service, is the sole property of TDI Associates, Inc., and is not to be used in whole or in part for any other project or purpose without the expressed written authorization of TDI Associates, Inc.

Sheet Title
LIFE SAFETY
PLAN SYMBOLS, &
ACCESSIBLE
MOUNTING DIAG.

Issued For:	Date:
REV #2	06-27-2025
REV #3	08-06-2025

Date: 07-25-2024


Job NO.: 24103.000

Drawn By: RJH

Sheet No.

CONSTRUCTION PLANS FOR RUSS DARROW KIA WAUKESHA CITY OF WAUKESHA, WISCONSIN

VICINITY MAP

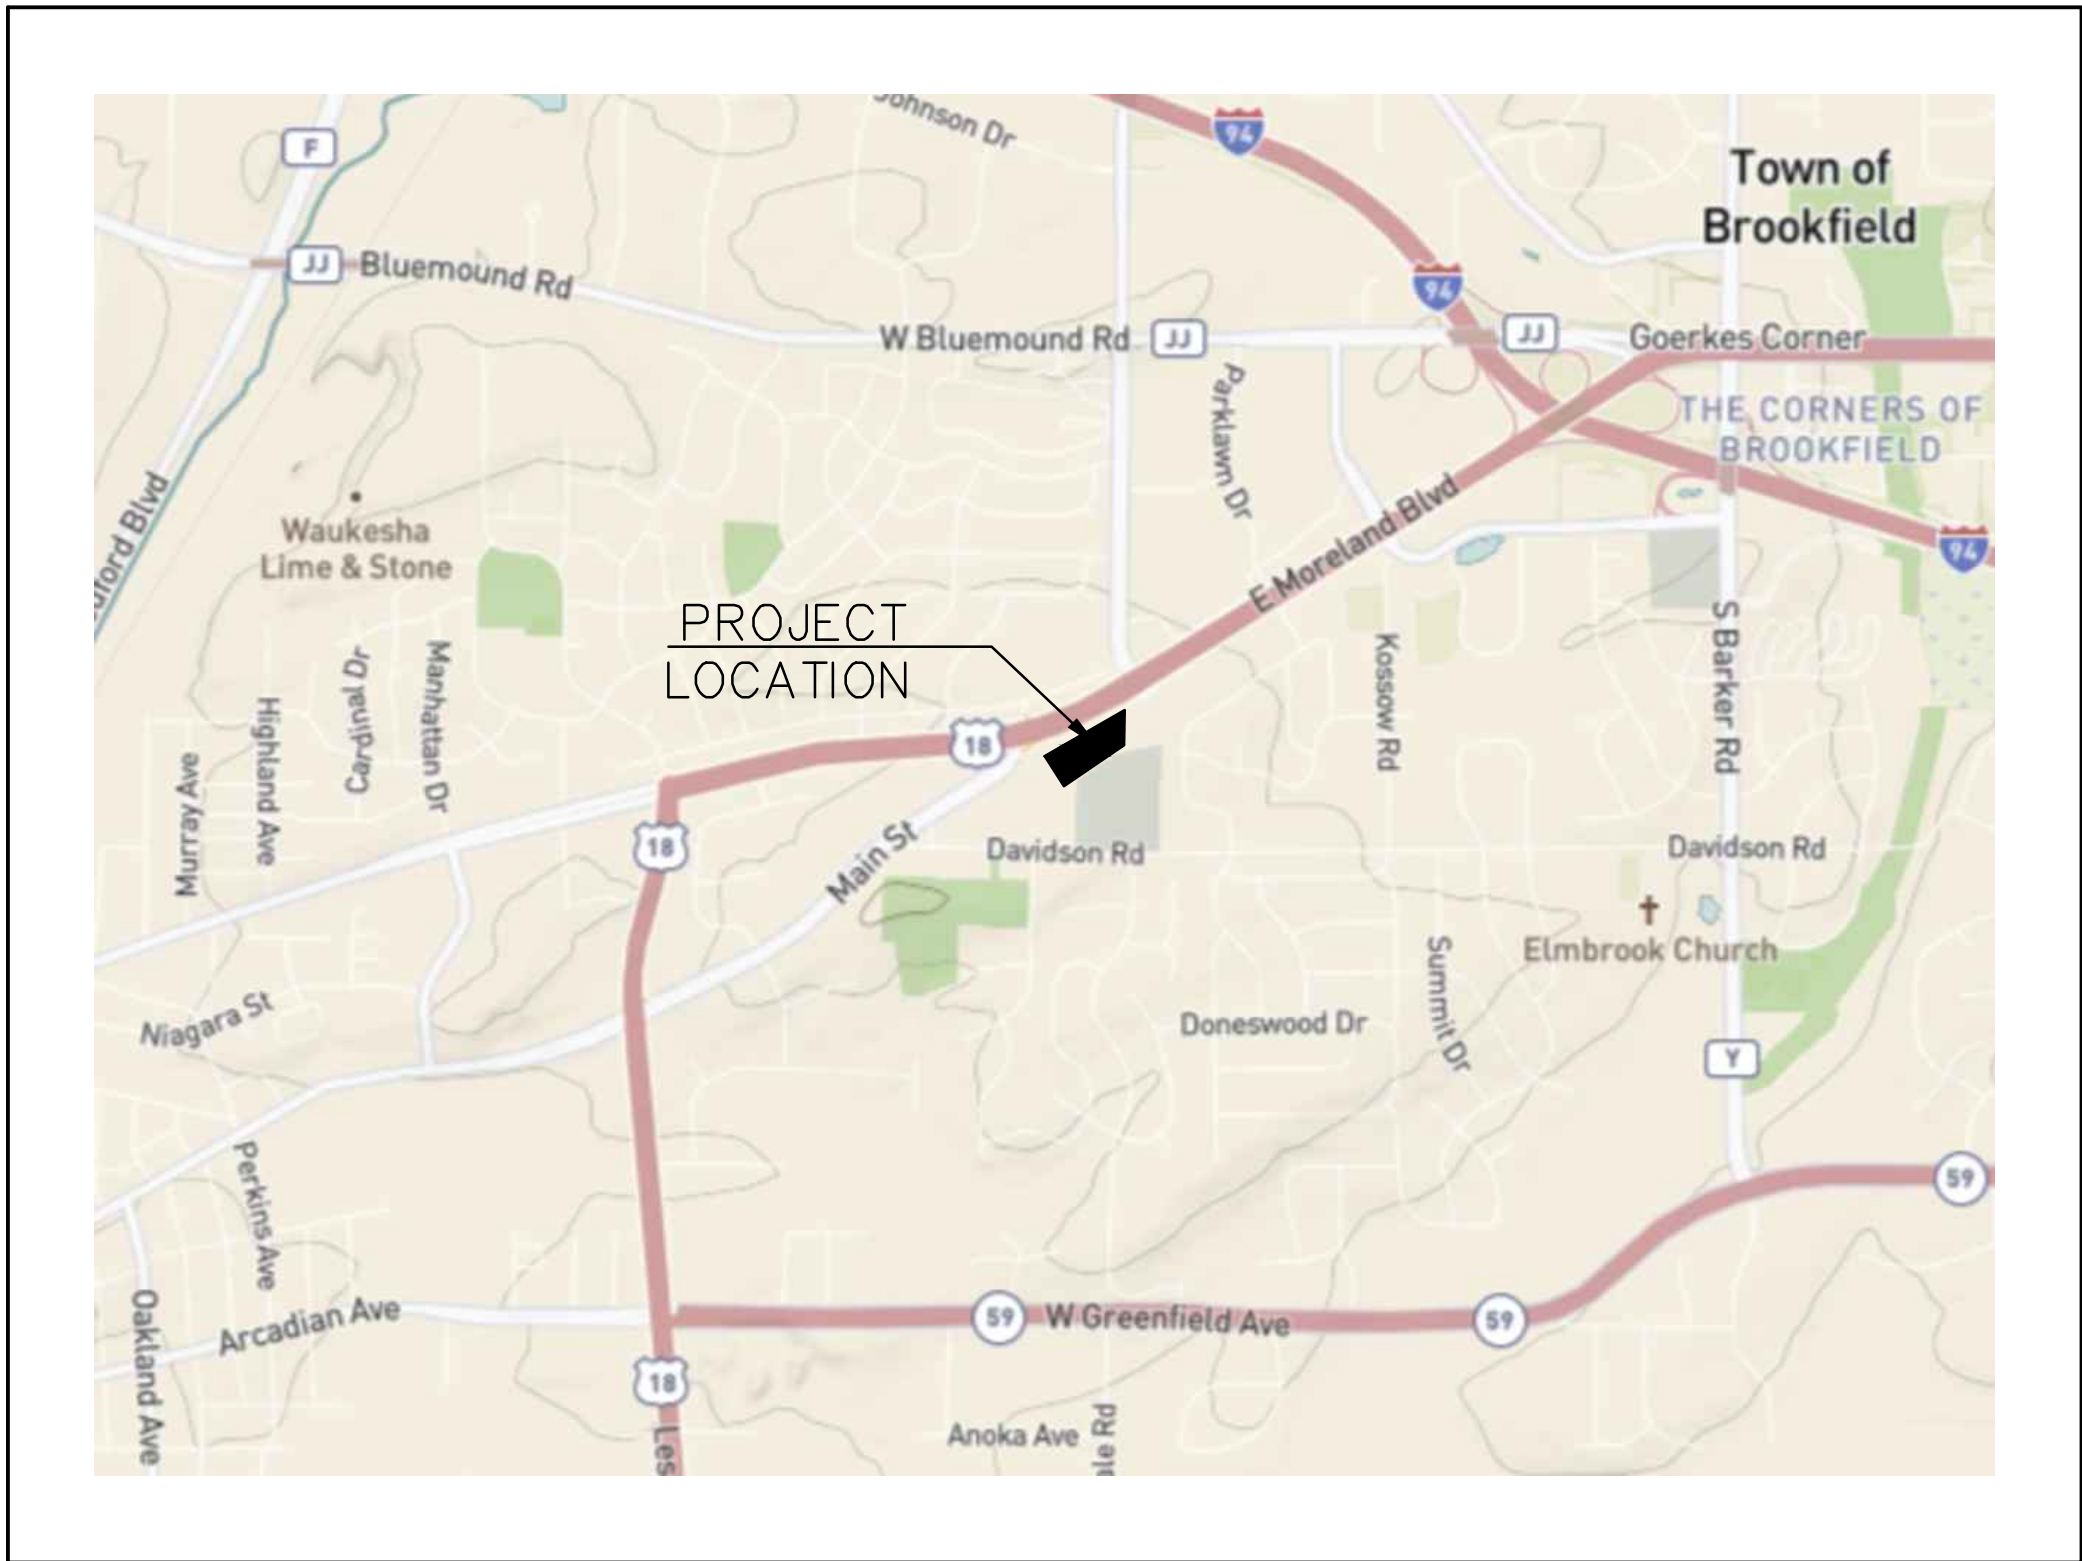

PLAN INDEX

SHEET NO.	DESCRIPTION
C000	COVER SHEET
1 OF 1	PLAT OF SURVEY
C100	EROSION CONTROL PLAN
C200	DEMOLITION PLAN
C300	OVERALL SITE & LANDSCAPE PLAN
C301	DETAILED SITE & LANDSCAPE PLAN
C400	GRADING PLAN
C500	UTILITY PLAN
C600	SPECIFICATIONS

ADDRESS:

2141 E. MORELAND BLVD
WAUKESHA, WI 53186

CITY OF WAUKESHA NOTE

- ALL SITE IMPROVEMENTS AND CONSTRUCTION SHOWN ON PLANS SHALL CONFORM TO THE CITY OF WAUKESHA DEVELOPMENT HANDBOOK & INFRASTRUCTURE SPECIFICATIONS. WHERE THE PLANS DO NOT COMPLY, IT SHALL BE THE SOLE RESPONSIBILITY AND EXPENSE OF THE DEVELOPER TO MAKE REVISIONS TO THE PLANS AND/OR CONSTRUCTED INFRASTRUCTURE TO COMPLY.
- VERTICAL DATUM: NAVD 88, STARTING BENCHMARK: NORTHWEST CORNER OF NORTHWEST 1/4 OF SECTION 31, TOWNSHIP 7 NORTH, RANGE 20 EAST, FOUND CONCRETE MONUMENT WITH BRASS CAP, ELEVATION (CITY) 120.75+780.45= 901.20' NAVD 88
- HORIZONTAL DATUM: NAD83

PLAN DATE: 1/21/2025

REVISIONS	ISSUE DATE	SHEET NO.'S	ISSUED FOR:

BENCHMARK 1:

SW BOLT ON HYDRANT.
HYDRANT IS NW OF SITE.
ELEVATION = 953.41'
VERTICAL DATUM: NAVD 88

BENCHMARK 2:

TOP OF CONC BASE LP. LP IS
NE OF SITE
ELEVATION = 959.99'
VERTICAL DATUM: NAVD 88

SEWRPC BENCHMARK 1:

CONC. MON. W/ BRASS CAP
SW CORNER OF NW ¼ SEC.
31-7-20
ELEVATION = 954.57'
N: 378,688.03 USFT
E: 2,453,501.89 USFT

SEWRPC BENCHMARK 2:

CONC. MON. W/ CAP
NW CORNER OF NW ¼ SEC.
31-7-20
ELEVATION = 901.20'
N: 381,331.06 USFT
E: 2,453,478.14 USFT



R.A. SMITH, INC. ASSUMES NO RESPONSIBILITY FOR DAMAGES, LIABILITY OR COSTS RESULTING FROM CHANGES OR ALTERATIONS MADE TO THIS PLAN WITHOUT THE EXPRESSED WRITTEN CONSENT OF R.A. SMITH, INC.

ALL COPYRIGHTS TO THESE DRAWINGS ARE RESERVED. THEY MAY NOT BE COPIED, CHANGED, OR ASSIGNED TO ANY THIRD PARTY IN ANY MANNER WITHOUT OBTAINING THE EXPRESSED WRITTEN PERMISSION OF R.A. SMITH, INC.

LEGEND (PROPOSED FEATURES)

	TREE REMOVAL
	EXISTING CONCRETE PAVEMENT TO BE REMOVED
	EXISTING ASPHALT PAVEMENT TO BE REMOVED
	EXISTING GRAVEL TO BE REMOVED
	EXISTING BUILDING/STRUCTURE TO BE REMOVED
	SAWCUT LINE
	PROPOSED PROPERTY LINE
	PROPOSED SITE LIGHTING (DESIGNED BY OTHERS, FOR REFERENCE ONLY)
	MONUMENT SIGNS (CONSTRUCTION DETAILS BY OTHERS)
	SIGN
	HEAVY-DUTY CONCRETE PAVEMENT
	CONCRETE SIDEWALK
	HEAVY-DUTY ASPHALT PAVEMENT
	STANDARD-DUTY ASPHALT PAVEMENT
	COLORED AND STAMPED CONCRETE
	PROPOSED ACCESSIBLE PAVEMENT MARKING VAN ACCESSIBLE STALL
	PROPOSED TYPE 3 CURB RAMP (SEE DETAIL SHEET, NOTE LINEWORK ON PLAN IS SYMBOLIC ONLY.)
	PROPOSED TYPE 3A CURB RAMP (SEE DETAIL SHEET, NOTE LINEWORK ON PLAN IS SYMBOLIC ONLY.)
	PROPOSED TYPE 4 CURB RAMP (SEE DETAIL SHEET, NOTE LINEWORK ON PLAN IS SYMBOLIC ONLY.)
	PROPOSED TYPE 4A CURB RAMP (SEE DETAIL SHEET, NOTE LINEWORK ON PLAN IS SYMBOLIC ONLY.)
	PROPOSED TYPE 7 CURB RAMP (SEE DETAIL SHEET, NOTE LINEWORK ON PLAN IS SYMBOLIC ONLY.)
	DOOR
	STRUCTURAL RETAINING WALL - (DESIGNED BY OTHERS)
	PROPOSED 0.5-FOOT GRADE CONTOUR (ONLY USED WHEN CRITICAL)
	PROPOSED 1-FOOT GRADE CONTOUR
	PROPOSED 5-FOOT GRADE CONTOUR
	PROPOSED SPOT GRADE
	PROPOSED TOP OF CURB
	PROPOSED FINISHED SURFACE GRADE ADJACENT TO TOP OF WALL
	PROPOSED FINISHED SURFACE GRADE ADJACENT TO BASE OF WALL
	PROPOSED EROSION CONTROL BALE
	PROPOSED TEMPORARY DITCH CHECK
	PROPOSED INLET PROTECTION
	PROPOSED SILT FENCE
	PROPOSED TEMPORARY DIVERSION SWALE & BERM
	PROPOSED LEVEL SPREADER
	PROPOSED STONE TRACKING MAT
	PROPOSED PERMANENT TURF REINFORCEMENT MAT
	EROSION CONTROL BLANKET
	PROPOSED RIPRAP
	PROPOSED GAS LINE
	PROPOSED ELECTRIC LINE
	PROPOSED TELEPHONE LINE
	PROPOSED WATER MAIN
	PROPOSED STORM SEWER
	PROPOSED SANITARY SEWER
	PROPOSED FIRE DEPARTMENT CONNECTION
	PROPOSED WATER VALVE
	PROPOSED FIRE HYDRANT
	PROPOSED INLET / CB
	PROPOSED STORM MANHOLE
	PROPOSED AREA DRAIN
	PROPOSED SANITARY MANHOLE

LEGEND

()	INDICATES RECORDED DIMENSION WHERE DIFFERENT FROM ACTUAL MEASUREMENT
OR SECTION OR 1/4 SECTION CORNER AS DESCRIBED	
1" DIA. IRON PIPE FOUND (UNLESS OTHERWISE NOTED)	
1" DIA. IRON PIPE, 18" LONG-SET (UNLESS OTHERWISE NOTED)	
BOLLARD	
SOIL BORING/MONITORING WELL	
FLAGPOLE	
MAILBOX	
SIGN	
BILLBOARD	
AIR CONDITIONER	
CONTROL BOX	
TRAFFIC SIGNAL	
RAILROAD CROSSING SIGNAL	
CABLE PEDESTAL	
POWER POLE	
GUY POLE	
GUY WIRE	
LIGHT POLE	
SPOT/YARD/PEDESTAL LIGHT	
HANDICAPPED PARKING	
ELECTRIC MANHOLE	
ELECTRIC PEDESTAL	
ELECTRIC METER	
ELECTRIC TRANSFORMER	
TELEPHONE MANHOLE	
TELEPHONE PEDESTAL	
MARKED FIBER OPTIC	
GAS VALVE	
GAS METER	
GAS WARNING SIGN	
STORM MANHOLE	
ROUND INLET	
SQUARE INLET	
STORM SEWER END SECTION	
SANITARY MANHOLE	
SANITARY CLEANOUT OR SEPTIC VENT	
SANITARY INTERCEPTOR MANHOLE	
MISCELLANEOUS MANHOLE	
WATER VALVE	
HYDRANT	
WATER SERVICE CURB STOP	
WATER MANHOLE	
WELL	
WATER SURFACE	
WETLANDS FLAG	
MARSH	
CONIFEROUS TREE	
DECIDUOUS TREE	
SHRUB	
-S-	EDGE OF TREES
-STO-	SANITARY SEWER
-W-	STORM SEWER
-C-	WATERMAIN
-E-	MARKED GAS MAIN
-OHW-	MARKED ELECTRIC
-B-	OVERHEAD WIRES
-T-	BUREAU ELEC. SERV.
-TV-	MARKED TELEPHONE
-FO-	MARKED CABLE TV LINE
-750-	MARKED FIBER OPTIC
x 780.55	INDICATES EXISTING CONTOUR ELEVATION
-----	INDICATES EXISTING SPOT ELEVATION
-----	EXISTING PROPERTY LINE
-----	EXISTING EASEMENT LINE

ENGINEER AND LANDSCAPE ARCHITECT:

raSmith

CREATIVITY BEYOND ENGINEERING

RYAN J. LANCOUR, P.E. PROJECT MANAGER
PH: (262) 317-3259

PROPERTY OWNER:

REALTY INCOME PROPERTIES 24, LLC
C/O RUSS DARROW AUTO GROUP
W133N8569 EXECUTIVE PKWY
MENOMONEE FALLS, WI 53051

DEVELOPER:

CHAD KEMNITZ, PRESIDENT
PROFESSIONAL CONSULTANTS, INC.
133 HILL ST.
HARTLAND, WI 53029
PH: (262) 367-6080

16745 W. Bluemound Road
Brookfield, WI 53005-5938
(262) 781-1000
rasmith.com

16745 W. Bluemound Road
Brookfield, WI 53005-5938

raSmith

CREATIVITY BEYOND ENGINEERING
rasmith.com

RUSS DARROW KIA WAUKESHA
WAUKESHA, WISCONSIN

COVER SHEET



1/21/2025

© COPYRIGHT 2025

R.A. Smith, Inc.

DATE: 1/21/2025

SCALE: NTS

JOB NO. 3200102.01

PROJECT MANAGER:
RYAN J. LANCOUR, P.E.

DESIGNED BY: CRR

CHECKED BY: RJL

SHEET NUMBER

C000

PLAT OF SURVEY W/ TOPOGRAPHIC DATA

KNOWN AS: 2141 E. MORELAND BOULEVARD, WAUKESHA, WISCONSIN

LOT 1 OF CERTIFIED SURVEY MAP NO. 12184, RECORDED IN WAUKESHA COUNTY REGISTER OF DEEDS OFFICE ON May 28, 2021, IN BOOK 124, PAGES 327-330, AS DOCUMENT NO. 4588107, BEING PART OF THE SOUTHEAST 1/4 OF THE NORTHEAST 1/4 OF SECTION 36, TOWNSHIP 7 NORTH, RANGE 19 EAST, IN THE CITY OF WAUKESHA, WAUKESHA COUNTY, WISCONSIN.

PREPARED FOR: PROFESSIONAL CONSULTANTS, INC.
SURVEY NO: 169065-KAC

NOTES:
-VERTICAL DATUM: NAVD 88, STARTING BENCHMARK: NORTHWEST CORNER OF NORTHWEST 1/4 OF SECTION 31, TOWNSHIP 7 NORTH, RANGE 20 EAST, FOUND CONCRETE MONUMENT WITH BRASS CAP, ELEVATION (CITY) 120.75+780.45= 901.20' NAVD 88
-HORIZONTAL DATUM: NAD83

I CERTIFY, that this survey was prepared under my supervision and is correct to the best of my professional knowledge and belief and complies with Chapter A-E 7 of the Wisconsin Administrative Code.

Date: June 18, 2024
Date of Revision: January 15, 2025

Eric R. Sturm

ERIC R. STURM
WISCONSIN PROFESSIONAL LAND SURVEYOR S-2309



LEGEND

- BOLLARD
- ⊕ SOIL BORING/MONITORING WELL
- ⚑ FLAGPOLE
- ✉ MAILBOX
- ⊞ SIGN
- ⊞ AIR CONDITIONER
- ⊞ CONTROL BOX
- ⊞ TRAFFIC SIGNAL
- ⊞ CABLE PEDESTAL
- ⊞ POWER POLE
- ⊞ GUY POLE
- ⊞ GUY WIRE
- ⊞ LIGHT POLE
- ⊞ SPOT/YARD/PEDESTAL LIGHT
- ⊞ HANDICAPPED PARKING
- ⊞ PULL BOX
- ⊞ ELECTRIC MANHOLE
- ⊞ ELECTRIC PEDESTAL
- ⊞ ELECTRIC METER
- ⊞ ELECTRIC TRANSFORMER
- ⊞ TELEPHONE MANHOLE
- ⊞ TELEPHONE PEDESTAL
- ⊞ UTILITY VAULT
- ⊞ GAS VALVE
- ⊞ GAS METER
- ⊞ GAS WARNING SIGN
- ⊞ STORM MANHOLE
- ⊞ ROUND INLET
- ⊞ SQUARE INLET
- ⊞ STORM SEWER END SECTION
- ⊞ SANITARY MANHOLE
- ⊞ SANITARY CLEANOUT OR SEPTIC VENT
- ⊞ SANITARY INTERCEPTOR MANHOLE
- ⊞ MISCELLANEOUS MANHOLE
- ⊞ IRRIGATION CONTROL BOX
- ⊞ WATER VALVE
- ⊞ HYDRANT
- ⊞ WATER SERVICE CURB STOP
- ⊞ WATER MANHOLE
- ⊞ WELL
- ⊞ WATER SURFACE
- ⊞ WETLANDS FLAG
- ⊞ MARSH
- ★ CONIFEROUS TREE
- DECIDUOUS TREE
- SHRUB
- EDGE OF TREES
- S—SANITARY SEWER
- STO—STORM SEWER
- W—WATERMAIN
- G—MARKED GAS MAIN
- E—MARKED ELECTRIC
- OHW—OVERHEAD WIRES
- B—BUREAU ELEC. SERV.
- T—MARKED TELEPHONE
- TV—MARKED CABLE TV LINE
- FO—MARKED FIBER OPTIC
- (P)—UTILITY PER PLAN
- INDICATES EXISTING CONTOUR ELEVATION
- 780.55 INDICATES EXISTING SPOT ELEVATION


DIGGERS HOTLINE TICKET NOS: 20242025334 & 5345

THE UNDERGROUND UTILITY INFORMATION AS SHOWN HEREON IS BASED, IN PART, UPON INFORMATION FURNISHED BY UTILITY COMPANIES AND THE LOCAL MUNICIPALITY. WHILE THIS INFORMATION IS BELIEVED TO BE RELIABLE, ITS ACCURACY AND COMPLETENESS CANNOT BE GUARANTEED NOR CERTIFIED TO.

(P) INDICATES PIPE SIZES PER RECORD PLANS. OTHER PIPE SIZES ARE ESTIMATED. NO PIPE SIZES SHOULD BE RELIED UPON WITHOUT FURTHER VERIFICATION.


R.A.SMITH, INC. ASSUMES NO RESPONSIBILITY FOR DAMAGES, LIABILITY OR COSTS RESULTING FROM CHANGES OR ALTERATIONS MADE TO THIS PLAN WITHOUT THE EXPRESSED WRITTEN CONSENT OF R.A.SMITH, INC.


ALL COPYRIGHTS TO THESE DRAWINGS ARE RESERVED. THEY MAY NOT BE COPIED, CHANGED, OR ASSIGNED TO ANY THIRD PARTY IN ANY MANNER WITHOUT OBTAINING THE EXPRESSED WRITTEN PERMISSION OF R.A.SMITH, INC.

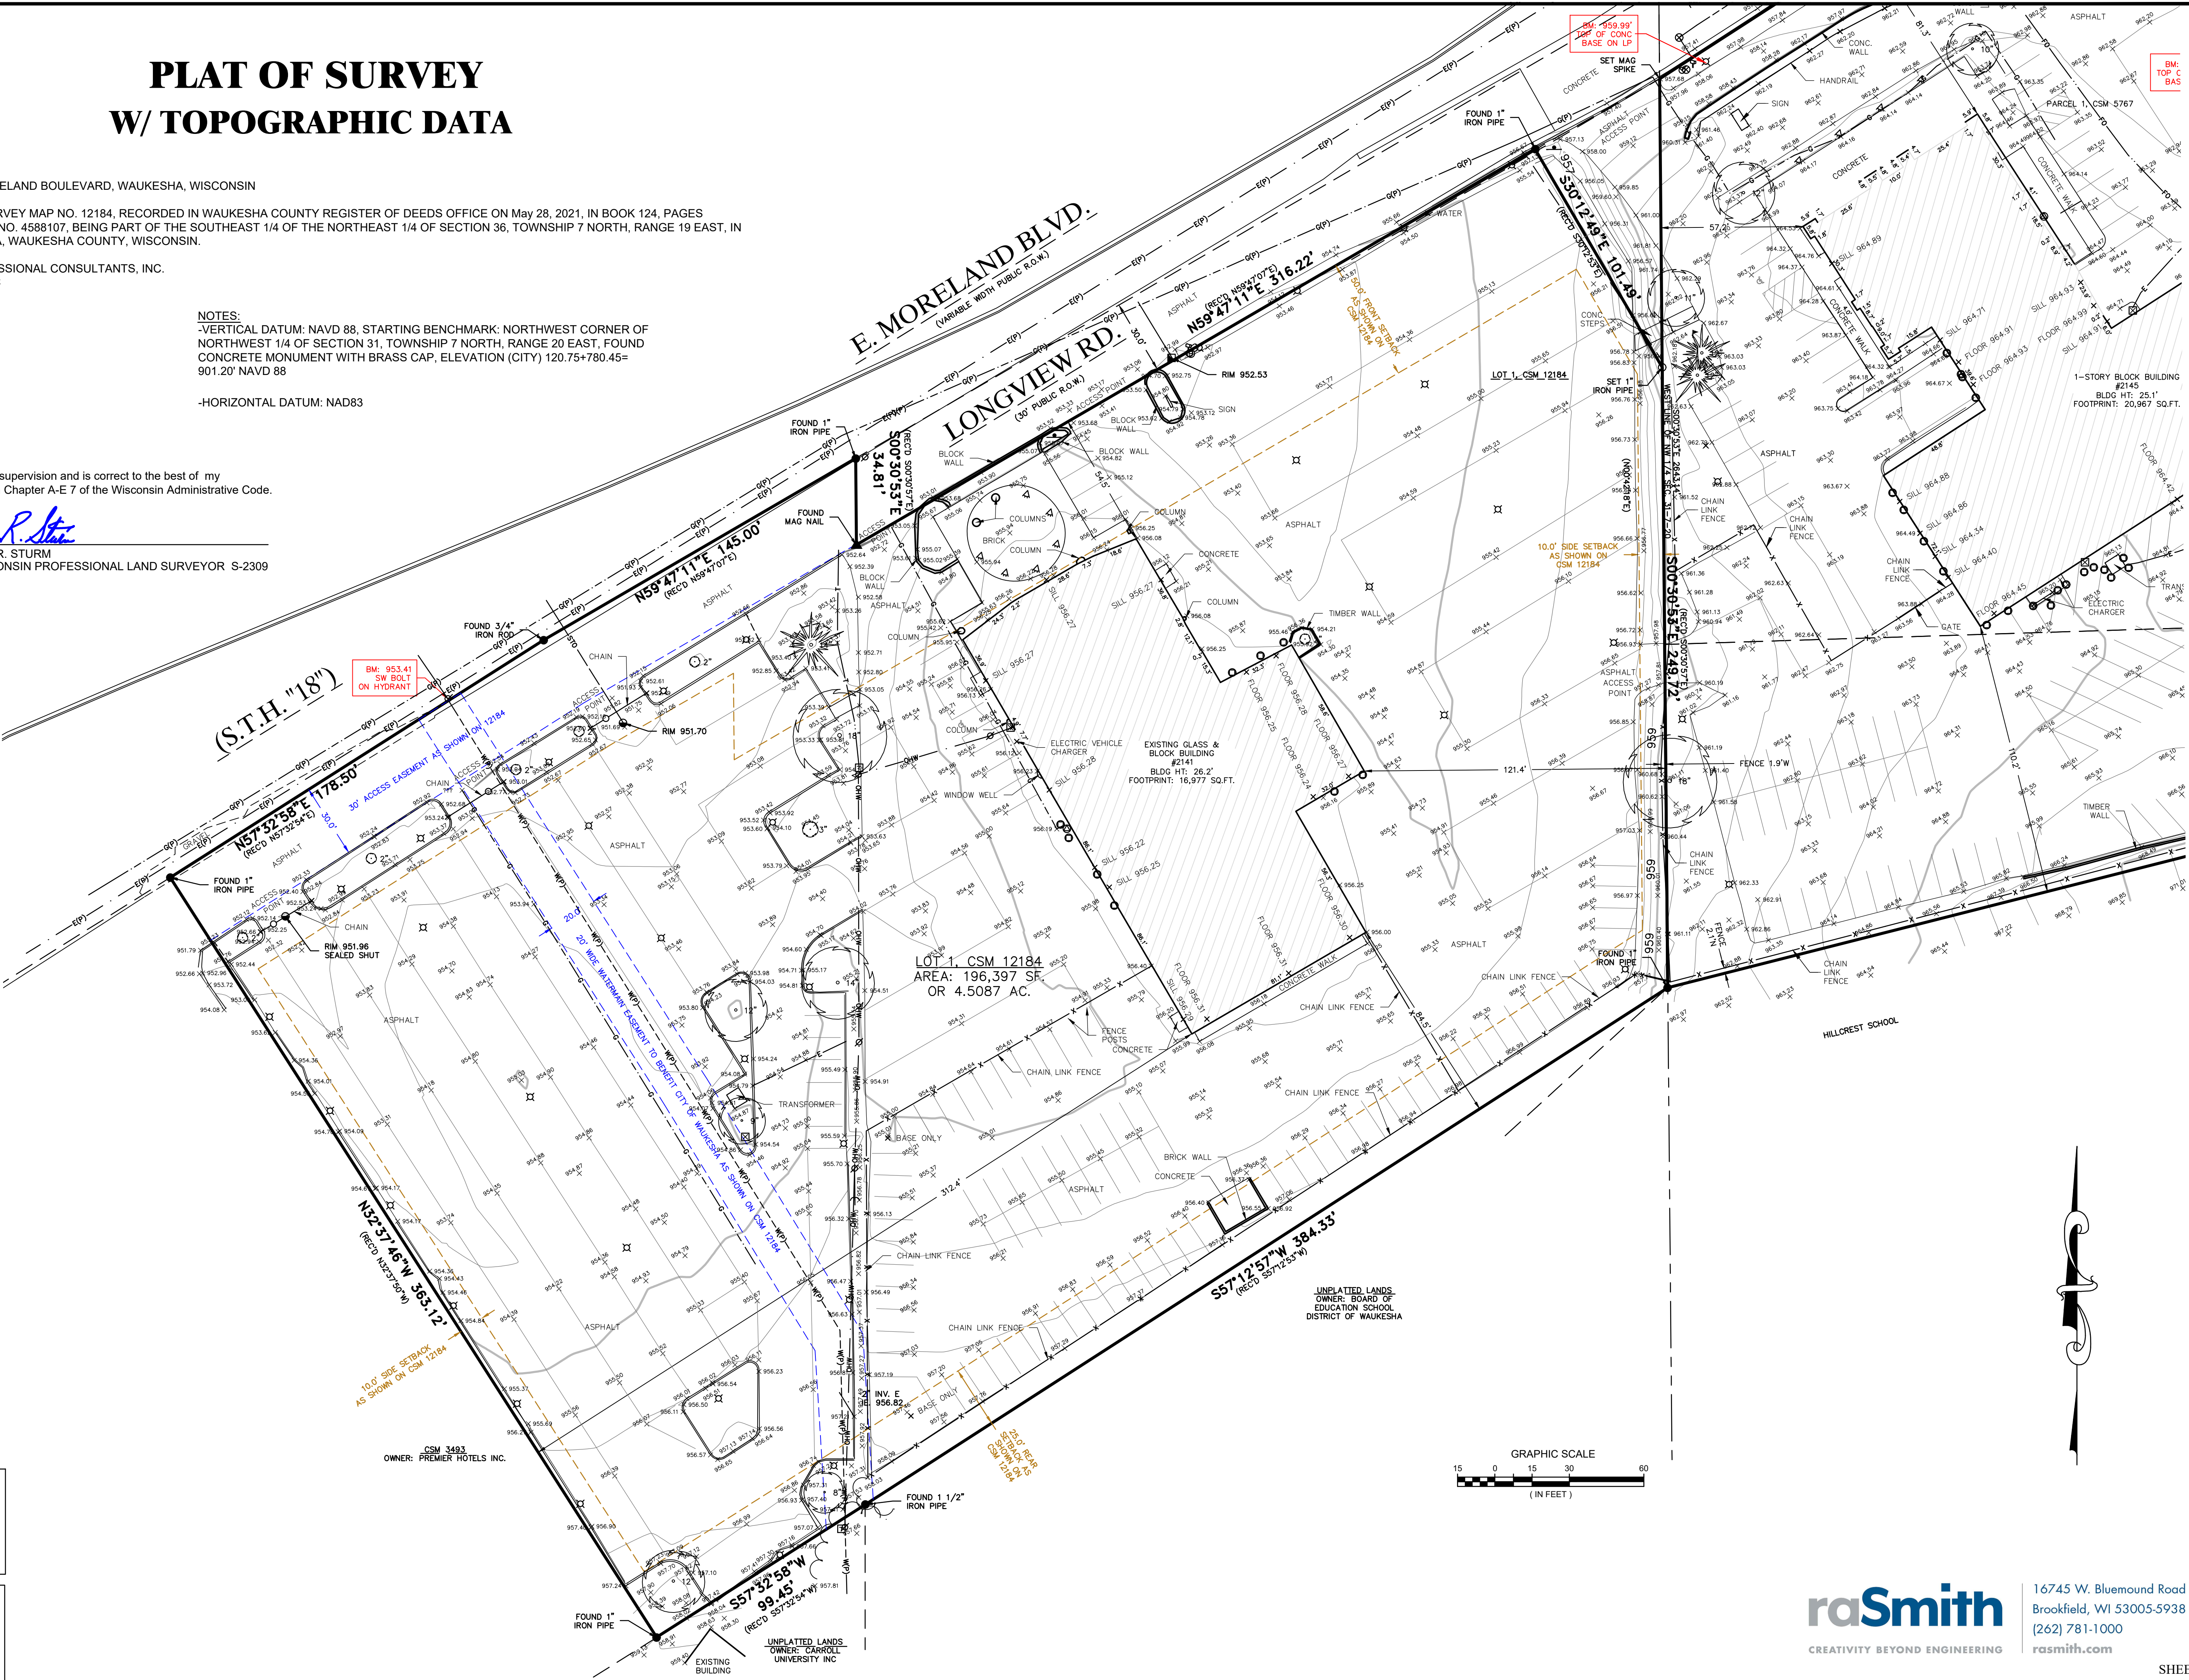


raSmith
CREATIVITY BEYOND ENGINEERING

 
16745 W. Bluemound Road
Brookfield, WI 53005-5938
(262) 781-1000
rasmith.com



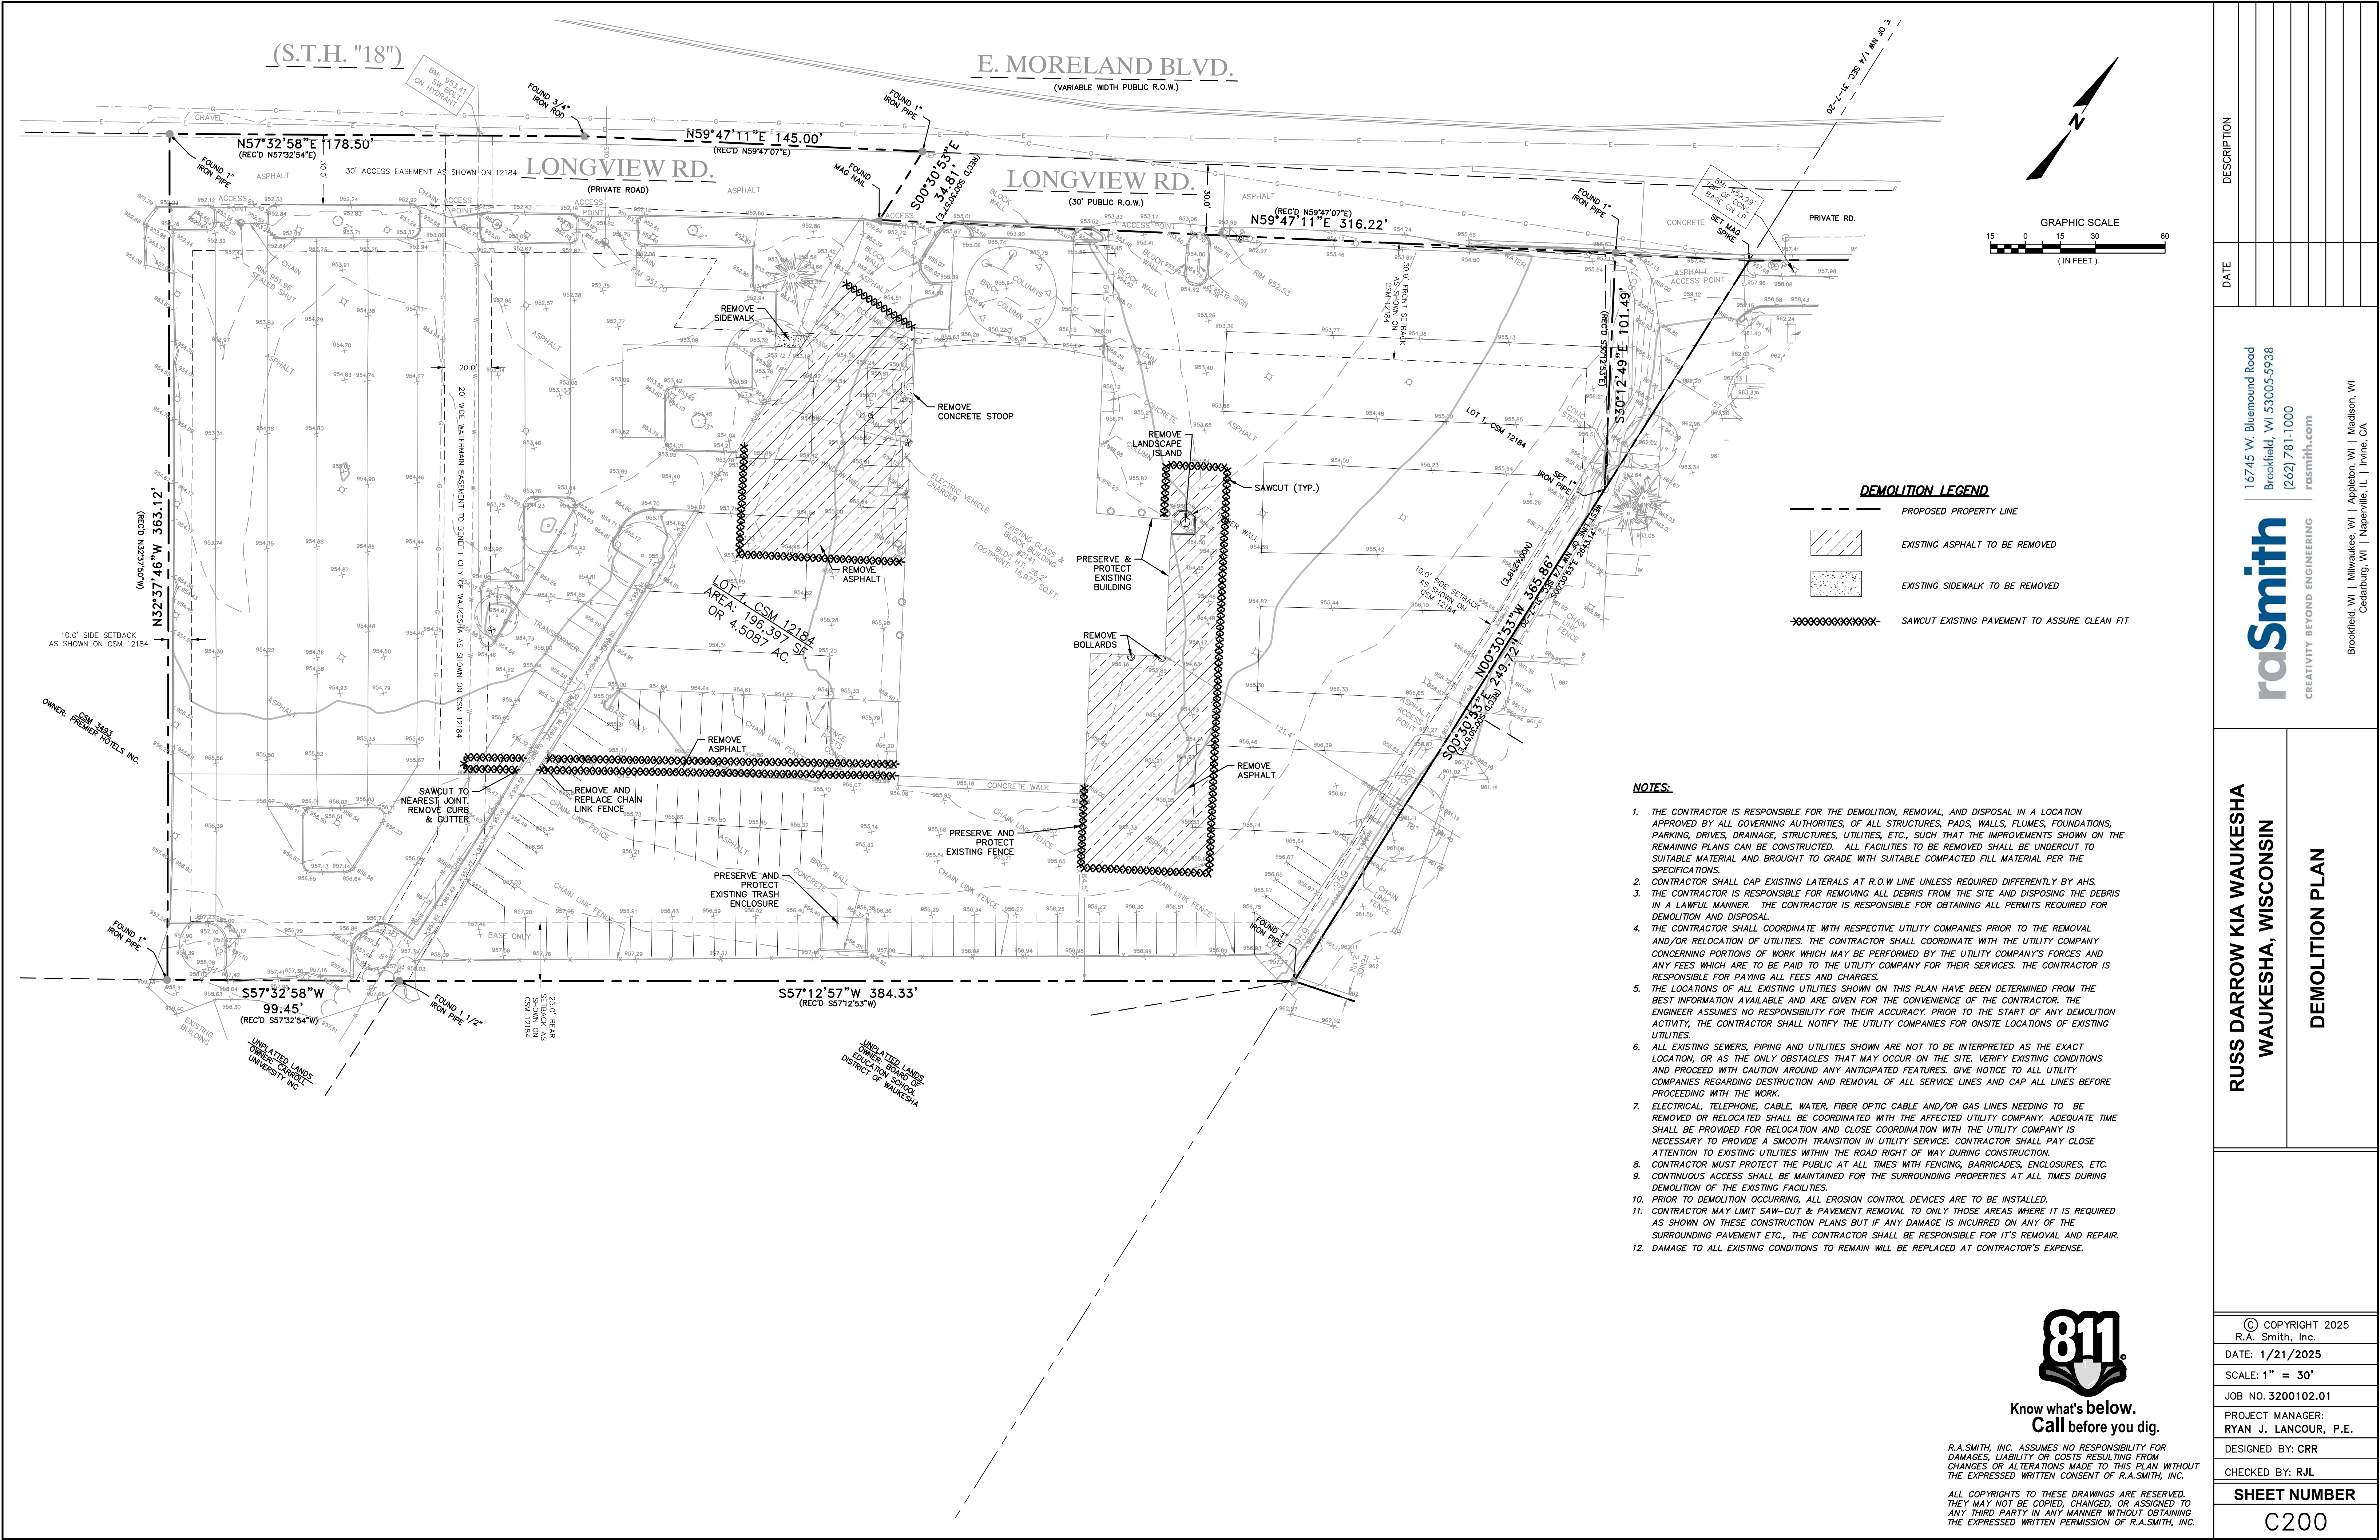


P:\3200102\3200102.01\Qing\Sheets\3200102.01 DP01.dwg, Demo, 1/21/2025 3:23:03 PM, crr

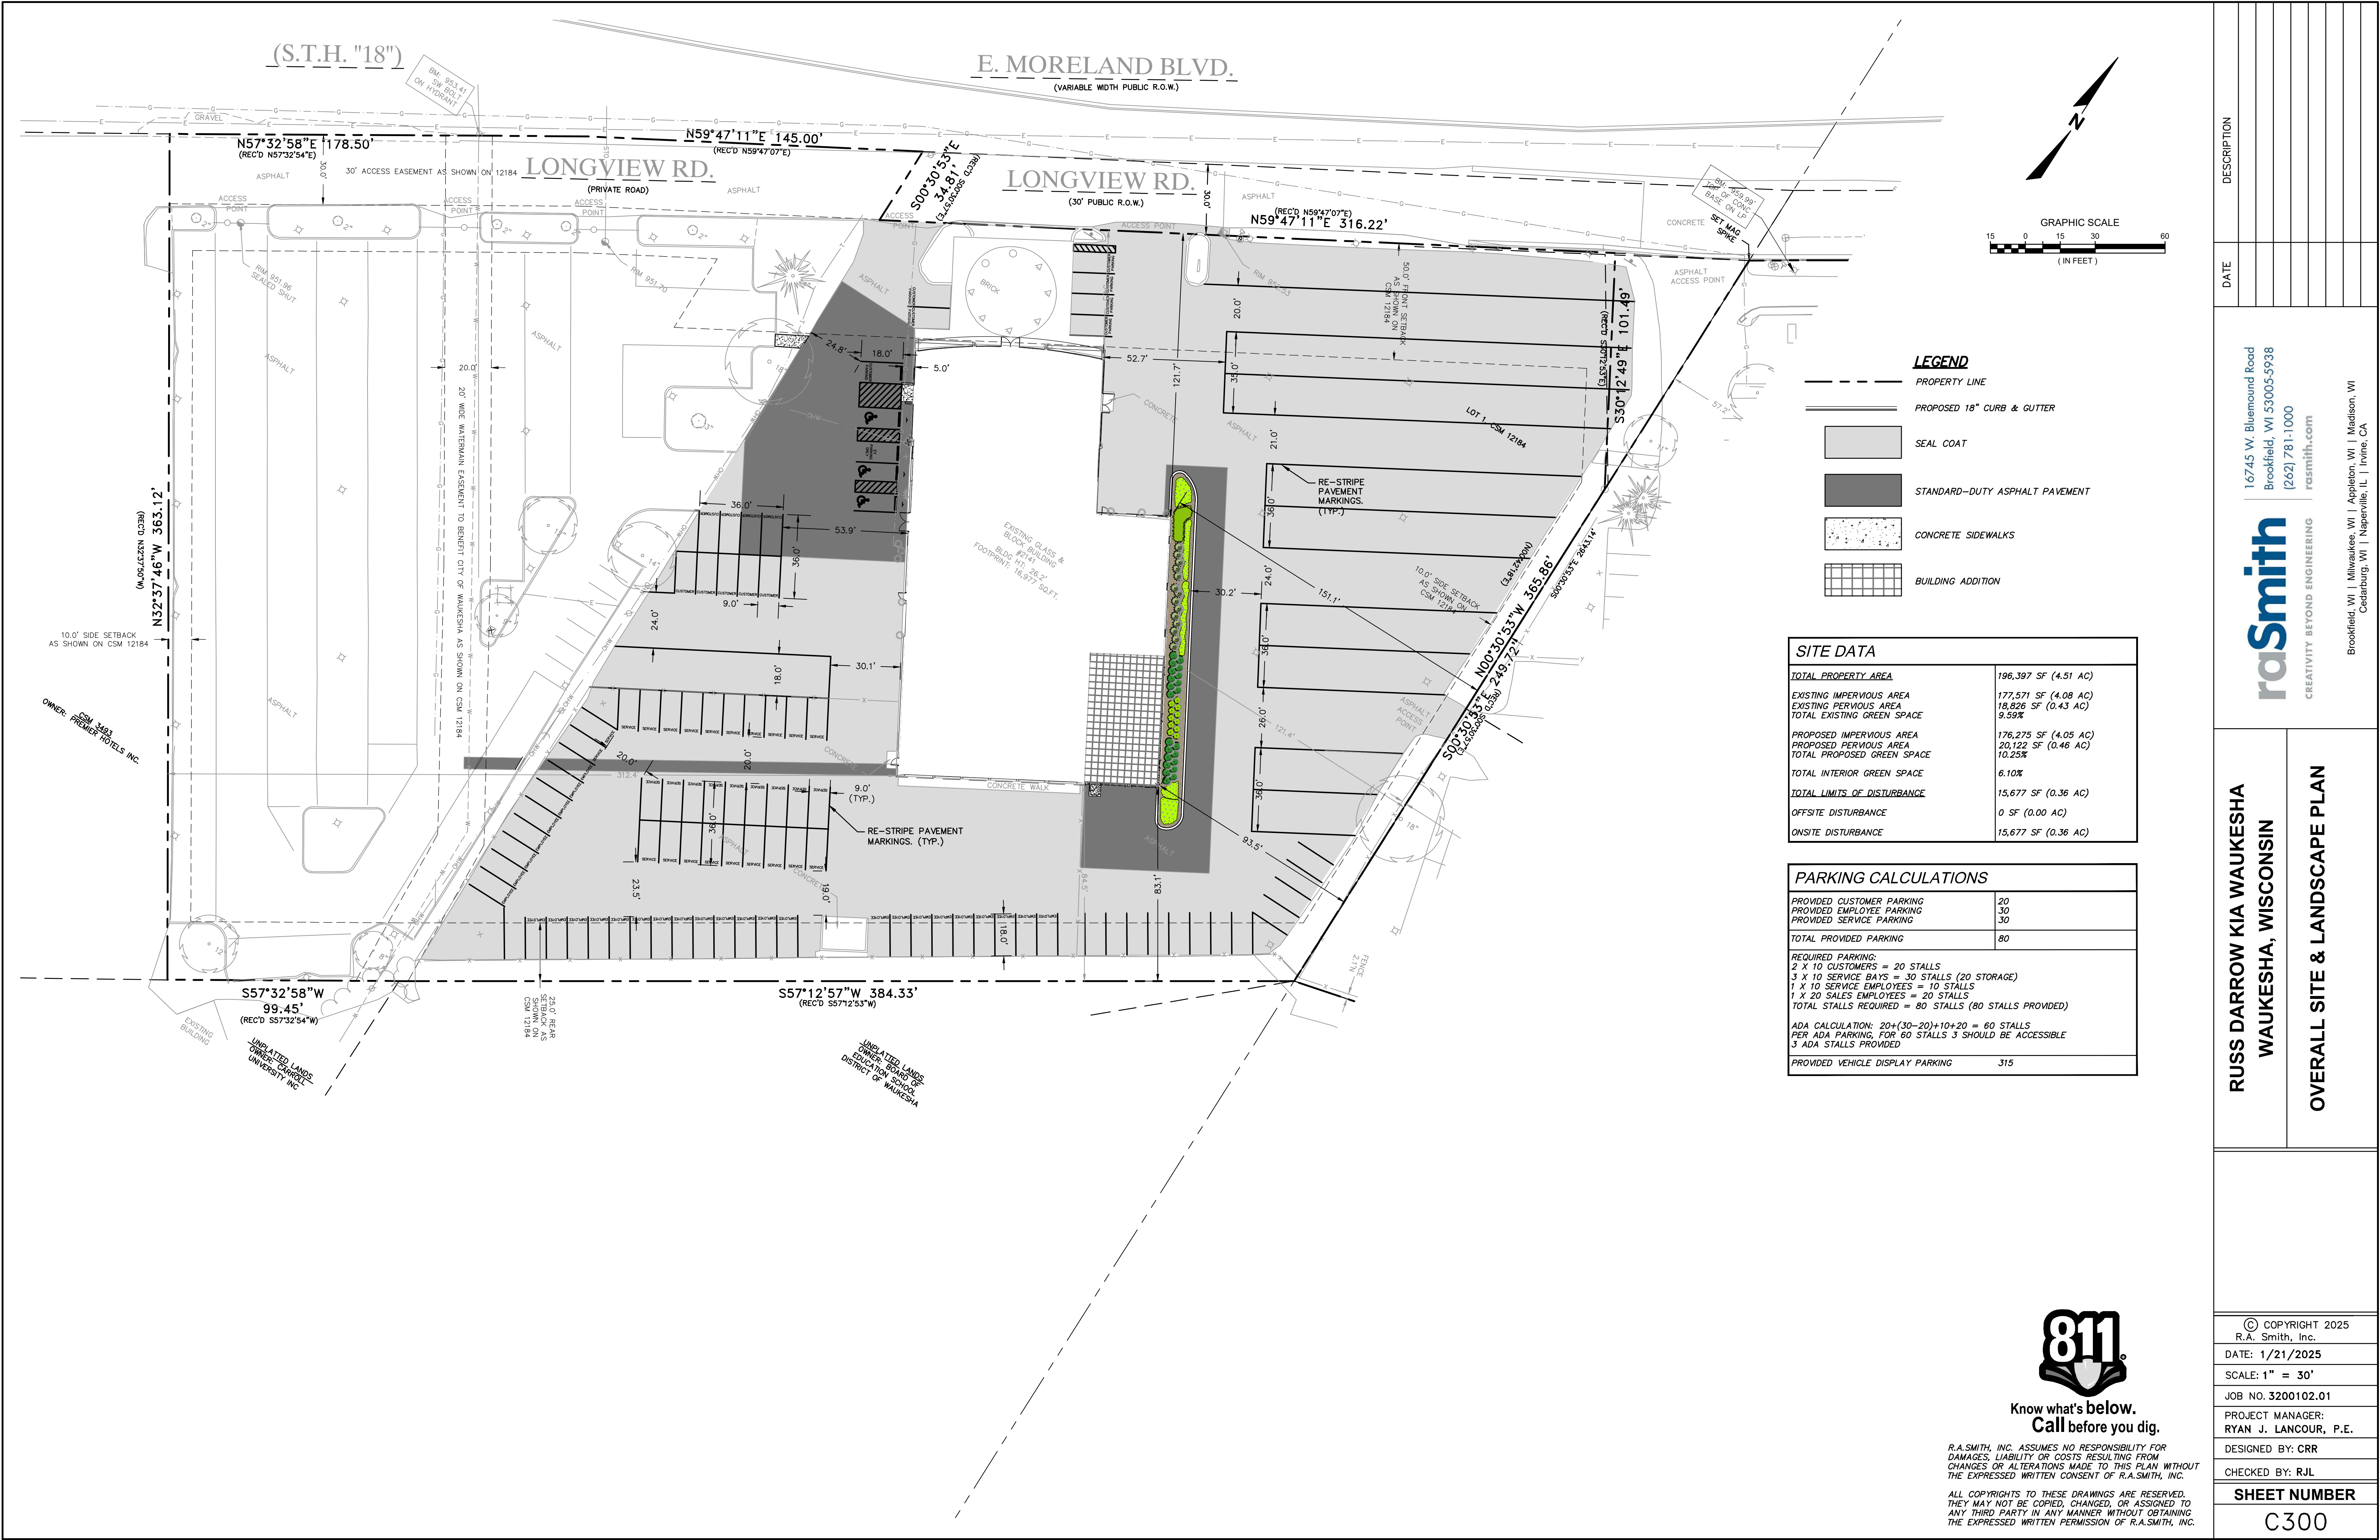

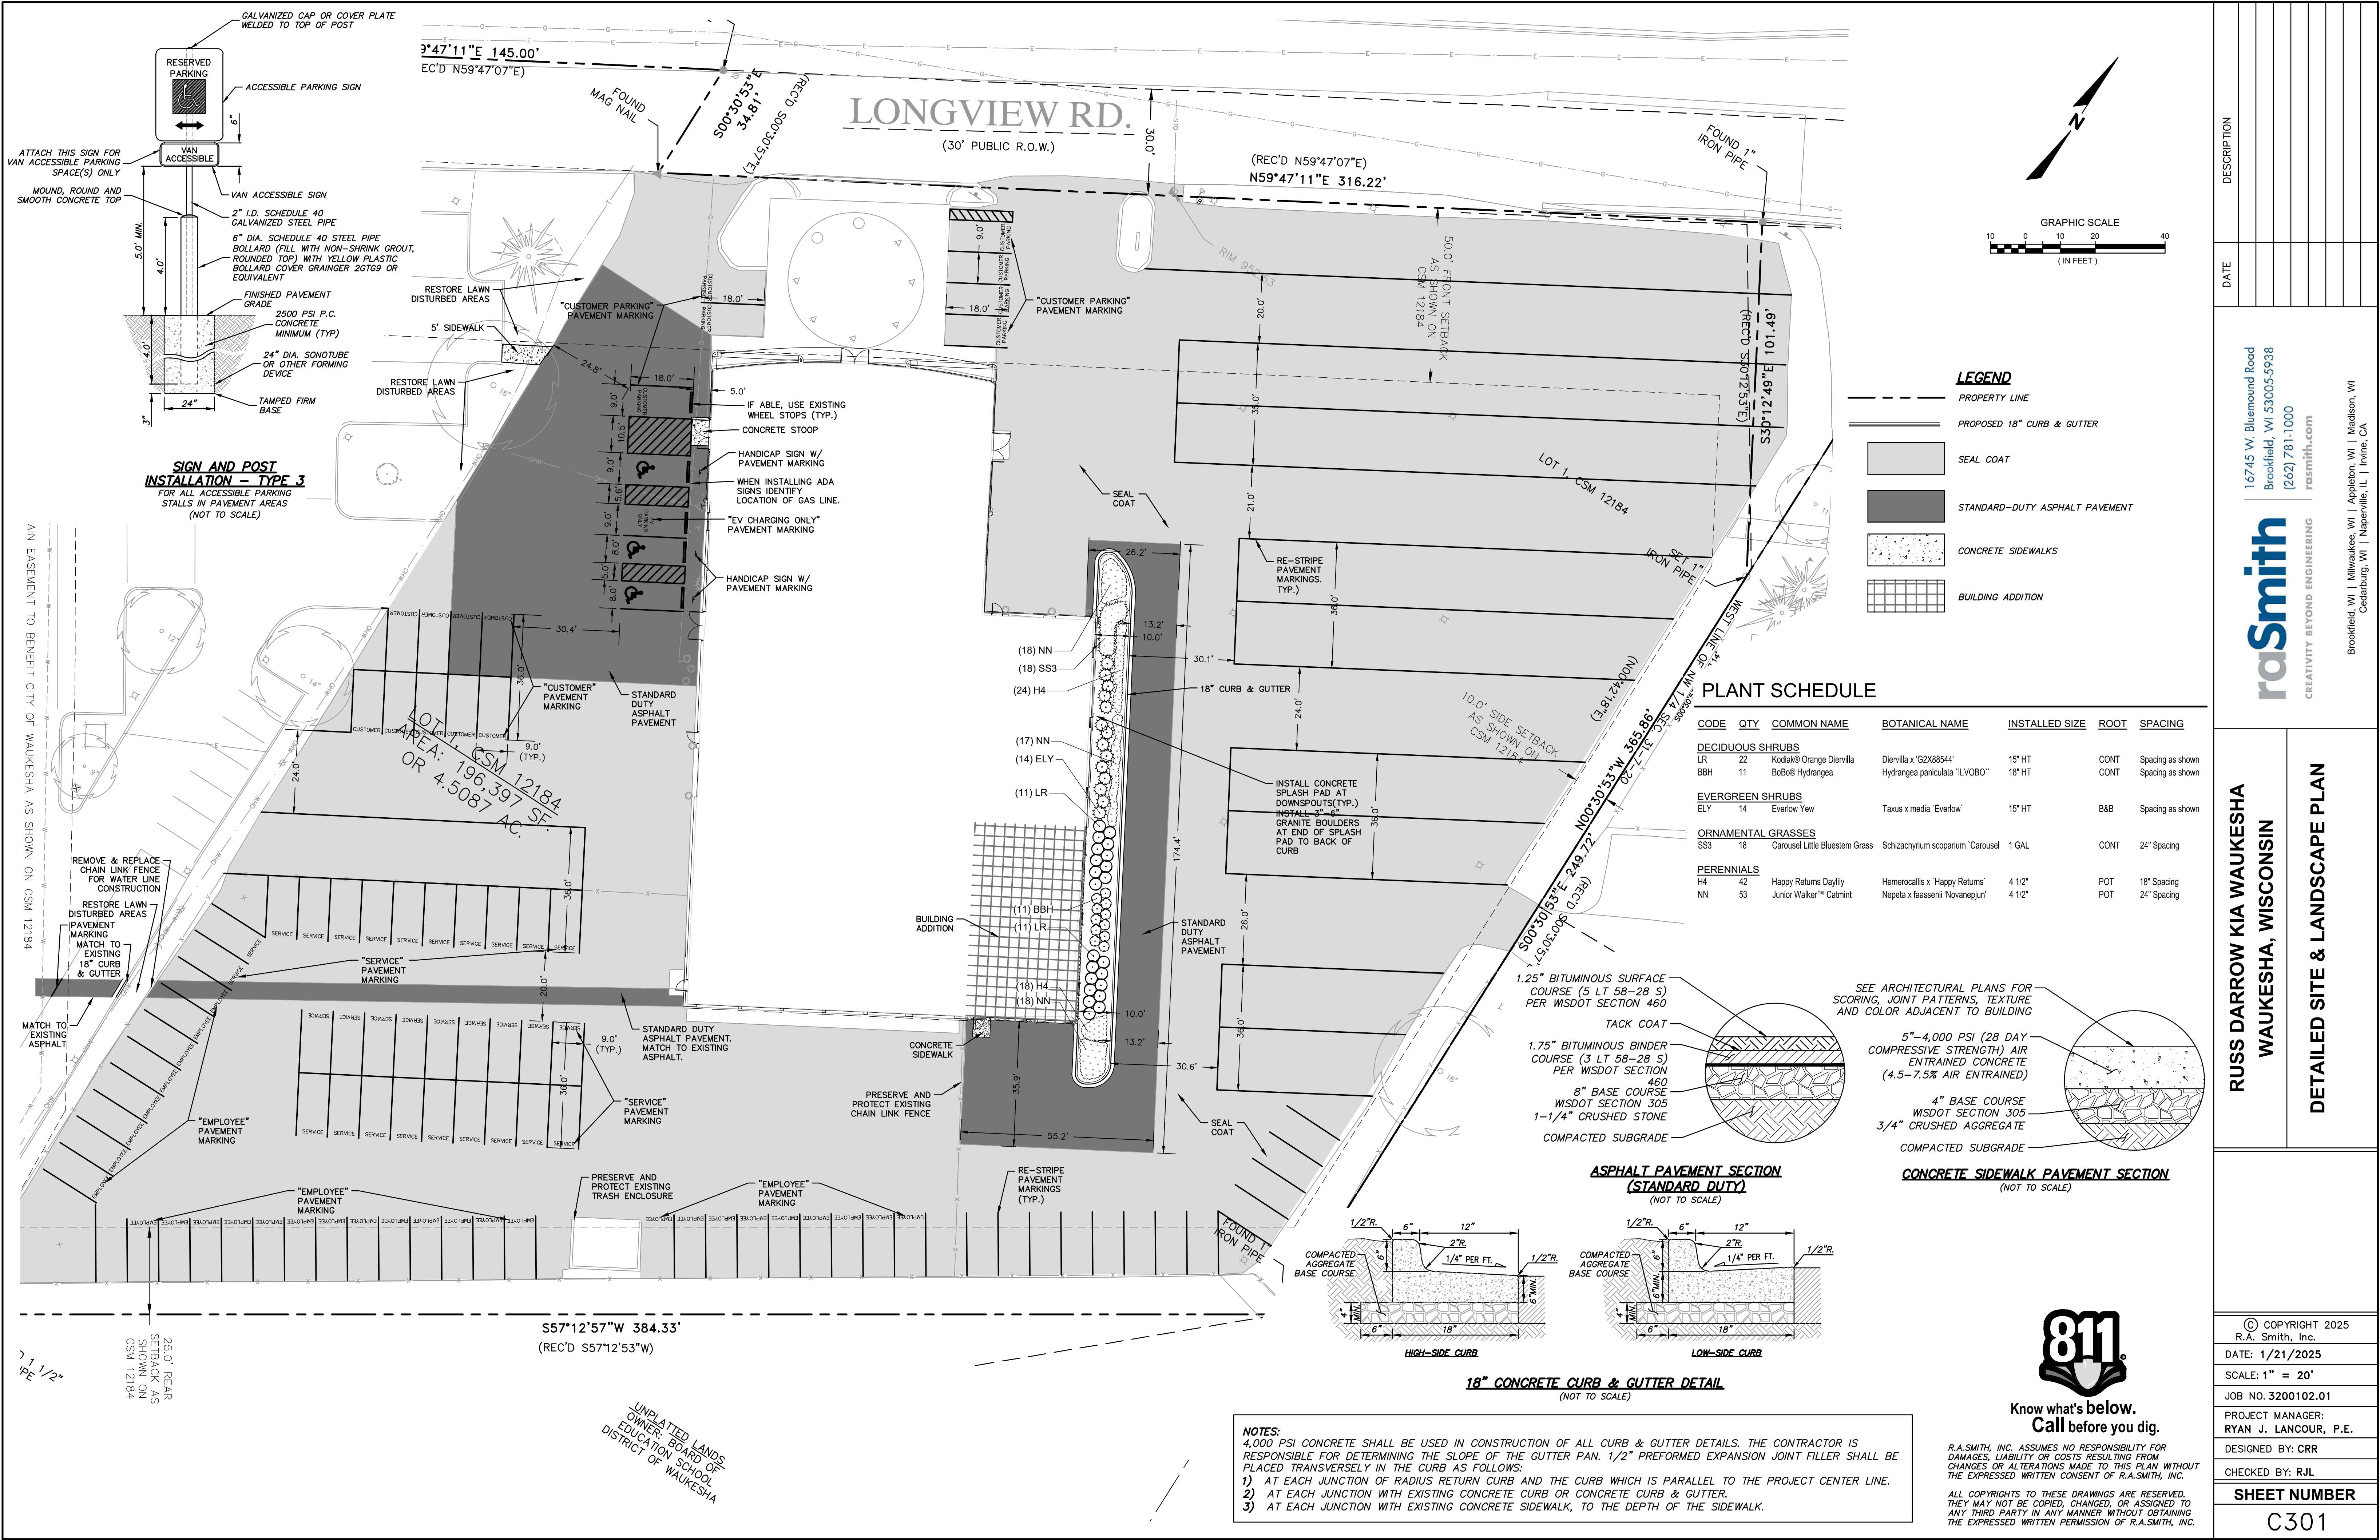

DESCRIPTION	
DATE	
16745 W. Bluemound Road Brookfield, WI 53005-5938 (262) 781-1000 rasmith.com	
raSmith CREATIVITY BEYOND ENGINEERING	
Brookfield, WI Milwaukee, WI Appleton, WI Madison, WI Cedarburg, WI Naperville, IL Irvine, CA	
RUSS DARROW KIA WAUKESHA WAUKESHA, WISCONSIN	
DETAILED SITE & LANDSCAPE PLAN	
© COPYRIGHT 2025 R.A. Smith, Inc.	
DATE: 1/21/2025	
SCALE: 1" = 20'	
JOB NO. 3200102.01	
PROJECT MANAGER: RYAN J. LANCOUR, P.E.	
DESIGNED BY: CRR	
CHECKED BY: RJL	
SHEET NUMBER	
C301	

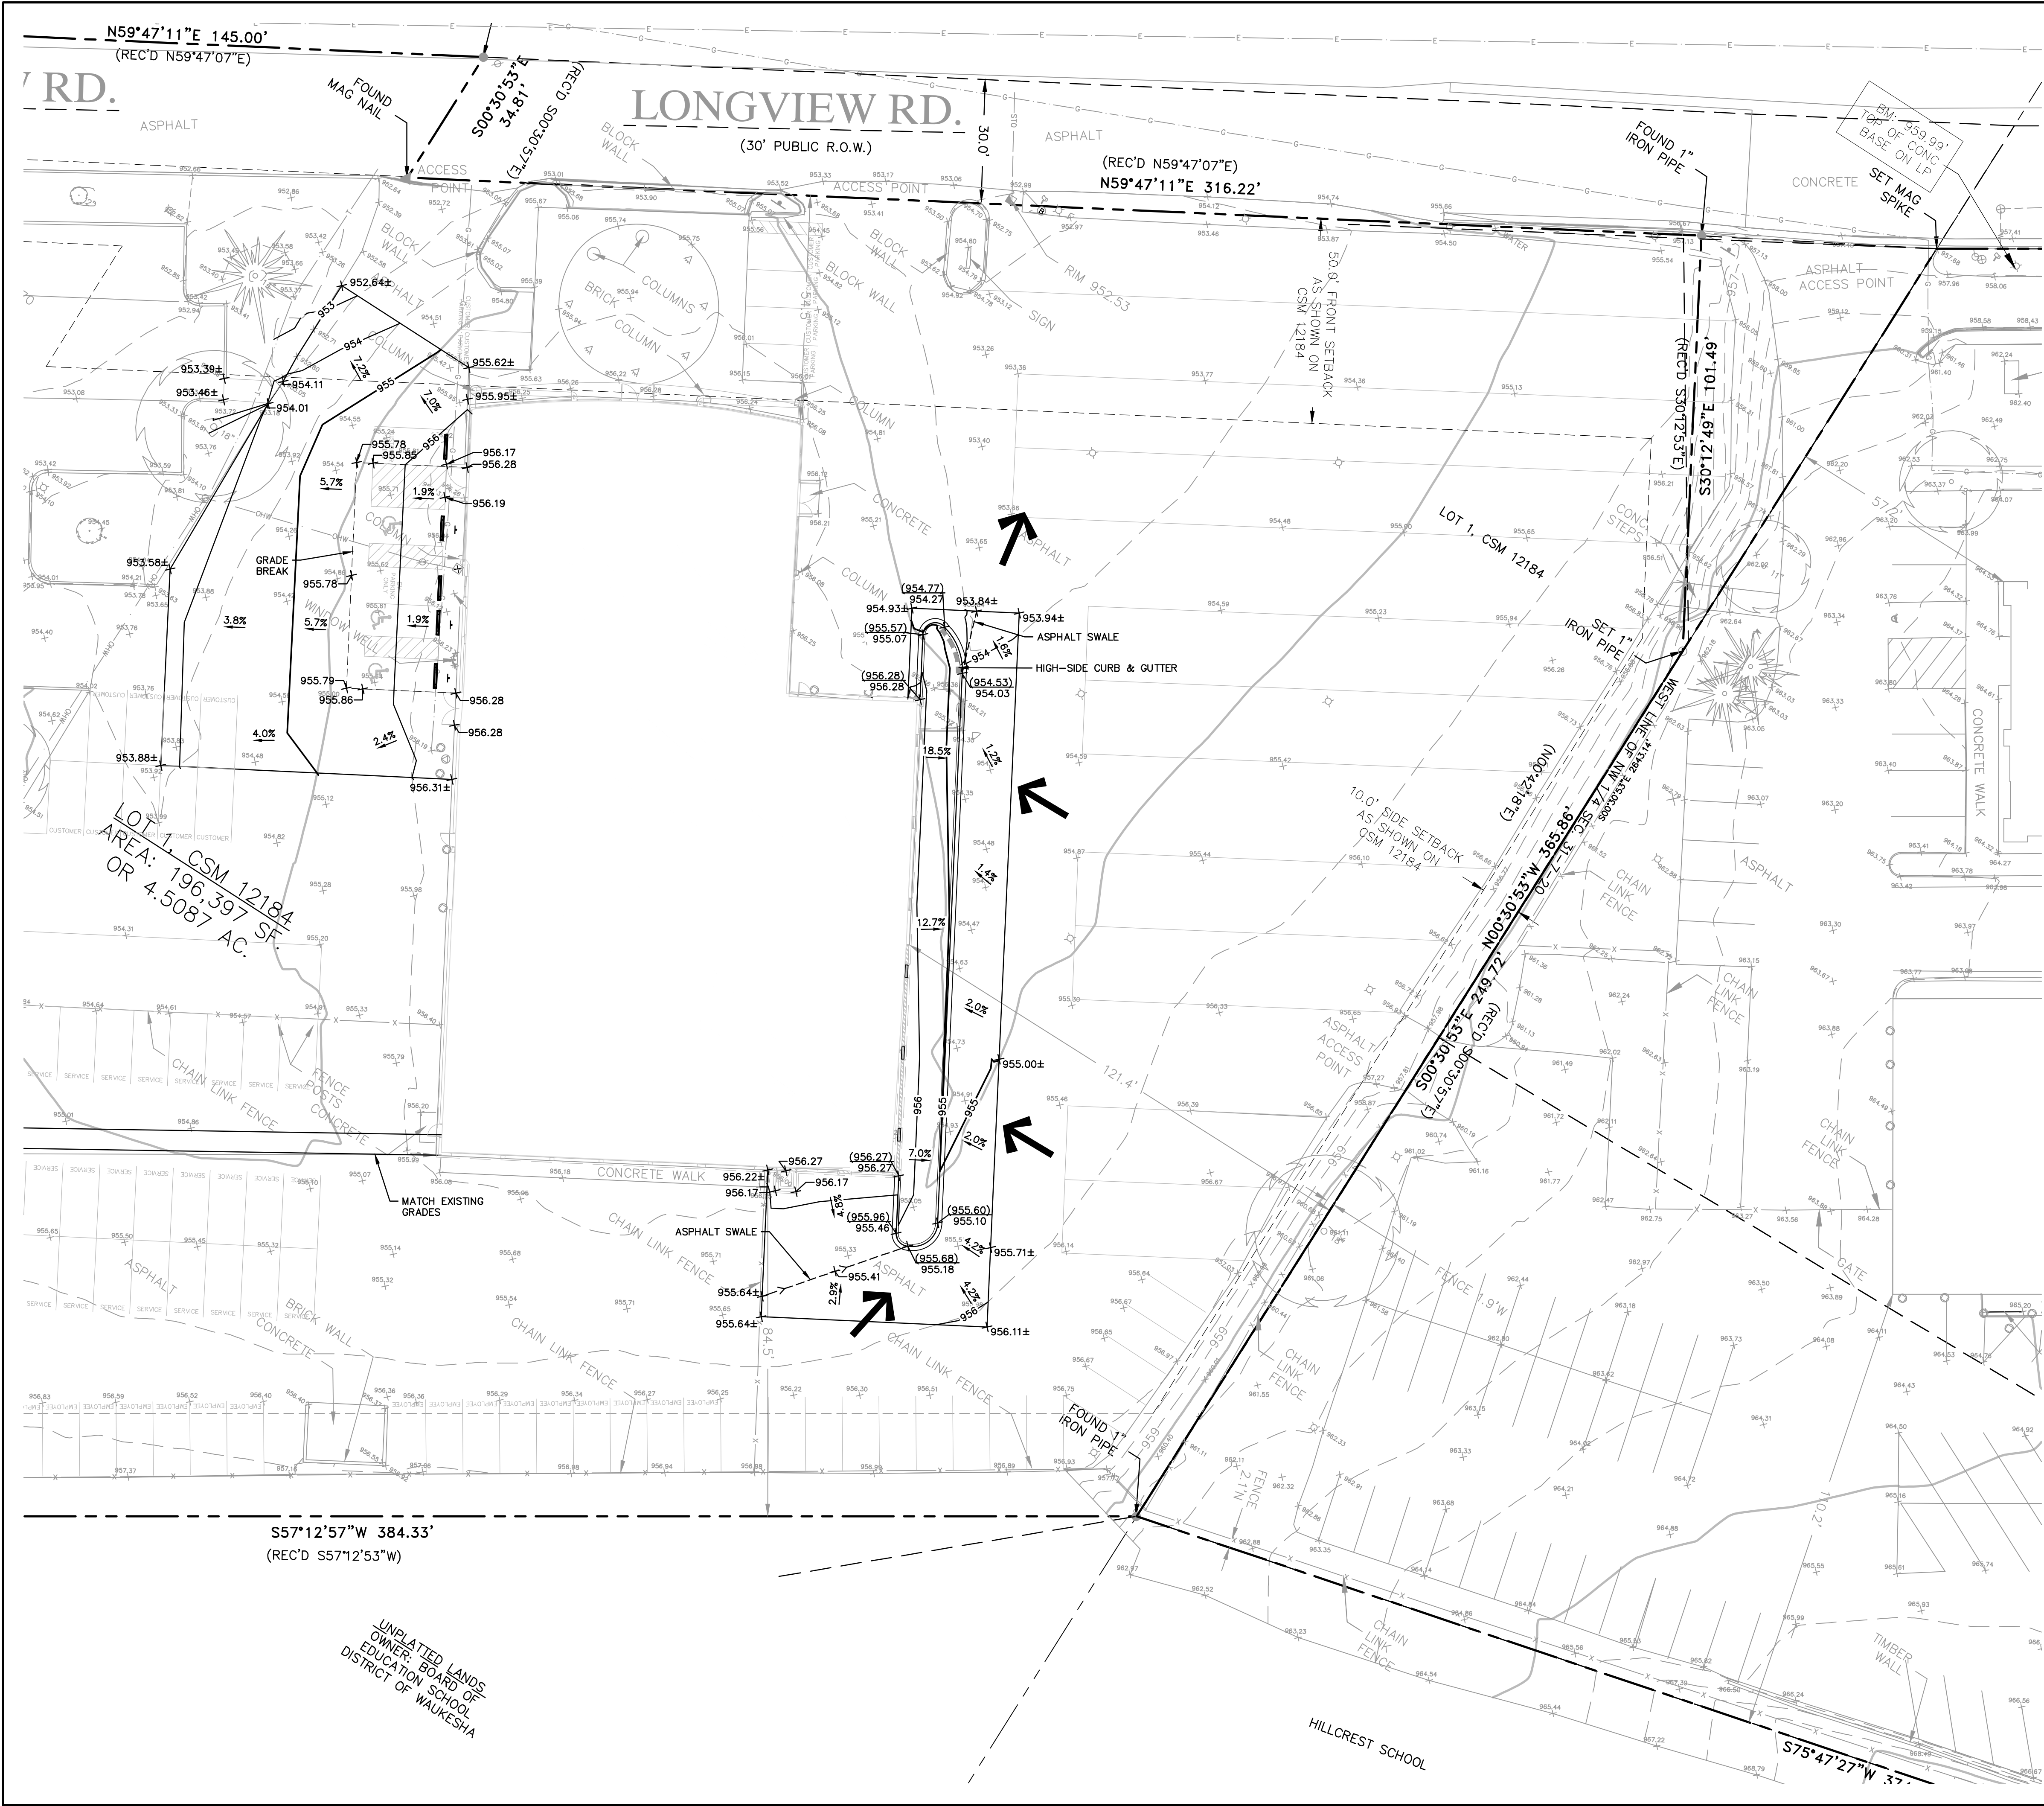

LEGEND

- PROPERTY LINE
- PROPOSED 18" HIGH-SIDE CURB & GUTTER
- PROPOSED 1-FOOT GRADE CONTOUR
- PROPOSED 5-FOOT GRADE CONTOUR
- PROPOSED SPOT GRADE
- PROPOSED TOP OF CURB
- EXISTING CONTOUR ELEVATION
- EXISTING SPOT ELEVATION
- OVERLAND FLOW ROUTE

GRADING NOTES:



- ALL SIDEWALKS TO BE SLOPED AT LESS THAN 5.0% AND NO MORE THAN 2.0% CROSS SLOPE
- THE PROPOSED IMPROVEMENTS SHALL BE CONSTRUCTED ACCORDING TO THE D.O.T. STANDARD SPECIFICATIONS, LOCAL ORDINANCES AND SPECIFICATIONS, AND RECOMMENDATIONS IN THE GEOTECHNICAL REPORT.
- THE CONTRACTOR SHALL MAINTAIN SITE DRAINAGE THROUGHOUT CONSTRUCTION. THIS MAY INCLUDE THE EXCAVATION OF TEMPORARY DITCHES OR PUMPING TO ALLEVIATE WATER PONDING.
- SILT FENCE AND OTHER EROSION CONTROL FACILITIES MUST BE INSTALLED PRIOR TO CONSTRUCTION OR ANY OTHER LAND DISTURBING ACTIVITY. THE CONTRACTOR SHALL BE RESPONSIBLE FOR REMOVING ALL EROSION CONTROL FACILITIES ONCE THE THREAT OF EROSION HAS PASSED WITH THE APPROVAL OF THE GOVERNING AGENCY.
- THE CONTRACTOR SHALL ASSUME SOLE RESPONSIBILITY FOR THE COMPUTATIONS OF ALL GRADING AND FOR ACTUAL LAND BALANCE, INCLUDING UTILITY TRENCH SPOIL. THE CONTRACTOR SHALL IMPORT OR EXPORT MATERIAL AS NECESSARY TO COMPLETE THE PROJECT.
- GRADING SHALL CONSIST OF CLEARING AND GRUBBING EXISTING VEGETATION, STRIPPING TOPSOIL, REMOVAL OF EXISTING PAVEMENT OR FOUNDATIONS, IMPORTING OR EXPORTING MATERIAL TO ACHIEVE AND ON-SITE EARTHWORK BALANCE, GRADING THE PROPOSED BUILDING PAD AND PAVEMENT AREAS, SCARPING AND FINAL COMPACTION OF THE PAVEMENT SUBGRADE, AND PLACEMENT OF TOPSOIL.
- NO FILL SHALL BE PLACED ON A WET OR SOFT SUBGRADE. THE SUBGRADE SHALL BE PROOF-ROLLED AND INSPECTED BY THE GEOTECHNICAL ENGINEER BEFORE ANY MATERIAL IS PLACED.




Know what's below.
Call before you dig.

R.A. SMITH, INC. ASSUMES NO RESPONSIBILITY FOR DAMAGES, LIABILITY OR COSTS RESULTING FROM CHANGES OR ALTERATIONS MADE TO THIS PLAN WITHOUT THE EXPRESSED WRITTEN CONSENT OF R.A. SMITH, INC.
ALL COPYRIGHTS TO THESE DRAWINGS ARE RESERVED. THEY MAY NOT BE COPIED, CHANGED, OR ASSIGNED TO ANY THIRD PARTY IN ANY MANNER WITHOUT OBTAINING THE EXPRESSED WRITTEN PERMISSION OF R.A. SMITH, INC.

DESCRIPTION	
DATE	
16745 W. Bluemound Road Brookfield, WI 53005-5938 (262) 781-1000 rasmith.com	
raSmith CREATIVITY BEYOND ENGINEERING	
Brookfield, WI Milwaukee, WI Appleton, WI Madison, WI Cedarburg, WI Naperville, IL Irvine, CA	
RUSS DARROW KIA WAUKESHA WAUKESHA, WISCONSIN	GRADING PLAN
© COPYRIGHT 2025 R.A. Smith, Inc. DATE: 1/21/2025 SCALE: 1" = 20' JOB NO. 3200102.01 PROJECT MANAGER: RYAN J. LANCOUR, P.E. DESIGNED BY: CRR CHECKED BY: RJL	SHEET NUMBER C400

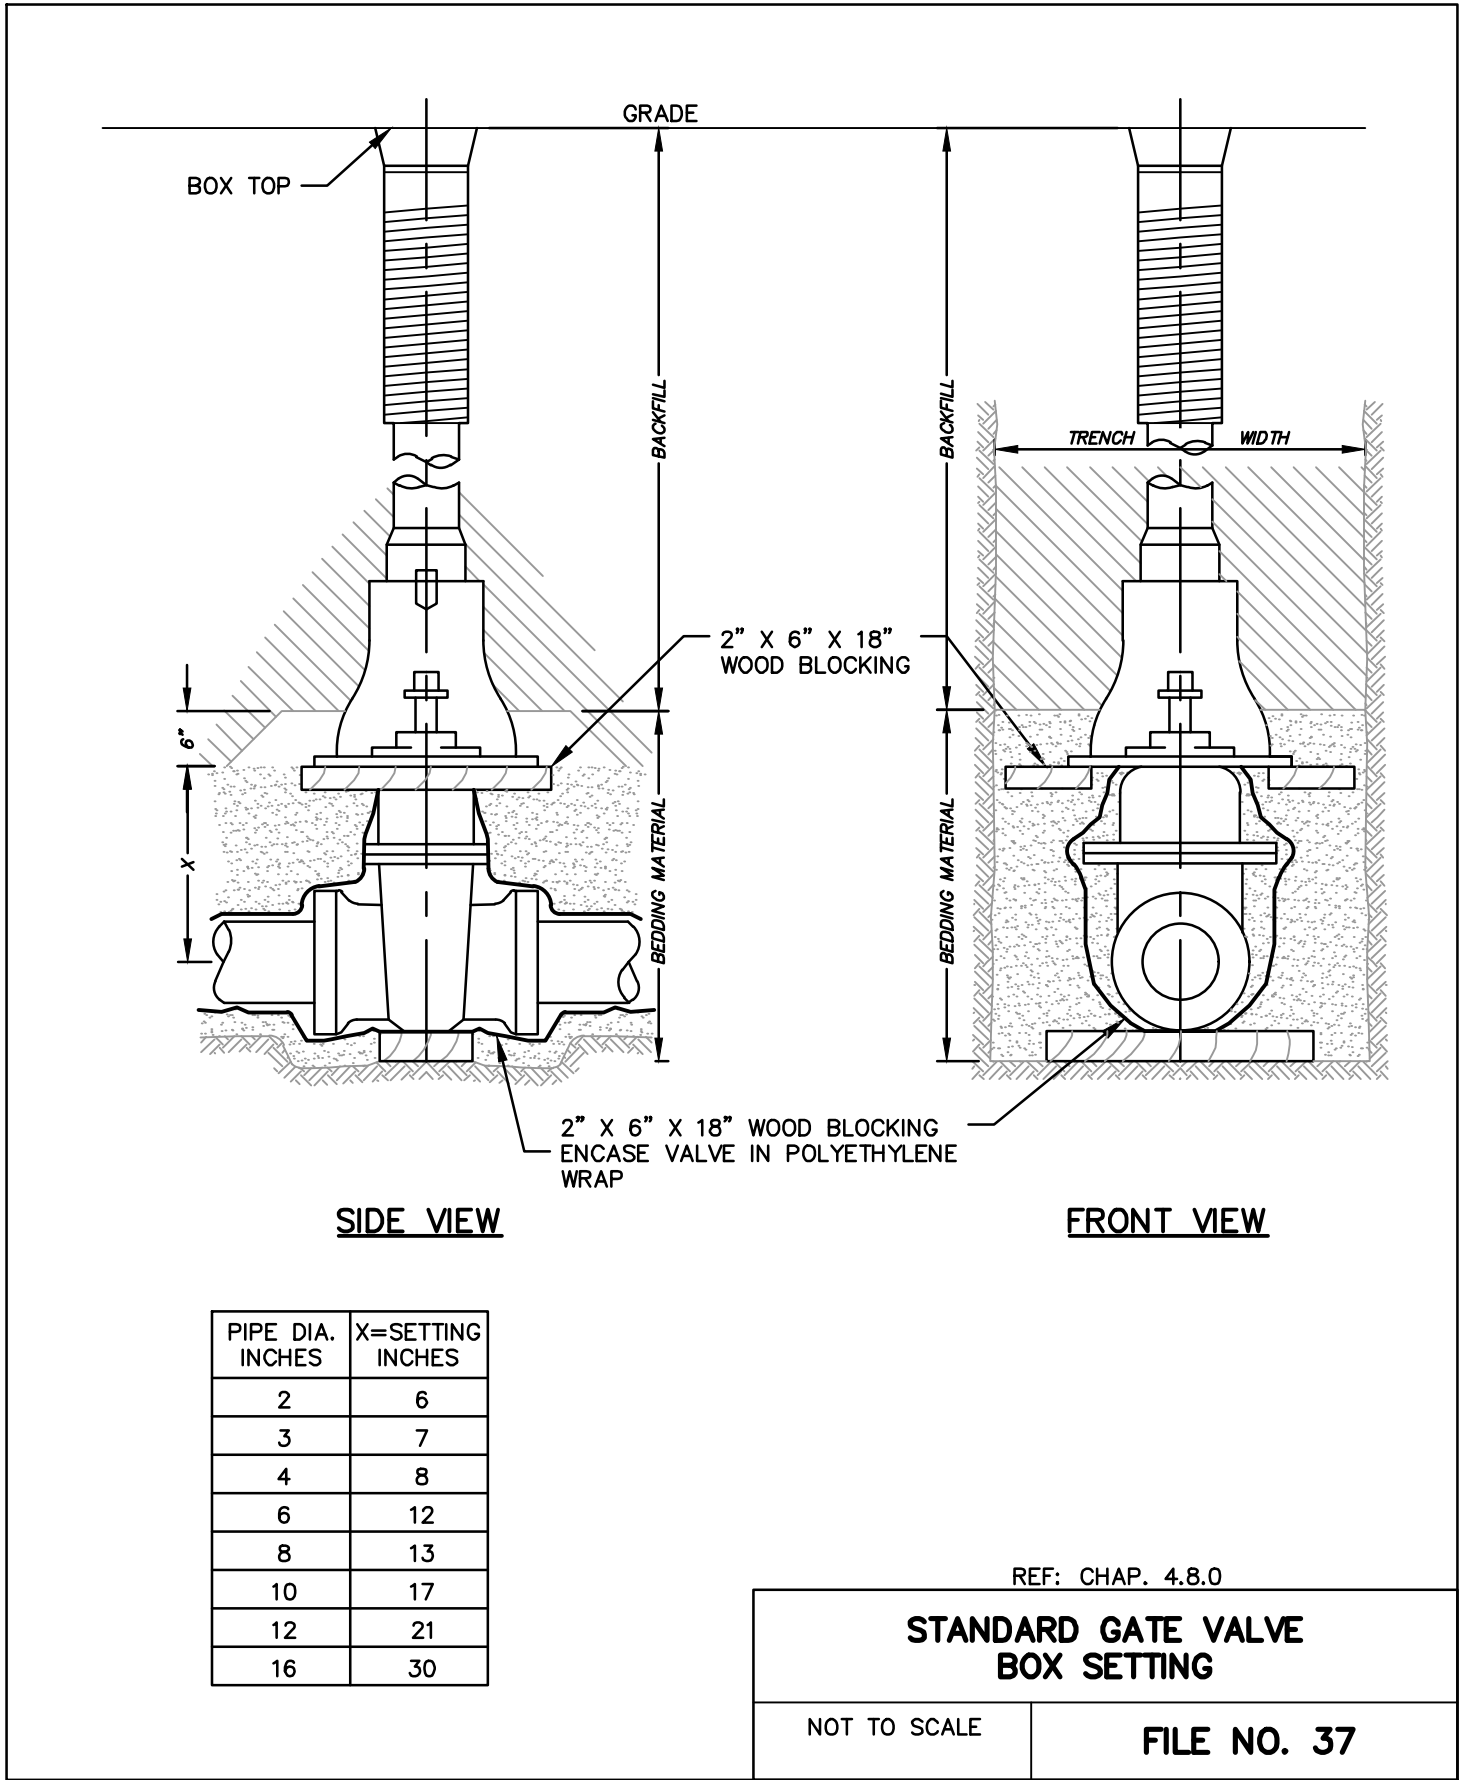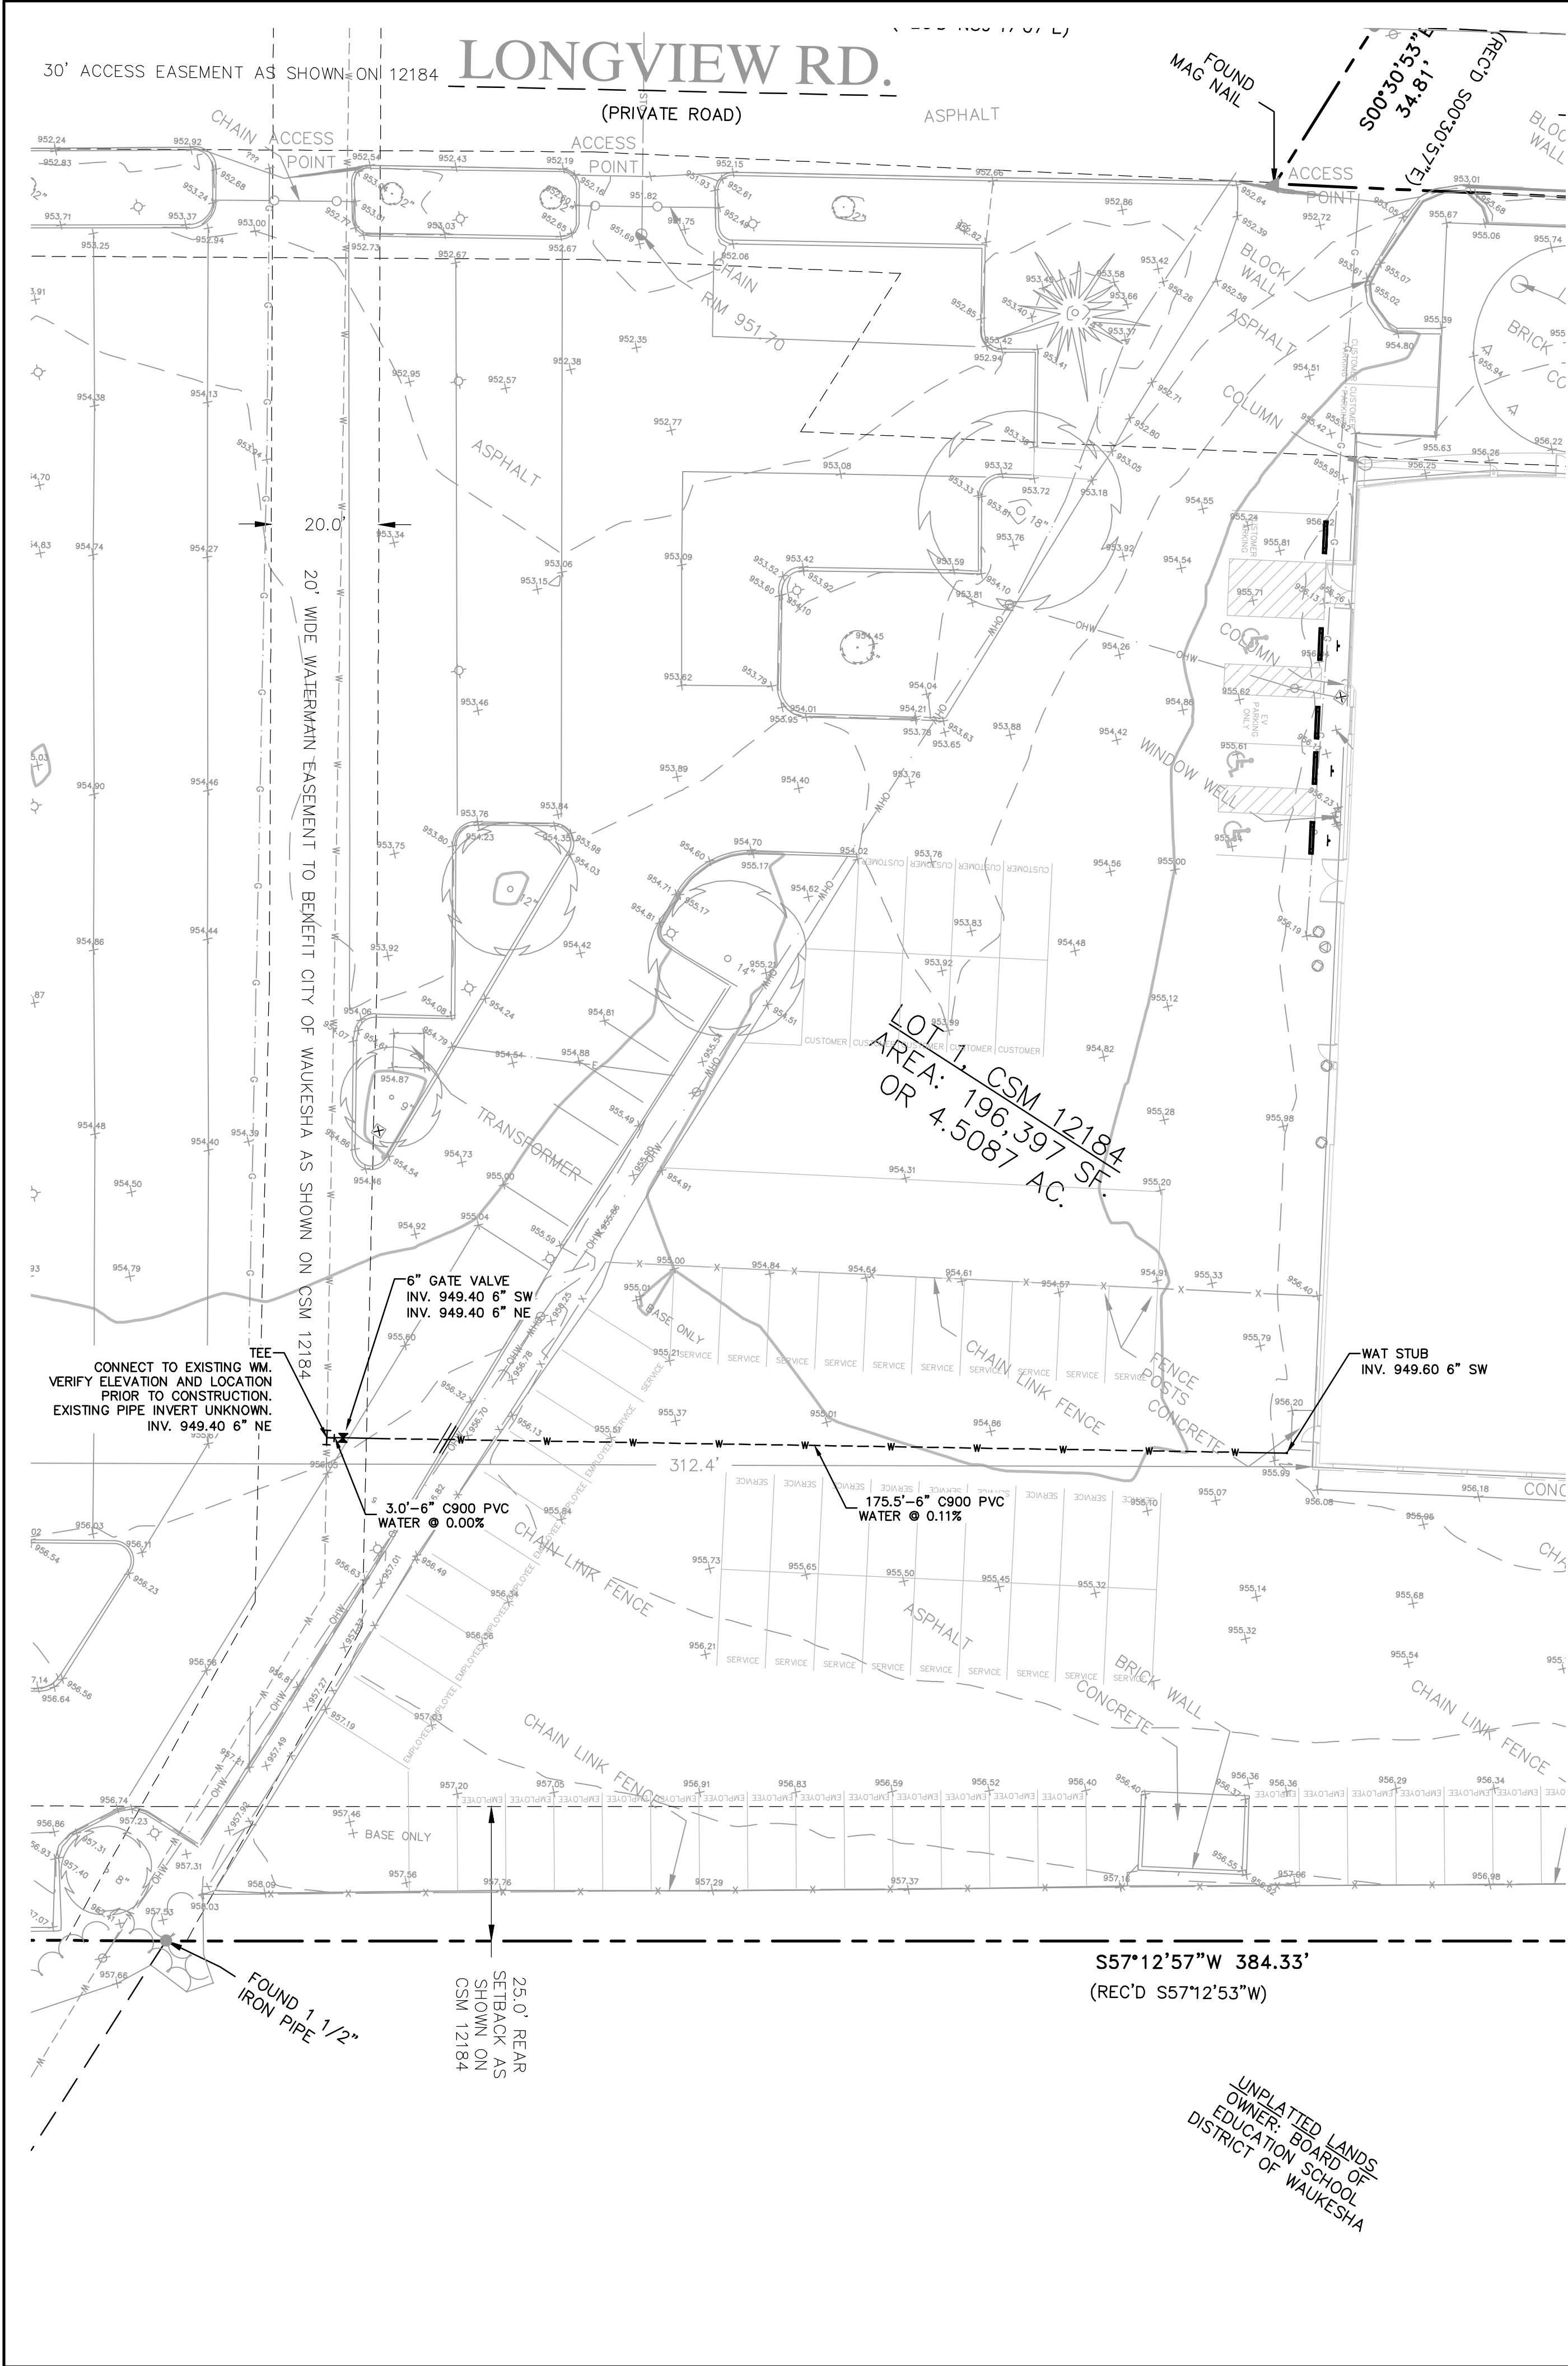


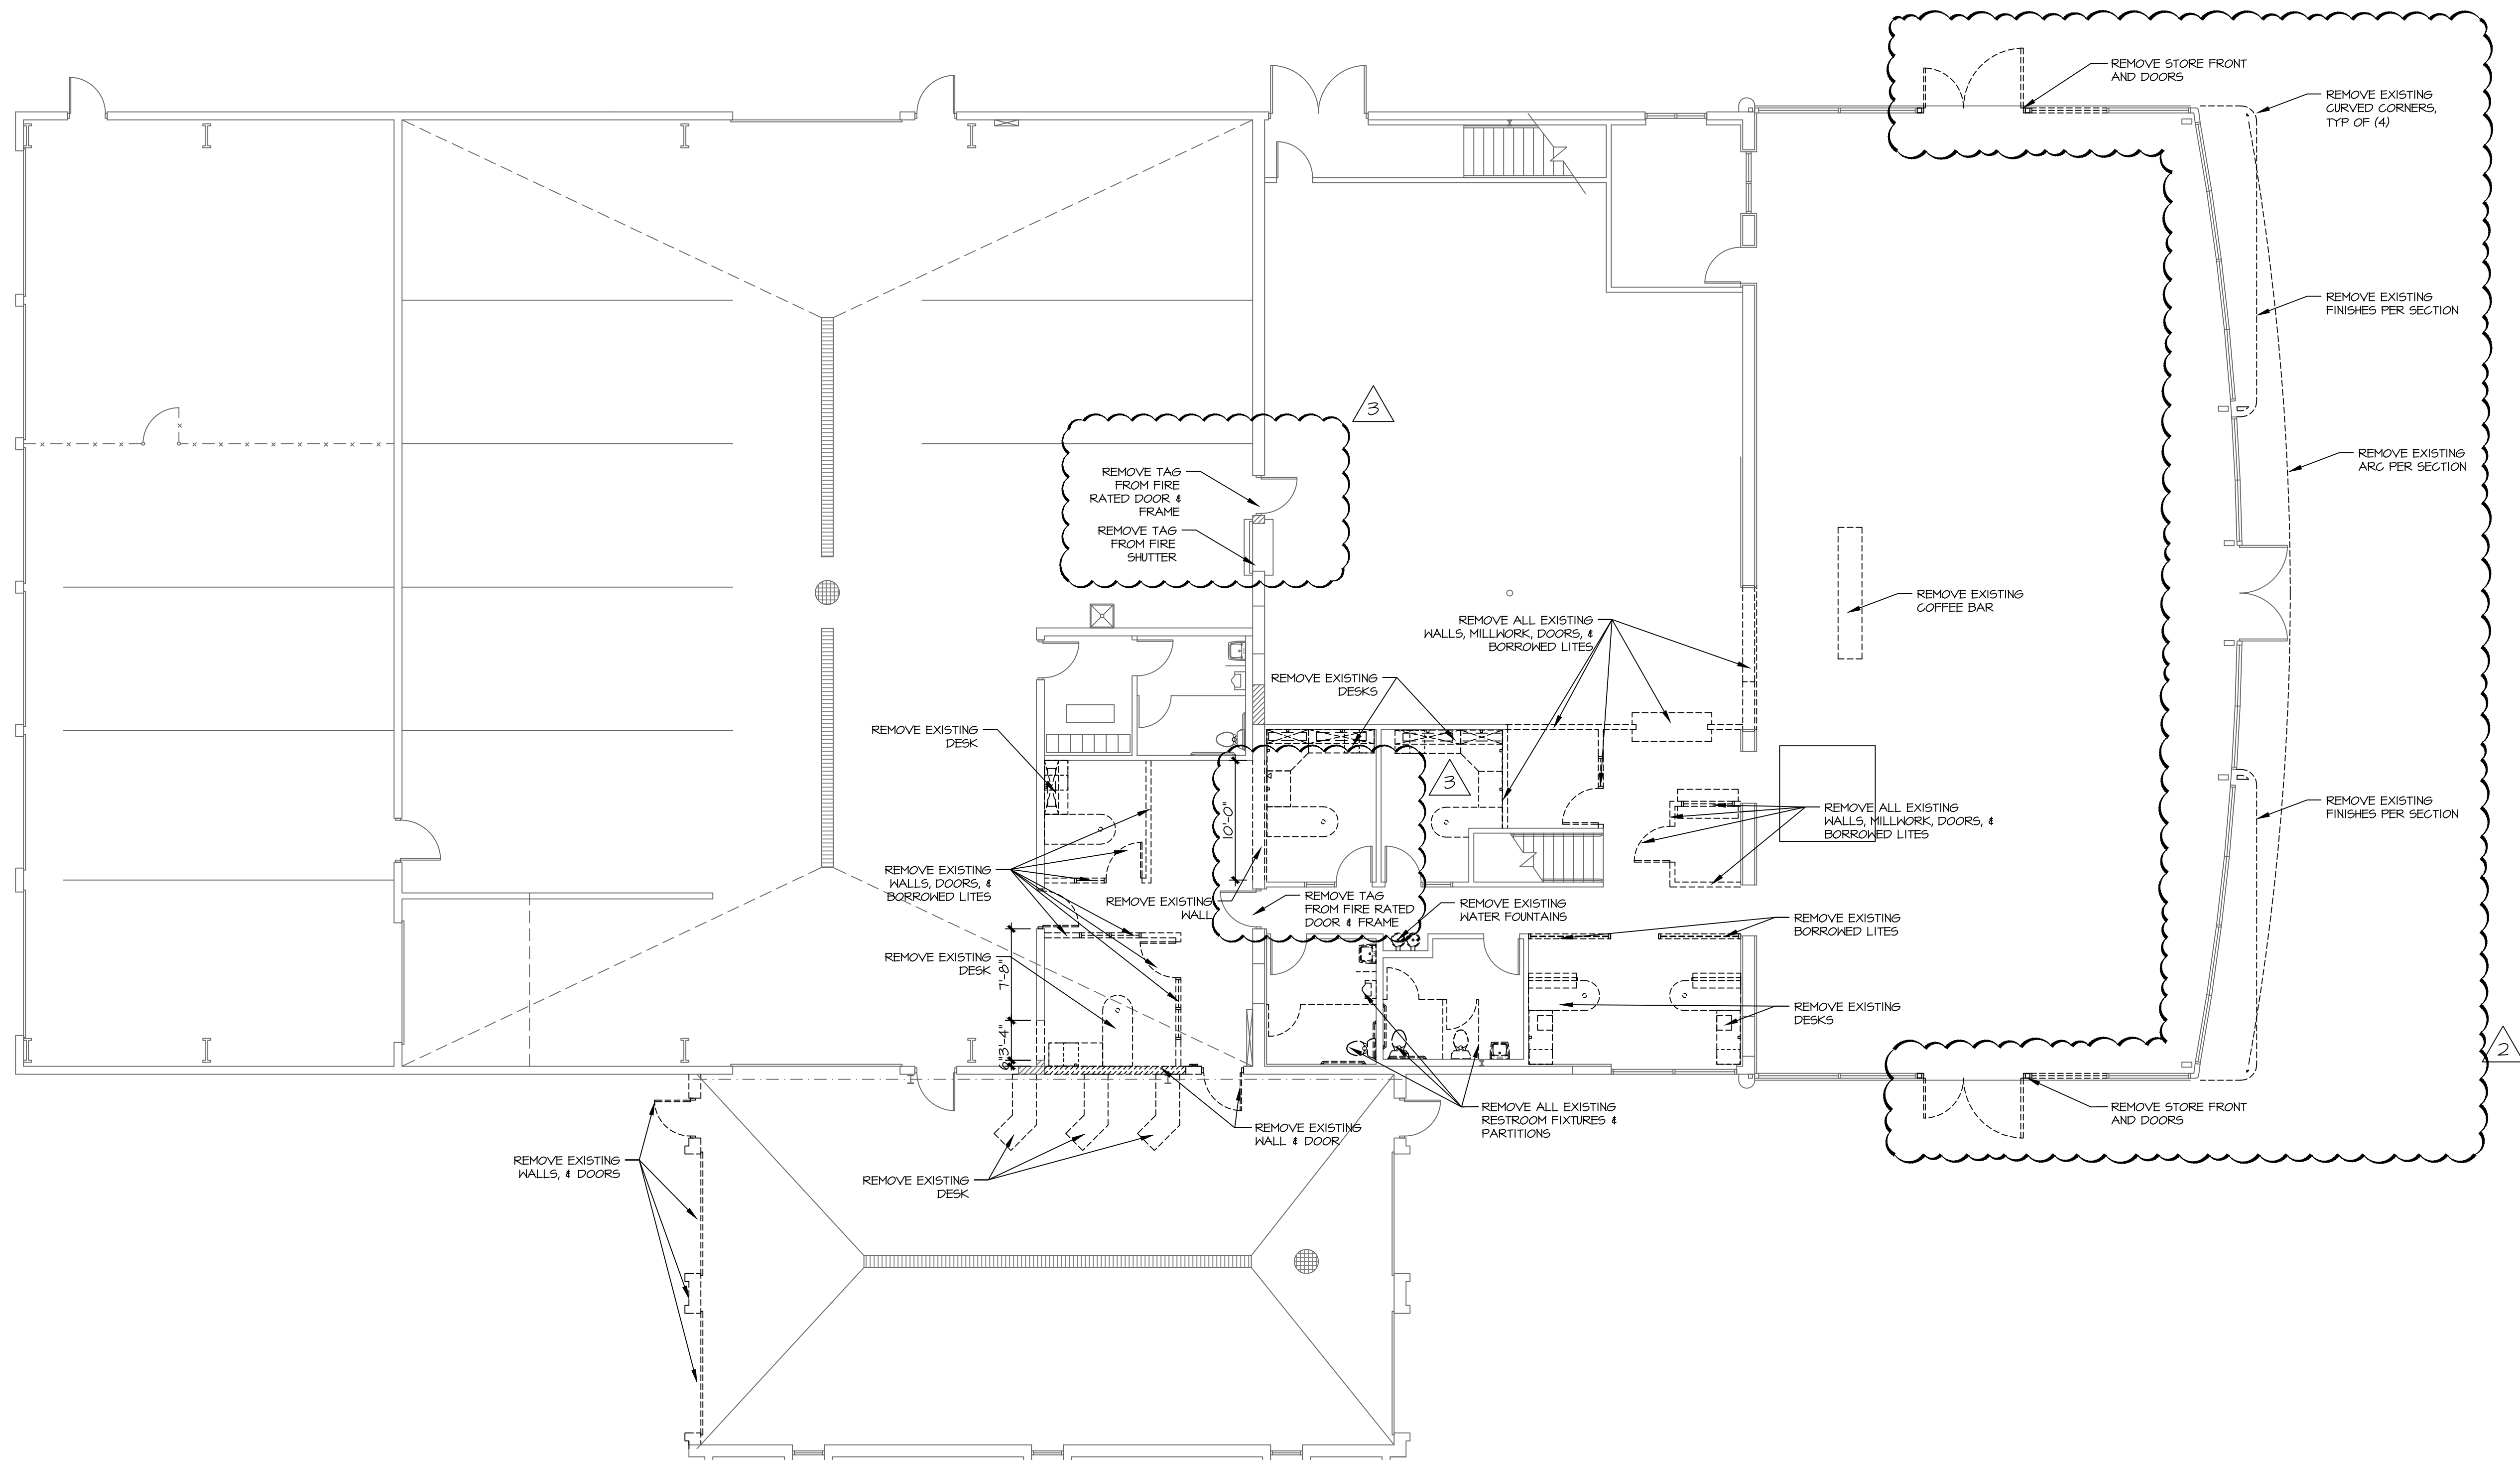

NOTE
REMOVE ALL EXISTING FURNITURE

1 DEMO FLOOR PLAN
1/8"=1'-0"

NORTH

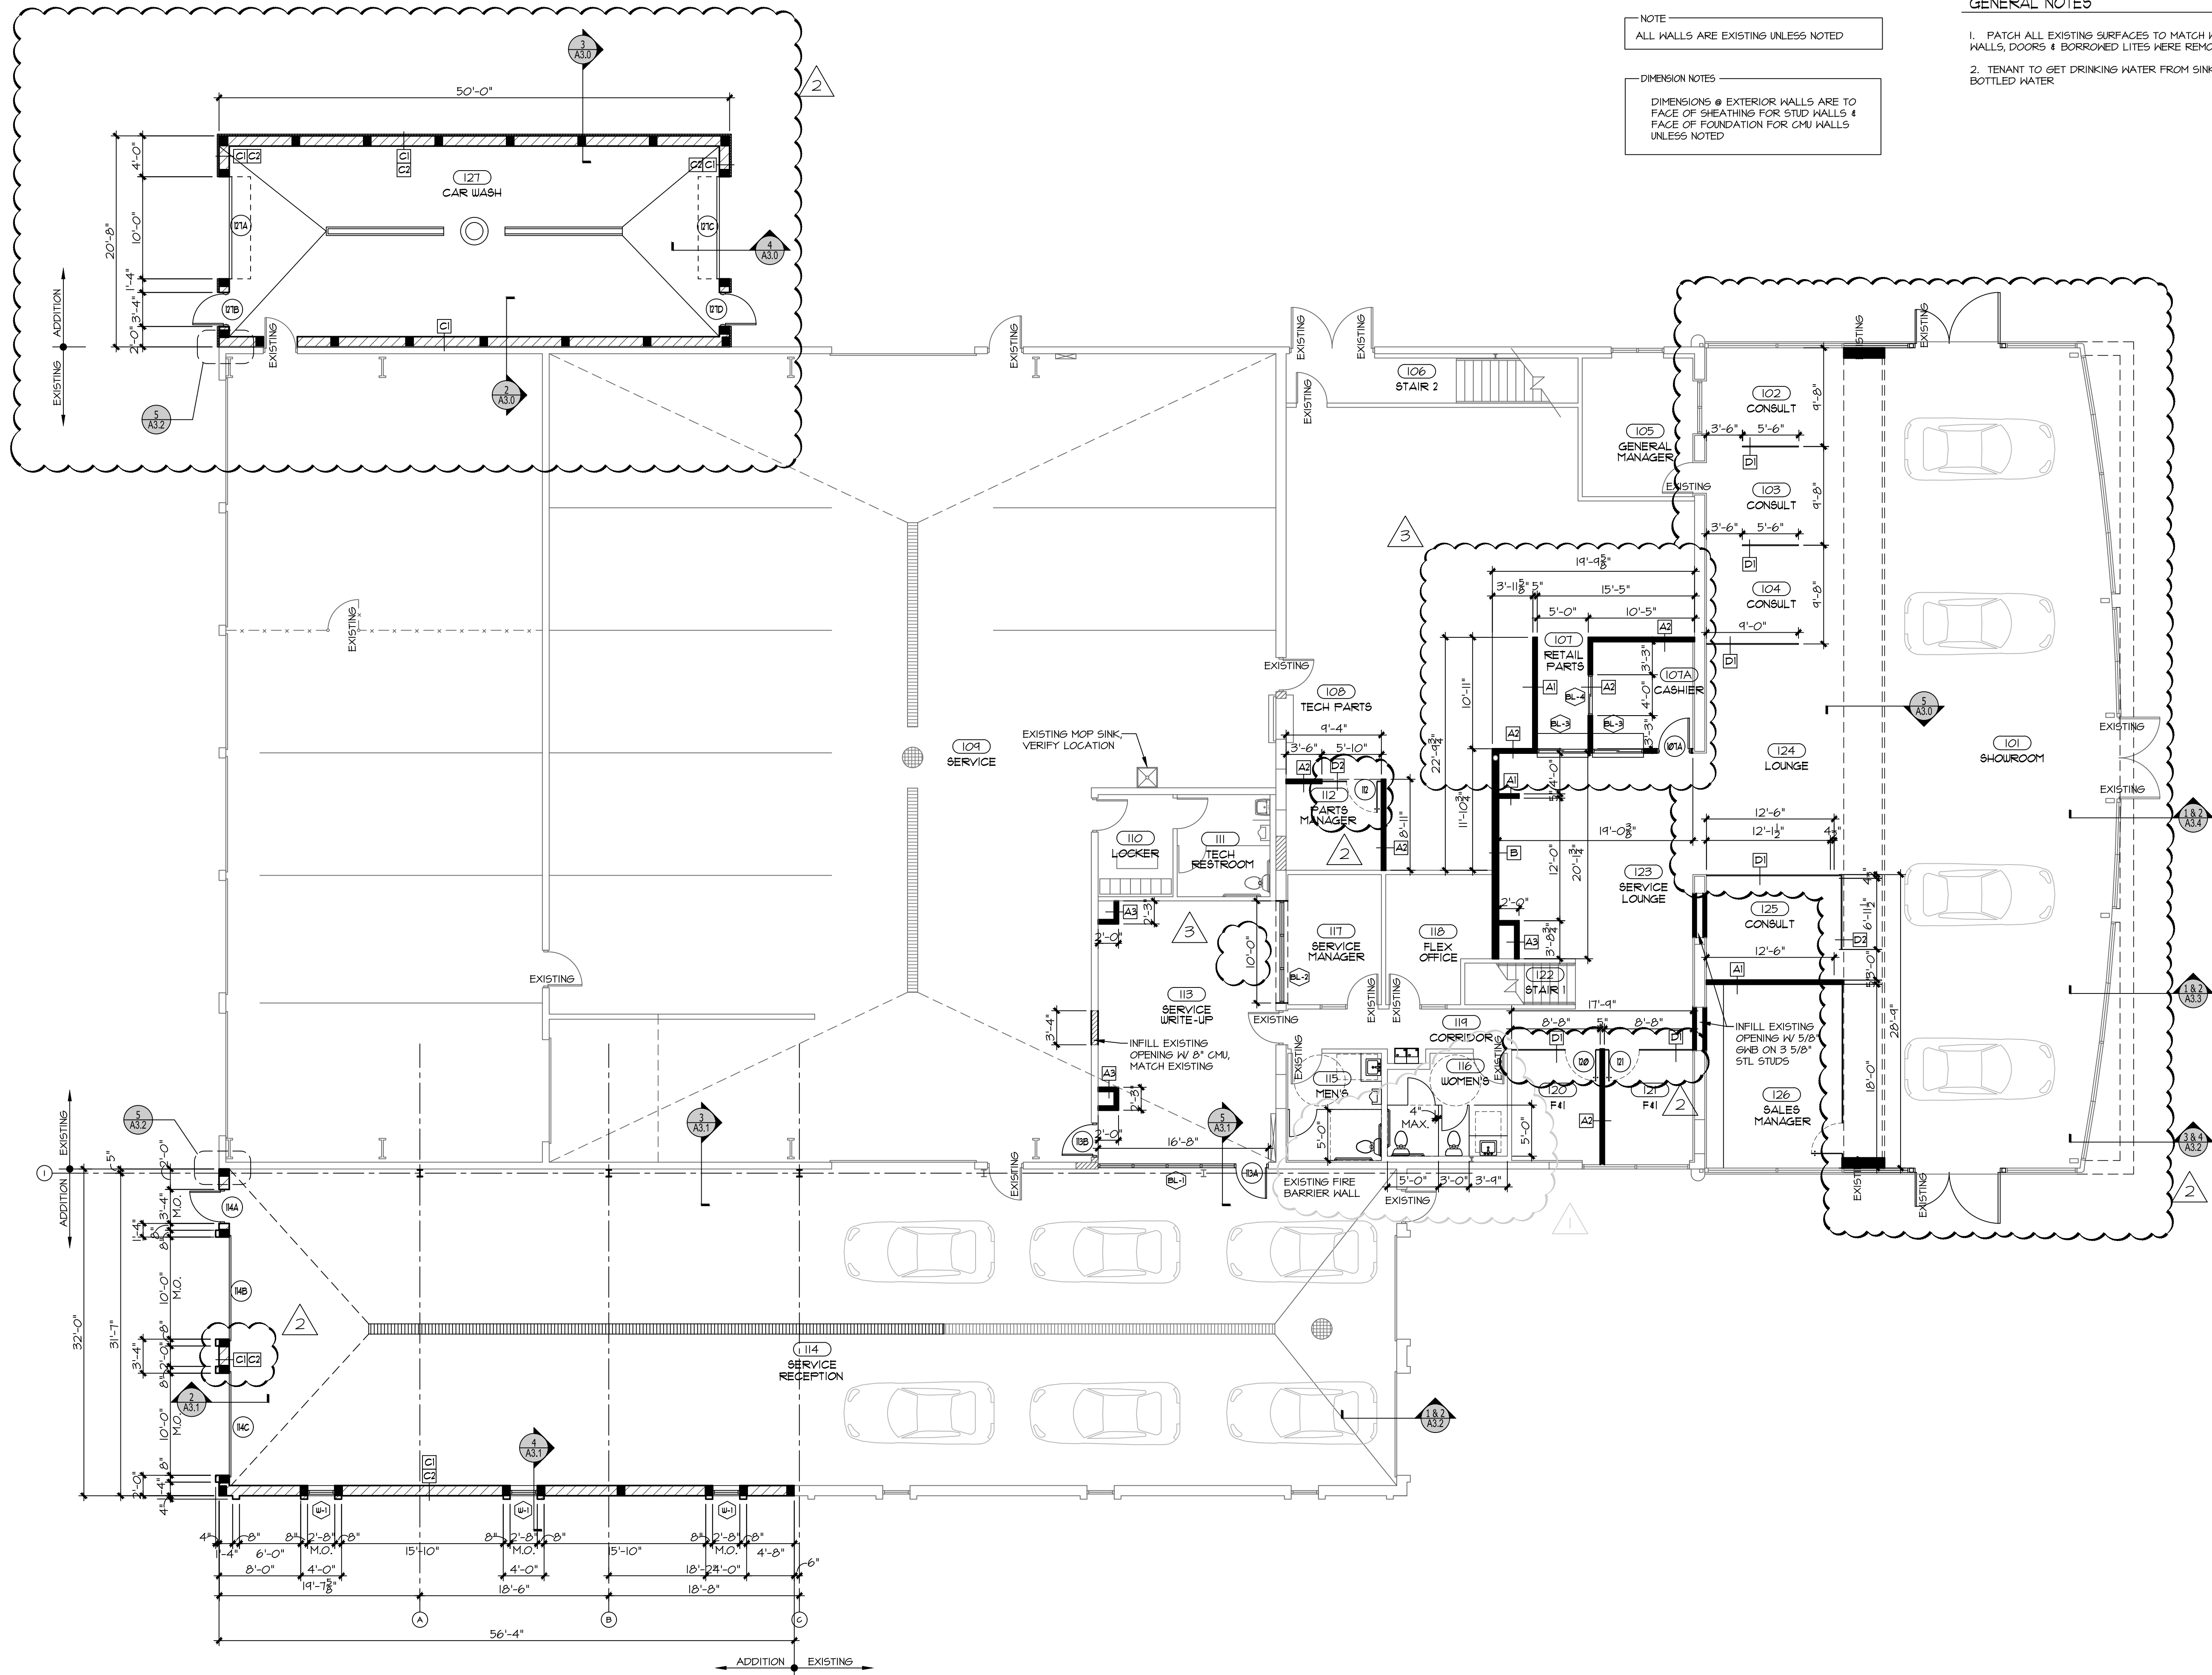


NOTE
ALL WALLS ARE EXISTING UNLESS NOTED

DIMENSION NOTES
DIMENSIONS @ EXTERIOR WALLS ARE TO FACE OF SHEATHING FOR STUD WALLS & FACE OF FOUNDATION FOR CMU WALLS UNLESS NOTED

- GENERAL NOTES
1. PATCH ALL EXISTING SURFACES TO MATCH WHERE EXISTING WALLS, DOORS & BORROWED LITES WERE REMOVED
 2. TENANT TO GET DRINKING WATER FROM SINK OR PROVIDE BOTTLED WATER

1 FIRST FLOOR PLAN
1/8"=1'-0"

25217 SOUTH WIND LAKE ROAD
WIND LAKE, WISCONSIN 53185
PHONE 262-409-2530

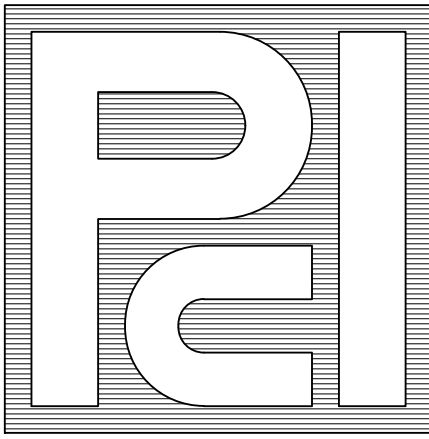

PROFESSIONAL
CONSULTANTS, INC.
300 COTTONWOOD AVE # 7
HARTLAND, WISCONSIN 53029
(262) 367-6080

RUSS DARROW
KIA OF WAUKESHA
2141 EAST MORELAND BLVD
WAUKESHA, WISCONSIN

TDI ASSOCIATES, INC.
All Rights Reserved
OWNERSHIP OF DOCUMENTS
This document, and the ideas and design incorporated herein, as an instrument of professional service, is the sole property of TDI Associates, Inc., and is not to be used in whole or in part for any other project or purpose without the expressed written authorization of TDI Associates, Inc.

Sheet Title
FIRST FLOOR
PLAN

Issued For: Date:
REV #1 09-03-2024
REV #2 06-27-2025
REV #3 08-06-2025


Date: 07-25-2024

Job NO.: 24103.000


Drawn By: LCC

Sheet No.


A1.1

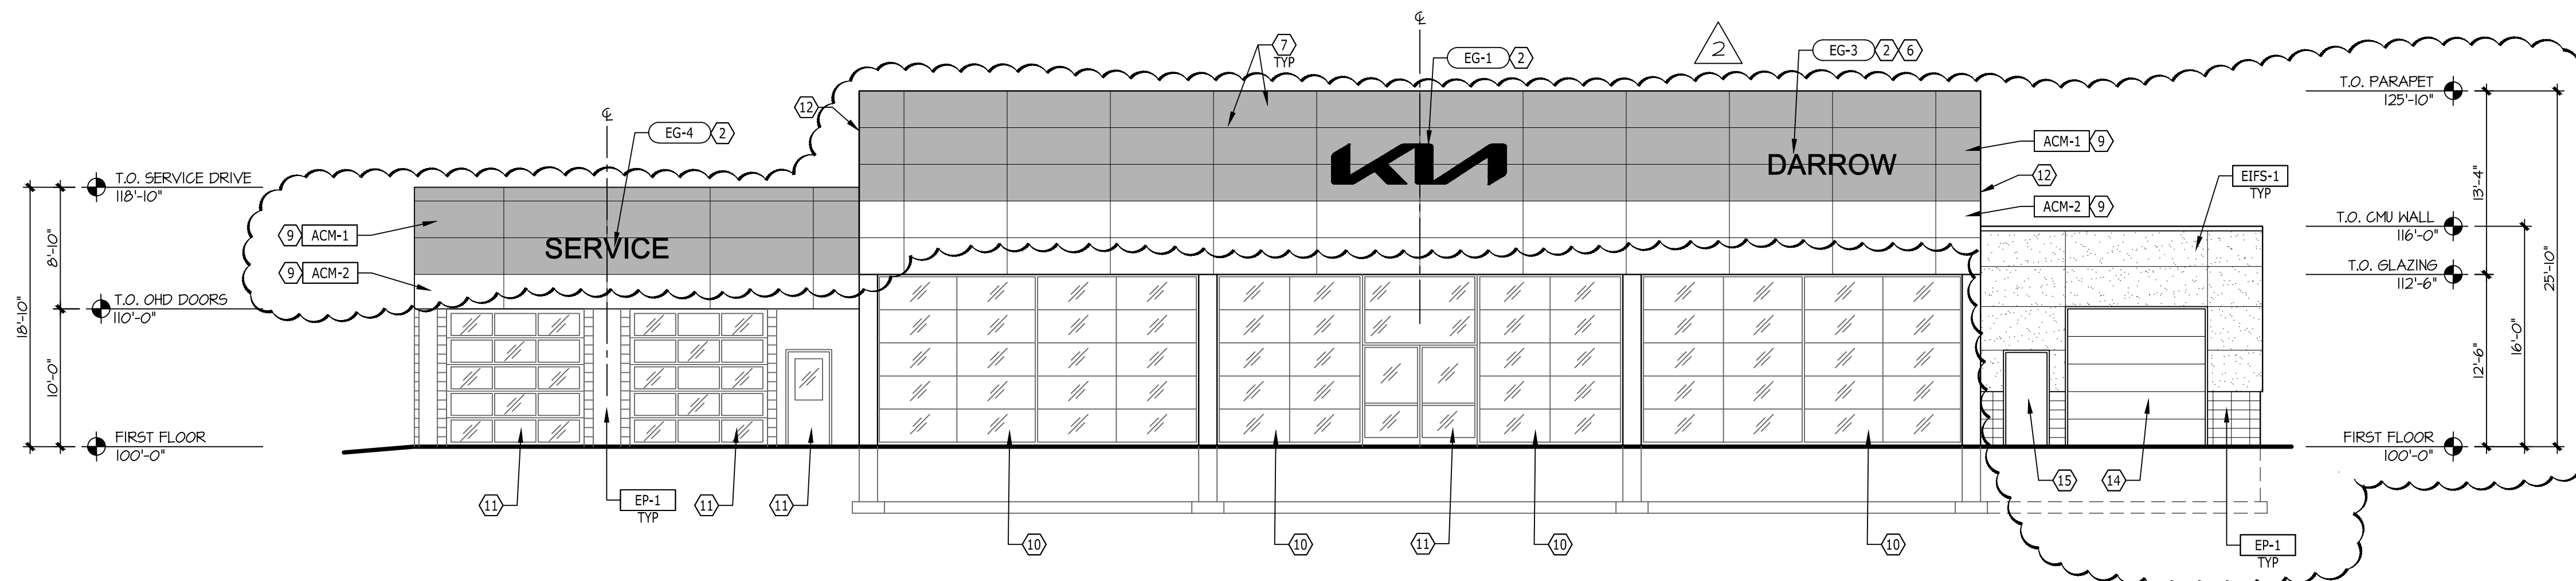

1 NORTH ELEVATION
1/8" = 1'-0"

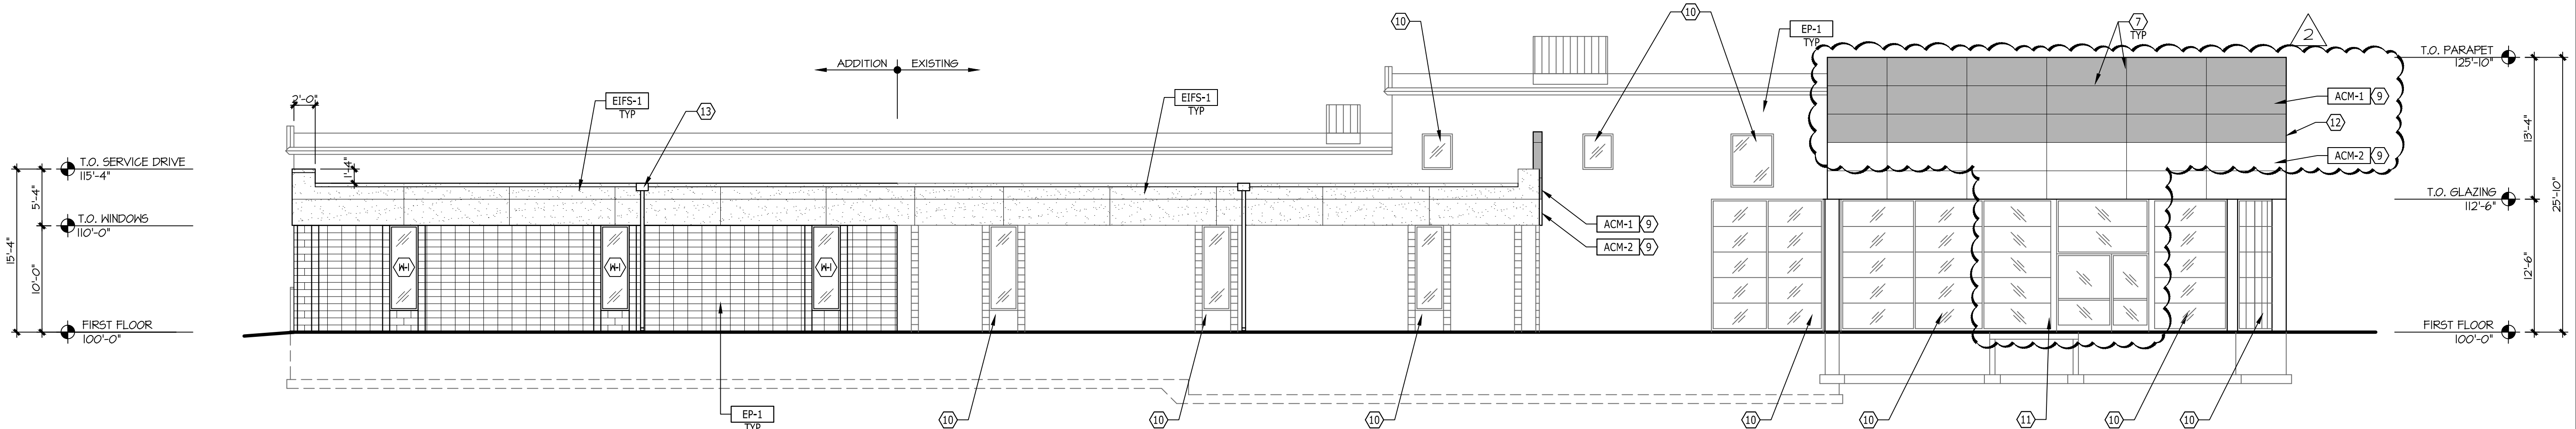

2 EAST ELEVATION
1/8" = 1'-0"

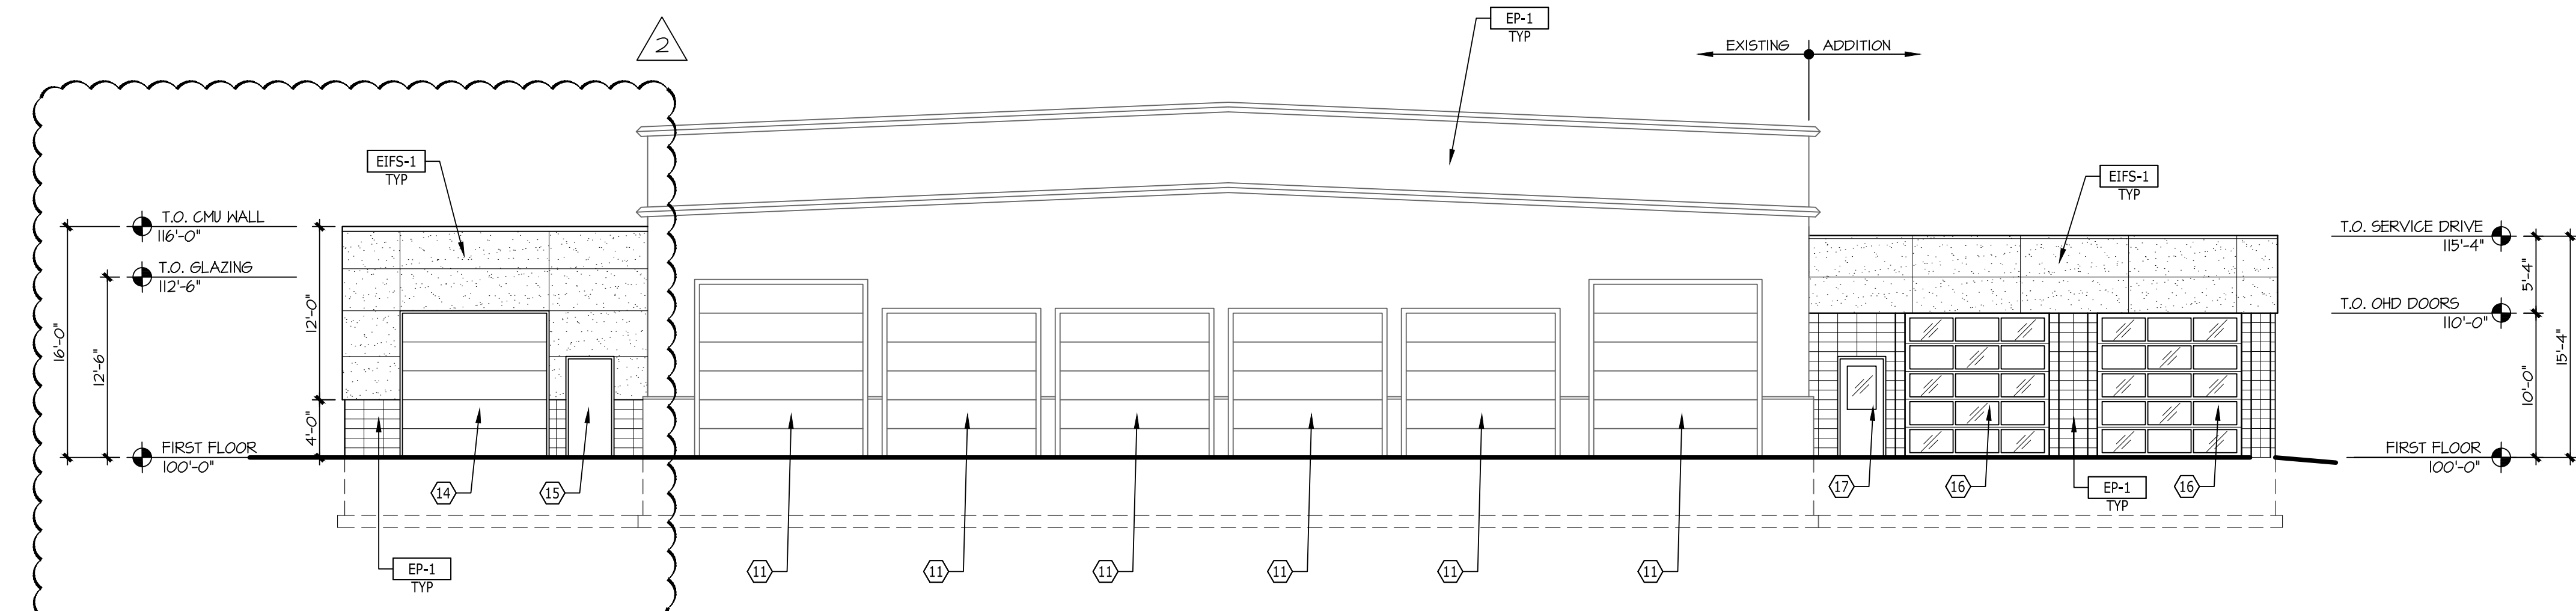



3 SOUTH ELEVATION
1/8" = 1'-0"

LEGEND	
⬡	NOTE DESIGNATOR - REFER TO DRAWING NOTES ON THIS SHEET
EG-X	GRAPHICS DESIGNATOR - REFER TO SHEET G-X
7-#	FINISH DESIGNATOR - REFER TO EXTERIOR FINISH SCHEDULE

DRAWING NOTES

- NOT USED.
- BUILDING SIGNAGE. SEE GRAPHICS SHEETS.
- CENTERLINE OF MULLIONS CURTAIN WALL SYSTEM SHALL BE EQUAL FRAME SPACING AS ALLOWABLE.
- DISPLAY PLATFORM. SEE DETAILS ON SHEET A.1A.
- NOT USED.
- DEALER NAME TO BE ALL UPPERCASE, 2'-0" ALL LETTERS OR 1'-6" LETTER FOR LONGER NAMES.
- ACM PANEL JOINT, TYP.
- ENTRY PORTAL PROVIDED BY PATTISON SIGN GROUP. CONTACT BELOW FOR COORDINATION AND REQUIREMENTS.
CONTACT: STEVIE WEBB swebb@pattisonsign.com
- ACM PROVIDED AND INSTALLED BY PATTISON SIGN GROUP. NO EXCEPTIONS. CONTACT BELOW FOR COORDINATION AND REQUIREMENTS.
CONTACT: STEVIE WEBB swebb@pattisonsign.com
INSTALL OVER EXISTING EIFS / RIGID INSULATION
- EXISTING GLAZING. ALL EXISTING GLAZING SHALL BE PROVIDED WITH LIKE-NEW APPEARANCE. REPAIR DAMAGED AND DISCOLORED AREAS AS NOTED
- EXISTING DOOR. ALL EXISTING GLAZING SHALL BE PROVIDED WITH LIKE-NEW APPEARANCE. REPAIR DAMAGED AND DISCOLORED AREAS AS NOTED
- EXTEND STEEL STUD FRAMING AND SHEATHING TO SQUARE OFF CORNERS.
- PREFINISHED METAL SCUPPER & DOWN SPOUT, MATCH EXISTING
- NEW INSULATED SECTIONAL DOOR
- NEW INSULATED HOLLOW METAL DOOR
- NEW INSULATED GLASS ALUM. SECTIONAL DOOR
- NEW INSULATED GLASS ALUM. DOOR

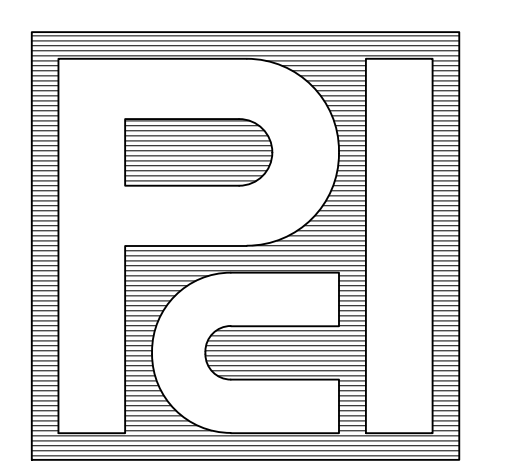

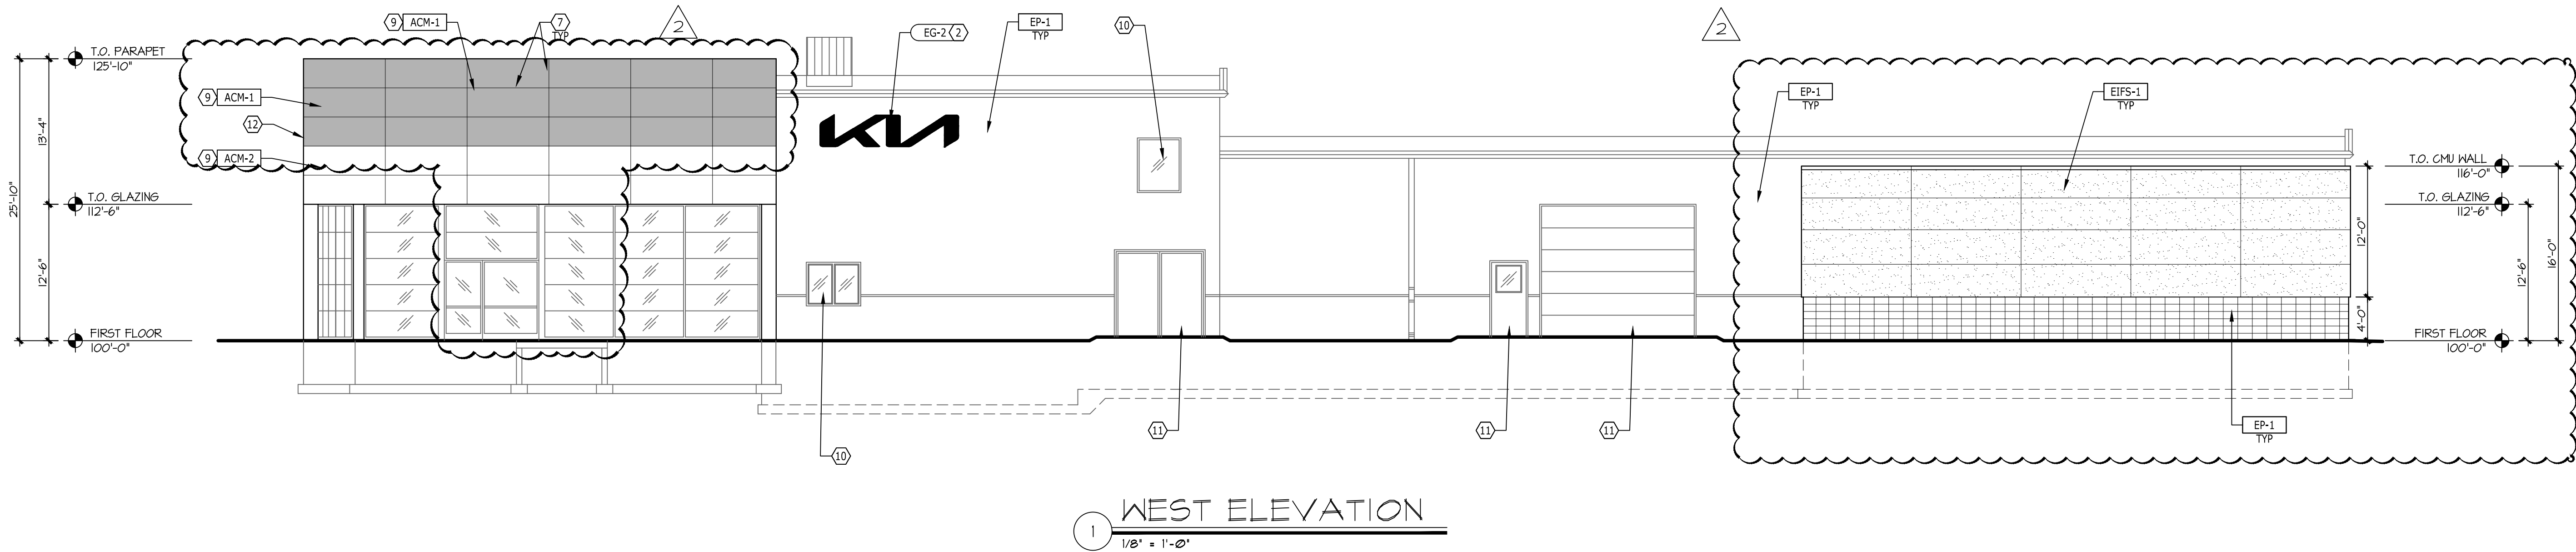

EXTERIOR FINISH SCHEDULE								
KIA 2023 CBS EXTERIOR MATERIALS AND FINISHES SCHEDULE								
CODE	MATERIAL	NOTES	LOCATION	MANUFACTURER	PRODUCT	FINISH/COLOR	DIMENSION	WEBSITE
ACM-1	ALUMINUM COMPOSITE MATERIAL	CONTRACTOR TO COORDINATE ALL ADDITIONAL PARTS AND SYSTEMS THAT ARE RECOMMENDED BY THE MANUFACTURER TO COMPLETE INSTALL.	EXTERIOR FACADE	PATTISON SIGN GROUP	BESTWORTH	TOR BLACK	REFERENCE CONSTRUCTION DOCUMENTS	https://bestworth.com/acm-architectural-panelwall-series/
ACM-1 (ALT)	ALUMINUM COMPOSITE MATERIAL	CONTRACTOR TO COORDINATE ALL ADDITIONAL PARTS AND SYSTEMS THAT ARE RECOMMENDED BY THE MANUFACTURER TO COMPLETE INSTALL.	EXTERIOR FACADE	ALPOLIC	ALPOLIC / FR	TOR BLACK	REFERENCE CONSTRUCTION DOCUMENTS	https://www.alpolic-americas.com/products/fire-resistant/
ACM-1 (ALT 2)	ALUMINUM COMPOSITE MATERIAL	CONTRACTOR TO COORDINATE ALL ADDITIONAL PARTS AND SYSTEMS THAT ARE RECOMMENDED BY THE MANUFACTURER TO COMPLETE INSTALL.	EXTERIOR FACADE	ALFLEX	ALFLEX / FR	MIDNIGHT BLACK #ENC-1819	REFERENCE CONSTRUCTION DOCUMENTS	https://www.alflexusa.com
ACM-2	ALUMINUM COMPOSITE MATERIAL	CONTRACTOR TO COORDINATE ALL ADDITIONAL PARTS AND SYSTEMS THAT ARE RECOMMENDED BY THE MANUFACTURER TO COMPLETE INSTALL.	ENTRY PORTAL	PATTISON SIGN GROUP	BESTWORTH	BSX SILVER METALLIC	REFERENCE CONSTRUCTION DOCUMENTS	https://bestworth.com/acm-architectural-panelwall-series/
ACM-2 (ALT)	ALUMINUM COMPOSITE MATERIAL	CONTRACTOR TO COORDINATE ALL ADDITIONAL PARTS AND SYSTEMS THAT ARE RECOMMENDED BY THE MANUFACTURER TO COMPLETE INSTALL.	ENTRY PORTAL	ALPOLIC	ALPOLIC / FR	BSX SILVER METALLIC	REFERENCE CONSTRUCTION DOCUMENTS	https://www.alpolic-americas.com/products/fire-resistant/
ACM-2 (ALT 2)	ALUMINUM COMPOSITE MATERIAL	CONTRACTOR TO COORDINATE ALL ADDITIONAL PARTS AND SYSTEMS THAT ARE RECOMMENDED BY THE MANUFACTURER TO COMPLETE INSTALL.	ENTRY PORTAL	ALFLEX	ALFLEX / FR	BRIGHT SILVER METALLIC #JY-3510	REFERENCE CONSTRUCTION DOCUMENTS	https://www.alflexusa.com
CW-1	CURTAIN WALL	CONTRACTOR TO COORDINATE ALL ADDITIONAL PARTS AND SYSTEMS THAT ARE RECOMMENDED BY THE MANUFACTURER TO COMPLETE INSTALL.	SHOWROOM	KAWNEER	1500UT CURTAIN WALL SYSTEM GLAZING METHOD: EXTERIOR GLAZING TO BE DETERMINED BY ARCHITECT OF RECORD. ARCHITECT OF RECORD TO SELECT GLAZING BASED OFF THEIR LOCAL JURISDICTIONS THERMAL REQUIREMENTS.	MULLIONS AND HARDWARE COLOR: ANODIZED ALUMINUM GLAZING: CLEAR, LOW IRON	FACE WIDTH: 2" OVERALL DEPTH: 10"(FACILITY TO VERIFY REQUIREMENTS) GLAZING INT'L: 1" REFERENCE DESIGN DOCUMENTS FOR GLAZING PANEL SIZES.	https://www.kawneer.com
EIFS-1	EXTERIOR INSULATION FINISH SYSTEM	CONTRACTOR TO COORDINATE ALL ADDITIONAL PARTS AND SYSTEMS THAT ARE RECOMMENDED BY THE MANUFACTURER TO COMPLETE INSTALL.	EXTERIOR OF BUILDING	DRYVIT	DRYVIT "DEMANDIT ADVANTAGE" ARCHITECTURAL COATING KIAM G3 5413 S APPLIED OVER DRYVIT "FINESSE" SPECIALLY FINISH KIAM G3 1036 S INCORPORATING DRYVIT "STRATOTONE" HIGH PERFORMANCE COLORANT (S). SYSTEM REFERENCE: DRYVIT "OUTSULATION PLUS HD" EIFS WITH MOISTURE DRAINAGE	TO MATCH BM HC-169 CONVENTRY GRAY	REFERENCE CONSTRUCTION DOCUMENTS	https://www.dryvit.com/products/coatings/stains/demandit-advantage/
EP-1	PAINT	PREP AND PRIME SURFACES PER MANUFACTURER'S RECOMMENDATIONS.	EXTERIOR PAINT	BENJAMIN MOORE	REGAL SELECT EXTERIOR LATEX PAINT	COLOR: BM HC-169 CONVENTRY GRAY FINISH: EGGSHELL	N/A	https://store.benjaminmoore.com/storefront/us/en/coating/exterior-greint/benjamin-moore/regal-select-exterior-paint/regal-select20FLAT



25217 SOUTH WIND LAKE ROAD
WIND LAKE, WISCONSIN 53185
PHONE 262-409-2530



300 COTTONWOOD AVE #7
HARTLAND, WISCONSIN 53029
(262) 367-6080

RUSS DARROW
KIA OF WAUKESHA
2141 EAST MORELAND BLVD
WAUKESHA, WISCONSIN

TDI ASSOCIATES, INC
All Rights Reserved

OWNERSHIP OF DOCUMENTS

This document, and the ideas and design incorporated herein, as an instrument of professional service, is the sole property of TDI Associates, Inc., and is not to be used in whole or in part for any other project or purpose without the expressed written authorization of TDI Associates, Inc.

Sheet Title
WALL TYPES &
WALL SECTION

Issued For: Date:
EV #2 06-27-2025



Date: 07-25-2024

Job NO.: 24103.000

Drawn By: LCC

Sheet No. _____

A3.0 $\triangle_2$

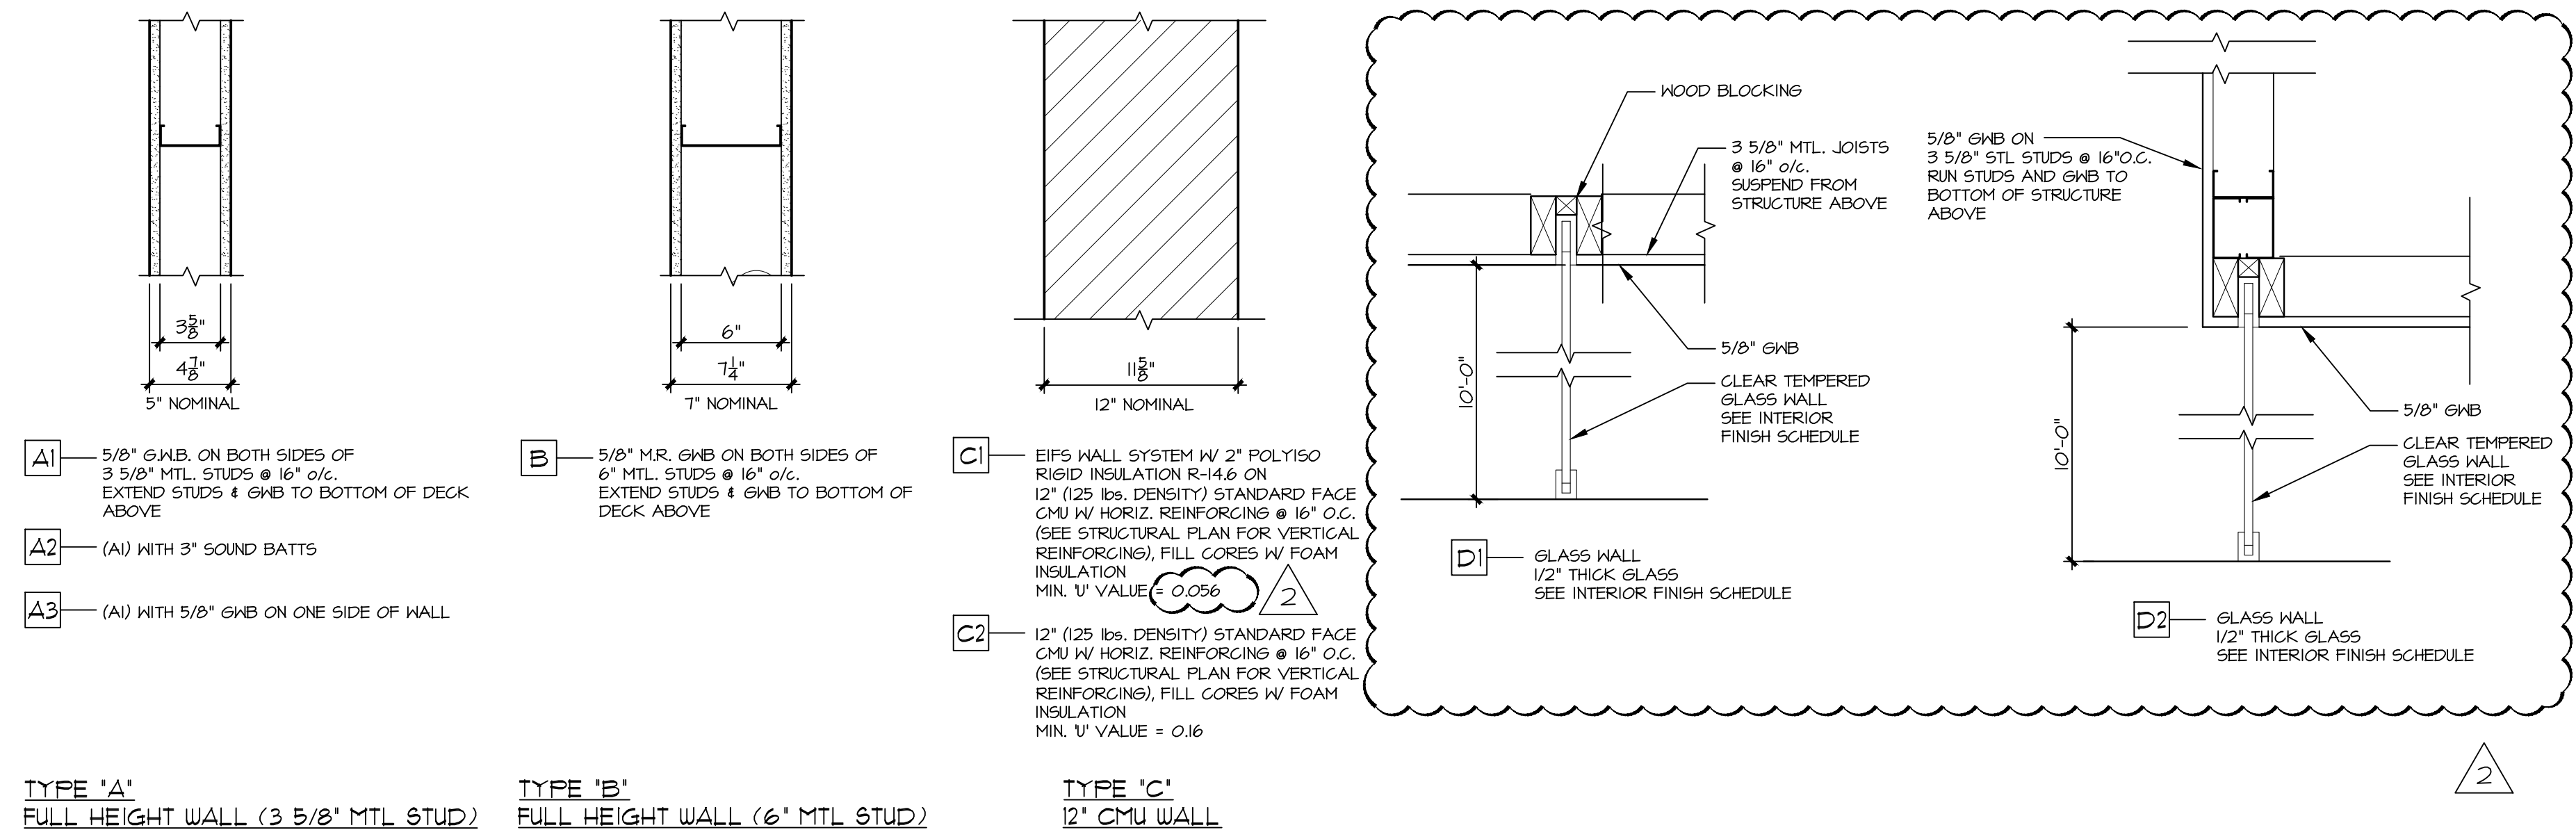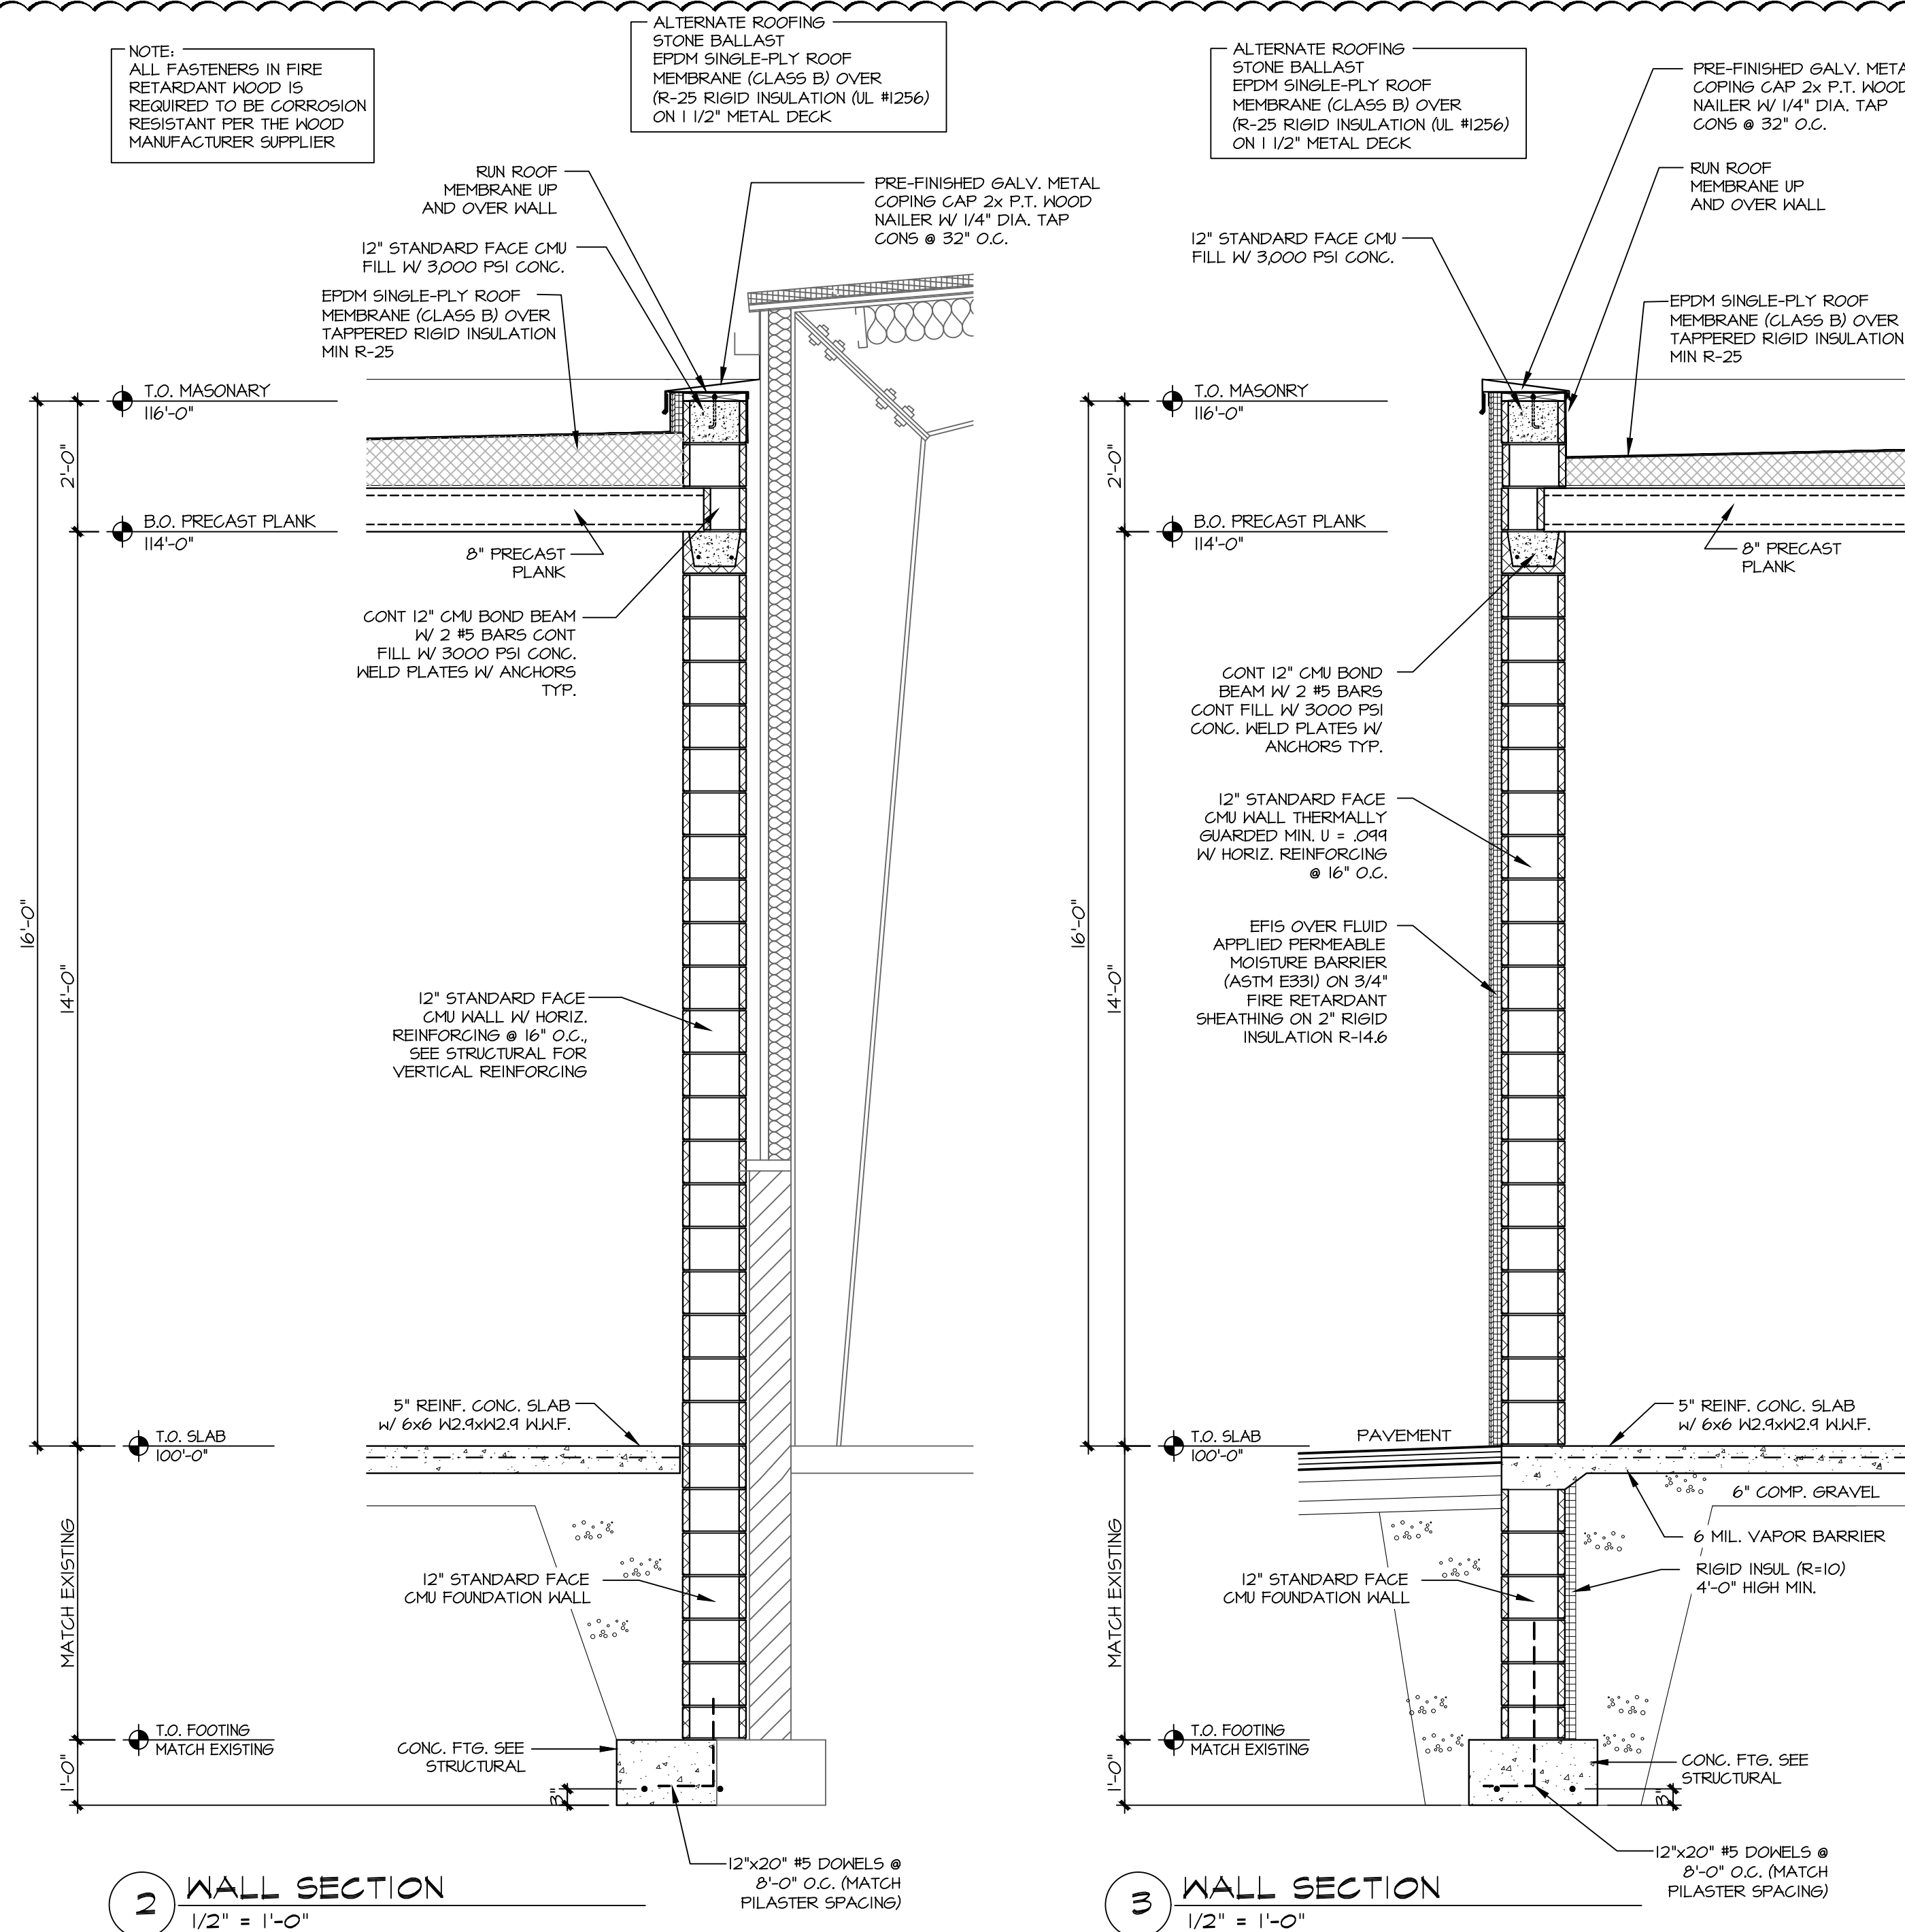

$$1\ 1/2" = 1'-\emptyset'$$


NOTE:
ALL FASTENERS IN FIRE RETARDANT WOOD IS REQUIRED TO BE CORROSION RESISTANT PER THE WOOD MANUFACTURER SUPPLIER.

ALTERNATE ROOFING
STONE BALLAST
EPDM SINGLE-PLY ROOF MEMBRANE (CLASS B) OVER (R-25 RIGID INSULATION (UL #1256) ON 1 1/2" METAL DECK.


4 WALL SECTION
1/2" = 1'-0"

5 WALL SECTION
1/2" = 1'-0"

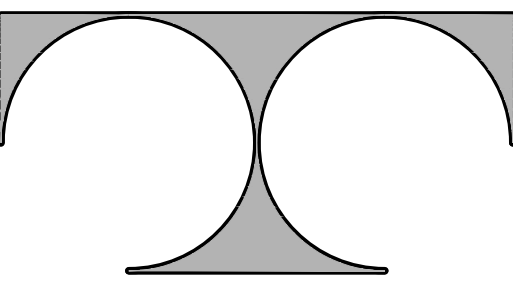

TDI ASSOCIATES, INC.
ARCHITECTURE & PLANNING

25217 SOUTH WIND LAKE ROAD
WIND LAKE, WISCONSIN 53185
PHONE 262-409-2530

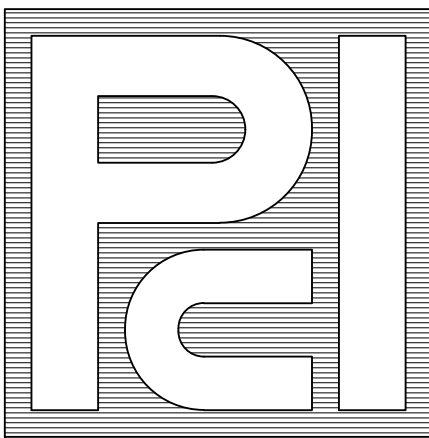

PROFESSIONAL
CONSULTANTS, INC.

300 COTTONWOOD AVE # 7
HARTLAND, WISCONSIN 53029
(262) 367-6080

RUSS DARROW
KIA OF WAUKESHA
2141 EAST MORELAND BLVD
WAUKESHA, WISCONSIN

TDI ASSOCIATES, INC.
All Rights Reserved

OWNERSHIP OF DOCUMENTS

This document, and the ideas and design incorporated herein, as an instrument of professional service, is the sole property of TDI Associates, Inc., and is not to be used in whole or in part for any other project or purpose without the expressed written authorization of TDI Associates, Inc.

Sheet Title
WALL SECTIONS

Issued For: REV #2 Date: 06-27-2025


Date: 07-25-2024

Job NO.: 24103.000


Drawn By: LCC

Sheet No.


A3.1

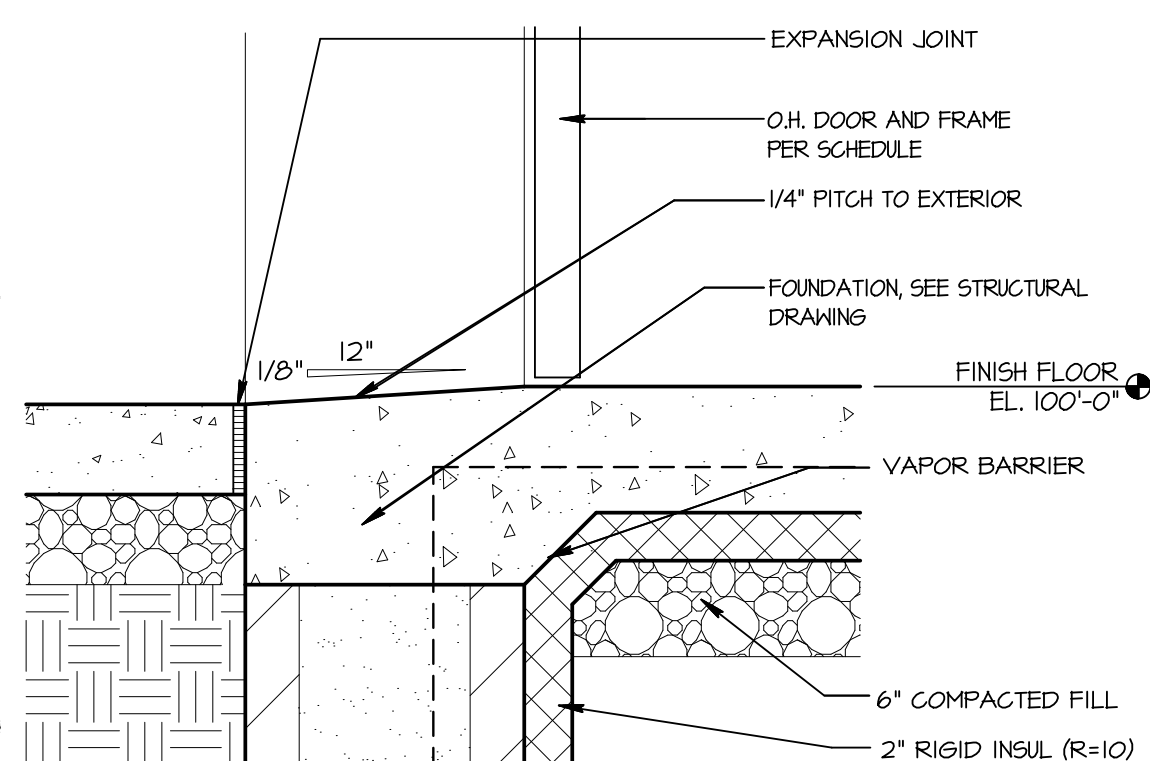

6 OVERHEAD DOOR SILL
1 1/2" = 1'-0"

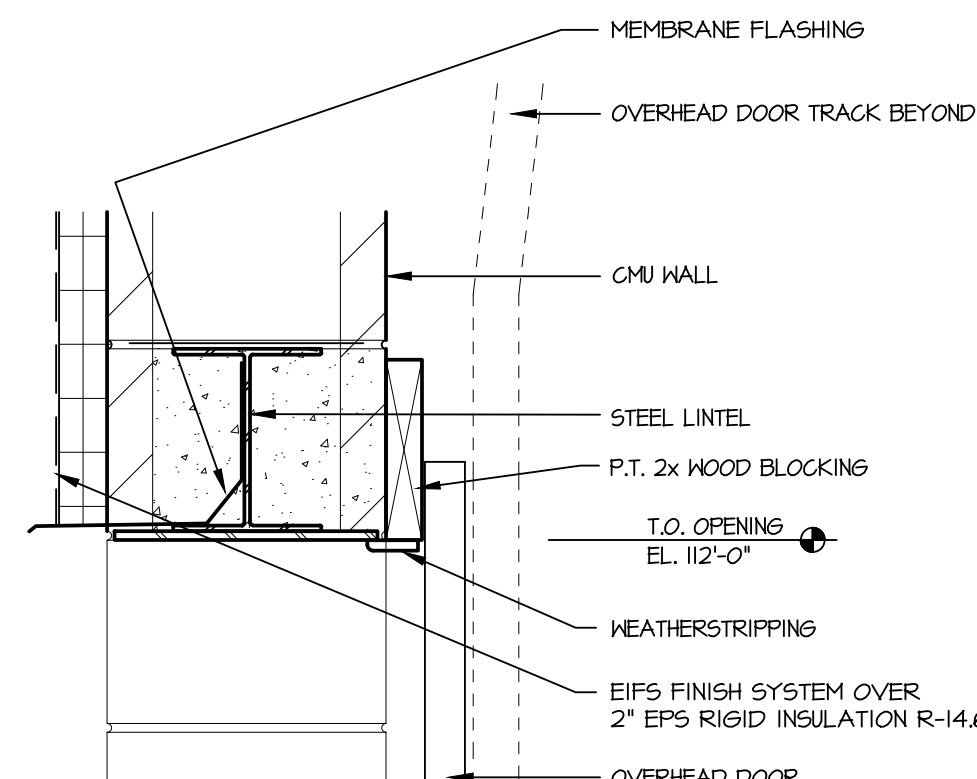

7 OVERHEAD DOOR HEAD
1 1/2" = 1'-0"

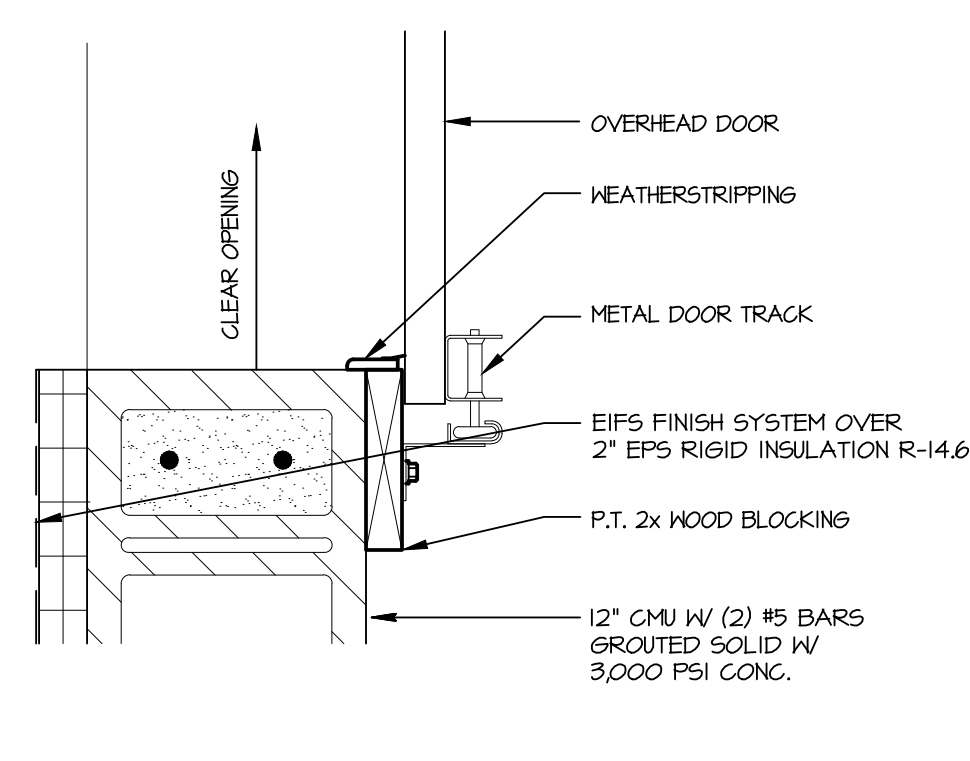

8 OVERHEAD DOOR JAMB
1 1/2" = 1'-0"

ALTERNATE ROOFING
STONE BALLAST
EPDM SINGLE-PLY ROOF
MEMBRANE (CLASS B) OVER
(R-38) RIGID INSULATION (UL #1256)
ON 1 1/2" METAL DECK

PRE-FINISHED GALV. METAL
COPING CAP 2x P.T. WOOD
NAILER W/ 1/4" DIA. TAP
CONS @ 32" O.C.

CONT 12" CMU BOND BEAM
W/ 2 #5 BARS CONT
FILL W/ 3000 PSI CONC.
TYP.

EIFS WALL SYSTEM
W/ 2" POLYISO RIGID
INSULATION R-14.6
1.3"x3"x1/4" CONT. BRG
ANGLE W/ 5/8" EXP. BOLT
@ 6'-0" O.C.

STL. LINTEL SEE
STRUCTURAL

CMU BEYOND AT BASE
OF WALL

HI LIFT DOOR
TRACK

INSULATED GLASS
OVERHEAD DOOR
MAX U-VALUE = 0.9

5" REINF. CONC. SLAB
W/ 6x6 W2.9xW2.9 W.W.F.

6" COMP. GRAVEL

6 MIL. VAPOR BARRIER

2" RIGID INSUL (R=10)
4'-0" HIGH MIN.

CONC. FTG. SEE
STRUCTURAL

PAVEMENT

12" STANDARD FACE
CMU FOUNDATION WALL
MATCH EXISTING
HEIGHT

CONC. FTG. SEE
STRUCTURAL

2 WALL SECTION
1/2" = 1'-0"

ALTERNATE ROOFING
STONE BALLAST
EPDM SINGLE-PLY ROOF
MEMBRANE (CLASS B) OVER
(R-38) RIGID INSULATION (UL #1256)
ON 1 1/2" METAL DECK

RUN ROOF MEMBRANE UP
EXISTING WALL

STONE BALLAST
EPDM SINGLE-PLY ROOF
MEMBRANE (CLASS B) OVER
(R-38) RIGID INSULATION ON
1/2" DENSEDECK EXTERIOR
BOARD ON 1 1/2" METAL DECK

STL. JOISTS SEE
STRUCTURAL

STEEL BEAM, SEE
STRUCTURAL

STEEL COLUMN,
SEE STRUCTURAL

JOIST BRG.
114'-0" 1/8"

1/2" EXPANSION MATERIAL TYP.

BASE PLATE SEE STRUCTURAL
1/4" SETTING
3/4" NON-SHRINK GROUT
3/4" DIA ANCHOR BOLTS

5" REINF. CONC. SLAB
W/ 6x6 W2.9xW2.9 W.W.F.

6" COMP. GRAVEL

6 MIL. VAPOR BARRIER

CMU FOUNDATION WALL
SEE STRUCTURAL

CONC. FTG. SEE
STRUCTURAL

PAVEMENT

12" STANDARD FACE
CMU FOUNDATION WALL

CONC. FTG. SEE
STRUCTURAL

HEIGHT VARY
DEFENDING ON EXISTING
FOOTING HGT.

5 BARS @ 16" O.C.
W/ 6" EMBEDMENT

3 WALL SECTION
1/2" = 1'-0"

ALTERNATE ROOFING
STONE BALLAST
EPDM SINGLE-PLY ROOF
MEMBRANE (CLASS B) OVER
(R-38) RIGID INSULATION (UL #1256)
ON 1 1/2" METAL DECK

PRE-FINISHED GALV. METAL
COPING CAP 2x P.T. WOOD
NAILER W/ 1/4" DIA. TAP
CONS @ 32" O.C.

CONT 12" CMU BOND BEAM
W/ 2 #5 BARS CONT
FILL W/ 3000 PSI CONC.
WELD PLATES W/ ANCHORS
TYP.

12" (125 LBS. DENSITY) STANDARD FACE
CMU W/ HORIZ. REINFORCING @ 16" O.C.
(SEE STRUCTURAL PLAN FOR VERTICAL
REINFORCING), FILL CORES W/ FOAM
INSULATION
MIN. U VALUE = 0.16

EIFS WALL SYSTEM
W/ 2" POLYISO RIGID
INSULATION R-14.6

STL. LINTEL SEE
STRUCTURAL

MEMBRANE FLASHING

1" THERMALLY BROKEN
INSULATED WINDOW
MAX U VALUE = .29
MAX SHGC VALUE = .40

RUN RIGID INSULATION
UP BETWEEN CMU &
CONC. SLAB

5" REINF. CONC. SLAB
W/ 6x6 W2.9xW2.9 W.W.F.

6" COMP. GRAVEL

6 MIL. VAPOR BARRIER

RIGID INSUL (R=10)
4'-0" HIGH MIN.

CONC. FTG. SEE
STRUCTURAL


PAVEMENT

12" STANDARD FACE
CMU FOUNDATION WALL



CONC. FTG. SEE
STRUCTURAL


HEIGHT VARY
DEFENDING ON EXISTING
FOOTING HGT.

4 WALL SECTION
1/2" = 1'-0"

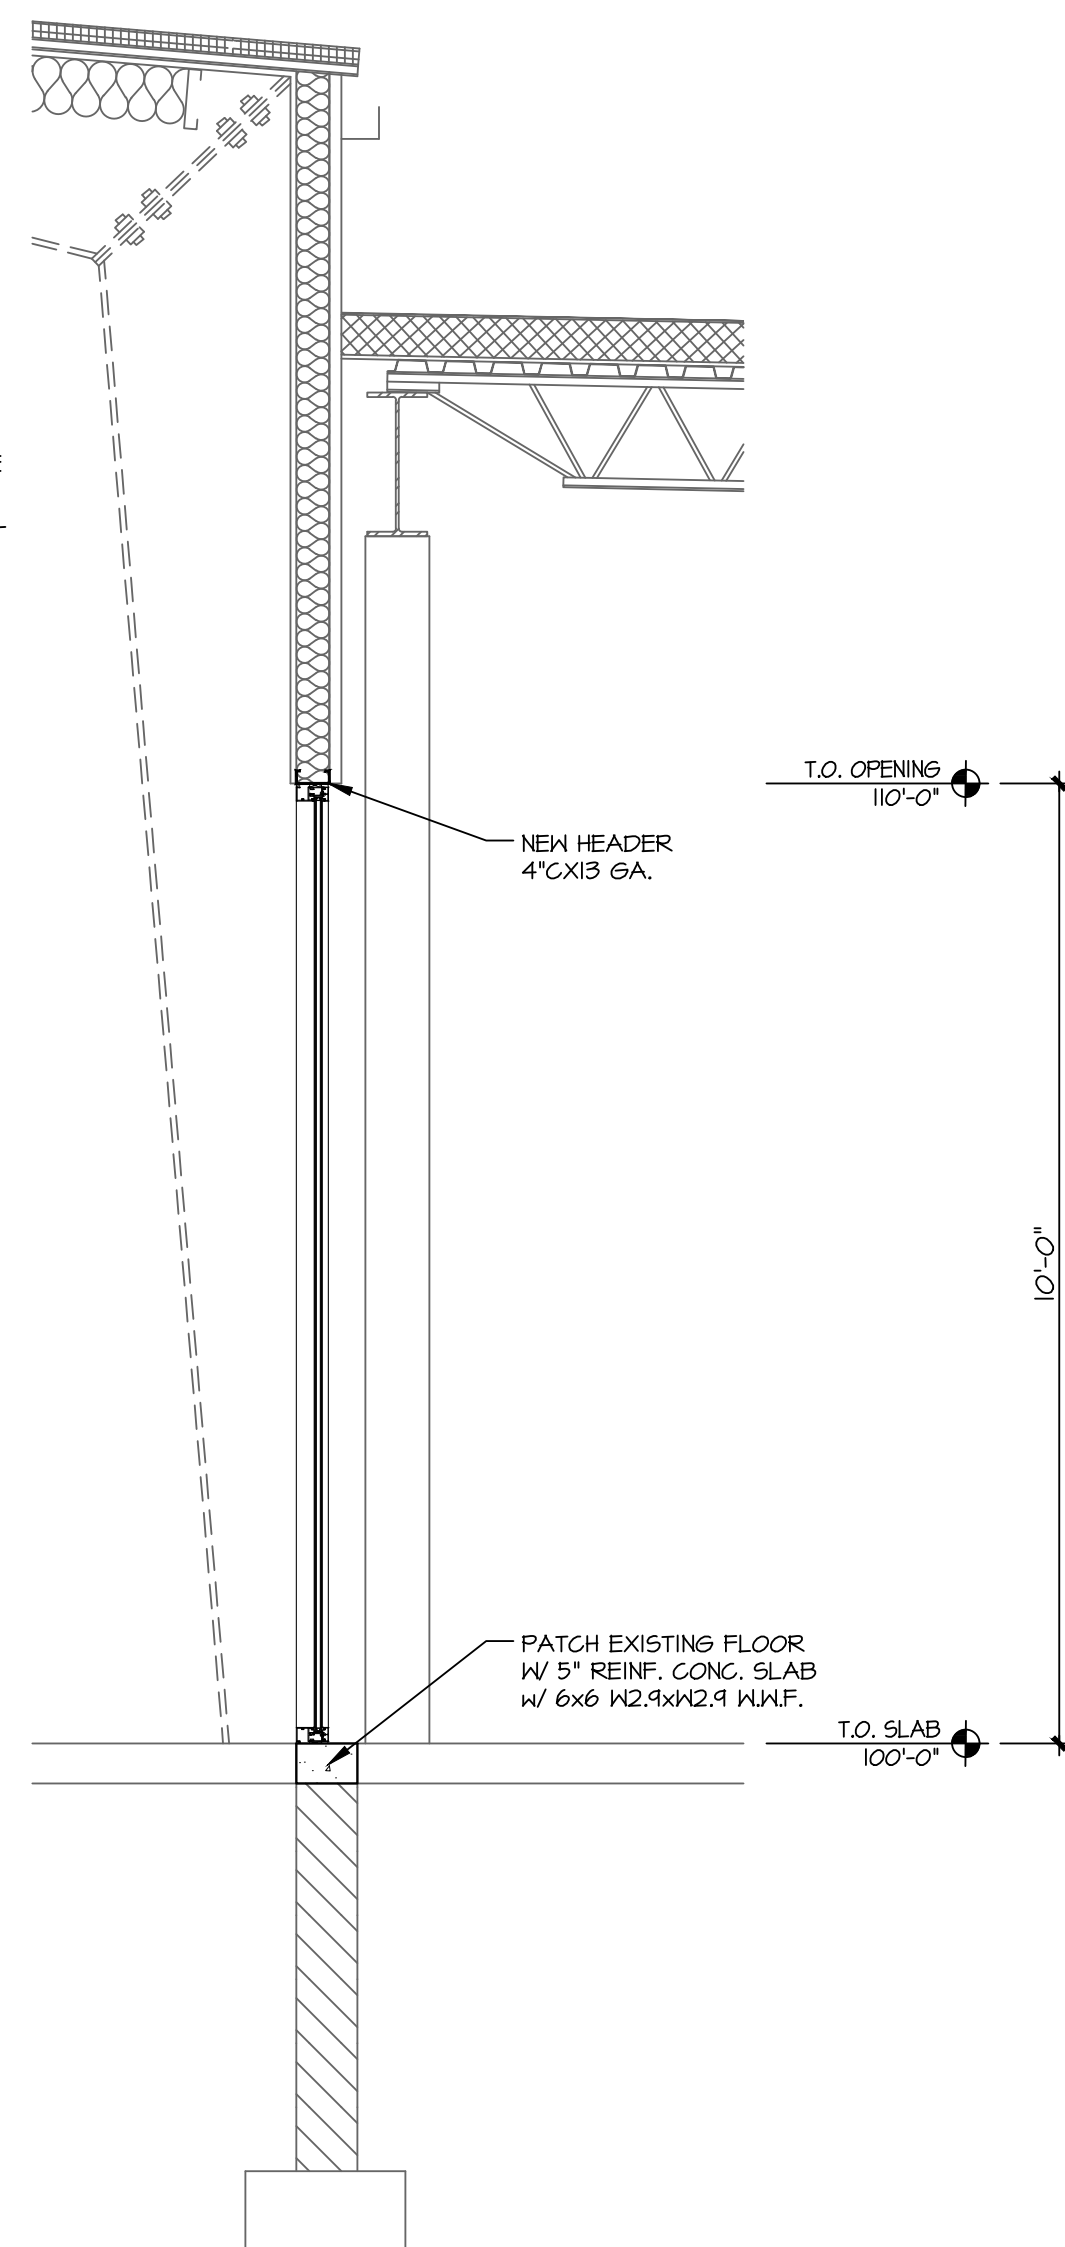


5 WALL SECTION
1/2" = 1'-0"

  


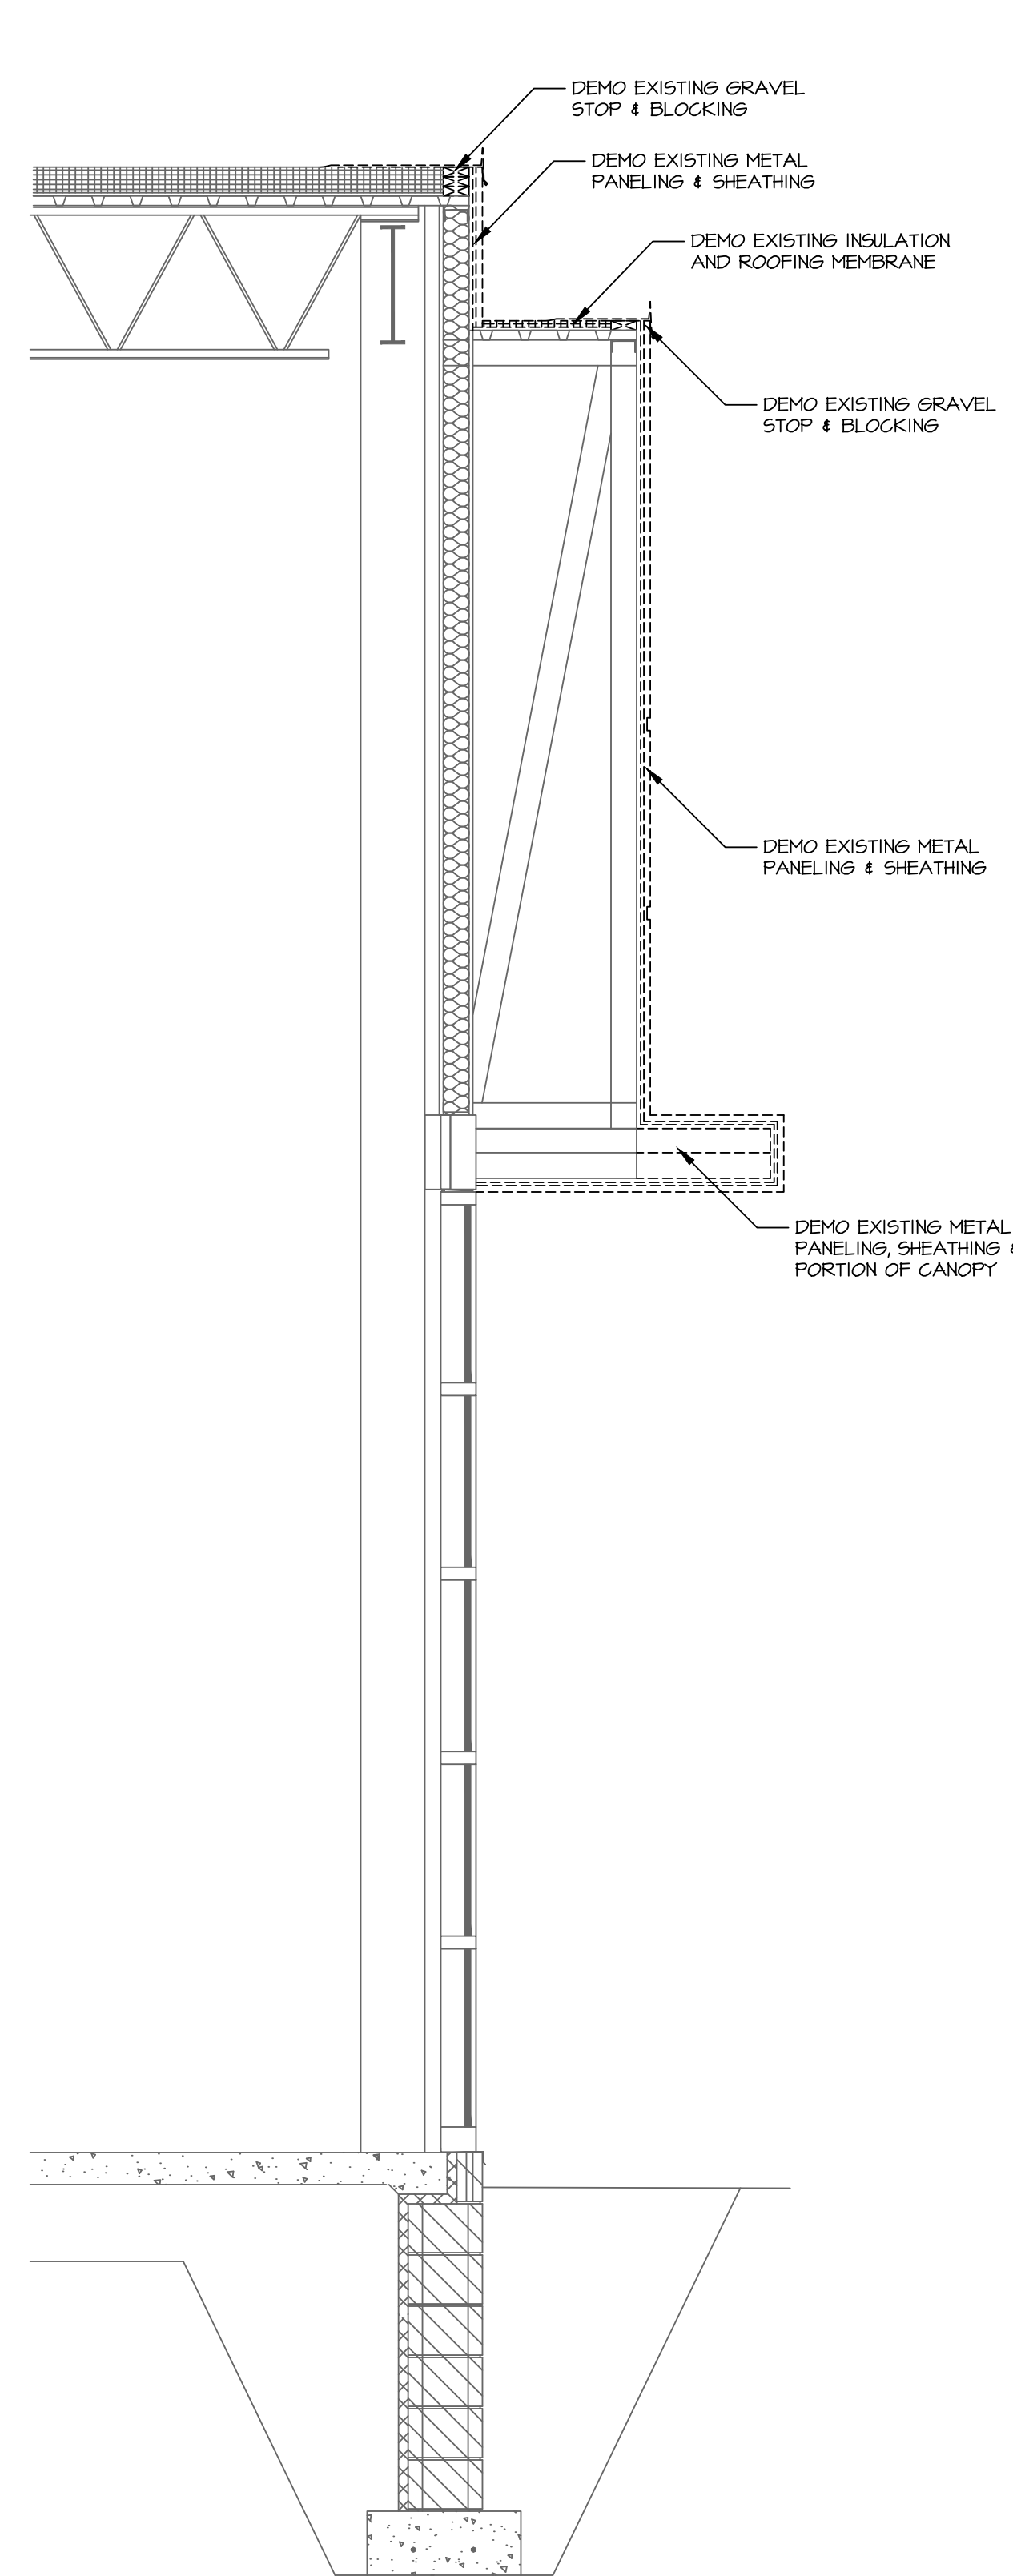

1 DEMO WALL SECTION
1/2" = 1'-0"

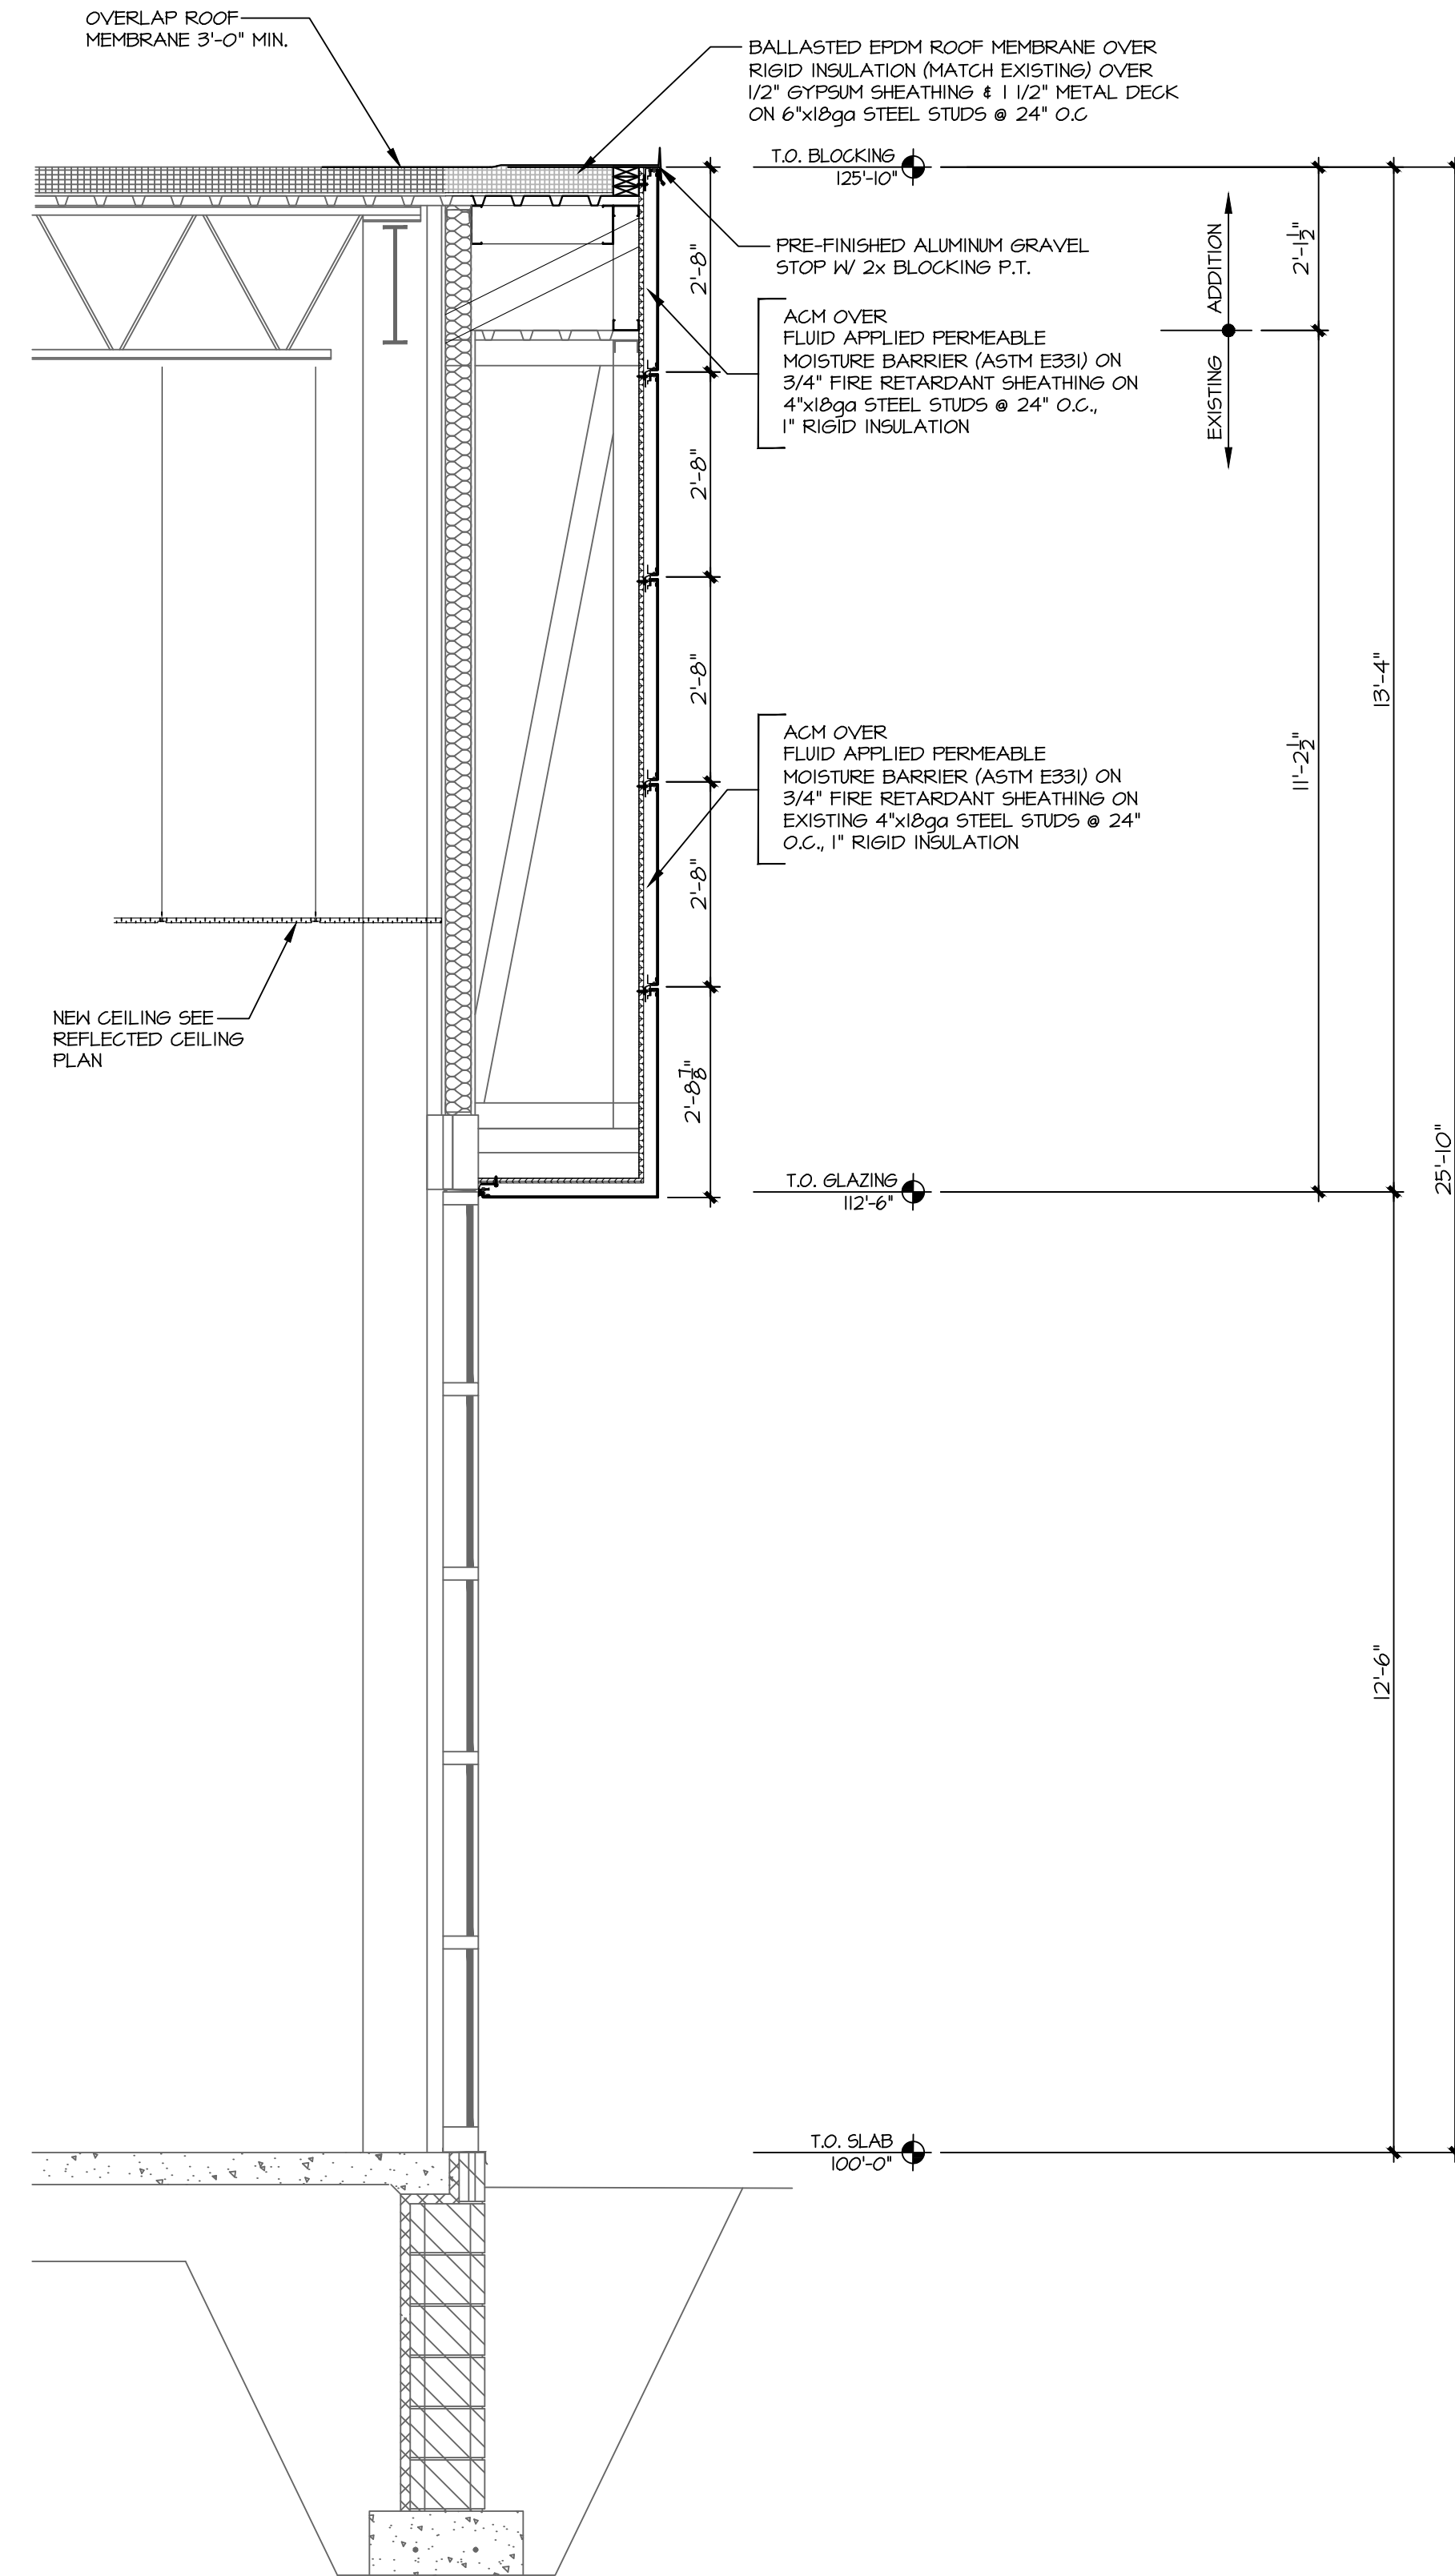


2 WALL SECTION
1/2" = 1'-0"

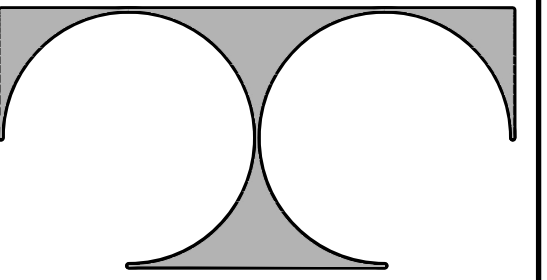

TDI ASSOCIATES, INC.
ARCHITECTURE & PLANNING

25217 SOUTH WIND LAKE ROAD
WIND LAKE, WISCONSIN 53185
PHONE 262-409-2530

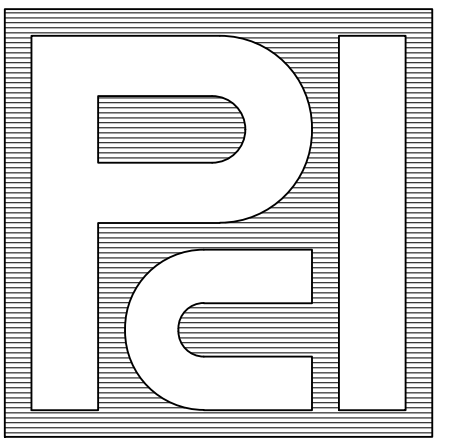

PROFESSIONAL
CONSULTANTS, INC.

300 COTTONWOOD AVE # 7
HARTLAND, WISCONSIN 53029
(262) 367-6080

RUSS DARROW
KIA OF WAUKESHA
2141 EAST MORELAND BLVD
WAUKESHA, WISCONSIN

TDI ASSOCIATES, INC
All Rights Reserved

OWNERSHIP OF DOCUMENTS

This document, and the ideas and design incorporated herein, as an instrument of professional service, is the sole property of TDI Associates, Inc., and is not to be used in whole or in part for any other project or purpose without the expressed written authorization of TDI Associates, Inc.

Sheet Title
WALL SECTIONS

Issued For: Date:

Date: 07-25-2024

Job NO.: 24103.000

Drawn By: LCC

Sheet No.

A3.3



25217 SOUTH WIND LAKE ROAD
WIND LAKE, WISCONSIN 53185
PHONE 262-409-2530



300 COTTONWOOD AVE #7
HARTLAND, WISCONSIN 53029
(262) 367-6080

RUSS DARROW
KIA OF WAUKESHA
2141 EAST MORELAND BLVD
WAUKESHA, WISCONSIN

TDI ASSOCIATES, INC
All Rights Reserved

OWNERSHIP OF DOCUMENTS

This document, and the ideas and design incorporated herein, as an instrument of professional service, is the sole property of TDI Associates, Inc., and is not to be used in whole or in part for any other project or purpose without the expressed written authorization of TDI Associates, Inc.

Sheet Title
WALL SECTIONS

Issued For: Date:
EV #2 06-27-2025


Date: 07-25-2024

Job NO.: 24103.000


Drawn By: LCC

Sheet No.


A3.4

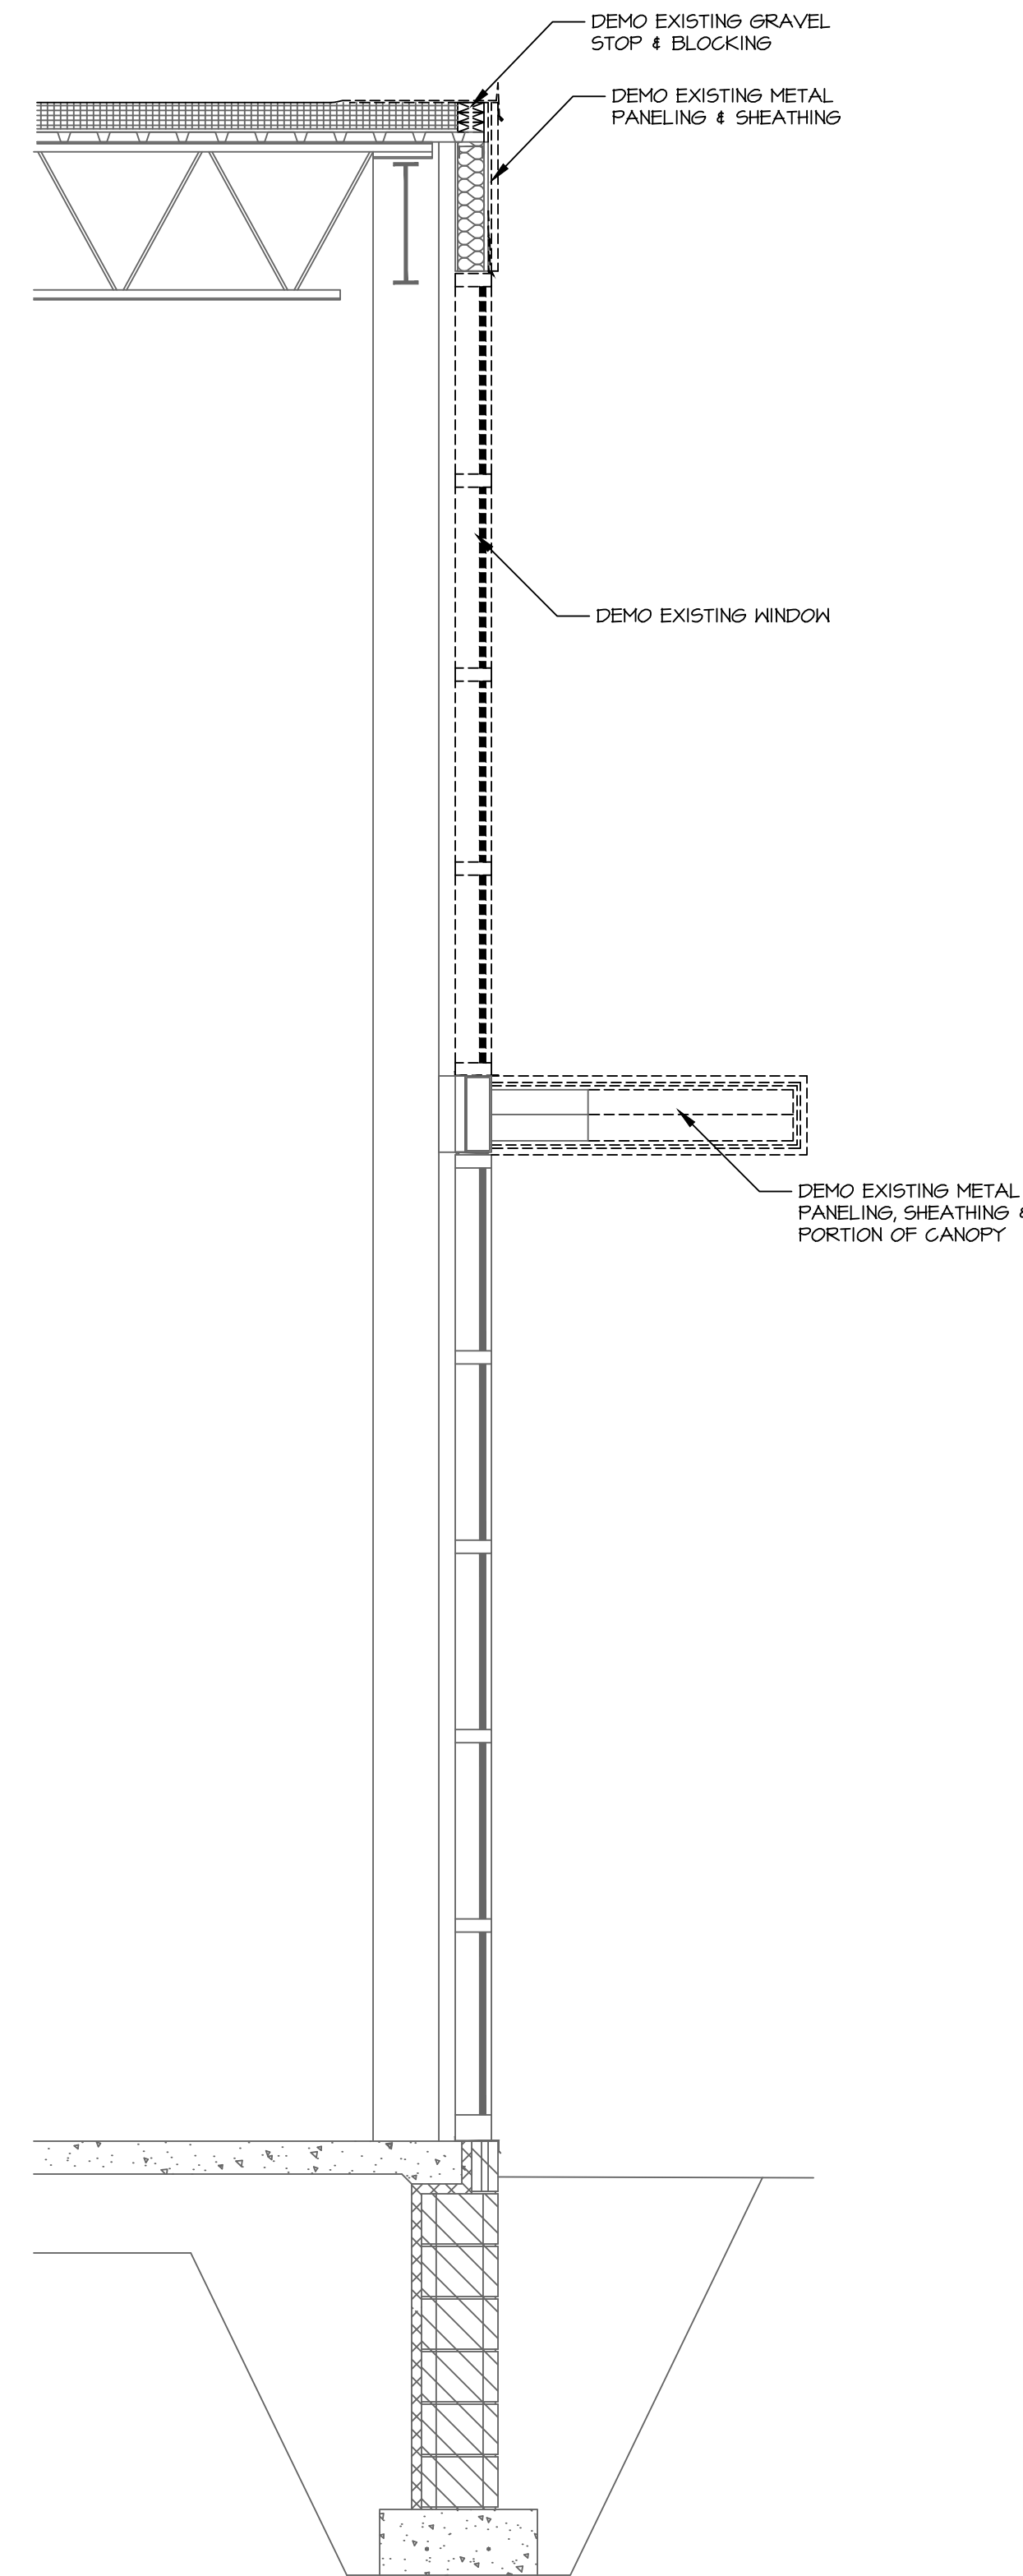

1 DEMO WALL SECTION
1/2" = 1'-0"

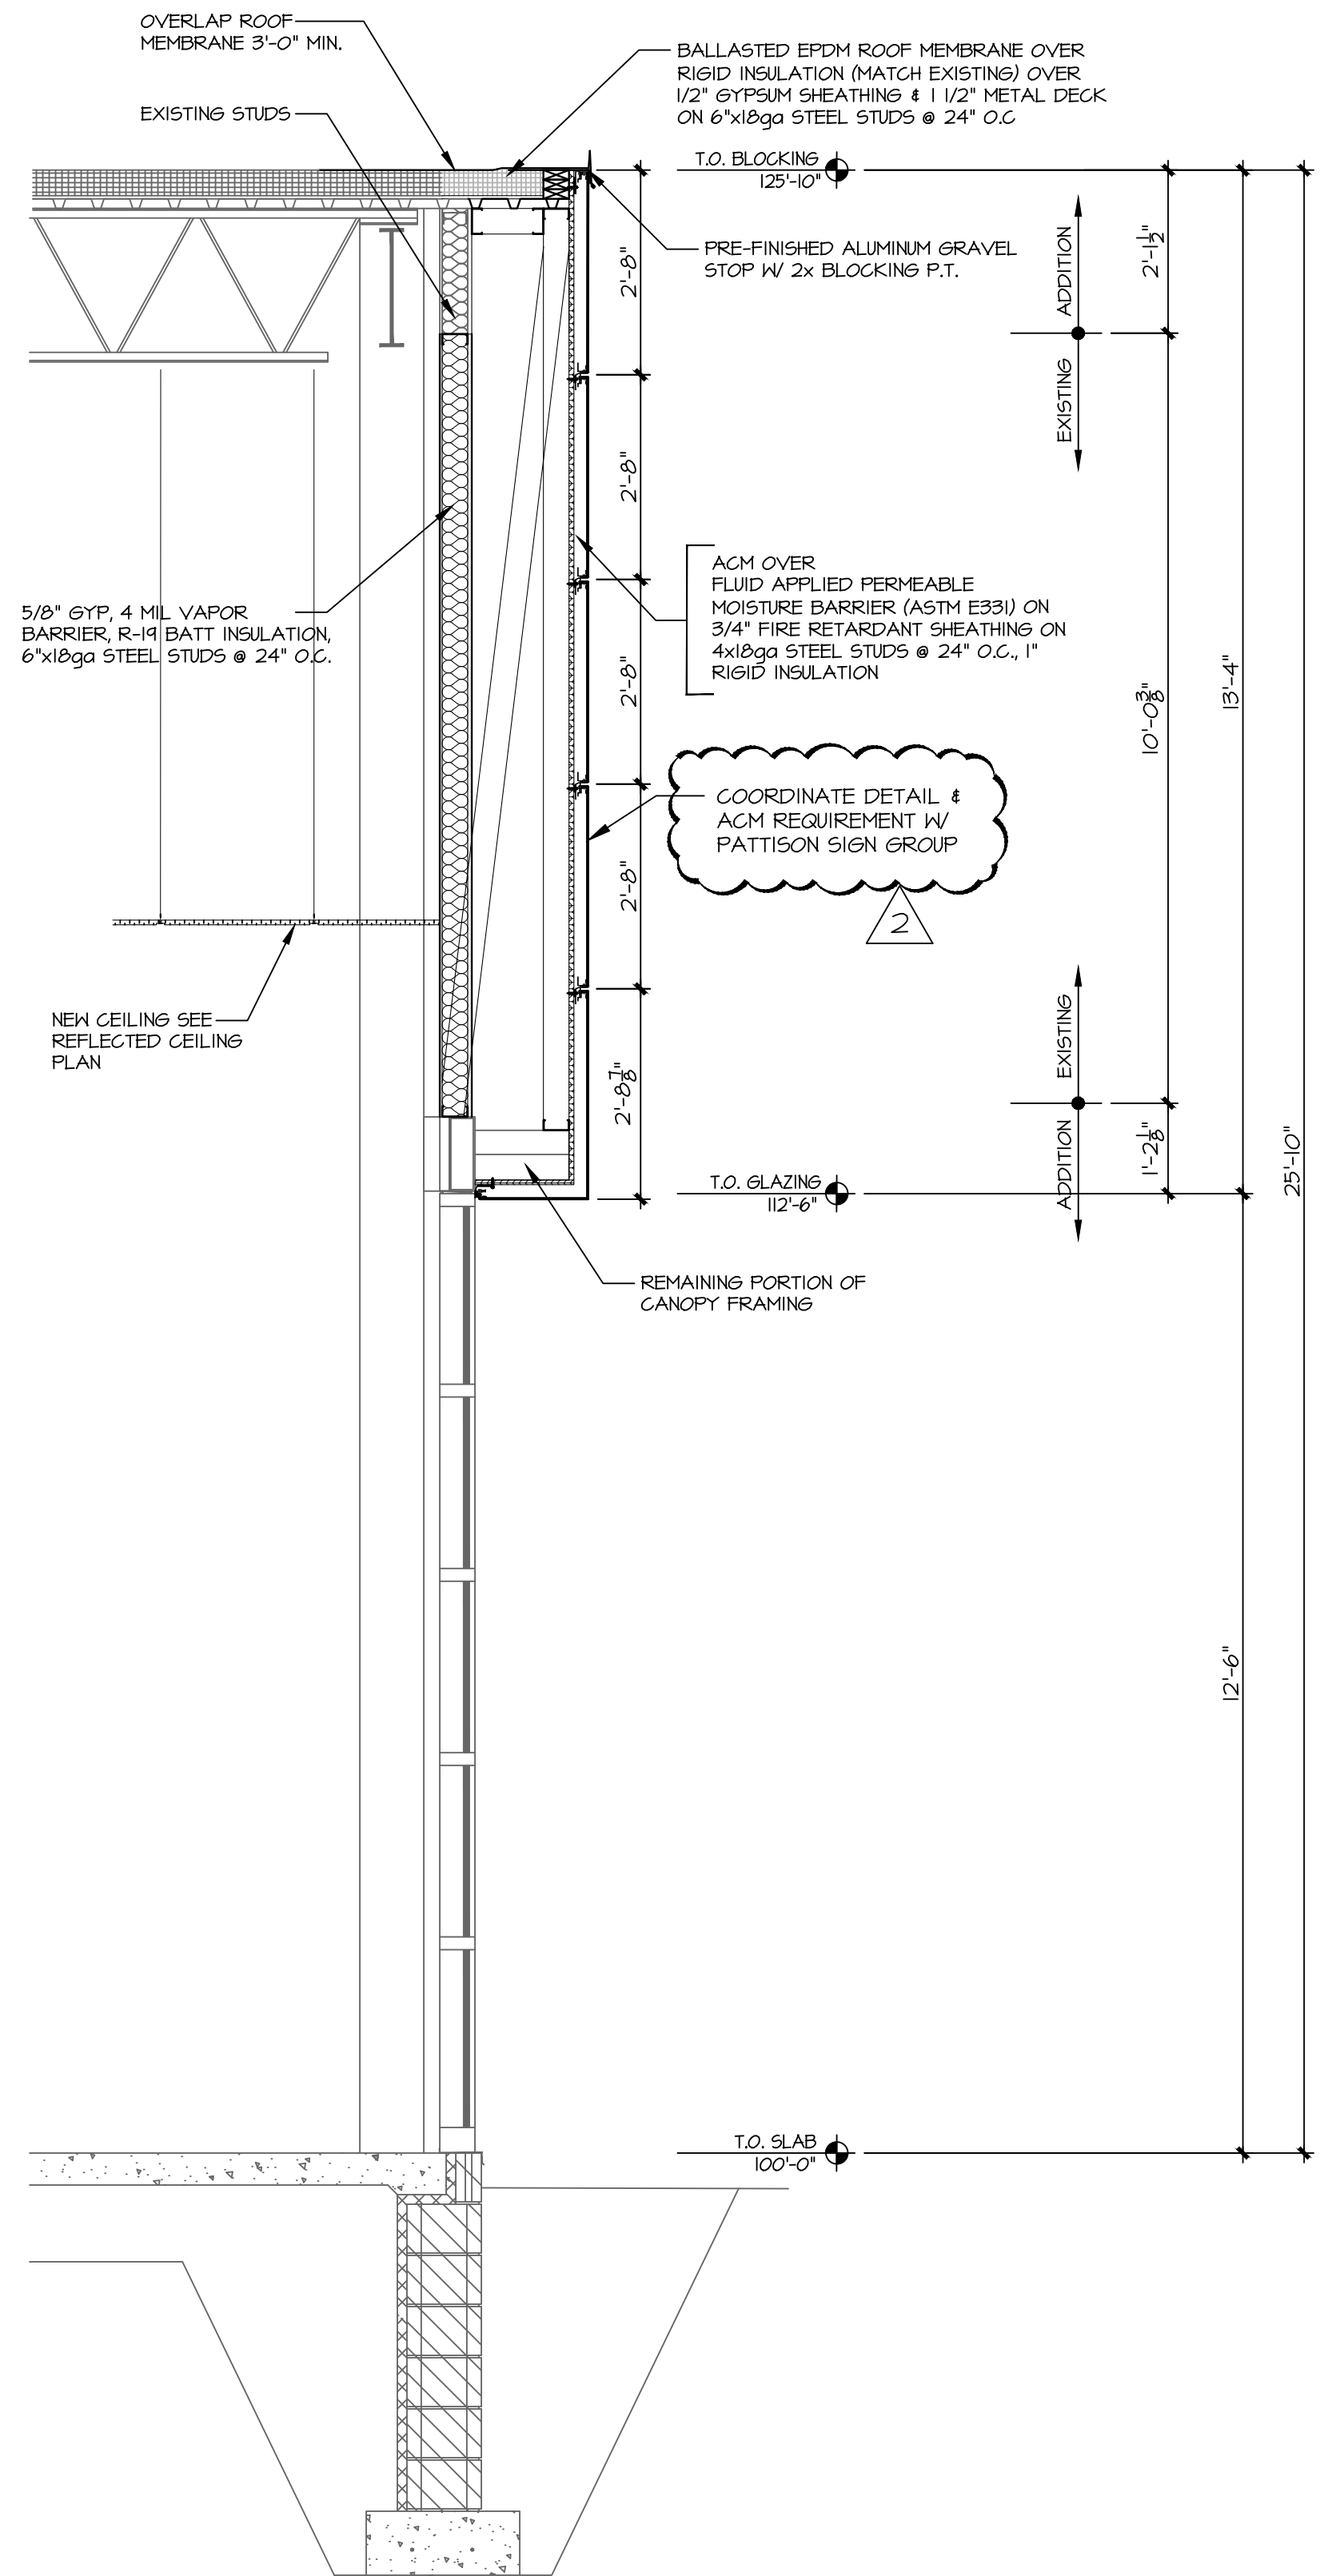

2 WALL SECTION
1/2" = 1'-0"

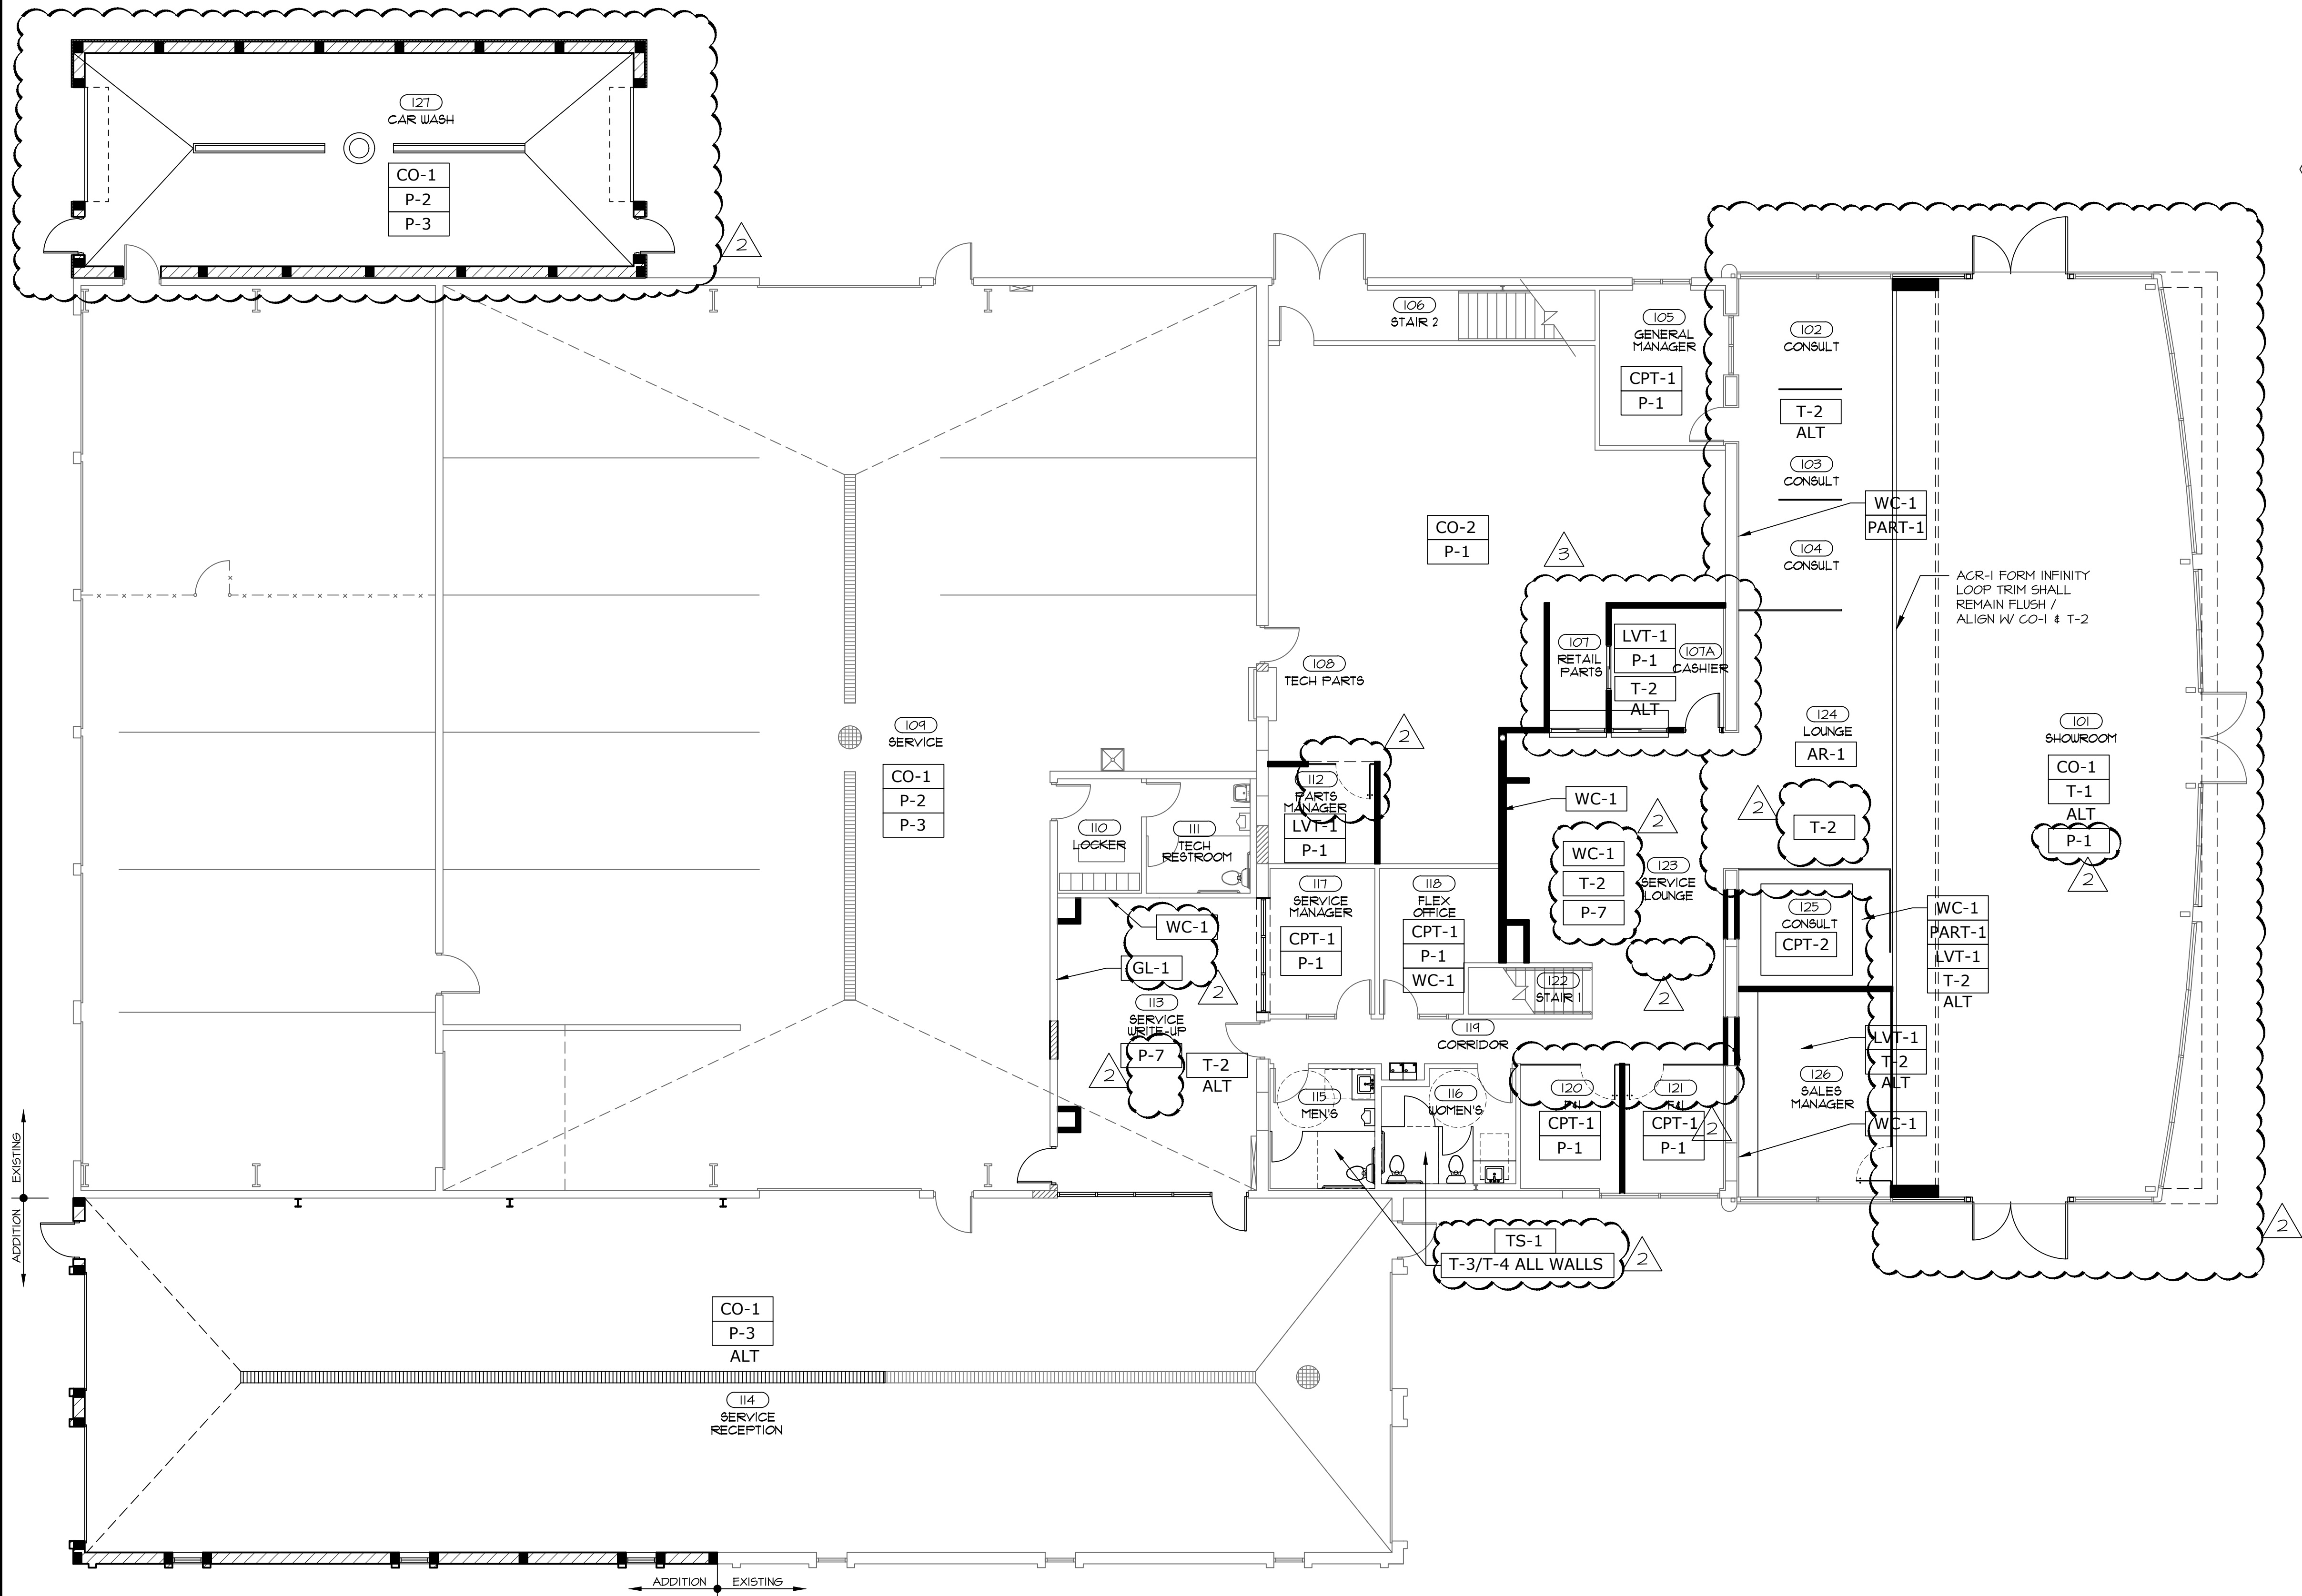

LEGEND	
#	NOTE DESIGNATOR - REFER TO DRAWING NOTES ON THIS SHEET
?-#	FLOOR FINISH DESIGNATOR - REFER TO INTERIOR FINISH SCHEDULES
?-#	WALL FINISH DESIGNATOR - REFER TO INTERIOR FINISH SCHEDULES


GENERAL NOTES

- A. REFER TO WALL FINISH SCHEDULE FOR WALL FINISH INFORMATION.
- B. REFER TO SHEET A6.1 FOR CEILING FINISHES.
- C. ALL FINISHES AND MATERIALS SHOULD BE IN ACCORDANCE WITH DESIGN MANUAL

DRAWING NOTES


- DOOR THRESHOLD.
- FLOORING TRANSITION REQUIRED.
- STEEL COLUMNS PAINTED P-3.
- WB-1, P-6 TO BE USED FOR ALL CUSTOMER FACING ROOMS WITH LVT.
- LINE TO BE PAINTED ON FLOOR FINISH.
- INFINITE LOOP FLOOR TRANSITION. 3" WIDE EPOXY-3 PAINTED STRIPE.
- WB-2 TO BE USED FOR ALL ROOMS WITH CARPET AND BACK OF HOUSE ROOMS.
- RUG TO EITHER BE AR-1, AR-2 OR AR-3 DEPENDING ON LOUNGE SIZE RESTRICTIONS. REFER TO FINISH SCHEDULE FOR DIMENSIONS.

1 FIRST FLOOR FINISH PLAN
1/8"=1'-0"

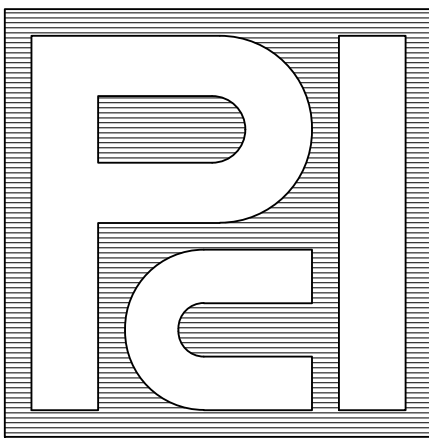


INTERIOR FINISH SCHEDULE

CODE									
MATERIAL									
NOTES									
LOCATION									
MANUFACTURER									
PRODUCT									
FINISH/COLOR									
DIMENSION									
WEBSITE									
MANUFACTURER REPRESENTATIVE CONTACT INFORMATION									
ACT-1	ACOUSTICAL CEILING TILES	CONTRACTOR TO COORDINATE ALL ADDITIONAL PARTS AND SYSTEMS THAT ARE RECOMMENDED BY THE MANUFACTURER TO COMPLETE INSTALL.	SEE RCP	ARMSTRONG	LYRA PB CONCEALED TIER 84395	COLOR: WHITE (W1) EDGE: REVEALED CONCEALED 15/16 SUSPENSION SYSTEM: WHITE	24" W X 48" L	https://www.armstrongceilings.com/commercial/en/commercial-ceilings/walls/lyra-concealed-ceilings.html#?query=LYRA	COMPANY: ARMSTRONG WORLD INDUSTRIES NAME: DEBORAH L. PICKENS P: 480-695-9053 E: D.PICKENS@ARMSTRONGCEILING.COM WWW.ARMSTRONGCEILING.COM
ACT-2	ACOUSTICAL CEILING TILES	CONTRACTOR TO COORDINATE ALL ADDITIONAL PARTS AND SYSTEMS THAT ARE RECOMMENDED BY THE MANUFACTURER TO COMPLETE INSTALL.	SEE RCP	ARMSTRONG	ACOUSTIBUILD SEAMLESS ACOUSTICAL CEILING SYSTEM TIER 2804	COLOR: FINE WHITE TEXTURE FINISH (FW) EDGE: EDGE: TAPERED	48" W X 72" L	https://www.armstrongceilings.com/commercial/en/commercial-ceilings/walls/acoustibuild-ceilings-panels.html	COMPANY: ARMSTRONG WORLD INDUSTRIES NAME: DEBORAH L. PICKENS P: 480-695-9053 E: D.PICKENS@ARMSTRONGCEILING.COM WWW.ARMSTRONGCEILING.COM
ACR-1	NON-ILLUMINATED INFINITY LOOP	CONTRACTOR TO COORDINATE ALL ADDITIONAL PARTS AND SYSTEMS THAT ARE RECOMMENDED BY THE MANUFACTURER TO COMPLETE INSTALL.	SEE FLOOR PLAN AND RCP	3 FORM	VARIA	COLOR: 50-57292.01 / LD: 1065373 CLEAR SURFACE FINISH: STUCCO COLORED SURFACE FINISH: STUCCO	THICKNESS: 3/8"	https://3-form.com/materials/varia	COMPANY: 3FORM NAME: SUSAN STUDER P: 800-453-4050 E: SUSAN.STUDER@3FORM.COM WWW.3-FORM.COM
AR-1	AREA RUG	CONTRACTOR TO COORDINATE ALL ADDITIONAL PARTS AND SYSTEMS THAT ARE RECOMMENDED BY THE MANUFACTURER TO COMPLETE INSTALL.	LOUNGE	SHAW CONTRACT	STYLE: INHERIT SA229 WEIGHT: 32 OZ. BACKING: NON-SOD RUBBER BACKING EDGE: RUBBER REDUCER, COLOR: 00114 LUNAR DUST	COLOR: GREY SLATE 64535 MANUFACTURING LAYOUT: 749588_RUG A / 749588_RUG B / 749588_RUG C	12" DIAMETER / 10" DIAMETER / 8" DIAMETER	https://www.shawcontract.com/en-us/products/SA229/	COMPANY: SHAW CONTRACT NAME: LAUREN THOMAS E: LAUREN.HULLNER.THOMAS@SHAWCONTRACT.COM WWW.SHAWCONTRACT.COM
AR-2	SQUARE RUG	CONTRACTOR TO COORDINATE ALL ADDITIONAL PARTS AND SYSTEMS THAT ARE RECOMMENDED BY THE MANUFACTURER TO COMPLETE INSTALL.	LOUNGE	SHAW CONTRACT	STYLE: INHERIT SA229 WEIGHT: 32 OZ. BACKING: NON-SOD RUBBER BACKING EDGE: RUBBER REDUCER, COLOR: 00114 LUNAR DUST	COLOR: GREY SLATE 64535 MANUFACTURING LAYOUT: 749588_RUG A / 749588_RUG B / 749588_RUG C	10' X 10' SQUARE	https://www.shawcontract.com/en-us/products/SA229/	COMPANY: SHAW CONTRACT NAME: LAUREN THOMAS E: LAUREN.HULLNER.THOMAS@SHAWCONTRACT.COM WWW.SHAWCONTRACT.COM
CD-1	CONCRETE DYE	FINISHING GRADE 1 = EXPOSES THE SAND PARTICLES IN THE CONCRETE. THE GRADE 1 FINISH SHOULD RESULT IN A "CREAMY LOOKING" SURFACE AND HAS THE MOST CONSISTENT APPEARANCE. FINISH CLASS 2: (SPECIFIED AS 800 GRIT) RESULTS IN A SURFACE THAT EXHIBITS A MODERATE LEVEL OF SPECULAR REFLECTIVITY. THIS FLOOR WITH BE REFLECTING, BUT WILL NOT BE "MIRROR-LIKE"	SHOWROOM, SERVICE RECEPTION, VEHICLE DELIVERY (VAC) / PHOTO BOOTH	SIKA	SCOFIELD FORMULA ONE LIQUID DYE FINISHING GRADE: GRADE 1 FINISHING CLASS: 2	COLOR: G388 SOFT GRAY	REFERENCE CONSTRUCTION DOCUMENTS	https://usa.sika.com/en/construction/concrete/decorative-concrete/stains-dyes/scsfeld-formulaone-liquid-dye-concrete.html	COMPANY: Sika NAME: CUSTOMER SERVICE P: 800-453-4050 WWW.SIKA.COM
CO-2	CONCRETE	CONTRACTOR TO PREP SUBSTRATE AS RECOMMENDED BY THE MANUFACTURER	PARTS, TOOLS, RECEIVING	TO BE DETERMINED BY CONTRACTOR	CONTRACTOR TO SEAL CONCRETE SLAB WITH INDUSTRIAL SEALER THAT CAN WITHSTAND WATER AND HARSH CHEMICALS	COLOR: CLEAR	REFERENCE CONSTRUCTION DOCUMENTS	N/A	N/A
CPT-1	CARPET TILE	CONTRACTOR TO PREP SUBSTRATE AS RECOMMENDED BY THE MANUFACTURER INSTALLATION: ASHLAR PATTERN	OFFICES, SEE FINISH PLAN	SHAW CONTRACT	COLLECTION: COLLECTIVE STYLE: ST408 COLLECTIVE TILE CONSTRUCTION: MULTI-LEVEL PATTERN LOOP FIBER: 100% SOLUTION DYED ECO SOLUTION Q NYLON BACKING: ECOWORK TILE	COLOR: BLACK 38505	9" W X 36" L	https://www.shawcontract.com/en-us/product/details/ST408/colours/38505	COMPANY: SHAW CONTRACT NAME: LAUREN THOMAS E: LAUREN.HULLNER.THOMAS@SHAWCONTRACT.COM WWW.SHAWCONTRACT.COM
CPT-2	CARPET TILE	CONTRACTOR TO PREP SUBSTRATE AS RECOMMENDED BY THE MANUFACTURER INSTALLATION: ASHLAR PATTERN	CARPET INSET AT SEMI-ENCLOSED CONSULTATION OFFICES	SHAW CONTRACT	COLLECTION: WEST ELM + SHAW CONTRACT STYLE: ST489 SPARK TILE CONSTRUCTION: MULTI-LEVEL PATTERN CUT/LOOP FIBER: 100% SOLUTION DYED ECO SOLUTION Q NYLON BACKING: ECOWORK TILE	COLOR: BRIO- COLOR 87485	24" W X 24" L	https://www.shawcontract.com/en-us/products/ST489/colours/87485	COMPANY: SHAW CONTRACT NAME: LAUREN THOMAS E: LAUREN.HULLNER.THOMAS@SHAWCONTRACT.COM WWW.SHAWCONTRACT.COM
EPOXY-1	EPOXY	REFERENCE MANUFACTURER'S GUIDELINES FOR SURFACE PREP AND INSTALLATION	SERVICE FLOOR	FLOROCK	FLUID-APPLIED FLOORING TYPE IAP-4: EPOXY FLOOR, FOLLOWED BY CHEMICAL RESISTANT HIGH WEAR URETHANE. 1: PRIMER COAT: TWO-COMPONENT EPOXY. APPLY AT 10-12 MILS. A: PRODUCT: FLOROCK FLOROPOXY 4200 2: OVERLAY: EPOXY AND SAND AGGREGATE MIXTURE TROWELED IN PLACE, APPLIED AT 1/4" THICKNESS A: PRODUCT: FLOROCK FLOROPOXY 4865 B: COLOR: BLACK 3: GROUT COAT: HIGH-PERFORMANCE EPOXY RESIN. APPLY AT 16 MILS. A: PRODUCT: FLOROCK FLOROPOXY 4865 B: COLOR: BLACK 4: GROUT COAT: HIGH-PERFORMANCE EPOXY RESIN. APPLY AT 16 MILS A: PRODUCT: FLOROCK FLOROPOXY 4805 B: COLOR: BLACK 5: TOPCOAT - URETHANE TOP COAT: FLOROTHAN MC HT A: COLOR: BLACK B: SLIP RESISTANCE AS REQUIRED	COLOR: BLACK FINISH: GLOSS TEXTURE: SAND	REFERENCE CONSTRUCTION DOCUMENTS	https://www.florock.net/	COMPANY: FLOROCK NAME: BUCK OLENIK P: 616-915-4840 E: BUCK.OLENIK@FLOROCK.NET WWW.FLOROCK.NET
EPOXY-2	EPOXY	REFERENCE MANUFACTURER'S GUIDELINES FOR SURFACE PREP AND INSTALLATION	SERVICE FLOOR	FLOROCK	FLUID-APPLIED FLOORING TYPE IAP-4: EPOXY FLOOR, FOLLOWED BY CHEMICAL RESISTANT HIGH WEAR URETHANE. 1: PRIMER COAT: TWO-COMPONENT EPOXY. APPLY AT 10-12 MILS. A: PRODUCT: FLOROCK FLOROPOXY 4200 2: OVERLAY: EPOXY AND SAND AGGREGATE MIXTURE TROWELED IN PLACE, APPLIED AT 1/4" THICKNESS A: PRODUCT: FLOROCK FLOROPOXY 4865 B: COLOR: LIGHT GREY 3: GROUT COAT: HIGH-PERFORMANCE EPOXY RESIN. APPLY AT 16 MILS. A: PRODUCT: FLOROCK FLOROPOXY 4865 B: COLOR: LIGHT GREY 4: GROUT COAT: HIGH-PERFORMANCE EPOXY RESIN. APPLY AT 16 MILS A: PRODUCT: FLOROCK FLOROPOXY 4805 B: COLOR: LIGHT GREY 5: TOPCOAT - URETHANE TOP COAT: FLOROTHAN MC HT A: COLOR: LIGHT GREY B: SLIP RESISTANCE AS REQUIRED	COLOR: LIGHT GREY FINISH: GLOSS TEXTURE: SAND	REFERENCE CONSTRUCTION DOCUMENTS	https://www.florock.net/	COMPANY: FLOROCK NAME: BUCK OLENIK P: 616-915-4840 E: BUCK.OLENIK@FLOROCK.NET WWW.FLOROCK.NET
EPOXY-3	EPOXY	REFERENCE MANUFACTURER'S GUIDELINES FOR SURFACE PREP AND INSTALLATION	INFINITY LOOP	FLOROCK	FLUID-APPLIED FLOORING TYPE IAP-4: EPOXY FLOOR, FOLLOWED BY CHEMICAL RESISTANT HIGH WEAR URETHANE. 1: PRIMER COAT: TWO-COMPONENT EPOXY. APPLY AT 10-12 MILS. A: PRODUCT: FLOROCK FLOROPOXY 4200 2: OVERLAY: EPOXY AND SAND AGGREGATE MIXTURE TROWELED IN PLACE, APPLIED AT 1/4" THICKNESS A: PRODUCT: FLOROCK FLOROPOXY 4865 B: COLOR: PMS 180C 3: GROUT COAT: HIGH-PERFORMANCE EPOXY RESIN. APPLY AT 16 MILS. A: PRODUCT: FLOROCK FLOROPOXY 4865 B: COLOR: PMS 180C 4: GROUT COAT: HIGH-PERFORMANCE EPOXY RESIN. APPLY AT 16 MILS A: PRODUCT: FLOROCK FLOROPOXY 4805 B: COLOR: PMS 180C 5: TOPCOAT - URETHANE TOP COAT: FLOROTHAN MC HT A: COLOR: PMS 180C B: SLIP RESISTANCE AS REQUIRED	COLOR: TO MATCH PMS 180C FINISH: GLOSS TEXTURE: SMOOTH	REFERENCE CONSTRUCTION DOCUMENTS	https://www.florock.net/	COMPANY: FLOROCK NAME: BUCK OLENIK P: 616-915-4840 E: BUCK.OLENIK@FLOROCK.NET WWW.FLOROCK.NET
GF-1	GLASS FILM	CONTRACTOR TO COORDINATE ALL ADDITIONAL PARTS AND SYSTEMS THAT ARE RECOMMENDED BY THE MANUFACTURER TO COMPLETE INSTALL.	ALL SHOWROOM AND LOUNGE AREA GLASS	DECORATIVE FILMS	SOLIX GLASS FINISHES	COLOR: SKJ -0548 DUAL FEATHER GRADIENT	60" WIDE ROLL	https://www.decorativefilm.com/skj-0548-dual-feather-gradient	COMPANY: DECORATIVE FILM NAME: IBRAHYMA MANIRAT P: 888-823-3224 F: 240-363-4818 E: N/A WWW.DECORATIVEFILM.COM
GL-1	GLASS	CONTRACTOR RESPONSIBLE TO COORDINATE APPROPRIATE HARDWARE WITH MANUFACTURER	BRAND WALL	SKYLINE GLASS	VITRACOLOR BACK-PAINTED LOW-IRON TEMPERED SAFETY GLASS	COLOR: CUSTOM TO MATCH PMS 7547 C	MAX PANEL SIZE: 48" X 144" 1/4" THICKNESS	https://skydesign.com/glass_type/vitracolor-back-painted-glass/	COMPANY: SKYLINE DESIGN NAME: ANTHONY HAMMOND E: ANTHONY.H@SKYDESIGN.COM SALES@SKYDESIGN.COM WWW.SKYDESIGN.COM
LVT-1	LUXURY VINYL TILE	ALTERNATE TO T-3 PREP AND PRIME SURFACES PER MANUFACTURER'S RECOMMENDATIONS	LOUNGE AREAS, CONSULT AREAS, CORRIDORS	MATTER SURFACES	WINEO PURLINE LVT, WOOD XL	COLOR: CRAFTED OAK	10" W X 59" L	https://mattersurfaces.com/purline-crafted-oak	COMPANY: MATS INC. NAME: MARK SADANUSKAS P: 781-573-0216 F: 781-573-0216 E: MSADANUSKAS@MATSINC.COM WWW.MATSINC.COM
LVT-1 ALT	LUXURY VINYL TILE	ALTERNATE TO LVT-1 PREP AND PRIME SURFACES PER MANUFACTURER'S RECOMMENDATIONS	LOUNGE AREAS, CONSULT AREAS, CORRIDORS	AUTOSTONE	LV WOODPLANK	COLOR: MAPLE BEECH FINISH: TEXTURE WOOD GRAIN	7" W X 48" L	https://autostoneusa.com/la/	COMPANY: AUTOSTONE USA NAME: BARRY WELLS P: 214-889-1265 E: KJAB@AUTOSTONEUSA.COM WWW.AUTOSTONEUSA.COM
P-1	PAINT	PREP AND PRIME SURFACES PER MANUFACTURER'S RECOMMENDATIONS	WALLS UNLESS NOTED OTHERWISE	BENJAMIN MOORE	AURA WATERBORNE INTERIOR ACRYLIC LATEX PAINT FINISH: FLAT FOR CEILINGS / SOFFITS FINISH: EGGSHELL FOR WALLS	COLOR: OC-61 WHITE DIAMOND FINISH: FLAT FOR CEILINGS / SOFFITS FINISH: EGGSHELL FOR WALLS	N/A	https://store.benjaminmoore.com/storefront/us/en/coating/interior-paints/benjamin-moore-aura-waterborne-interior-paint/aura/lyN521 https://store.benjaminmoore.com/storefront/us/en/coating/interior-paints/benjamin-moore-aura-waterborne-interior-paint/aura/lyN524	COMPANY: BENJAMIN MOORE NAME: DOROTHY HAZINSKI P: 866-708-9181 M: 330-353-3850 E: DOROTHY.HAZINSKI@BENJAMINMOORE.COM WWW.BENJAMINMOORE.COM
P-2	PAINT	PREP AND PRIME SURFACES PER MANUFACTURER'S RECOMMENDATIONS	SHOWROOM SOFFIT, LOUNGE, VEHICLE DELIVERY (VDC)/PHOTO BOOTH WALLS	BENJAMIN MOORE	AURA WATERBORNE INTERIOR ACRYLIC LATEX PAINT FINISH: FLAT FOR SOFFITS FINISH: EGGSHELL FOR WALLS	COLOR: 2129-10 MIDNIGHT DREAM FINISH: FLAT FOR SOFFITS FINISH: EGGSHELL FOR WALLS	N/A	https://store.benjaminmoore.com/storefront/us/en/coating/interior-paints/benjamin-moore-aura-waterborne-interior-paint/aura/lyN522 https://store.benjaminmoore.com/storefront/us/en/coating/interior-paints/benjamin-moore-aura-waterborne-interior-paint/aura/lyN524	COMPANY: BENJAMIN MOORE NAME: DOROTHY HAZINSKI P: 866-708-9181 M: 330-353-3850 E: DOROTHY.HAZINSKI@BENJAMINMOORE.COM WWW.BENJAMINMOORE.COM
P-3	PAINT	PREP AND PRIME SURFACES PER MANUFACTURER'S RECOMMENDATIONS	SERVICE DRIVE WALLS AND SHOWROOM COLUMNS	BENJAMIN MOORE	AURA WATERBORNE INTERIOR ACRYLIC LATEX PAINT FINISH: EGGSHELL	COLOR: HC-169 COVENTRY GRAY FINISH: EGGSHELL	N/A	https://store.benjaminmoore.com/storefront/us/en/coating/interior-paints/benjamin-moore-aura-waterborne-interior-paint/aura/lyN524	COMPANY: BENJAMIN MOORE NAME: DOROTHY HAZINSKI P: 866-708-9181 M: 330-353-3850 E: DOROTHY.HAZINSKI@BENJAMINMOORE.COM WWW.BENJAMINMOORE.COM
P-4	PAINT	PREP AND PRIME SURFACES PER MANUFACTURER'S RECOMMENDATIONS	DOORS	BENJAMIN MOORE	AURA WATERBORNE INTERIOR ACRYLIC LATEX PAINT FINISH: EGGSHELL	COLOR: HC-169 COVENTRY GRAY FINISH: EGGSHELL	N/A	https://store.benjaminmoore.com/storefront/us/en/coating/interior-paints/benjamin-moore-aura-waterborne-interior-paint/aura/lyN524	COMPANY: BENJAMIN MOORE NAME: DOROTHY HAZINSKI P: 866-708-9181 M: 330-353-3850 E: DOROTHY.HAZINSKI@BENJAMINMOORE.COM WWW.BENJAMINMOORE.COM
P-6	PAINT	PREP AND PRIME SURFACES PER MANUFACTURER'S RECOMMENDATIONS	REFERENCE CONSTRUCTION DOCUMENTS	BENJAMIN MOORE	COROTEC CHAMAND WATERBORNE ACRYLIC URETHANE FINISH: EGGSHELL	COLOR: 1117 GUESTHOUSE FINISH: EGGSHELL	N/A	https://store.benjaminmoore.com/storefront/us/en/coating/interior-paints/stains/product-catalog/cwe/corotect-waterborne-enamels	COMPANY: BENJAMIN MOORE NAME: DOROTHY HAZINSKI P: 866-708-9181 M: 330-353-3850 E: DOROTHY.HAZINSKI@BENJAMINMOORE.COM WWW.BENJAMINMOORE.COM
P-7	PAINT	PREP AND PRIME SURFACES PER MANUFACTURER'S RECOMMENDATIONS	SHOWROOM WALLS AS NOTED	BENJAMIN MOORE	AURA WATERBORNE INTERIOR ACRYLIC LATEX PAINT FINISH: EGGSHELL	COLOR: OC-10 WHITE SAND FINISH: EGGSHELL	N/A	https://store.benjaminmoore.com/storefront/us/en/coating/interior-paints/paints/benjamin-moore-aura-waterborne-interior-paint/aura/lyN524	COMPANY: BENJAMIN MOORE NAME: DOROTHY HAZINSKI P: 866-708-9181 M: 330-353-3850 E: DOROTHY.HAZINSKI@BENJAMINMOORE.COM WWW.BENJAMINMOORE.COM
P-8	METALLIC PAINT	PREP AND PRIME SURFACES PER MANUFACTURER'S RECOMMENDATIONS	SHOWROOM WALLS AS NOTED, LOUNGE CEILING COVE	CRESCENT BRONZE POWDER CO.	METALLIC PIGMENTS AND PAINTS COLOR: PALE 251	COLLECTION: DESIGNER TONES COLOR: PALE 251	N/A	https://www.crescentbronze.com/product-page/black-12011p-metallic-powder	COMPANY: CRESCENT BRONZE POWDER CO. NAME: CUSTOMER SERVICE P: 800-445-6810 O: 800-230-3270 WWW.CRESCENTBRONZE.COM
P-9	PAINT	PREP AND PRIME SURFACES PER MANUFACTURER'S RECOMMENDATIONS	INFINITY LOOP	BENJAMIN MOORE	COROTEC CHAMAND WATERBORNE ACRYLIC URETHANE GLOSS V390 FINISH: EGGSHELL	COLOR: HC-181 HERITAGE RED FINISH: EGGSHELL	N/A	https://store.benjaminmoore.com/storefront/us/en/coating/interior-paints/stains/product-catalog/cwe/corotect-waterborne-enamels	COMPANY: BENJAMIN MOORE NAME: DOROTHY HAZINSKI P: 866-708-9181 M: 330-353-3850 E: DOROTHY.HAZINSKI@BENJAMINMOORE.COM WWW.BENJAMINMOORE.COM
P-10	METALLIC PAINT	PREP AND PRIME SURFACES PER MANUFACTURER'S RECOMMENDATIONS	INFINITY LOOP	CRESCENT BRONZE POWDER CO.	METALLIC PIGMENTS AND PAINTS COLOR: BLACK 781	COLOR: BLACK 781	N/A	https://www.crescentbronze.com/product-page/black-10111p-metallic-powder	COMPANY: CRESCENT BRONZE POWDER CO. NAME: CUSTOMER SERVICE P: 800-445-6810 O: 800-230-3270 WWW.CRESCENTBRONZE.COM
PC-1	INTERIOR POWDERCOAT	N/A	INFINITY LOOP	PRISMATIC POWDERS	INTERIOR GRADE POWDERCOAT FINISH: GLOSS	COLOR: RAL 3020 FINISH: GLOSS	REFERENCE CONSTRUCTION DOCUMENTS	https://www.prismaticpowders.com/shop/powder-coating-colors/	COMPANY: NIC INDUSTRIES NAME: ERIK GRAMHAM P: 541-830-6502 M: 541-830-6502 E: JESSIE@NICINDUSTRIES.COM WWW.PRISMATICPOWDERS.COM
PC-2	INTERIOR POWDERCOAT	N/A	BRAND WALL BASE	TIGER DRYLAC	INTERIOR GRADE POWDERCOAT FINISH: MATTE	COLOR: RAL 9005 49/82830 FINISH: MATTE	REFERENCE CONSTRUCTION DOCUMENTS	https://rl18.fronshite.com/RJowcl/specifierTIGEROrderform/index.html	COMPANY: TIGER DRYLAC NAME: MITCH ANGELES P: 310-961-5783 M: 620-593-3572 E: MITCH.ANGELES@TIGER-COATINGS.COM WWW.TIGER-COATINGS.COM

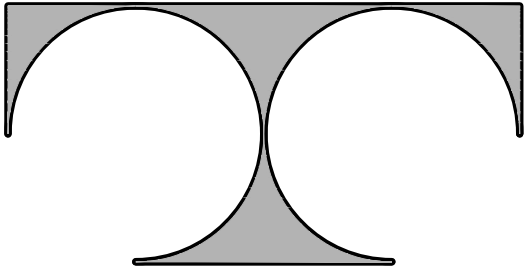

TDI ASSOCIATES, INC.
ARCHITECTURE & PLANNING

25217 SOUTH WIND LAKE ROAD
WIND LAKE, WISCONSIN 53185
PHONE 262-409-2530

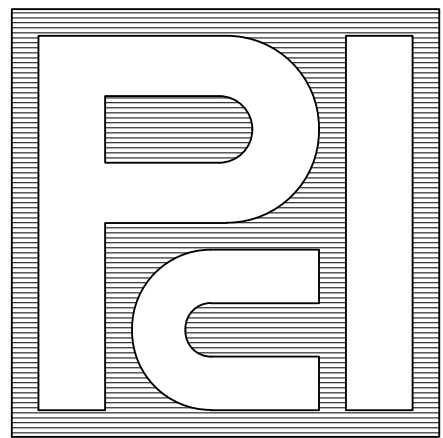

PROFESSIONAL
CONSULTANTS, INC.

300 COTTONWOOD AVE # 7
HARTLAND, WISCONSIN 53029
(262) 367-6080

RUSS DARROW
KIA OF WAUKESHA
2141 EAST MORELAND BLVD
WAUKESHA, WISCONSIN

TDI ASSOCIATES, INC
All Rights Reserved

OWNERSHIP OF DOCUMENTS

This document, and the ideas and design incorporated herein, as an instrument of professional service, is the sole property of TDI Associates, Inc., and is not to be used in whole or in part for any other project or purpose without the expressed written authorization of TDI Associates, Inc.

Sheet Title
INTERIOR
FINISH SCHEDULE

Issued For: Date:
REV #2 06-27-2025

Date: 07-25-2024

Job NO.: 24103.000


Drawn By: LCC

Sheet No.

A4.2


INTERIOR FINISH SCHEDULE CONTINUED

PC-3	INTERIOR POWDERCOAT	N/A	PART-1	PRISMATIC POWDERS	INTERIOR GRADE POWDERCOAT	COLOR: EMB-4448, TONIC GOLD II FINISH: SATN	REFERENCE CONSTRUCTION DOCUMENTS	EMB-4448/tonic-gold-II	P: 541-830-6502 M: 541-338-5551 E: JESSE@NCINDUSTRIES.COM WWW.PRISMATICPOWDERS.COM
PL-1	PLASTIC LAMINATE	N/A	FIXTURES, CUSTOMER FACING CABINETS, CUSTOMER FACING DOORS	WILSONART	STANDARD HIGH PRESSURE LAMINATE	COLOR: 7996-38 NATURAL RECON FINISH: FINE VELVET	REFERENCE CONSTRUCTION AND FIXTURE DOCUMENTS	https://www.wilsonart.com/natural-recon-7996	COMPANY: WILSONART NAME: LIZ MCILLAN P: 562-781-4057 E: MCILLE@WILSONART.COM WWW.WILSONART.COM
PL-3	PLASTIC LAMINATE	N/A	BATHROOM CABINETS	WILSONART	STANDARD HIGH PRESSURE LAMINATE	COLOR: BLACK #1595 FINISH: 60 MATTE	REFERENCE CONSTRUCTION AND FIXTURE DOCUMENTS	https://www.wilsonart.com/designer-white-0354	COMPANY: WILSONART NAME: LIZ MCILLAN P: 562-781-4057 E: MCILLE@WILSONART.COM WWW.WILSONART.COM
PL-4	PLASTIC LAMINATE	N/A	BACK OF HOUSE CABINETS	WILSONART	STANDARD HIGH PRESSURE LAMINATE	COLOR: CARBON MESH 4880-38 FINISH: FINE VELVET	REFERENCE CONSTRUCTION AND FIXTURE DOCUMENTS	https://www.wilsonart.com/carbon-mesh-4880	COMPANY: WILSONART NAME: LIZ MCILLAN P: 562-781-4057 E: MCILLE@WILSONART.COM WWW.WILSONART.COM
SS-1	SOLID SURFACE	N/A	FIXTURES, RESTROOMS, CUSTOMER FACING COUNTERS	LX HAUSYS	HI-MACS SOLID SURFACE	COLOR: KAMEI L017	REFERENCE CONSTRUCTION AND FIXTURE DOCUMENTS	https://www.lxhausys.com/us/products/html#himacs/Kamei/2551	COMPANY: LX HAUSYS NAME: MICHELLE ALLEN P: 513-214-9939 E: WALL@LXHAUSYS.COM WWW.LXHAUSYS.COM
SS-1 ALT	SOLID SURFACE	ALTERNATE TO SS-1	FIXTURES, RESTROOMS, CUSTOMER FACING COUNTERS	WILSONART	ACRYLIC RESIN BASED SOLID SURFACE	COLOR: WHITE STONE 9208CS	REFERENCE CONSTRUCTION AND FIXTURE DOCUMENTS	https://www.richelieu.com/us/en/category/surfaces-panels-and-edgebanding/colors/white-stone-9208cs-sheet/1201983/aku-w5080CS139	COMPANY: WILSONART NAME: LIZ MCILLAN P: 562-781-4057 E: MCILLE@WILSONART.COM WWW.WILSONART.COM
T-1	TILE	ALTERNATE TO CO-1 TO BE USED WHEN NEW CONCRETE CANNOT BE POURED INSTALL STACKBOND	RESTROOMS	AUTOSTONE	CERAMIC TILE	COLLECTION: CONCRETE COLOR: SHADOW AN13 FINISH: NATURAL, HOKED GROUT COLOR: MAPEI 27 SILVER	32" W X 32" L	solid-surfaces-wilsonart/wilsonart-solid-surfaces-particulate-https://autostoneusa.com/ku/	COMPANY: AUTOSTONE USA NAME: BARRY WELLS P: 214-850-1206 E: KBAB@AUTOSTONEUSA.COM WWW.AUTOSTONEUSA.COM
T-1 ALT	TILE	ALTERNATE TO T-1 TO BE USED WHEN NEW CONCRETE CANNOT BE POURED INSTALL STACKBOND	RESTROOMS	DALTILE	CERAMIC TILE	COLLECTION: ANDERS NAME: SHADOW AN13 FINISH: MATTE GROUT COLOR: MAPEI 27 SILVER	32" W X 32" L	https://www.daltile.com/products/Concrete-Look/Anders/Shadow	COMPANY: DALTILE NAME: DAVID SANTIBANEZ M: 562-644-4360 E: DAVID.SANTIBANEZ@DALTILE.COM WWW.DALTILE.COM
T-2	TILE	PREP AND PRIME SURFACES PER MANUFACTURER'S RECOMMENDATIONS	CUSTOMER SALES AREA, SALES AREA	CREATIVE MATERIALS CORP.	CERAMIC TILE	COLLECTION: INVO COLOR: GOLD FINISH: MATTE GROUT COLOR: MAPEI 05 CHAMOIS	8" W X 48" L	https://www.creativematerialscorp.com/product/invo/	COMPANY: CREATIVE MATERIALS CORPORATION NAME: DOUG SALATINO P: 518-713-5371 C: 518-261-8264 E: DSALATINO@CREATIVEMATERIALSCORP.COM WWW.CREATIVEMATERIALSCORP.COM
T-2 ALT1	TILE	ALTERNATE TO T-2 PREP AND PRIME SURFACES PER MANUFACTURER'S RECOMMENDATIONS	CUSTOMER SALES AREA, SALES AREA	AUTOSTONE	CERAMIC TILE	COLLECTION: AMBERWOOD PLAN COLOR: MAPLE HARVEST FINISH: NATURAL GROUT COLOR: MAPEI 05 CHAMOIS	8" W X 48" L	https://autostoneusa.com/ku/	COMPANY: AUTOSTONE USA NAME: BARRY WELLS P: 214-850-1206 E: KBAB@AUTOSTONEUSA.COM WWW.AUTOSTONEUSA.COM
T-2 ALT2	TILE	ALTERNATE TO T-2 PREP AND PRIME SURFACES PER MANUFACTURER'S RECOMMENDATIONS	CUSTOMER SALES AREA, SALES AREA	DALTILE	CERAMIC TILE	COLLECTION: FOREST PARK NAME: SUMMITREE P9990 FINISH: NATURAL GROUT COLOR: MAPEI 05 CHAMOIS	9" W X 36" L	https://www.daltile.com/products/wood-look/forest-park	COMPANY: DALTILE NAME: DAVID SANTIBANEZ M: 562-644-4360 E: DAVID.SANTIBANEZ@DALTILE.COM WWW.DALTILE.COM
T-3	TILE	PREP AND PRIME SURFACES PER MANUFACTURER'S RECOMMENDATIONS INSTALLED IN VERTICAL STACK BOND, 4'-0" TO UNDERSIDE OF CLG	RESTROOMS	CREATIVE MATERIALS CORP.	WALL TILE	COLLECTION: URBAN SUBWAY COLOR: WHITE FINISH: MATTE GROUT COLOR: MAPEI 77 FROST	3" W X 10" L	https://www.creativematerialscorp.com/product/tune/	COMPANY: CREATIVE MATERIALS CORPORATION NAME: DOUG SALATINO P: 518-713-5371 C: 518-261-8264 E: DSALATINO@CREATIVEMATERIALSCORP.COM WWW.CREATIVEMATERIALSCORP.COM
T-3 ALT1	TILE	ALTERNATE TO T-3 PREP AND PRIME SURFACES PER MANUFACTURER'S RECOMMENDATIONS INSTALLED IN VERTICAL STACK BOND, 4'-0" TO UNDERSIDE OF CLG	RESTROOMS	AUTOSTONE	WALL TILE	COLLECTION: STATION AMERICAN-A COLOR: WHITE SC23 FINISH: MATTE GROUT COLOR: MAPEI 77 FROST	4" W X 16" L	https://autostoneusa.com/ku/	COMPANY: AUTOSTONE USA NAME: BARRY WELLS P: 214-850-1206 E: KBAB@AUTOSTONEUSA.COM WWW.AUTOSTONEUSA.COM
T-3 ALT2	TILE	ALTERNATE TO T-3 PREP AND PRIME SURFACES PER MANUFACTURER'S RECOMMENDATIONS INSTALLED IN VERTICAL STACK BOND, 4'-0" TO UNDERSIDE OF CLG	RESTROOMS	DALTILE	WALL TILE	COLLECTION: STENCIL_FLAT FLOOR TILE COLOR: WHITE SC23 FINISH: MATTE GROUT COLOR: MAPEI 77 FROST	4" W X 12" L	https://www.daltile.com/products/Monochromatic-Look/Stencil/White	COMPANY: DALTILE NAME: DAVID SANTIBANEZ M: 562-644-4360 E: DAVID.SANTIBANEZ@DALTILE.COM WWW.DALTILE.COM
T-4	TILE	PREP AND PRIME SURFACES PER MANUFACTURER'S RECOMMENDATIONS INSTALLED IN VERTICAL STACK BOND, FINISH FLOOR TO 4'-0"	RESTROOMS (WAINSCOT)	CREATIVE MATERIALS CORP.	WALL TILE	COLLECTION: URBAN SUBWAY COLOR: WHITE LINEAR DECO FINISH: MATTE GROUT COLOR: MAPEI 77 FROST	3" W X 10" L	https://www.creativematerialscorp.com/product/tune/	COMPANY: CREATIVE MATERIALS CORPORATION NAME: DOUG SALATINO P: 518-713-5371 C: 518-261-8264 E: DSALATINO@CREATIVEMATERIALSCORP.COM WWW.CREATIVEMATERIALSCORP.COM
T-4 ALT1	TILE	ALTERNATE TO T-4 PREP AND PRIME SURFACES PER MANUFACTURER'S RECOMMENDATIONS INSTALLED IN VERTICAL STACK BOND, FINISH FLOOR TO 4'-0"	RESTROOMS (WAINSCOT)	AUTOSTONE	WALL TILE	COLLECTION: STATION AMERICA-B COLOR: WHITE FINISH: MATTE GROUT COLOR: MAPEI 77 FROST	4" W X 16" L	https://autostoneusa.com/ku/	COMPANY: AUTOSTONE USA NAME: BARRY WELLS P: 214-850-1206 E: KBAB@AUTOSTONEUSA.COM WWW.AUTOSTONEUSA.COM
T-4 ALT2	TILE	PREP AND PRIME SURFACES PER MANUFACTURER'S RECOMMENDATIONS INSTALLED IN VERTICAL STACK BOND, FINISH FLOOR TO 4'-0"	RESTROOMS (WAINSCOT)	DALTILE	WALL TILE	COLLECTION: STENCIL LINEAR WALL TILE COLOR: WHITE SC23 FINISH: MATTE GROUT COLOR: MAPEI 77 FROST	4" W X 12" L	https://www.daltile.com/products/Monochromatic-Look/Stencil/White	COMPANY: DALTILE NAME: DAVID SANTIBANEZ M: 562-644-4360 E: DAVID.SANTIBANEZ@DALTILE.COM WWW.DALTILE.COM
T-5	TILE	PREP AND PRIME SURFACES PER MANUFACTURER'S RECOMMENDATIONS INSTALLED IN HORIZONTAL STACK BOND	TECH RESTROOMS	ROYAL MOSA	WALL TILE	COLOR: GLOBAL FINISH: MOUSE GRAY 16880 GROUT COLOR: MAPEI 27 SILVER	4" W X 12" L	https://www.mosa.com/en-us/products/collection/4x12	COMPANY: ROYAL MOSA NAME: NAN MCGRINIS P: 513-703-5800 WWW.MOSA.COM
T-5 ALT1	TILE	ALTERNATE TO T-5 PREP AND PRIME SURFACES PER MANUFACTURER'S RECOMMENDATIONS INSTALLED IN HORIZONTAL STACK BOND	TECH RESTROOMS	AUTOSTONE	CERAMIC TILE	COLLECTION: SHOP WALLI COLOR: STORMY GREY FINISH: GLOSSY GROUT COLOR: MAPEI 27 SILVER	12" W X 24" L	https://autostoneusa.com/ku/	COMPANY: AUTOSTONE USA NAME: BARRY WELLS P: 214-850-1206 E: KBAB@AUTOSTONEUSA.COM WWW.AUTOSTONEUSA.COM
T-6	TILE	PREP AND PRIME SURFACES PER MANUFACTURER'S RECOMMENDATIONS INSTALLED IN HORIZONTAL STACK BOND	OPTIONAL NEW VEHICLE DELIVERY, SERVICE RECEPTION DRIVE LANES	AUTOSTONE	TILE	COLLECTION: DRIVE SERIES COLOR: ALLOY GREY SURFACE: R-12 TEXTURED GROUT COLOR: MAPEI 27 SILVER	8" W X 8" L	https://autostoneusa.com/ku/	COMPANY: AUTOSTONE USA NAME: BARRY WELLS P: 214-850-1206 E: KBAB@AUTOSTONEUSA.COM WWW.AUTOSTONEUSA.COM
T-7	TILE	PREP AND PRIME SURFACES PER MANUFACTURER'S RECOMMENDATIONS INSTALLED IN HORIZONTAL STACK BOND	OPTIONAL SERVICE RECEPTION DRIVE LANES	AUTOSTONE	TILE	COLLECTION: DRIVE SERIES COLOR: CARBON BLACK SURFACE: R-12 TEXTURED GROUT COLOR: MAPEI 27 SILVER	8" W X 8" L	https://autostoneusa.com/ku/	COMPANY: AUTOSTONE USA NAME: BARRY WELLS P: 214-850-1206 E: KBAB@AUTOSTONEUSA.COM WWW.AUTOSTONEUSA.COM
TS-1	TRANSITION STRIP	CONTRACTOR TO COORDINATE ALL ADDITIONAL PARTS AND SYSTEMS THAT ARE RECOMMENDED BY THE MANUFACTURER TO COMPLETE INSTALL	WALL BASE RESTROOMS	SCHLUTER	DILEX-AHK	FINISH: SATIN ANODIZED	REFERENCE CONSTRUCTION DOCUMENTS	https://www.schluter.com/schluter-us/en_US/Profiles/For-Floors-/Profiles/Schluter%20Dilex-AHK%20Dilex-AHK/Profiles-Floors	COMPANY: SCHLUTER SYSTEM NAME: LANCE BEARMAN P: 888-472-4588 M: 502-264-1199 E: LB@ARMAN@SCHLUTER.COM WWW.SCHLUTER.COM
TS-2	TRANSITION STRIP	CONTRACTOR TO COORDINATE ALL ADDITIONAL PARTS AND SYSTEMS THAT ARE RECOMMENDED BY THE MANUFACTURER TO COMPLETE INSTALL	BETWEEN T-3 AND T-4 IN RESTROOMS	SCHLUTER	SCHIENE	FINISH: SATIN ANODIZED	REFERENCE CONSTRUCTION DOCUMENTS	https://www.schluter.com/schluter-us/en_US/Profiles/For-Floors-/Same-height-Transitions/Schluter%20NAE-SCHIENE/2p/SCHIENE	COMPANY: SCHLUTER SYSTEM NAME: LANCE BEARMAN P: 888-472-4588 M: 502-264-1199 E: LB@ARMAN@SCHLUTER.COM WWW.SCHLUTER.COM
TS-3	TRANSITION STRIP	CONTRACTOR TO COORDINATE ALL ADDITIONAL PARTS AND SYSTEMS THAT ARE RECOMMENDED BY THE MANUFACTURER TO COMPLETE INSTALL	NVD	SCHLUTER	RENO-T	FINISH: SATIN ANODIZED	1"	https://www.schluter.com/schluter-us/en_US/Profiles/For-Floors-/Same-height-Transitions/Schluter%20NAE-RENO-T/2p/RENO-T	COMPANY: SCHLUTER SYSTEM NAME: LANCE BEARMAN P: 888-472-4588 M: 502-264-1199 E: LB@ARMAN@SCHLUTER.COM WWW.SCHLUTER.COM
WB-1	WALL BASE	PREP AND PRIME SURFACES PER MANUFACTURER'S RECOMMENDATIONS	ROOMS WITH T-2	CREATIVE MATERIALS CORP.	CERAMIC TILE - CUT TO 4" WITH SCHLUTER SCHIENE CAP (CLEAR ANODIZED)	COLLECTION: INVO COLOR: GOLD FINISH: MATTE GROUT COLOR: MAPEI 108 BAMBOO	4" H X 48" L	https://www.creativematerialscorp.com/product/invo/	COMPANY: CREATIVE MATERIALS CORPORATION NAME: DOUG SALATINO P: 518-713-5371 C: 518-261-8264 E: DSALATINO@CREATIVEMATERIALSCORP.COM WWW.CREATIVEMATERIALSCORP.COM
WB-2	WALL BASE	N/A	ROOMS WITH CO-1	TARKETT	TRADITIONAL VINYL 4'-1/8" TOELESS (TYPE TV)	COLOR: TAS COLONIAL GRAY	0.125" D X 4" H X 48" L	https://commercial.tarkett.com/en_US/collection/C000494-traditional-vinyl-1-8-type-tv	COMPANY: TARKETT NAME: ERIN RINK P: 513-504-5734 E: ERIN.RINK@TARKETT.COM WWW.TARKETT.COM
WB-3	WALL BASE	N/A	ROOMS WITH OPT-1	TARKETT	TRADITIONAL VINYL 4'-1/8" TOELESS (TYPE TV)	COLOR: 40 BLACK	0.125" D X 4" H X 48" L	https://commercial.tarkett.com/en_US/collection/C000494-traditional-vinyl-1-8-type-tv	COMPANY: TARKETT NAME: ERIN RINK P: 513-504-5734 E: ERIN.RINK@TARKETT.COM WWW.TARKETT.COM
WB-4	WALL BASE	SPECIFICATION INTENDED FOR DESIGN INTENT ONLY	ROOMS WITH LVT-1	HOME DEPOT	FINISHED ELEGANCE MDF MOULDING BOARD	P-6 U.N.O. SEE INTERIOR ELEVATIONS	1" D X 3" H X 96" L	N/A	COMPANY: THE HOME DEPOT NAME: CUSTOMER SERVICE P: 800-466-3337 WWW.HOMEDEPOT.COM
WC-1	WALLCOVERING	PREP AND PRIME SURFACES PER MANUFACTURER'S RECOMMENDATIONS DRYWALL SUBSTRATE TO BE FINISHED IN A LEVEL 5 FINISH STRAIGHT HANG, RANDOM MATCH, VERTICAL GRAIN	SHOWROOM, VEHICLE DELIVERY (VDC) / PHOTO BOOTH	MOMENTUM	WOODS WALLCOVERING	COLOR: SWS-54 RED OAK	36" W	https://www.momentumtextilesandwalls.com/0930525/p	COMPANY: MOMENTUM TEXTILES & WALLCOVERING NAME: AMBER GARNES P: 800-366-6839 x819 E: AGARNES@MOMTEX.COM WWW.MOMENTUMSAMPLES.COM
WC-1 ALT1	WALLCOVERING	PREP AND PRIME SURFACES PER MANUFACTURER'S RECOMMENDATIONS DRYWALL SUBSTRATE TO BE FINISHED IN A LEVEL 5 FINISH STRAIGHT HANG, RANDOM MATCH, VERTICAL GRAIN	SHOWROOM, VEHICLE DELIVERY (VDC) / PHOTO BOOTH	KOROSEAL	TIMBERLAND WALLCOVERING	COLOR: T122-16 WHITE OAK	36" W	https://koroseal.com/products/wallcoverings/timberland/white-oak	COMPANY: KOROSEAL COMMERCIAL WALLCOVERINGS NAME: CUSTOMER SERVICE P: 855-753-5474 WWW.KOROSEAL.COM

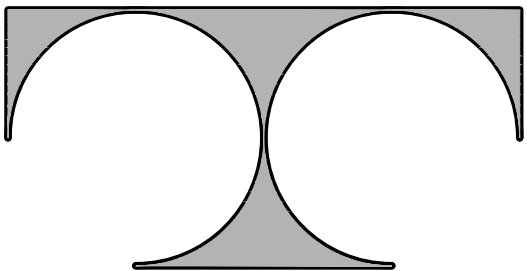

TDI ASSOCIATES, INC.
ARCHITECTURE & PLANNING

25217 SOUTH WIND LAKE ROAD
WIND LAKE, WISCONSIN 53185
PHONE 262-409-2530

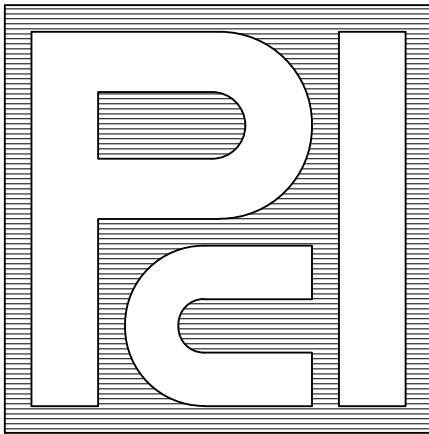

PROFESSIONAL
CONSULTANTS, INC.
300 COTTONWOOD AVE # 7
HARTLAND, WISCONSIN 53029
(262) 367-6080

RUSS DARROW
KIA OF WAUKESHA
2141 EAST MORELAND BLVD
WAUKESHA, WISCONSIN

TDI ASSOCIATES, INC
All Rights Reserved

OWNERSHIP OF DOCUMENTS

This document, and the ideas and design incorporated herein, as an instrument of professional service, is the sole property of TDI Associates, Inc., and is not to be used in whole or in part for any other project or purpose without the expressed written authorization of TDI Associates, Inc.

Sheet Title
INTERIOR
FINISH SCHEDULE

Issued For: Date:
- -

Date: 07-25-2024

Job NO.: 24103.000

Drawn By: LCC

Sheet No.


A4.3

FURNITURE SCHEDULE				
CODE	MATERIAL	NOTES	MANUFACTURER	PRODUCT
FN-1	FURNITURE	CONTRACTOR TO WORK WITH DEALER TO PROVIDE ALL NECESSARY PIECES AND PARTS REQUIRED FOR ASSEMBLY	HAWORTH	POPPY LOUNGE CHAIR BASE:FOUR LEG ARRAY
FN-2	FURNITURE	CONTRACTOR TO WORK WITH DEALER TO PROVIDE ALL NECESSARY PIECES AND PARTS REQUIRED FOR ASSEMBLY	HAWORTH	OPENEST CHICK POUF, WITH UPHOLSTERED BACK
FN-3	FURNITURE	CONTRACTOR TO WORK WITH DEALER TO PROVIDE ALL NECESSARY PIECES AND PARTS REQUIRED FOR ASSEMBLY	HAWORTH	OPENEST CHICK POUF, BACKLESS
FN-4	FURNITURE	CONTRACTOR TO WORK WITH DEALER TO PROVIDE ALL NECESSARY PIECES AND PARTS REQUIRED FOR ASSEMBLY	HAWORTH	OPENEST CHICK POUF, BACKLESS
FN-5	FURNITURE	CONTRACTOR TO WORK WITH DEALER TO PROVIDE ALL NECESSARY PIECES AND PARTS REQUIRED FOR ASSEMBLY	HAWORTH	OPENEST CHICK POUF, ROUND
FN-7	FURNITURE	CONTRACTOR TO WORK WITH DEALER TO PROVIDE ALL NECESSARY PIECES AND PARTS REQUIRED FOR ASSEMBLY	HAWORTH	HOB0 SOFA 2-SEAT, RIGHT ARM CONFIGURATION
FN-8	FURNITURE	CONTRACTOR TO WORK WITH DEALER TO PROVIDE ALL NECESSARY PIECES AND PARTS REQUIRED FOR ASSEMBLY	HAWORTH	HOB0 SOFA BENCH 2-SEAT CONFIGURATION LEFT ARM ORIENTATION
FN-9	FURNITURE	CONTRACTOR TO WORK WITH DEALER TO PROVIDE ALL NECESSARY PIECES AND PARTS REQUIRED FOR ASSEMBLY	HAWORTH	CABANA LOUNGE ISLAND MID FULL BACK POWERED: FOUR OUTLETS(OPTIONAL), TWO USB SINGLE SURFACE
FN-10	FURNITURE	CONTRACTOR TO WORK WITH DEALER TO PROVIDE ALL NECESSARY PIECES AND PARTS REQUIRED FOR ASSEMBLY	HAWORTH	MAARI SIDE CHAIR
FN-11	FURNITURE	CONTRACTOR TO WORK WITH DEALER TO PROVIDE ALL NECESSARY PIECES AND PARTS REQUIRED FOR ASSEMBLY	HAWORTH	MAARI SIDE CHAIR
FN-12	FURNITURE	CONTRACTOR TO WORK WITH DEALER TO PROVIDE ALL NECESSARY PIECES AND PARTS REQUIRED FOR ASSEMBLY	HAWORTH	MAARI LOW BACK BAR HEIGHT STOOL
FN-13	FURNITURE	CONTRACTOR TO WORK WITH DEALER TO PROVIDE ALL NECESSARY PIECES AND PARTS REQUIRED FOR ASSEMBLY	HAWORTH	MAARI LOW BACK BAR HEIGHT STOOL
FN-14	FURNITURE	CONTRACTOR TO WORK WITH DEALER TO PROVIDE ALL NECESSARY PIECES AND PARTS REQUIRED FOR ASSEMBLY	HAWORTH	POPPY GUEST CHAIR
FN-15	FURNITURE	CONTRACTOR TO WORK WITH DEALER TO PROVIDE ALL NECESSARY PIECES AND PARTS REQUIRED FOR ASSEMBLY	HAWORTH	LOTUS CHAIR LOW BACK, FIXED ARMS
FN-16	FURNITURE	CONTRACTOR TO WORK WITH DEALER TO PROVIDE ALL NECESSARY PIECES AND PARTS REQUIRED FOR ASSEMBLY	HAWORTH	LOTUS CHAIR HIGH FULL BACK, FIXED ARMS
FN-17	FURNITURE	CONTRACTOR TO WORK WITH DEALER TO PROVIDE ALL NECESSARY PIECES AND PARTS REQUIRED FOR ASSEMBLY	HAWORTH	PIP PERSONAL LAPTOP TABLE
FN-18	FURNITURE	CONTRACTOR TO WORK WITH DEALER TO PROVIDE ALL NECESSARY PIECES AND PARTS REQUIRED FOR ASSEMBLY	HAWORTH	GONG SIDE TABLE
FN-19	FURNITURE	CONTRACTOR TO WORK WITH DEALER TO PROVIDE ALL NECESSARY PIECES AND PARTS REQUIRED FOR ASSEMBLY	HAWORTH	PLANES SIDE TABLE KNIFE EDGE DISC BASE
FN-20	FURNITURE	CONTRACTOR TO WORK WITH DEALER TO PROVIDE ALL NECESSARY PIECES AND PARTS REQUIRED FOR ASSEMBLY	HAWORTH	IMMERSE SINGLE TABLE FOUR LEG BASE,NO POWER

CODE	MATERIAL	NOTES	MANUFACTURER	PRODUCT
FN-21	FURNITURE	CONTRACTOR TO WORK WITH DEALER TO PROVIDE ALL NECESSARY PIECES AND PARTS REQUIRED FOR ASSEMBLY	HAWORTH	PLANES TABLE, DINE HEIGHT KNIFE EDGE DISC BASE
FN-24	FURNITURE	CONTRACTOR TO WORK WITH DEALER TO PROVIDE ALL NECESSARY PIECES AND PARTS REQUIRED FOR ASSEMBLY	HAWORTH	HAWORTH VERY TASK CHAIR
FN-25	FURNITURE	DEALER TO COORDINATE DESKING REQUIREMENTS WITH FURNITURE MANUFACTURER FOR EXACT SPECIFICATIONS	HAWORTH	TRAINING TABLE
FN-27	FURNITURE	CONTRACTOR TO WORK WITH DEALER TO PROVIDE ALL NECESSARY PIECES AND PARTS REQUIRED FOR ASSEMBLY	FROVI	RELIC CREDENZA HIGH
FN-28	FURNITURE	DEALER TO COORDINATE DESKING REQUIREMENTS WITH FURNITURE MANUFACTURER FOR EXACT SPECIFICATIONS	HAWORTH	X SERIES SINGLE PEDESTAL DESK PRODUCT #: JD5L-2460-JFALBN RIGHT HAND ORIENTATION 1/3 HEIGHT MODESTY PANEL HEIGHT CABLE MANAGEMENT: NO SCALLOP
FN-28A	FURNITURE	DEALER TO COORDINATE DESKING REQUIREMENTS WITH FURNITURE MANUFACTURER FOR EXACT SPECIFICATIONS	HAWORTH	X SERIES PEDESTAL PRODUCT #: JPAH-24-L3 LAMINATE FRONT/PAINTED STEEL LOCKBAR PULL STYLE: TAPER
FN-29	FURNITURE	DEALER TO COORDINATE DESKING REQUIREMENTS WITH FURNITURE MANUFACTURER FOR EXACT SPECIFICATIONS	HAWORTH	X SERIES DESK SHELLS STANDARD RECTANGULAR DESK SHELL - LAMINATE TOP WITH LAMINATE END PANELS PRODUCT #: JD5L-3072-JFELBN 1/3 MODESTY PANEL HEIGHT CABLE MANAGEMENT: NO SCALLOP
FN-29A	FURNITURE	DEALER TO COORDINATE DESKING REQUIREMENTS WITH FURNITURE MANUFACTURER FOR EXACT SPECIFICATIONS	HAWORTH	X SERIES MOBILE PEDESTAL PRODUCT #: JPMF-2453 PAINTED STEEL FRONTS AND LOCKBAR PULL STYLE: TAPER
FN-30	FURNITURE	DEALER TO COORDINATE DESKING REQUIREMENTS WITH FURNITURE MANUFACTURER FOR EXACT SPECIFICATIONS	HAWORTH	X SERIES CONVERGENTS - CURVED WRAP AROUND D-TOP LAMINATE TOP WITH COLUMN AND LAMINATE END PANELS PRODUCT #: JDVL-3660-JDL-LBN4 LEFT-HAND ORIENTATION 1/3 MODESTY PANEL HEIGHT CABLE MANAGEMENT: NO SCALLOP ADJOINING SURFACE DEPTH: 24"
FN-30A	FURNITURE	DEALER TO COORDINATE DESKING REQUIREMENTS WITH FURNITURE MANUFACTURER FOR EXACT SPECIFICATIONS NOTE: TO BE USED WITH FN-30	HAWORTH	X SERIES RETURN - LAMINATE TOP WITH LAMINATE END PANEL PRODUCT #: JDRL-2466-JNFLBNS RIGHT-HAND ORIENTATION 1/3 MODESTY PANEL HEIGHT CABLE MANAGEMENT: NO SCALLOP
FN-30B	FURNITURE	DEALER TO COORDINATE DESKING REQUIREMENTS WITH FURNITURE MANUFACTURER FOR EXACT SPECIFICATIONS NOTE: TO BE USED WITH FN-30A	HAWORTH	X SERIES VERTICAL STORAGE UNITS PRODUCT #: JDFL-3366-LI FLIPPER DOOR VERTICAL STORAGE UNIT LAMINATE FRONT WITH LAMINATE END PANELS
FN-31	FURNITURE	DEALER TO COORDINATE DESKING REQUIREMENTS WITH FURNITURE MANUFACTURER FOR EXACT SPECIFICATIONS NOTE: PIECE IS CREATED USING 2 QUANTITY	HAWORTH	X SERIES FREESTANDING 2H LATERAL FILE PROUD STYLES PRODUCT #: JLPD-0236-LJ LAMINATE FRONTS/PAINTED STEEL LOCKBAR
FN-31A	FURNITURE	DEALER TO COORDINATE DESKING REQUIREMENTS WITH FURNITURE MANUFACTURER FOR EXACT SPECIFICATIONS MUST USED WITH FN-31	HAWORTH	X SERIES LATERAL FILE LAMINATE TOPS FOR USE WITH PROUD STYLE FRONTS PRODUCT #: JTPL-1872-JYJYS
FN-32	FURNITURE	DEALER TO COORDINATE DESKING REQUIREMENTS WITH FURNITURE MANUFACTURER FOR EXACT SPECIFICATIONS MUST USED WITH FN-31	HAWORTH	X SERIES LATERAL FILE LAMINATE TOPS FOR USE WITH PROUD STYLE FRONTS PRODUCT #: JTPL-1872-JYJYS
PART-1	PARTITION	CONTRACTOR TO COORDINATE ALL ADDITIONAL PARTS AND SYSTEMS THAT ARE RECOMMENDED BY THE MANUFACTURER TO COMPLETE INSTALL.	HAWORTH	ENCLOSE OFFICE SYSTEMS
PART-2	PARTITION	CONTRACTOR TO COORDINATE ALL ADDITIONAL PARTS AND SYSTEMS THAT ARE RECOMMENDED BY THE MANUFACTURER TO COMPLETE INSTALL.	HAWORTH	ENCLOSE OFFICE SYSTEMS


MANUFACTURER CONTACT

COMPANY: HAWORTH
NAME: LESLIE LEVINSKI
PHONE: N/A
MOBILE: 949-424-9340
EMAIL: LESLIE.LEVINSKI@HAWORTH.COM
WEBSITE: WWW.HAWORTH.COM

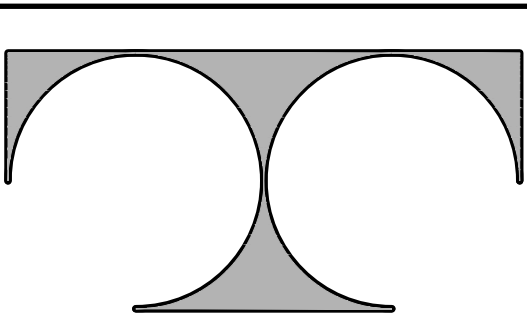

TDI ASSOCIATES, INC.
ARCHITECTURE & PLANNING

25217 SOUTH WIND LAKE ROAD
WIND LAKE, WISCONSIN 53185
PHONE 262-409-2530

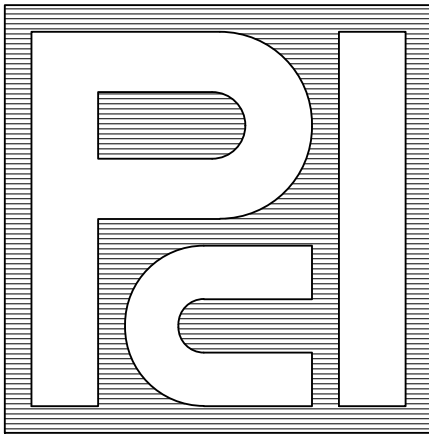

PROFESSIONAL
CONSULTANTS, INC.

300 COTTONWOOD AVE # 7
HARTLAND, WISCONSIN 53029
(262) 367-6080

RUSS DARROW
KIA OF WAUKESHA

2141 EAST MORELAND BLVD
WAUKESHA, WISCONSIN

TDI ASSOCIATES, INC
All Rights Reserved

OWNERSHIP OF DOCUMENTS

This document, and the ideas and design incorporated herein, as an instrument of professional service, is the sole property of TDI Associates, Inc., and is not to be used in whole or in part for any other project or purpose without the expressed written authorization of TDI Associates, Inc.

Sheet Title

FURNITURE
SCHEDULE

Issued For: Date:

- -

Date: 07-25-2024


Job NO.: 24103.000

Drawn By: LCC

Sheet No.


A4.5

FIXTURE SCHEDULE									
CODE	ITEM	NOTES	LOCATION	MANUFACTURER	PRODUCT	FINISH/COLOR	DIMENSION	WEBSITE	MANUFACTURER REPRESENTATIVE CONTACT INFORMATION
EQUIP-1	FAUCET	CONTRACTOR RESPONSIBLE FOR SPECIFYING AND ORDERING ALL PARTS TO COMPLETE INSTALL. CONTRACTOR RESPONSIBLE FOR SELECTING AC OR DC POWER OPTION ADA COMPLIANT	RESTROOMS	SLOAN	OPTIMA HARDWIRED-POWERED DECK-MOUNTED LOW BODY FAUCET MODEL: ETF-410-PLG-TEE-GR-0.5GPM-HLM-38-FCT CODE: 3360B03DT COMMERCIAL GRADE FAUCET, ADA COMPLIANT, INTEGRATED WATER SHUT-OFF, WIRELESS SETTINGS ADJUSTMENT, SELF-ADAPTING SENSOR	FINISH: GRAPHITE	N/A	https://www.sloan.com/commercial-bathroom-products/faucets/optima/etf-410?variation_finish=Graphite	COMPANY: SLOAN NAME: CUSTOMER SERVICE P: 847-871-4300 E: CUSTOMER.SERVICE@SLOAN.COM WWW.SLOAN.COM
EQUIP-2	SOAP DISPENSER	TO BE MOUNTED AT REQUIRED ADA HEIGHT ADA COMPLIANT	RESTROOMS	SLOAN	DECK-MOUNTED FOAM SOAP DISPENSER MODEL: ESD-410-GR CODE: 3340161	FINISH:GRAPHITE	N/A	https://www.sloan.com/commercial-bathroom-products/soap-dispensers/sloan/esd-410?variation_finish=Graphite	COMPANY: SLOAN NAME: CUSTOMER SERVICE P: 847-871-4300 E: CUSTOMER.SERVICE@SLOAN.COM WWW.SLOAN.COM
EQUIP-3	HAND DRYER	TO BE MOUNTED AT REQUIRED ADA HEIGHT ADA COMPLIANT	RESTROOMS	EXCEL DRYER	XLEBATOR HAND DRYER	FINISH:XL-GR GRAPHITE TEXTURED PAINTED COVER	6-11/16"D X 11-3/4"W X 12-11/16"H	https://www.exceldryer.com/product/xlelator-hand-dryer/	COMPANY: EXCEL DRYER NAME: CUSTOMER SERVICE P: 888-998-7704 E: SALES@EXCELDRYER.COM WWW.EXCELDRIYER.COM
EQUIP-4	TOWEL DISPENSER	CONTRACTOR RESPONSIBLE FOR COORDINATING WITH MANUFACTURER ALL PARTS AND PIECES THAT ARE NEEDED FOR PROPER INSTALLATION	RESTROOMS	AMERICAN SPECIALTIES, INC	PIATTO COMPLETELY RECESSED PAPER TOWEL DISPENSER AND WASTE RECEPTACLE MODEL: 64623-41	COLOR: MATTE BLACK PHENOLIC DOOR	FINISHED WALL OPENING (FWO): 4-11/16"D X 28-1/2"H X 14-5/16"W UNIT SIZE: 4-9/16"D X 28"H X 14-1/4"W	https://americaspecialties.com/product/piatto-completely-recessed-paper-towel-dispenser-and-waste-receptacle-matte-black-phenolic-door-64623-41/	COMPANY: AMERICAN SPECIALTIES, INC. NAME: CUSTOMER SERVICE P:914-476-0688 WWW.AMERICANSPECIALTIES.COM
EQUIP-5	GRAB BAR	TO BE MOUNTED AT REQUIRED ADA HEIGHT ADA COMPLIANT	RESTROOMS	KOHLER	KUMIN GRAB BAR	COLOR: MATTE BLACK	ADR TO CONFIRM REQUIRED DIMENSION(S) REQUIRED.	https://www.us.kohler.com/us/kumin-42-grab-bar/productDetail/accessories-grab-bars/1649312.htm?skuId=1649313&wcdId=1787392	COMPANY: KOHLER NAME: CUSTOMER SERVICE P:800-456-4537 WWW.US.KOHLER.COM
EQUIP-6	TOILET TISSUE DISPENSER	TO BE MOUNTED AT REQUIRED ADA HEIGHT ADA COMPLIANT	RESTROOMS	KOHLER	WALL MOUNTED TOILET TISSUE DISPENSER MODEL: K-78384-BL	COLOR: MATTE BLACK	6-1/4"D X 4-1/4"H X 12"W	https://www.kohler.com/en/products/bathroom-accessories/shop-bathroom-accessories/components-covered-double-toilet-tissue-holder-78384?skuId=78384-BL	COMPANY: KOHLER NAME: CUSTOMER SERVICE P:800-456-4537 WWW.US.KOHLER.COM
EQUIP-7	SANITARY NAPKIN RECEPTACLE	TO BE MOUNTED AT REQUIRED ADA HEIGHT ADA COMPLIANT	RESTROOMS	BOBRICK	WALL MOUNTED TOILET TISSUE DISPENSER MODEL: K-78384-BL	COLOR: MATTE BLACK	4-1/2"D X 14-1/8"H X 8-1/16"W	https://www.bobrick.com/products/washroom-accessories/toilet-compartment-accessories/toilet-compartment-catalog/sanitary-napkin-dispensers/product/9-35139-mbkl	COMPANY: BOBRICK NAME: CUSTOMER SERVICE P: 818-982-9600 E: SALES@SEVERUE.COM WWW.BOBRICK.COM
EQUIP-8	LIGHTED MIRROR	TO BE MOUNTED AT REQUIRED ADA HEIGHT THIS ITEM REQUIRES ELECTRIC - ARCHITECT OF RECORD TO COORDINATE APPROPRIATE ELECTRICAL NEEDS	RESTROOMS	GRAND MIRRORS	GRAND MIRRORS ECLIPSE BACK LIGHTED / ROUNDED CORNERS LED LIGHT: PHILLIPS LED LIGHT LED LIGHT TEMPERATURE: PHILLIPS MID-WARM LIGHT (4000K)	FINISH: BRUSHED STAINLESS	60"H X 36"W	https://grandmirrors.com/ecclipse/	COMPANY: GRAND MIRRORS NAME: CUSTOMER SERVICE P:949-441-4262 M:SALES@SEVERUE.COM WWW.GRANDMIRRORS.COM
EQUIP-9	BABY CHANGING STATION	TO BE MOUNTED AT REQUIRED ADA HEIGHT	RESTROOMS	KOALA	HORIZONTAL STAINLESS STEEL SURFACE-MOUNTED KB310-SSWH	FINISH: MATTE BLACK	6-25/32"D X 26-11/32"H X 41-15/32"W EXTENSION: 21-1/4"D	https://www.koalabear.com/product-catalog/kb310-sswh/	COMPANY: GRAND MIRRORS NAME: CUSTOMER SERVICE P:949-441-4262 M:SALES@SEVERUE.COM WWW.GRANDMIRRORS.COM
EQUIP-10	UNDERMOUNT SINK	TO BE MOUNTED AT REQUIRED ADA HEIGHT	RESTROOMS	TOTO	UNDERCOUNTER LAVATORY LT191(G)	FINISH: STANDARD WHITE	23-3/4"W X 14-3/8"D	https://www.totousa.com/undercounter-lavatory-ft191g	COMPANY: TOTO NAME: CUSTOMER SERVICE P:1-888-295-8134 E: CUSTOMER@TOTO.COM WWW.TOTOUSA.COM/

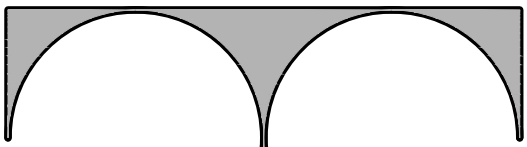

TDI ASSOCIATES, INC.
ARCHITECTURE & PLANNING

25217 SOUTH WIND LAKE ROAD
WIND LAKE, WISCONSIN 53185
PHONE 262-409-2530

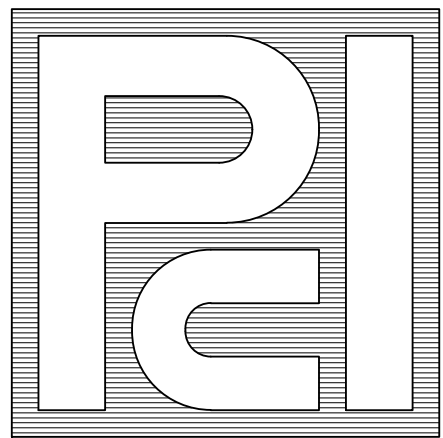

PROFESSIONAL
CONSULTANTS, INC.

300 COTTONWOOD AVE # 7
HARTLAND, WISCONSIN 53029
(262) 367-6080

RUSS DARROW
KIA OF WAUKESHA

2141 EAST MORELAND BLVD
WAUKESHA, WISCONSIN

TDI ASSOCIATES, INC
All Rights Reserved

OWNERSHIP OF DOCUMENTS

This document, and the ideas and design incorporated herein, as an instrument of professional service, is the sole property of TDI Associates, Inc., and is not to be used in whole or in part for any other project or purpose without the expressed written authorization of TDI Associates, Inc.

Sheet Title
FIXTURE
SCHEDULE

Issued For: Date:
- -

Date: 07-25-2024

Job NO.: 24103.000

Drawn By: LCC

Sheet No.

A4.6



300 COTTONWOOD AVE # 7
HARTLAND, WISCONSIN 53029
(262) 367-6080

TDI ASSOCIATES, INC
All Rights Reserved

OWNERSHIP OF DOCUMENTS

Sheet Title
LIGHT FIXTURE
SCHEDULE









Date: 07-25-2024

Job NO.: 24103.000

Drawn By: LCC

Sheet No. _____

A6.2 

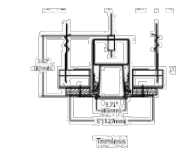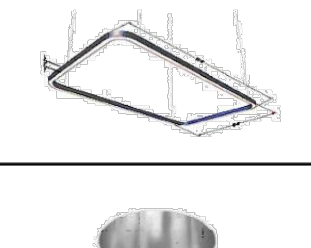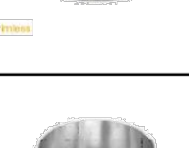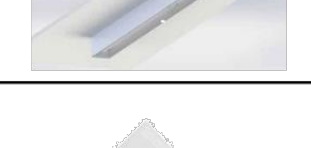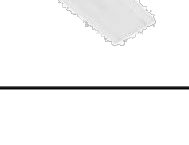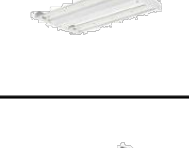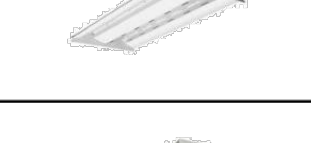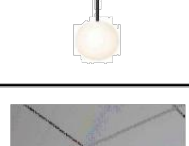
KIA 2023 CBS LIGHTING SCHEDULE													
TYPE	IMAGE	DESCRIPTION	MOUNTING	MANUFACTURER	SERIES	LOCATION	COLOR	FINISH	APPROX. SIZE	CAT. NO.	LED	SUSPENDED HEIGHT	NOTES
A		SPOTLIGHT IN CHANNEL	RECESS	ALW	LP5R	SHOWROOM	BLACK	TB - TEXTURED MATTE BLACK POWDERCOAT	5" DIA.	LP5RMD-DRY-S-NONE-DL2500/90/4000/40-N-*-TB	2500 LUMENS W/ 4000K 92 CRI	N/A	COORDINATE CEILING CONDITIONS WITH MANUFACTURER PRIOR TO ORDER
B		LINEAR	RECESS	LEDALITE	TRUGROOVE RECESSED MICRO	VARIOUS GYP CEILINGS	WHITE	N/A	1.75" x LENGTH PER PLANS	230 1 L 940 30 Q 3 S XX	750 LUMENS/FT 10 W/FT 4000K 90 CRI	N/A	N/A
C1		RECTANGLE	CABLE	FORUM	ARC 3	SHOWROOM LOUNGE	SATIN ANODIZED / SILVER	N/A	12" RADIUS @ CORNERS	ARCD 33 95 40 WOL H REC V CC W/ ROUND CORNERS	950 LUMENS/FT 9 W/FT 4000K 90+ CRI	9'-0"	SILVER MOUNTING CANOPY FINISH
C2		RECTANGLE	CABLE	FORUM	ARC 3	FOCAL VEHICLE	SATIN ANODIZED / SILVER	N/A	12" RADIUS @ CORNERS	ARCD 33 95 40 WOL H REC V CC W/ ROUND CORNERS	950 LUMENS/FT 9 W/FT 4000K 90+ CRI	10'-0"	WHITE MOUNTING CANOPY FINISH
D2		TRIMLESS DOWNLIGHT	RECESS	AMERLUX	EVOKE 4.75"	VARIOUS GYP CEILINGS	CLEAR	TRIMLESS	5" DIA.	E4.75R NC A17 T 16 VOLTS 0-10V SD FL 409	1200 LUMENS 16 W 4000K 90+ CRI	N/A	25°
D3		TRIMLESS DOWNLIGHT	RECESS	AMERLUX	EVOKE 4.75"	VARIOUS GYP CEILINGS	CLEAR	TRIMLESS	5" DIA.	E4.75R NC A17 T 16 VOLTS 0-10V SD WF 409	2100 LUMENS 29 W 4000K 90+ CRI	N/A	40°
D4		DOWNLIGHT	RECESS	AMERLUX	EVOKE 2.9"	MERCHANDISING AREA	CLEAR	TRIMLESS	3" DIA.	E2.9RD HP T 11 120 X 1-10V T CLC NF 40	700 LUMENS 11 W 4000K 80+ CRI	N/A	20°
E		STRIP LIGHT	RECESS	TBD	TBD	LIGHT COVES THROUGHOUT	CLEAR	N/A	1.2" x 1.4" x LENGTH PER PLAN	TBD	TBD	N/A	3
F		LINEAR	CABLE	FORUM	ALUMINA	SERVICE RECEPTION	WHITE	N/A	4" x 4" x LENGTH PER PLAN	SAD 44 95 40 WOL H 20' UNV WH	950 LUMENS/FT 8.9W/FT 4000K 80+ CRI	N/A	N/A
F1		HIGH BAY	SUSPENDED	LSI	ALLIANCE	SERVICE BAYS	WHITE	N/A	2' x 1'	LSI ALI2 2LEDSE 18L LL W UNV 40 HCH10	18,060 LUMENS 118 W 4000K 80+ CRI	N/A	N/A
F1-ALT1		HIGH BAY	SUSPENDED	SIGNIFY	DAY-BRITE	SERVICE BAYS	WHITE	CLEAR	2' x 1'-2"	PHILIPS DAYBRITE FBX 16L L 40 UNV	16,000 LUMENS 124 W 4000K 80+ CRI	N/A	N/A
F1-ALT2		HIGH BAY	SUSPENDED	MERCURY ARCHITECTURAL LIGHTING	LHBT SERIES	SERVICE BAYS	WHITE	N/A	2' x 1'-8"	MERCURY LHBT 4 20000 40K R UNI	18,000 LUMENS 142 W 4000K 80+ CRI	N/A	N/A
F2		HIGH BAY	SUSPENDED	LSI	EG3	SERVICE BAYS	WHITE	N/A	4'	LSI EG3 4 LED 6L DA S UNV DIM 40 80 HCH10	4,400 LUMENS 32 W 4000K 80 CRI	N/A	N/A
F2-ALT1		HIGH BAY	SUSPENDED	SIGNIFY	DAYBRITE	SERVICE BAYS	WHITE	CLEAR	4'	PHILIPS DAYBRITE DWA E 65L 840 4 UNV	7,000 LUMENS 65 W 4000K 80 CRI	N/A	N/A
F3		HIGH BAY	SUSPENDED	LSI	EG3	SERVICE BAYS	WHITE	N/A	4'	LSI EG3 4 LED 6L DA S UNV DIM 40 80 HCH10	6,695 LUMENS 32 W 4000K 80 CRI	N/A	N/A
LT-2		HANGING PENDANT	SUSPENDED	A+R	BOLA SPHERE	OFFICES	MATTE BLACK	N/A	12"	BOLA SPHERE PENDANT	1,500 LUMENS 20 W 2700K 95 CRI	7'-0" AFF	N/A
M24		2 x 4	RECESS	DAYBRITE	ARIOSO	VARIOUS	WHITE	N/A	24" x 48"	2 AVE G 43L 840 4 ACR UNV DIM	4,300 LUMENS 40 W 4000K 80+ CRI	N/A	N/A
M22		2 x 2	RECESS	DAYBRITE	ARIOSO	VARIOUS	WHITE	N/A	24" x 24"	2 AVE G 38L 840 2 ACR UNV DIM	3,800 LUMENS 31 W 4000K 80+ CRI	N/A	N/A
S		WRAPAROUND STRIP	SURFACE	DAYBRITE	ARIOSO	VARIOUS	WHITE	N/A	4" x 48"	FSWEZ 4 40L 840 UNV	4,000 LUMENS 32 W 4000K 80+ CRI	N/A	N/A
GENERAL NOTES: OPTIONAL LIGHTING CONSULTANTS: 1. PROVIDE 0-10V DIMMING CAPABILITY AND APPROPRIATE CONTROLS FOR ALL LUMINAIRES 2. PROVIDE HIGH CRI (80+) LEDS 3. INCLUDE ALL SYSTEM INTEGRATION ACCESSORIES (POWER SUPPLIES, FEED CABLES, MOUNTING HARDWARE, ETC) AS NEEDED. 4. PROVIDE EXIT AND EGRESS LIGHTING TO COMPLY WITH NATIONAL AND LOCAL CODES 5. VOLTAGES ARE TO BE DETERMINED BY ELECTRICAL ENGINEER 6. ALL LIGHTING SHALL BE AS SPECIFIED OR APPROVED EQUAL. ARCHITECT OF RECORD TO CONTACT CHANGE UP FOR LIGHT FIXTURE SUBSTITUTION APPROVAL AS REQUIRED. COMPANY: KING LIGHTING, INC NAME: MEGAN BLANEY P: 513-519-1986 E: MEGAN.BLANEY@KING-LIGHTING.COM COMPANY: BR LIGHTING & CONTROLS NAME: CLIFF BROOKS P: 937-672-2064 E: CLIFF@BRLTG.COM COMPANY: COMMERCIAL LIGHTING NAME: FARREN HALCOVICH P: 760-831-9815 E: FARREN@COMMERCIAL-LIGHTING.NET													

DOOR SCHEDULE												
MARK	ROOM	WIDTH	HEIGHT	MATERIAL	FINISH	TYPE	GLASS	LABEL	TYPE	MATERIAL	H.W.	REMARKS
101A	CASHIER	3'-0"	7'-0"	SOLID CORE WOOD	PAINT	B	NONE		F-2	HOLLOW METAL	6	
112	PARTS MANAGER	3'-0"	7'-0"	GLASS	CLEAR	A	VISION			ALUMINUM	2	
113A	SERVICE WRITE-UP	3'-0"	7'-0"	ALUM / GLASS	CLEAR	A	VISION		BL-1	ALUMINUM	4	
113B	SERVICE WRITE-UP	3'-0"	7'-0"	HOLLOW MTL	PAINT	B	NONE		F-1	HOLLOW METAL	1	FRAME & DOOR PAINTED TO MATCH ADJACENT WALL
114A	SERVICE RECEPTION	3'-0"	7'-0"	ALUM / GLASS	CLEAR	A	VISION		F-1	ALUMINUM	4	
114B	SERVICE RECEPTION	10'-0"	10'-0"	ALUM / GLASS	PRE. FIN.	C	VISION		-	-	3	
114C	SERVICE RECEPTION	10'-0"	10'-0"	ALUM / GLASS	PRE. FIN.	C	VISION		-	-	3	
120	F#1	3'-0"	7'-0"	GLASS	CLEAR	D	VISION		-	ALUMINUM	2	
121	F#1	3'-0"	7'-0"	GLASS	CLEAR	D	VISION		-	ALUMINUM	2	
121A	CAR WASH	10'-0"	10'-0"	STEEL INSULATED	PRE. FIN.	E	NONE		-	ALUMINUM	3	
121B	CAR WASH	3'-0"	7'-0"	HOLLOW MTL	PAINT	B	NONE		F-1	HOLLOW METAL	5	FRAME & DOOR PAINTED TO MATCH ADJACENT WALL
121C	CAR WASH	10'-0"	10'-0"	STEEL INSULATED	PRE. FIN.	E	NONE		-	ALUMINUM	3	
121D	CAR WASH	3'-0"	7'-0"	HOLLOW MTL	PAINT	B	NONE		F-1	HOLLOW METAL	5	FRAME & DOOR PAINTED TO MATCH ADJACENT WALL

DOOR NOTES


1. ALL DOOR HARDWARE SETS SHALL HAVE LEVER HANDLES UNLESS OTHERWISE NOTED.
2. ALL EXISTING AND NEW WOOD DOORS SHALL BE PL-1 W/ BLACK FRAMES & HARDWARE.

HARDWARE SET #1	HARDWARE SET #2	HARDWARE SET #3	HARDWARE SET #4	HARDWARE SET #5	HARDWARE SET #6
1-1/2 PR. HINGES	1 SET PIVOTS	HARDWARE BY DOOR MANUFACTURER	1 SETS PIVOTS	1-1/2 PR. HINGES	1-1/2 PR. HINGES
1 STOP CLOSURE	1 SET STOP		1 SETS STOP	1 STOP CLOSURE	1 STOP CLOSURE
1 LEVER PASSAGE	1 SET PUSH/PULL HDWR LOCK W/CYLINDER		1 SET CLOSERS	1 ALUM. THRESHOLD	1 LEVER OFFICE LOCK
			1 SET WEATHER-STRIPPING	1 SET WEATHERSTRIPPING	
			1 SET PUSH/PULL HDWR LOCK W/CYLINDER	1 SET LEVER ENTRANCE LOCK	

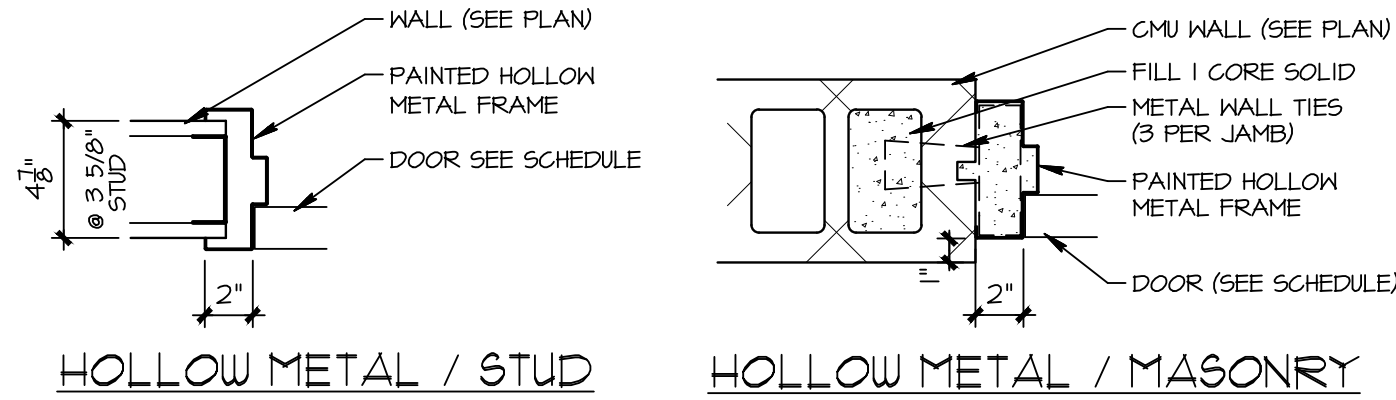


FRAME DETAILS

SCALE: 1 1/2" = 1'-0"

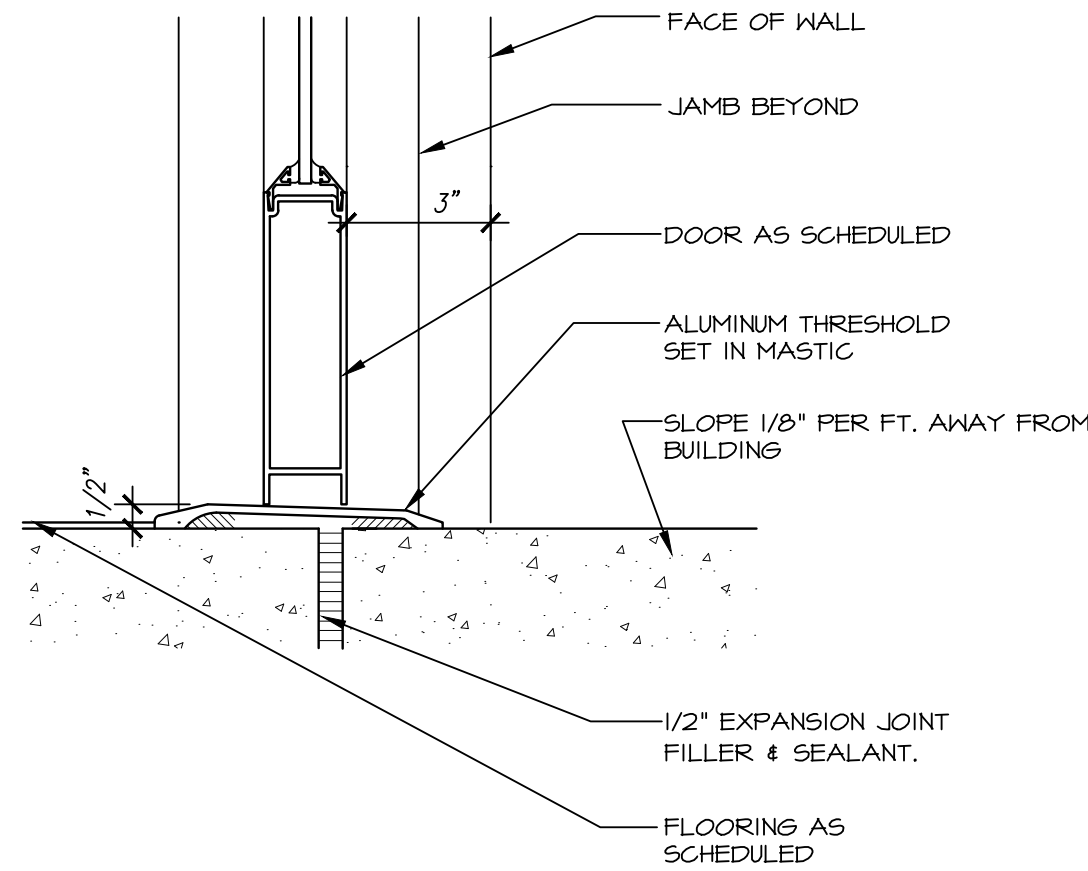


THRESHOLD DETAIL

SCALE: 3" = 1'-0"

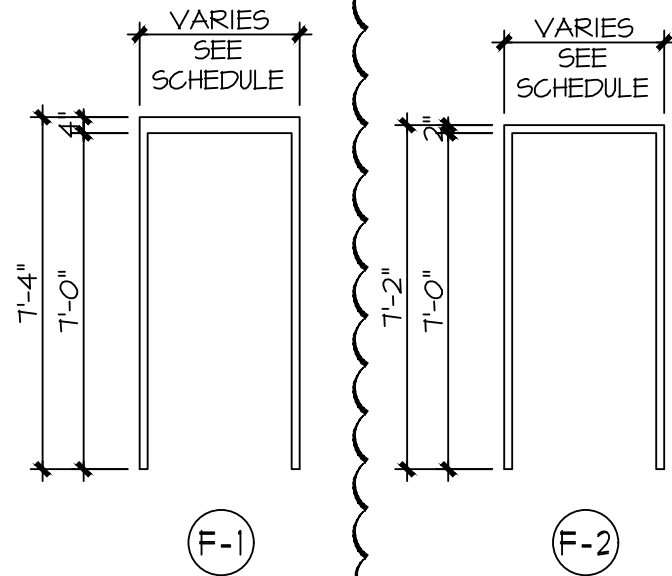


DOOR FRAMES

SCALE: 1/4" = 1'-0"

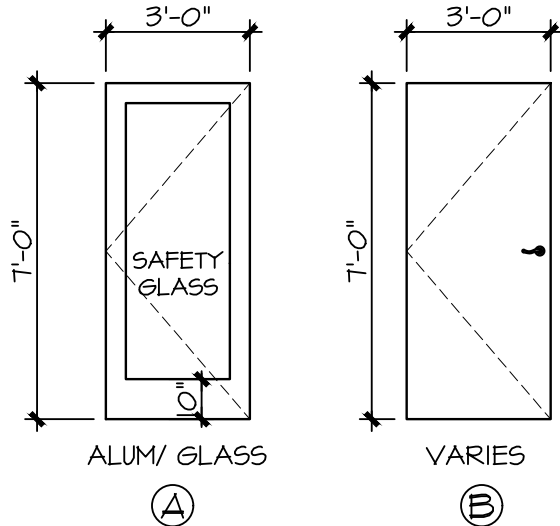


DOOR STYLES

SCALE: 1/4" = 1'-0"

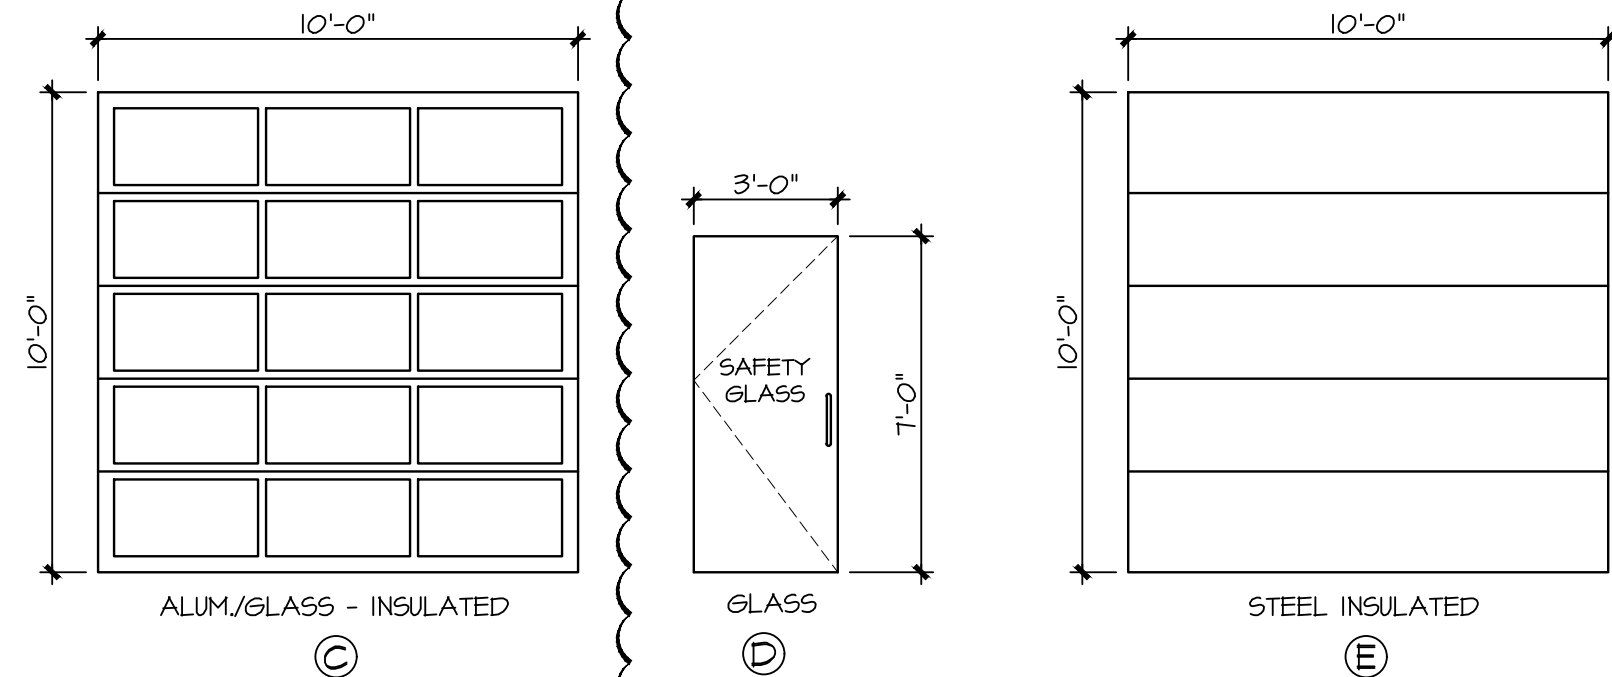


WINDOW FRAMES


SCALE: 1/4" = 1'-0"

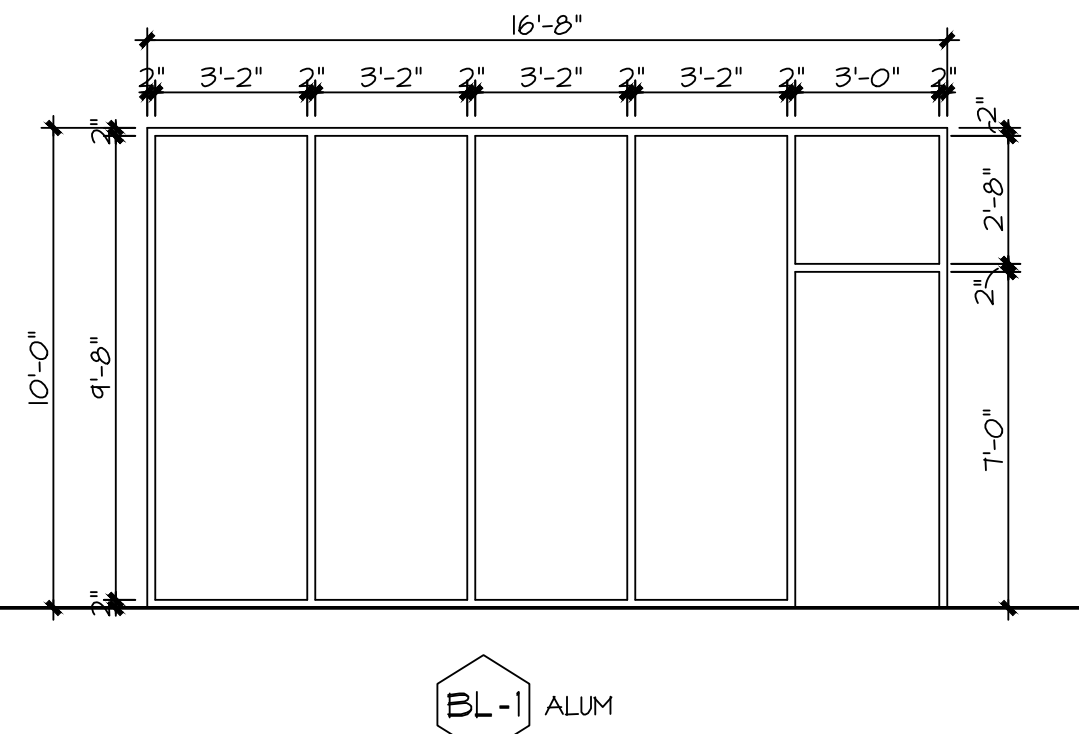

BORROWED LITES

SCALE: 1/4" = 1'-0"

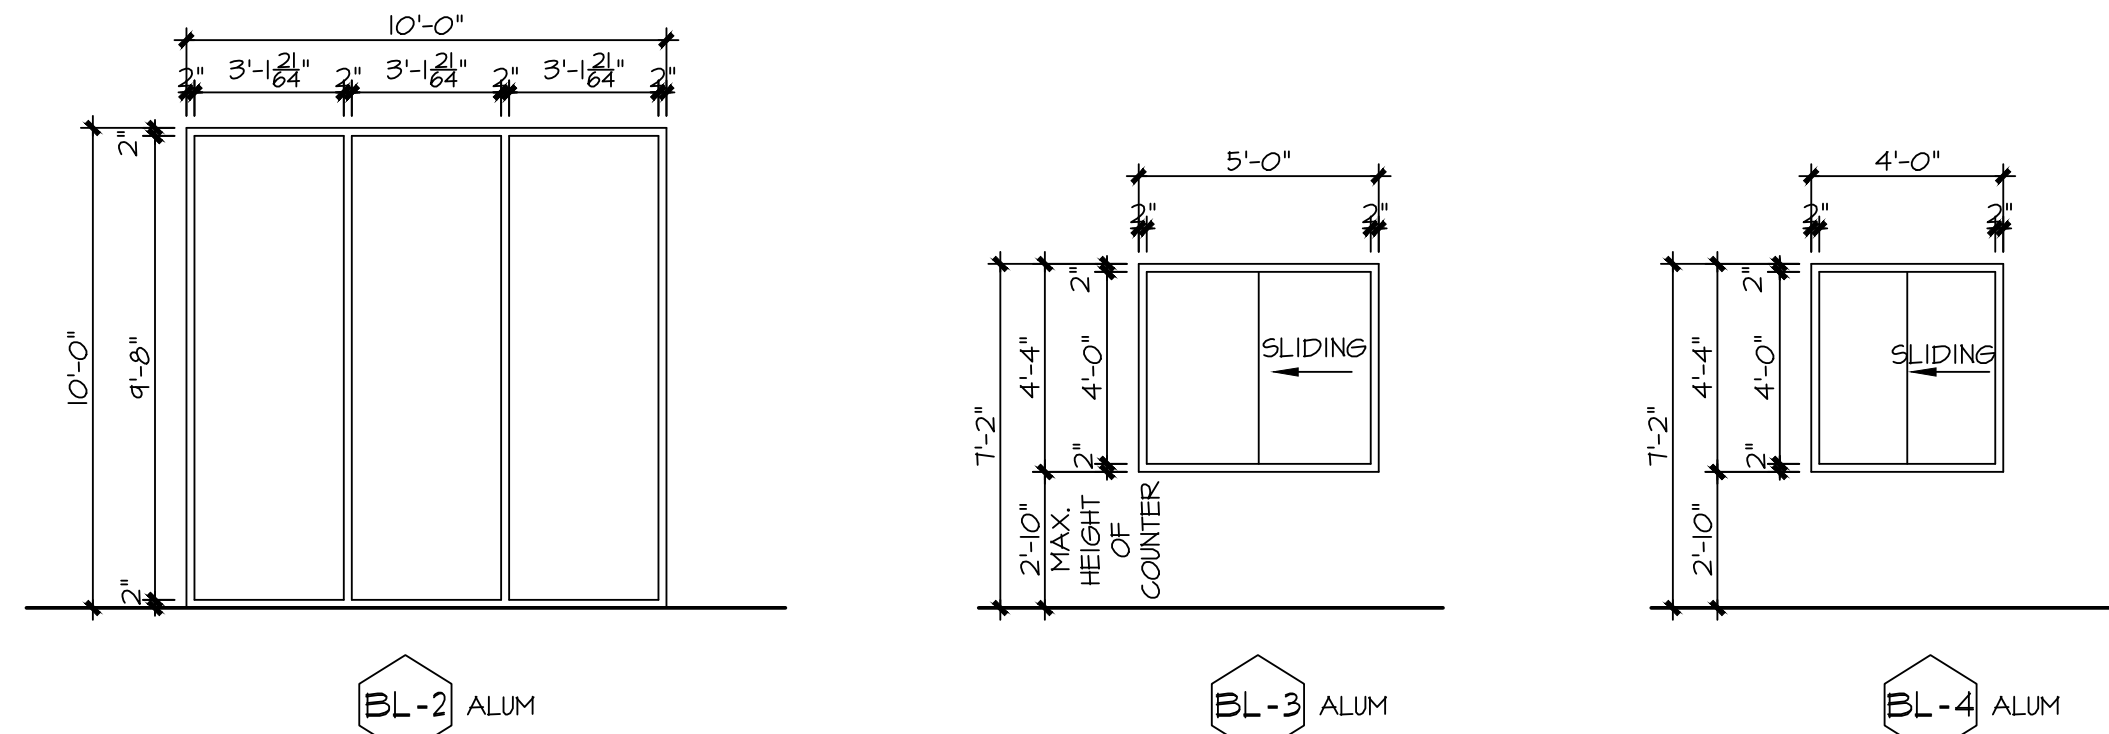

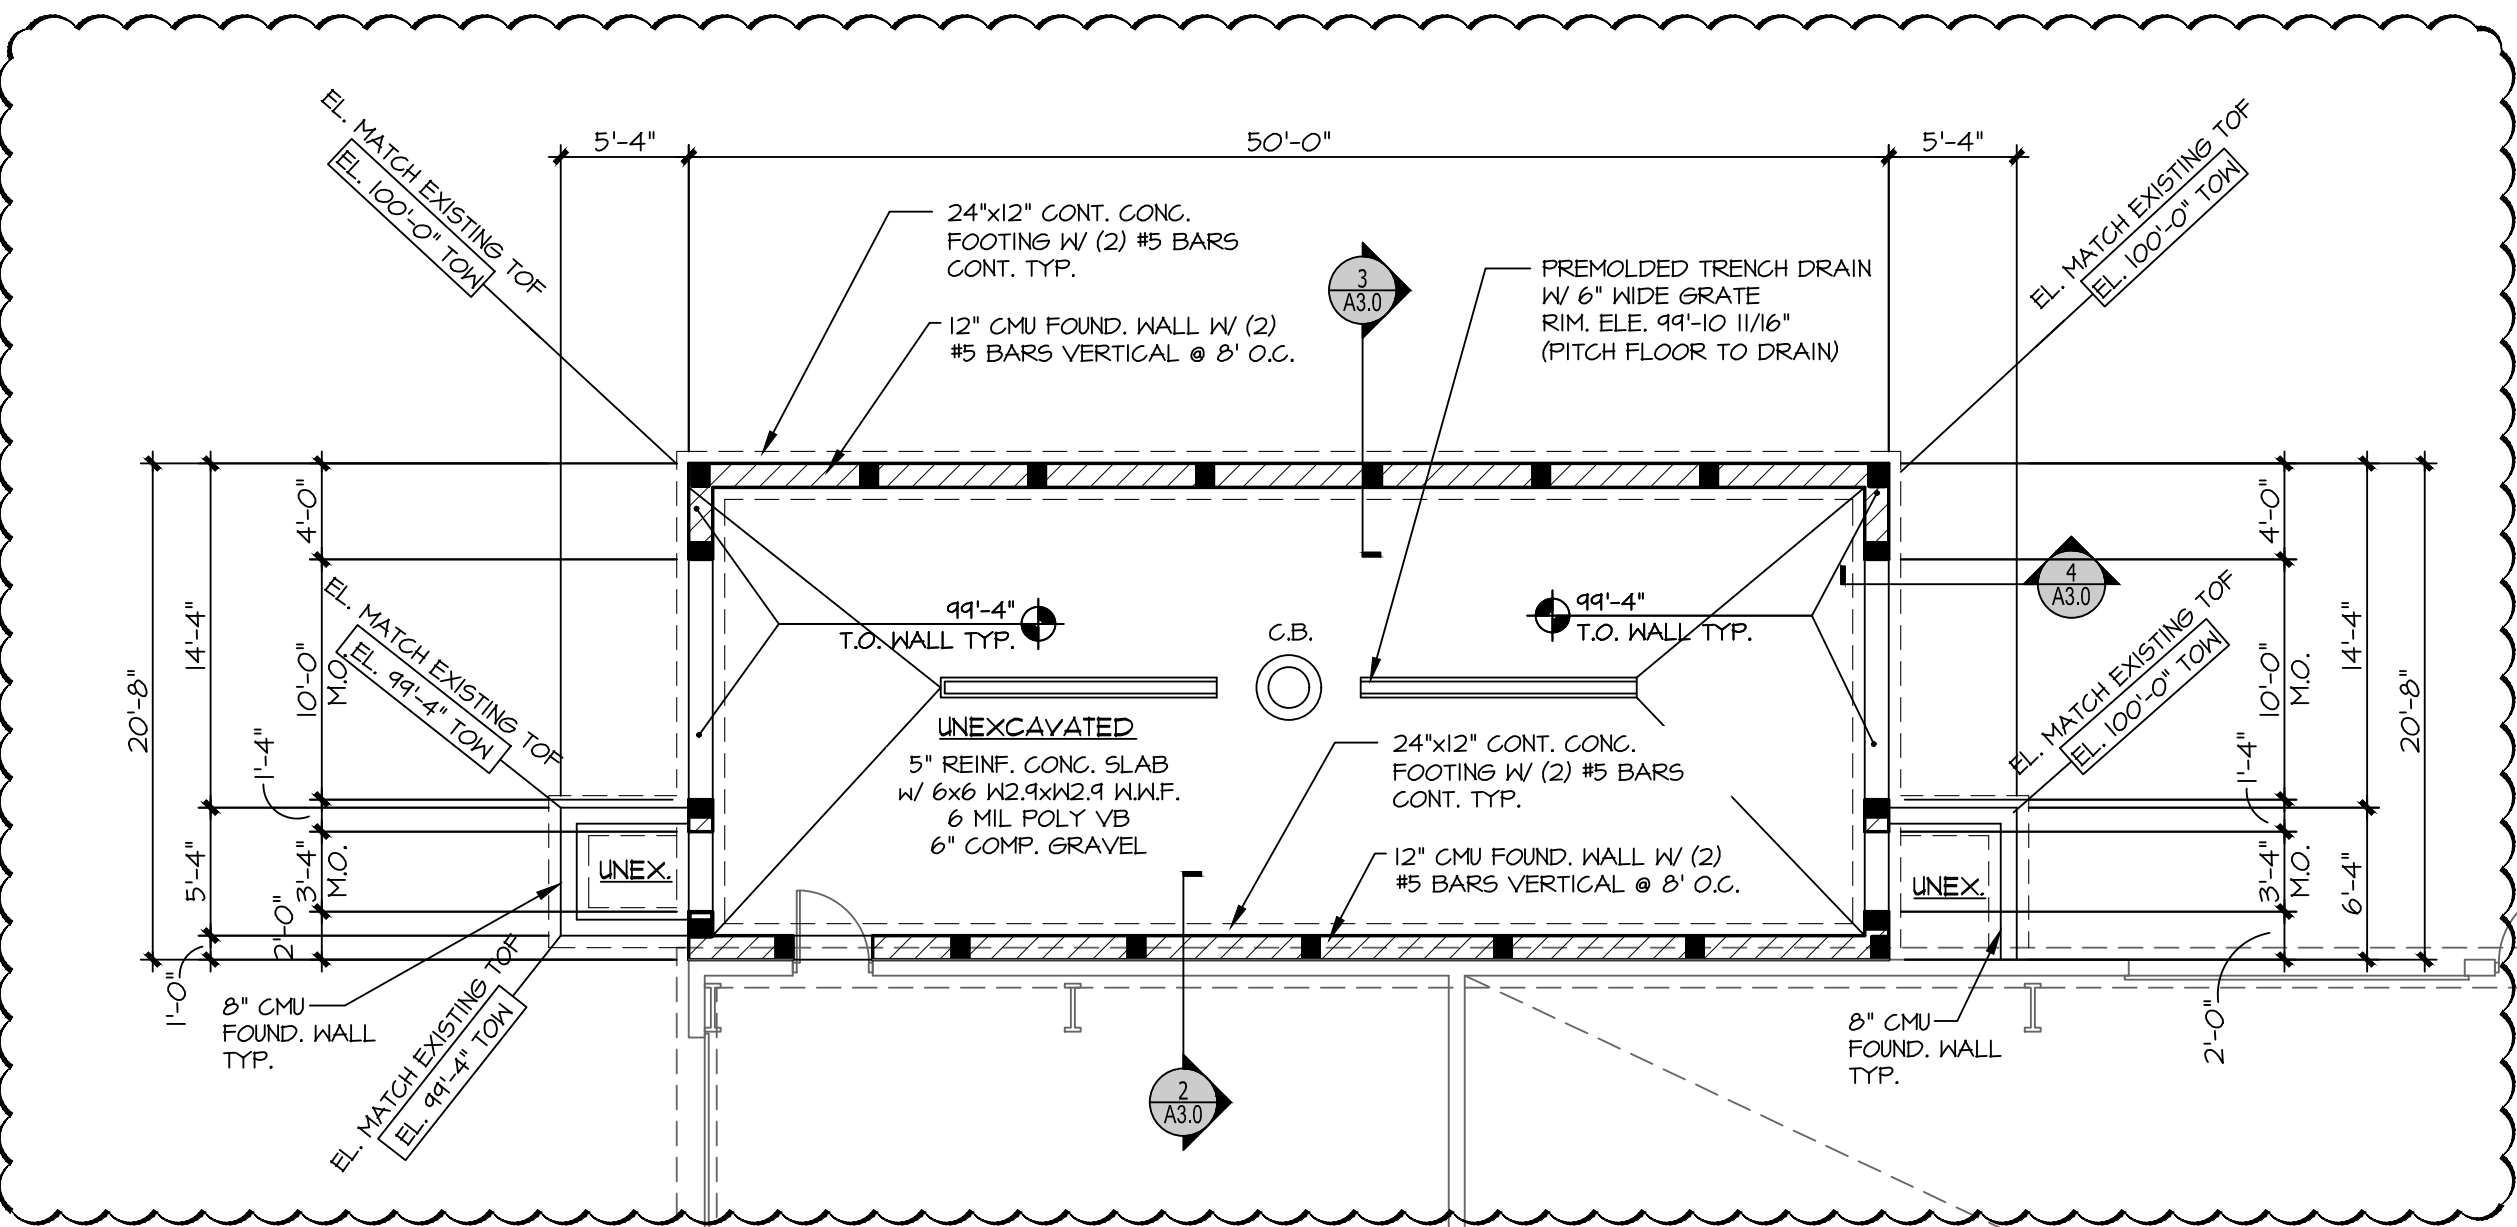

REINFORCEMENT DEVELOPMENT & LAP SPLICE SCHEDULE											
SCHEDULE NOTES:											
1. ALL VALUES BELOW ARE IN INCHES.											
2. ALL SPLICES IN REINFORCEMENT SHALL BE CLASS "B" LAPS UNLESS OTHERWISE NOTED.											
3. STEEL REINFORCING BARS SHALL CONFORM TO ASTM A615 (GRADE 60).											
4. TENSION DEVELOPMENT LENGTHS AND TENSION LAP SPLICE LENGTHS ARE CALCULATED PER CURRENT ADDITION OF ACI-318.											
5. TOP BARS ARE DEFINED AS HORIZONTAL BARS HAVING 12" OR MORE OF CONCRETE CAST BELOW THE BARS.											
BAR SIZE	#3	#4	#5	#6	#7	#8	#9	#10	#11	REMARKS	
CLASS A SPLICE LENGTH	22	29	36	43	63	72	81	91	101		
CLASS B SPLICE LENGTH	28	37	47	56	81	93	105	118	131		


DIMENSION NOTES
DIMENSIONS @ EXTERIOR WALLS ARE TO FACE OF SHEATHING / FOUNDATION

LEGEND:
T.O.W. = TOP OF WALL
T.O.P. = TOP OF PIER
T.O.L. = TOP OF LEDGE
T.O.F. = TOP OF FOOTING

FLUSH PILASTERS
(2) #5 BARS IN ONE CORE GROUTED SOLID IN 3000 PSI CONCRETE W/ #5 DOVEL. @ FOOTING 8'-0" O.C. MAX SPACING (UNLESS NOTED)

CONTROL JOINT NOTE:
4" SLAB = 8'-0" MAX. SPACING
5" SLAB = 10'-0" MAX. SPACING

2

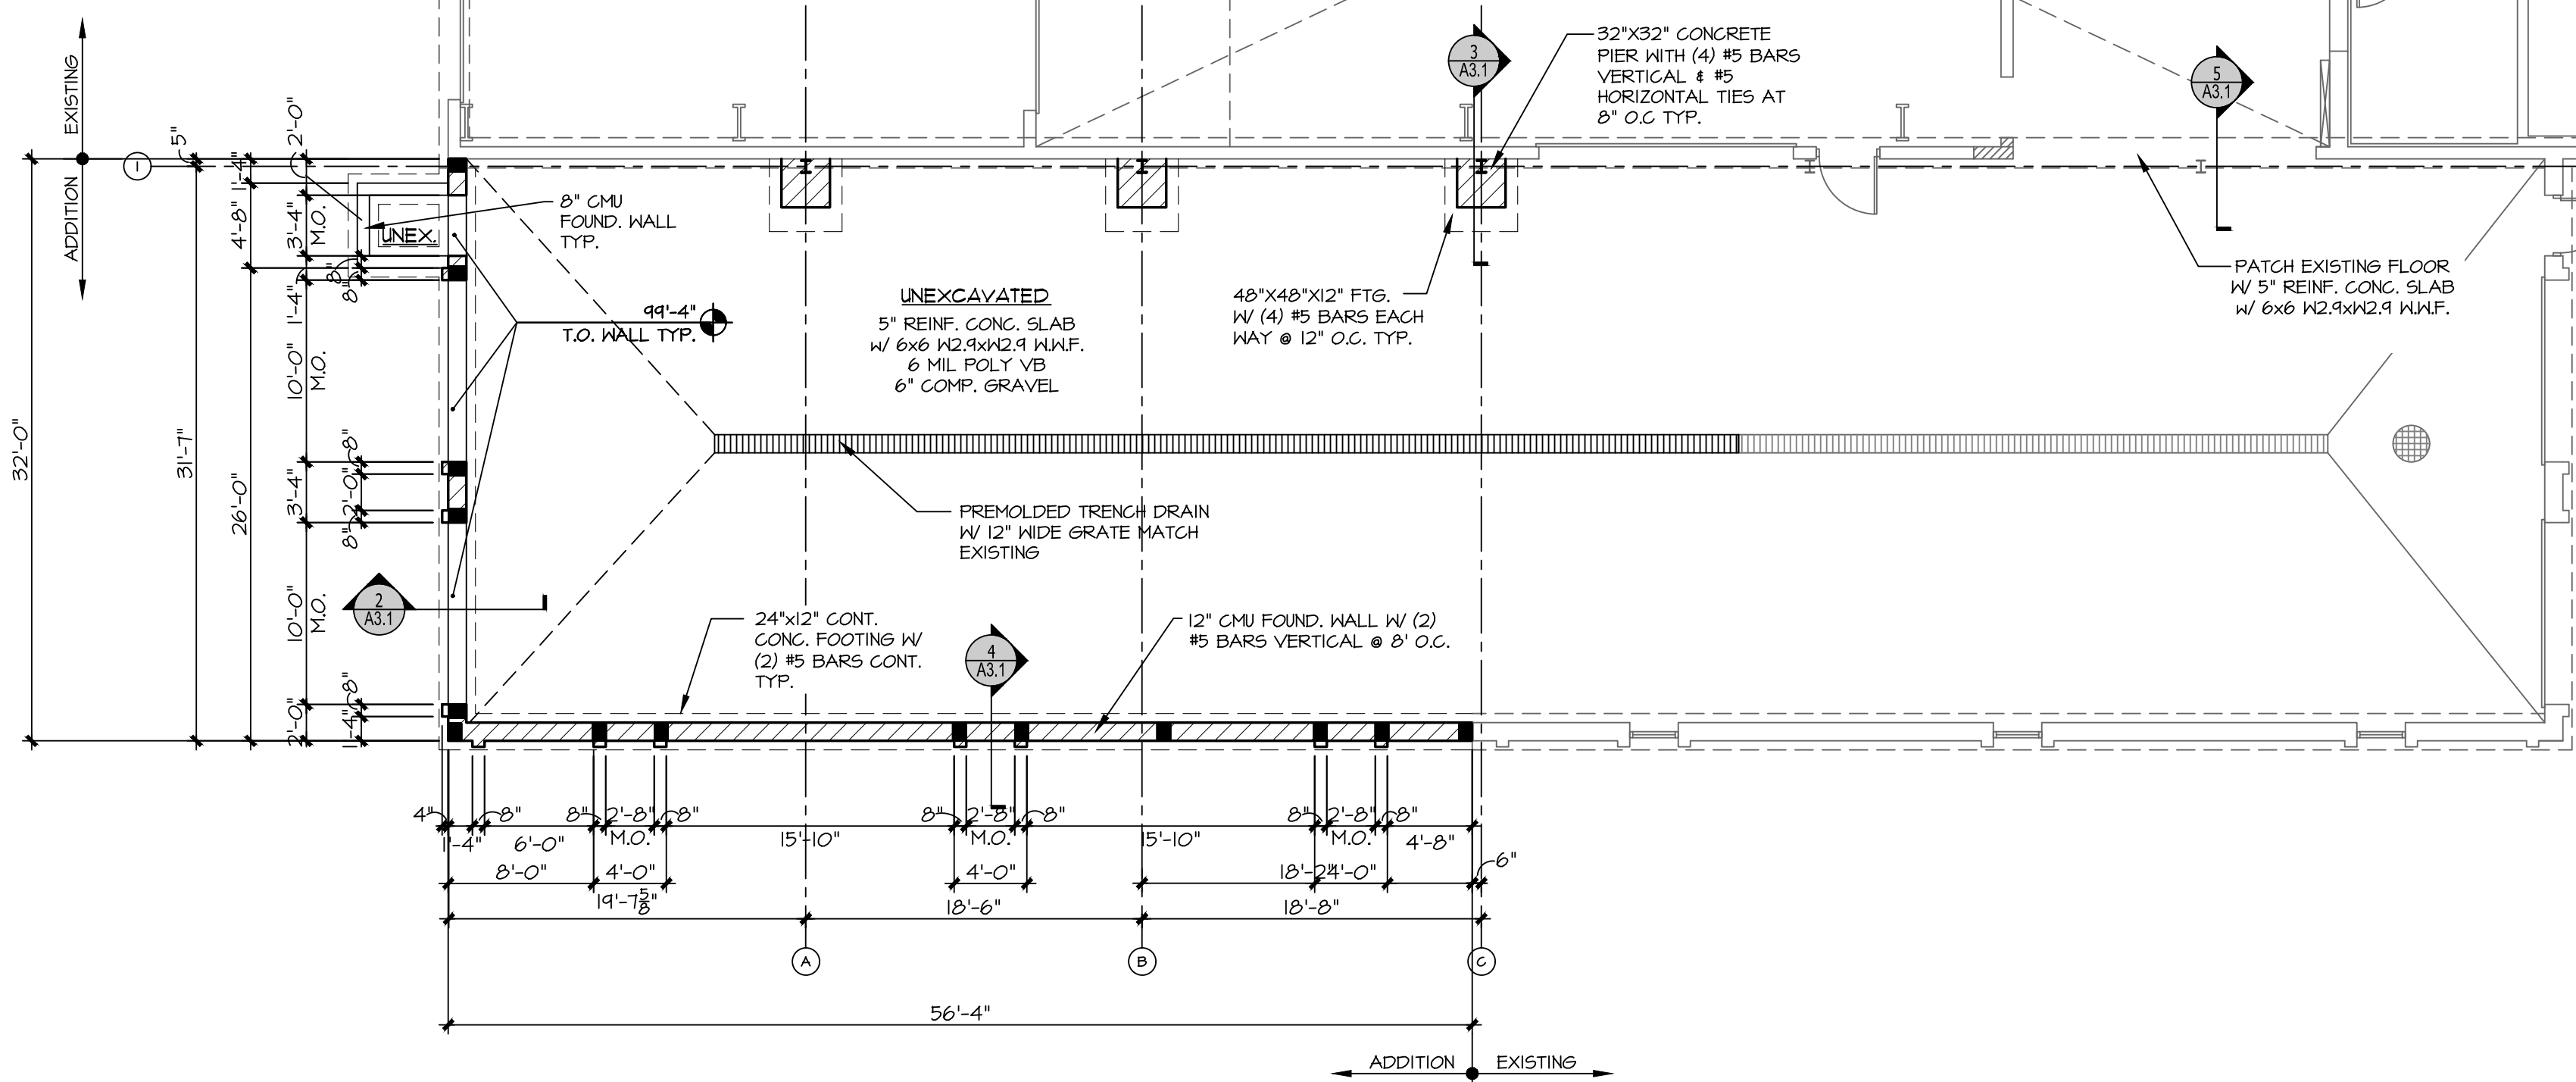

1 FOUNDATION PLAN
1/8"=1'-0"

TDI ASSOCIATES, INC.
ARCHITECTURE & PLANNING

25217 SOUTH WIND LAKE ROAD
WIND LAKE, WISCONSIN 53185
PHONE 262-409-2530

PROFESSIONAL CONSULTANTS, INC.
300 COTTONWOOD AVE # 7
HARTLAND, WISCONSIN 53029
(262) 367-6080

RUSS DARROW
KIA OF WAUKESHA
2141 EAST MORELAND BLVD
WAUKESHA, WISCONSIN

TDI ASSOCIATES, INC.
All Rights Reserved
OWNERSHIP OF DOCUMENTS
This document, and the ideas and design incorporated herein, as an instrument of professional service, is the sole property of TDI Associates, Inc., and is not to be used in whole or in part for any other project or purpose without the expressed written authorization of TDI Associates, Inc.

Sheet Title
FOUNDATION PLAN

Issued For: **REV #2** Date: **06-27-2025**

Date: **07-25-2024**

Job NO.: **24103.000**

Drawn By: **LCC**

Sheet No.

S1.1

