


# PROPOSED RESIDENTIAL SUBDIVISION WINTERBERRY RESERVE

## WAUKESHA, WISCONSIN


### SHEET INDEX

SHEETS BELOW INTENDED TO BE PRINTED IN COLOR. REFER TO DIGITAL FORMAT DRAWINGS IF PRINTED GRAYSCALE TO ENSURE SCOPE CLARITY.

NUMBER	SHEET NAME/DESCRIPTION	PRELIMINARY	PRELIMINARY	SHEET ISSUE BID & PERMITTING	ADDENDUM 1
		DATE:	JAN. 27, 2025	--- --, 2025	--- --, 2025
TITLE SHEET, SPECIFICATIONS, AND DETAILS					
C1.0	CIVIL COVER SHEET	PRELIM			
EXISTING CONDITIONS PLAN					
C3.0	EXISTING SITE PLAN	PRELIM			
MASS GRADING AND EROSION CONTROL					
C4.0	OVERALL MASTER GRADING AND EROSION CONTROL PLAN	PRELIM			
C4.1	NORTHWEST MASTER GRADING AND EROSION CONTROL PLAN	PRELIM			
C4.2	NORTHEAST MASTER GRADING AND EROSION CONTROL PLAN	PRELIM			
C4.3	SOUTH MASTER GRADING AND EROSION CONTROL PLAN	PRELIM			
UTILITY SYSTEM PLAN					
C5.0	SYSTEM PLAN	PRELIM			
PLAN AND PROFILE					
C6.0	WINTERBERRY DRIVE	PRELIM			
C6.1	CRANBERRY CIRCLE	PRELIM			
C6.2	CRANBERRY CIRCLE	PRELIM			
C6.3	WINTERBERRY DRIVE AND WINDSOR PLACE	PRELIM			
C6.4	ALLEY	PRELIM			
LANDSCAPE AND LIGHTING PLAN					
C10.0	LANDSCAPE AND RESTORATION PLAN	PRELIM			
SHEET INDEX LEGEND: PRELIMINARY SHEET = PRELIM ISSUED SHEET = ●					

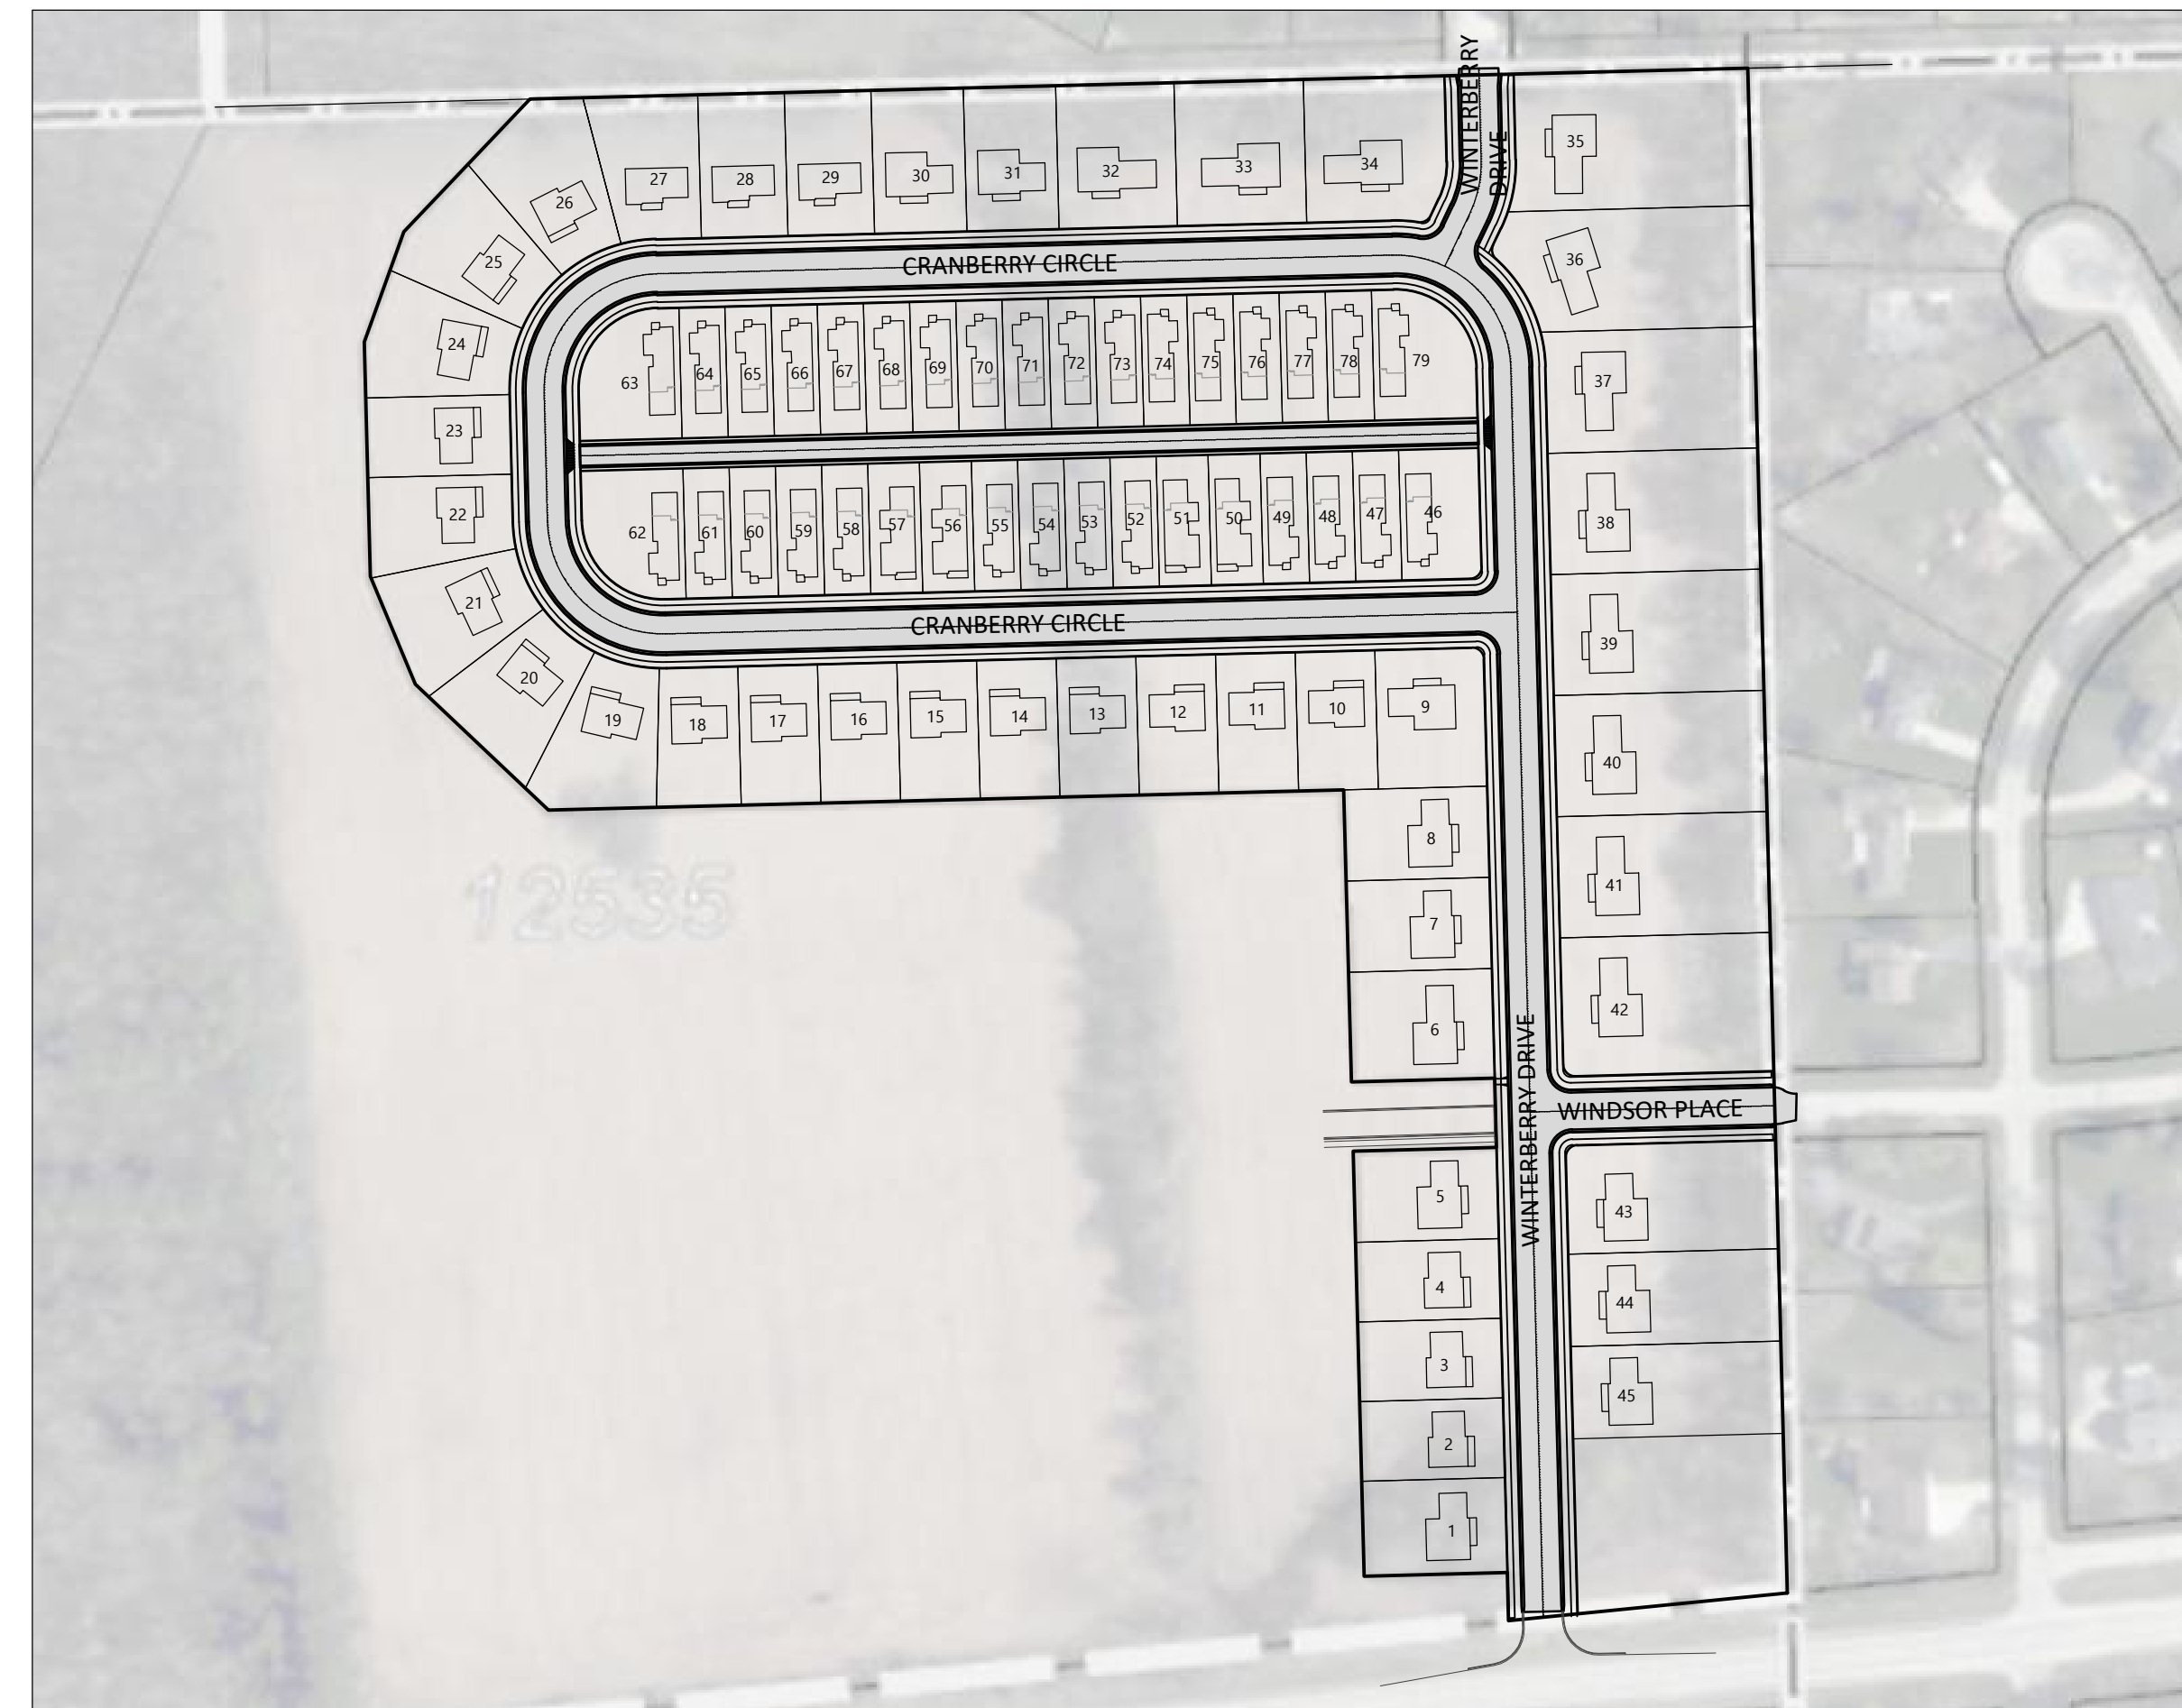

SUBDIVISION LAYOUT OVERVIEW

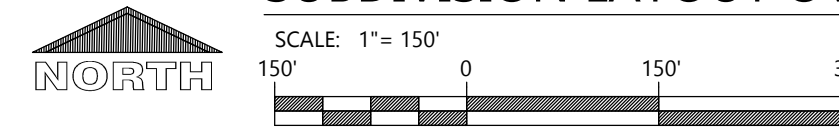

### LEGEND


NOTE: ALL SYMBOLS SHOWN MAY NOT APPEAR ON DRAWINGS.

SYM.	IDENTIFICATION	SYM.	IDENTIFICATION
<b>SPOT ELEVATIONS</b>			
● 888.30	PROPOSED SPOT ELEVATIONS	↖ 877.37	PROPOSED SPOT ELEVATIONS - INTERSECTION PLANS (FLOW LINE OF CURB UNLESS OTHERWISE SPECIFIED)
● 893.0 EG	EXISTING GRADE SPOT ELEVATIONS	✗ 876.1	INTERMEDIATE GRADE SPOT ELEVATIONS
<b>EXISTING SITE SYMBOLS</b>			
—	EXISTING SIGN	⊘	EXISTING UTILITY POLE
⊙	EXISTING WATER VALVE IN BOX	⊘→	EXISTING UTILITY POLE WITH GUY WIRE
⊙	EXISTING WATER VALVE IN MANHOLE	○→	EXISTING STREET LIGHT
✕	EXISTING WATER SERVICE VALVE	⊞	EXISTING TELEPHONE PEDESTAL
⊙	EXISTING WELL	⊞	EXISTING ELECTRIC PEDESTAL
⊙	EXISTING STORM CATCH BASIN	⊞	EXISTING ELECTRIC BOX
■	EXISTING STORM CURB INLET	▲	EXISTING FLOOD LIGHT
⊞	EXISTING SQUARE CATCH BASIN	⊞	EXISTING TELEPHONE MANHOLE
⊞	EXISTING END SECTION	⊞	EXISTING CABLE TV PEDESTAL
☆	EXISTING LIGHT POLE	⊞	EXISTING GAS VALVE
■	1-1/4" REBAR SET WEIGHING 4.30 LB/FT.	⊞	EXISTING HEDGE
●	3/4" REBAR SET WEIGHING 1.50 LB/FT.	⊞	EXISTING WOODED AREA
□	1-1/4" REBAR FOUND	⊞	EXISTING MARSH AREA
○	3/4" REBAR FOUND	⊞	EXISTING DECIDUOUS TREE WITH TRUNK DIAMETER
⊙	2" IRON PIPE FOUND	⊞	EXISTING CONIFEROUS TREE
▲	1" IRON PIPE FOUND	⊞	EXISTING SHRUB
⊞	SECTION CORNER	⊞	EXISTING STUMP
<b>PROPOSED SITE SYMBOLS</b>			
—	PROPOSED SIGN	→	PROPOSED DRAINAGE FLOW
⊙	PROPOSED WATER VALVE IN BOX	→	INTERMEDIATE DRAINAGE FLOW
✕	PROPOSED WATER SERVICE VALVE (CURB STOP)	■	SOIL BORING
⊙	PROPOSED STORM FIELD INLET - ST FI	⊞	PROPOSED CLEANOUT
■	PROPOSED STORM CURB INLET - ST CI	⊞	PROPOSED BAILE DITCH CHECK
⊞	PROPOSED STORM END SECTION	⊞	PROPOSED SILT LOG
<b>EXISTING LINETYPES</b>			
—	EXISTING CHAINLINK FENCE	— 800 —	EXISTING GROUND CONTOUR
—	EXISTING WOOD FENCE	FO	EXISTING UNDERGROUND FIBER OPTIC LINE
✕	EXISTING BARBED WIRE FENCE	E	EXISTING UNDERGROUND ELECTRIC CABLE
—	EXISTING CURB AND GUTTER	T	EXISTING UNDERGROUND TELEPHONE CABLE
—	EXISTING GUARD RAIL	G	EXISTING UNDERGROUND GAS LINE
ST	EXISTING STORM SEWER AND MANHOLE	OU	EXISTING OVERHEAD UTILITY LINE
SA	EXISTING SANITARY SEWER AND MANHOLE	—	EXISTING RAILROAD TRACKS
W	EXISTING WATER LINE AND HYDRANT	—	EXISTING RIGHT-OF-WAY LINE
<b>PROPOSED LINETYPES</b>			
—	PROPOSED SILT FENCE	—	PROPOSED STORM SEWER AND MANHOLE - ST MH
—	PROPOSED CURB AND GUTTER	—	PROPOSED SANITARY SEWER AND MANHOLE - SAN MH
— 800 —	PROPOSED GROUND CONTOUR	—	PROPOSED WATER LINE AND HYDRANT
--- 760 ---	INTERMEDIATE GROUND CONTOUR	—	PHASE LIMITS
—	PROPOSED PROPERTY LINE		

### PROJECT CONTACTS

<b>OWNER INFORMATION:</b> VERIDIAN HOMES MATT CUDNEY 6801 S. TOWNE DRIVE MADISON, WI 53713 Phone: (608) 236-3016 Email: m.cudney@veridianhomes.com	<b>CIVIL:</b> EXCEL ENGINEERING GRANT DUCHAC, P.E. 100 CAMELOT DRIVE FOND DU LAC, WI 54935 Phone: (920) 322-1681 E-mail: grant.duchac@excelengineer.com	<b>CITY PLANNER:</b> MARIA PANDAZI Phone: (262) 524-3530 E-mail: maria.pandazi@waukesha-wi.gov	<b>CITY ENGINEER:</b> BRANDON SCHWENN, P.E. Phone: (262) 524-3600 E-mail: brandon.schwenn@waukesha-wi.gov	<b>CITY FIRE MARSHAL:</b> BRIAN CHARLESWORTH Phone: (262) 524-3651 E-mail: brian.charlesworth@waukesha-wi.gov	<b>CITY BUILDING INSPECTOR:</b> KRISTIN STONE Phone: (262) 524-3530 E-mail: kristin.stone@waukesha-wi.gov	<b>CITY DEVELOPMENT DIRECTOR:</b> JENNIFER ANDREWS Phone: (262) 524-3750 E-mail: jennifer.andrews@waukesha-wi.gov	<b>WATER UTILITY:</b> CHRIS WALTER, P.E. Phone: (262) 409-4460 E-mail: chris.walter@waukesha-wi.gov	<b>CITY FORESTER:</b> AARON LEHNERT Phone: (262) 349-1931 E-mail: aaron.lehnert@waukesha-wi.gov	<b>CITY TRANSIT MANAGER:</b> BRIAN ENGELING Phone: (262) 524-3636 E-mail: brian.engeling@waukesha-wi.gov
--	---	---	--	--	--	--	--	--	---

### LOCATION MAP

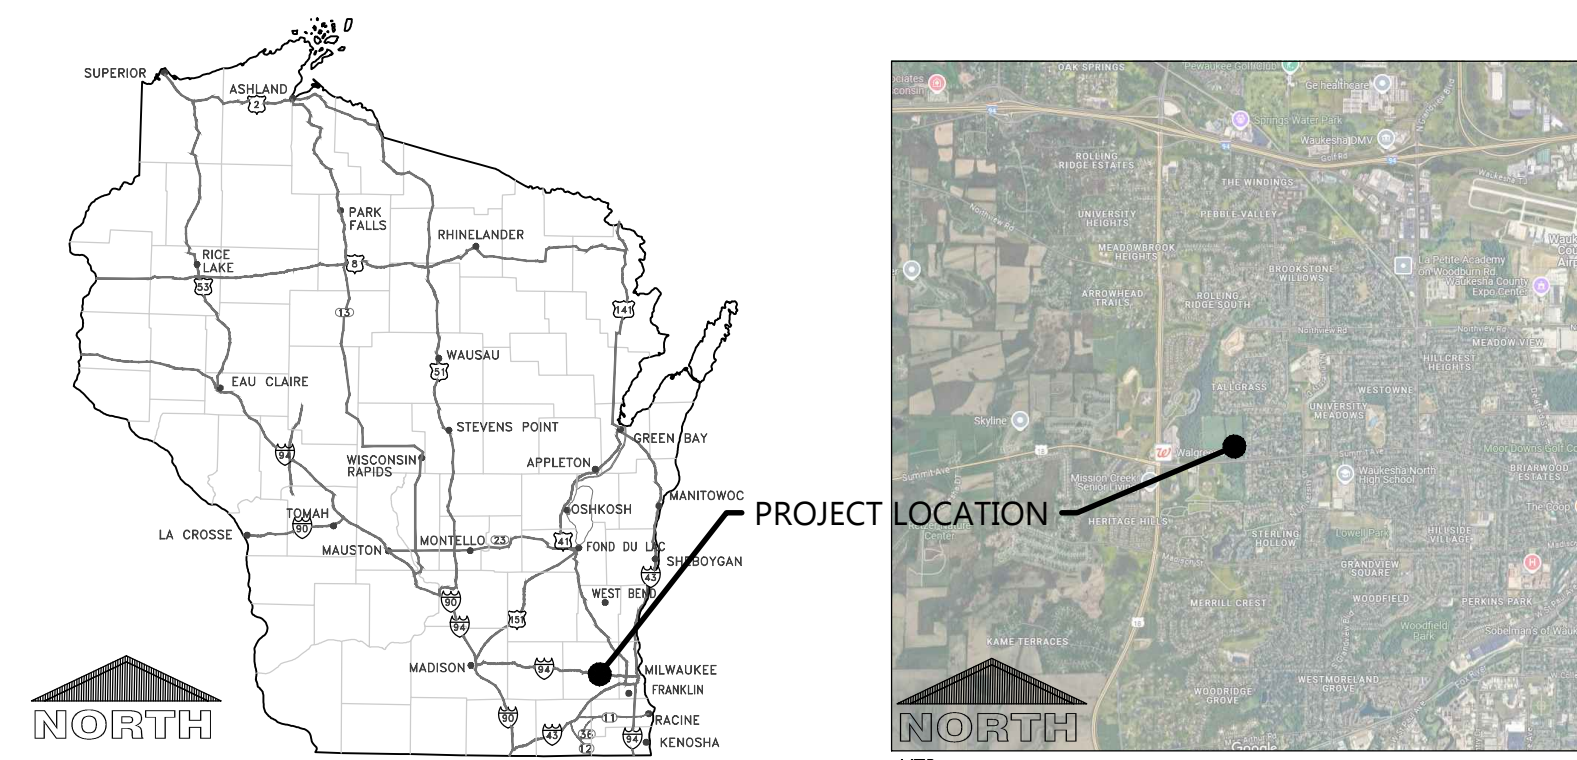

TO OBTAIN LOCATION OF PARTICIPANTS' UNDERGROUND FACILITIES BEFORE YOU DIG IN WISCONSIN  
CALL DIGGERS HOTLINE  
1-800-242-8511  
TOLL FREE TELEFAX (414) 259-0947  
TDD (FOR THE HEARING IMPAIRED) 1-800-542-2289  
WISCONSIN STATUTE 182.0175 (1974)  
REQUIRES MINIMUM OF 3 WORK DAYS NOTICE BEFORE YOU EXCAVATE

### BENCHMARK INFORMATION

BENCHMARK NUMBER	BENCHMARK DESCRIPTION (NAVD 88)	ELEVATION
BM1	ARROW ON HYDRANT SW OF THE WINTERBERRY DRIVE AND SUMMIT AVENUE INTERSECTION	911.94
BM2	ARROW ON HYDRANT AT THE NW CORNER OF MAPLE WAY AND WINDSOR PLACE	912.45
BM3	TOP OF NAIL ON EAST SIDE OF POLE LOCATED APPROXIMATELY 170' EAST OF BM2	910.17



Always a Better Plan

100 Camelot Drive  
Fond du Lac, WI 54935  
920-926-9800  
excelengineer.com

COLLABORATION



VERIDIAN  
HOMES

PROJECT INFORMATION

PROPOSED RESIDENTIAL SUBDIVISION  
**WINTERBERRY RESERVE**  
WINTERBERRY DRIVE • WAUKESHA, WI 53188

PROFESSIONAL SEAL

PRELIMINARY DATES

JAN. 27, 2025

NOT FOR CONSTRUCTION


JOB NUMBER

230103400

SHEET NUMBER

**C0.1**

CIVIL COVER SHEET

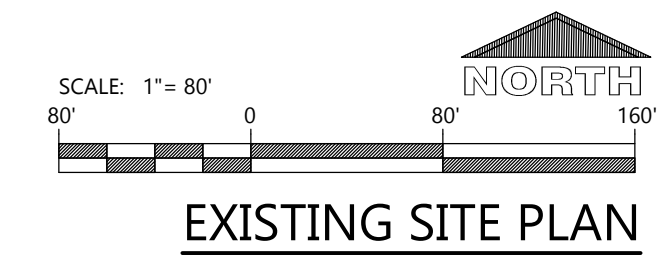

**EXCEL**  
 ARCHITECTS • ENGINEERS • SURVEYORS  
 Always a Better Plan  
 100 Camelot Drive  
 Fond Du Lac, WI 54935  
 Phone: (920) 926-9800  
 www.EXCELENGINEER.com

COLLABORATION

**VERIDIAN HOMES**

**PROJECT INFORMATION**

PROPOSED RESIDENTIAL SUBDIVISION  
**WINTERBERRY RESERVE**  
 WINTERBERRY DRIVE • WAUKESHA, WI 53188

PROFESSIONAL SEAL

**PRELIMINARY DATES**

JAN. 27, 2025


NOT FOR CONSTRUCTION

**JOB NUMBER**

230103400

**SHEET NUMBER**

**C3.0**

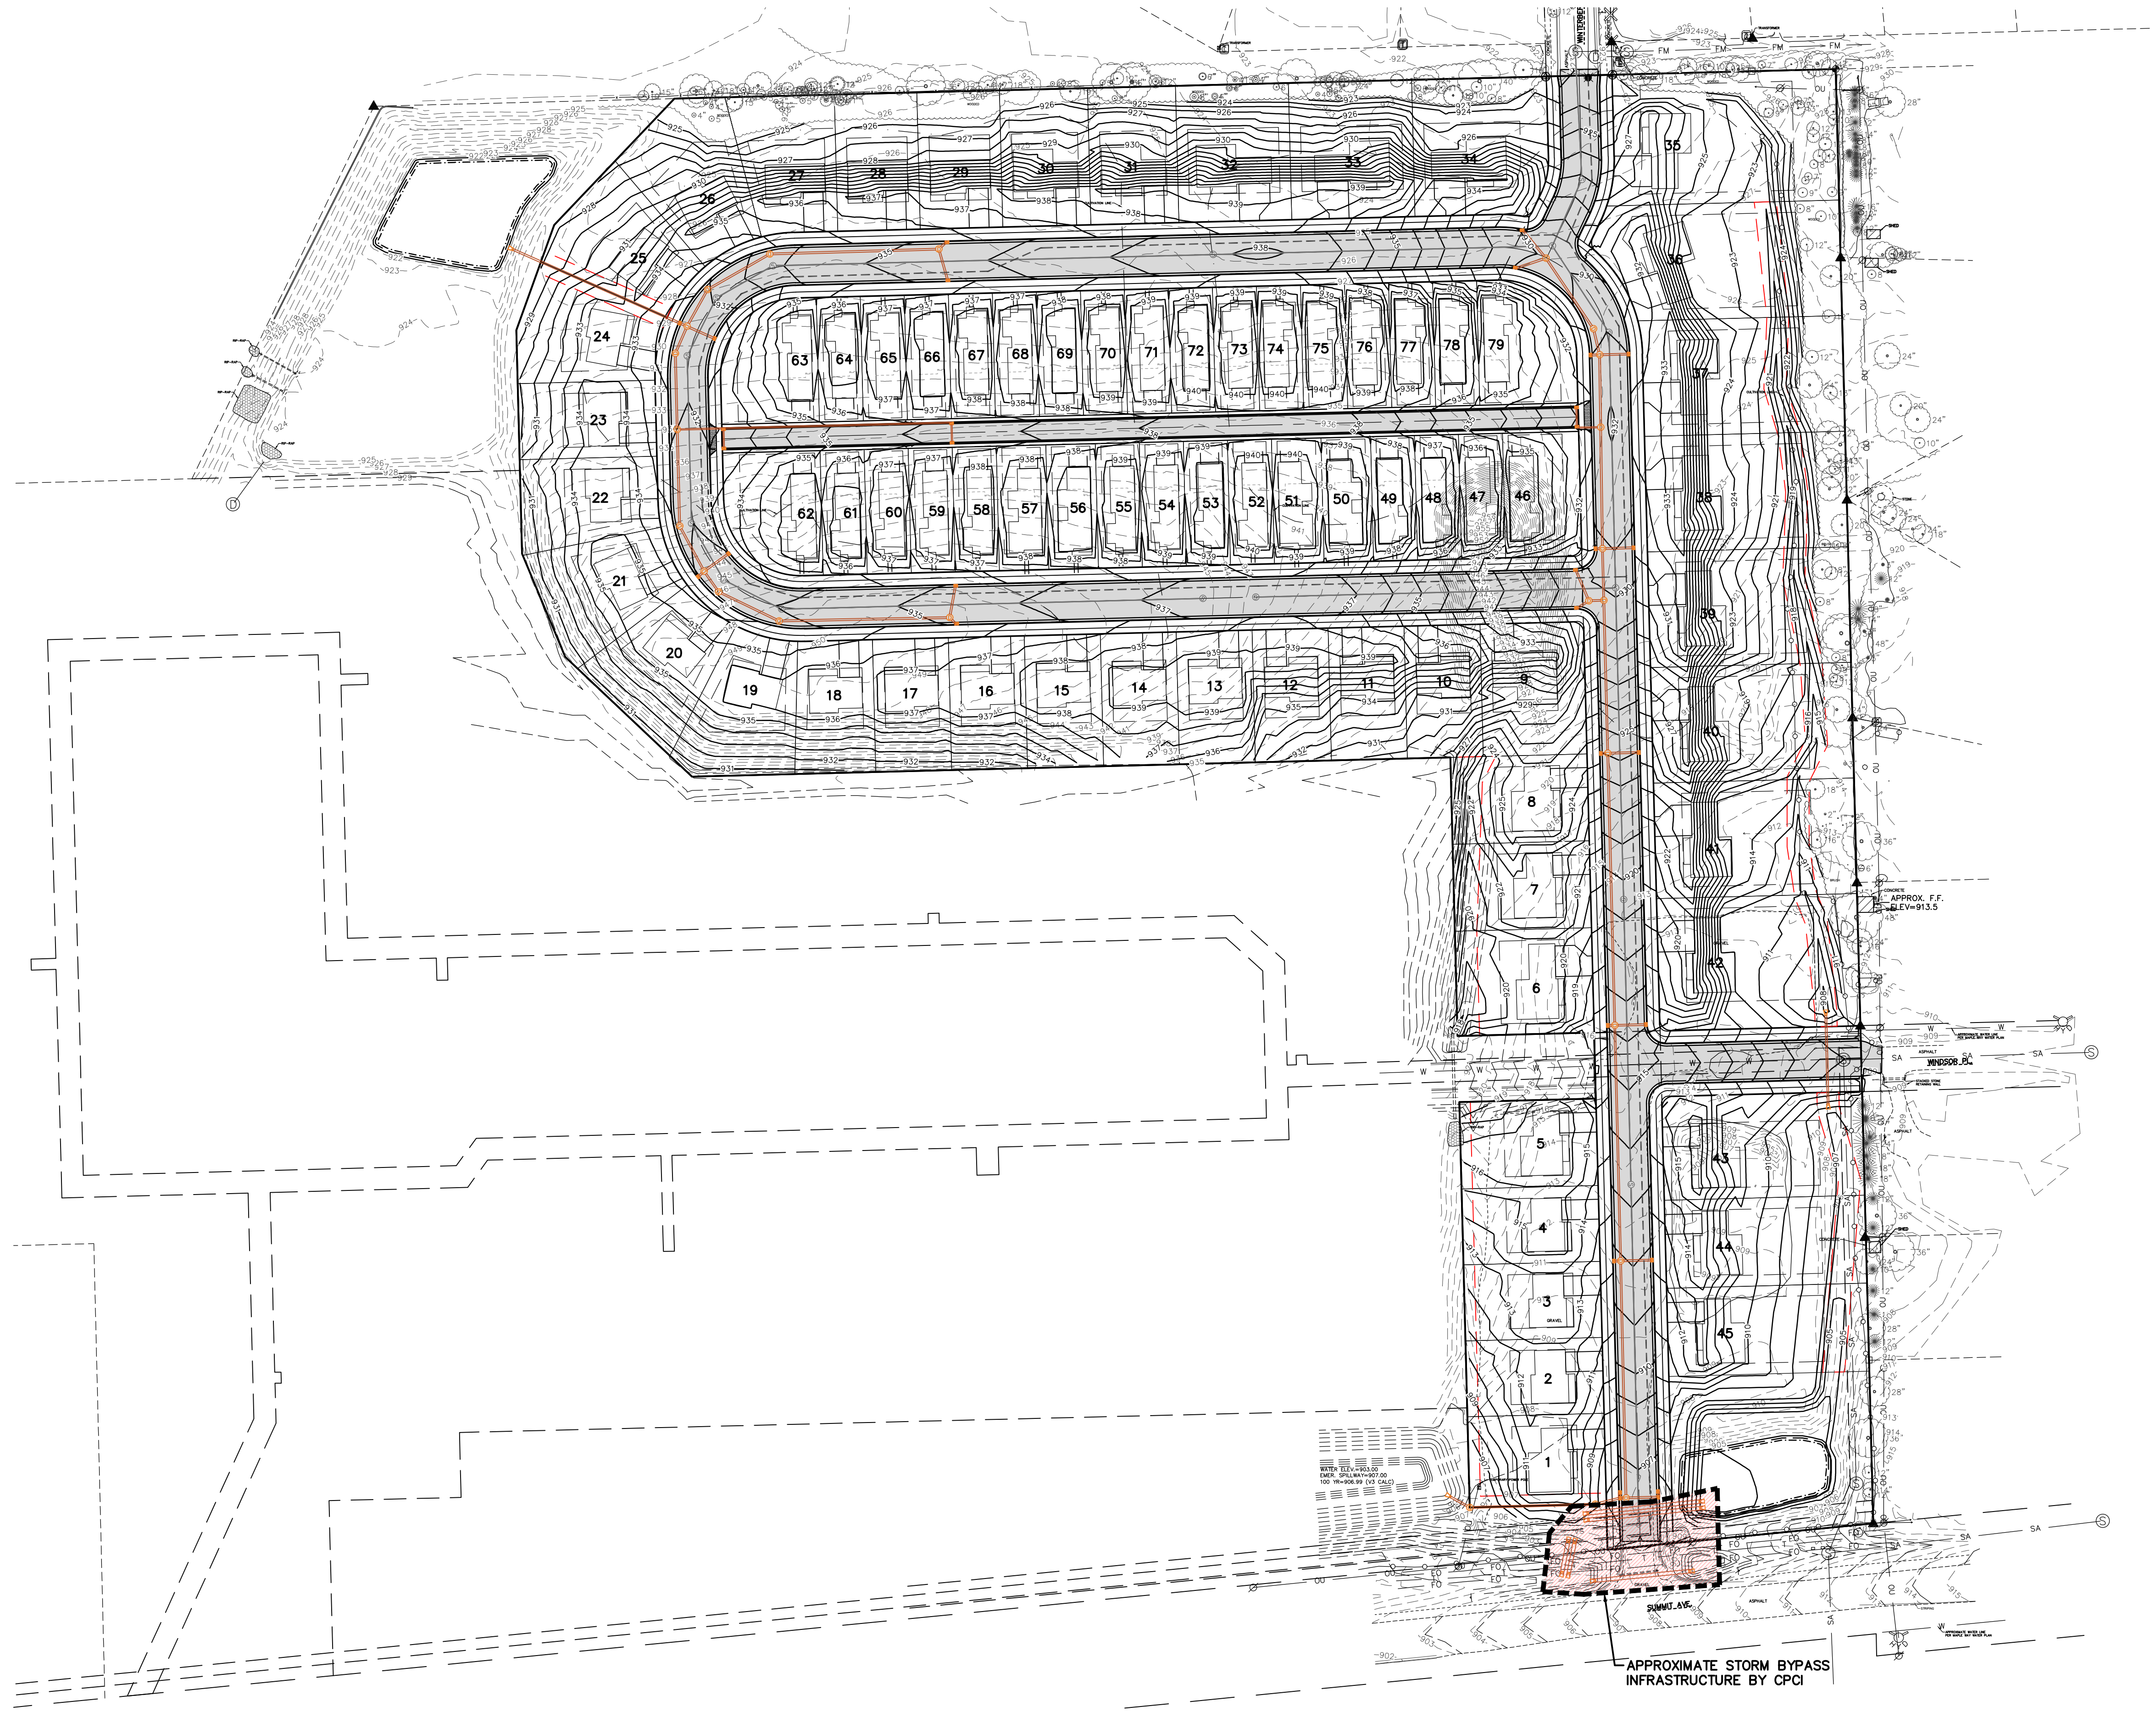

**EXCEL**  
 ARCHITECTS • ENGINEERS • SURVEYORS  
 Always a Better Plan  
 100 Camelot Drive  
 Fond Du Lac, WI 54935  
 Phone: (920) 926-9800  
 www.EXCELENGINEER.com

COLLABORATION

**VERIDIAN HOMES**

**PROJECT INFORMATION**

PROPOSED RESIDENTIAL SUBDIVISION  
**WINTERBERRY RESERVE**  
 WINTERBERRY DRIVE • WAUKESHA, WI 53188

PROFESSIONAL SEAL

**PRELIMINARY DATES**

JAN. 27, 2025


**NOT FOR CONSTRUCTION**

**JOB NUMBER**


230103400

**SHEET NUMBER**

**C4.0**

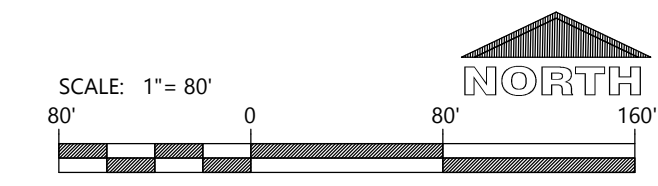

OVERALL MASTER GRADING AND EROSION CONTROL PLAN

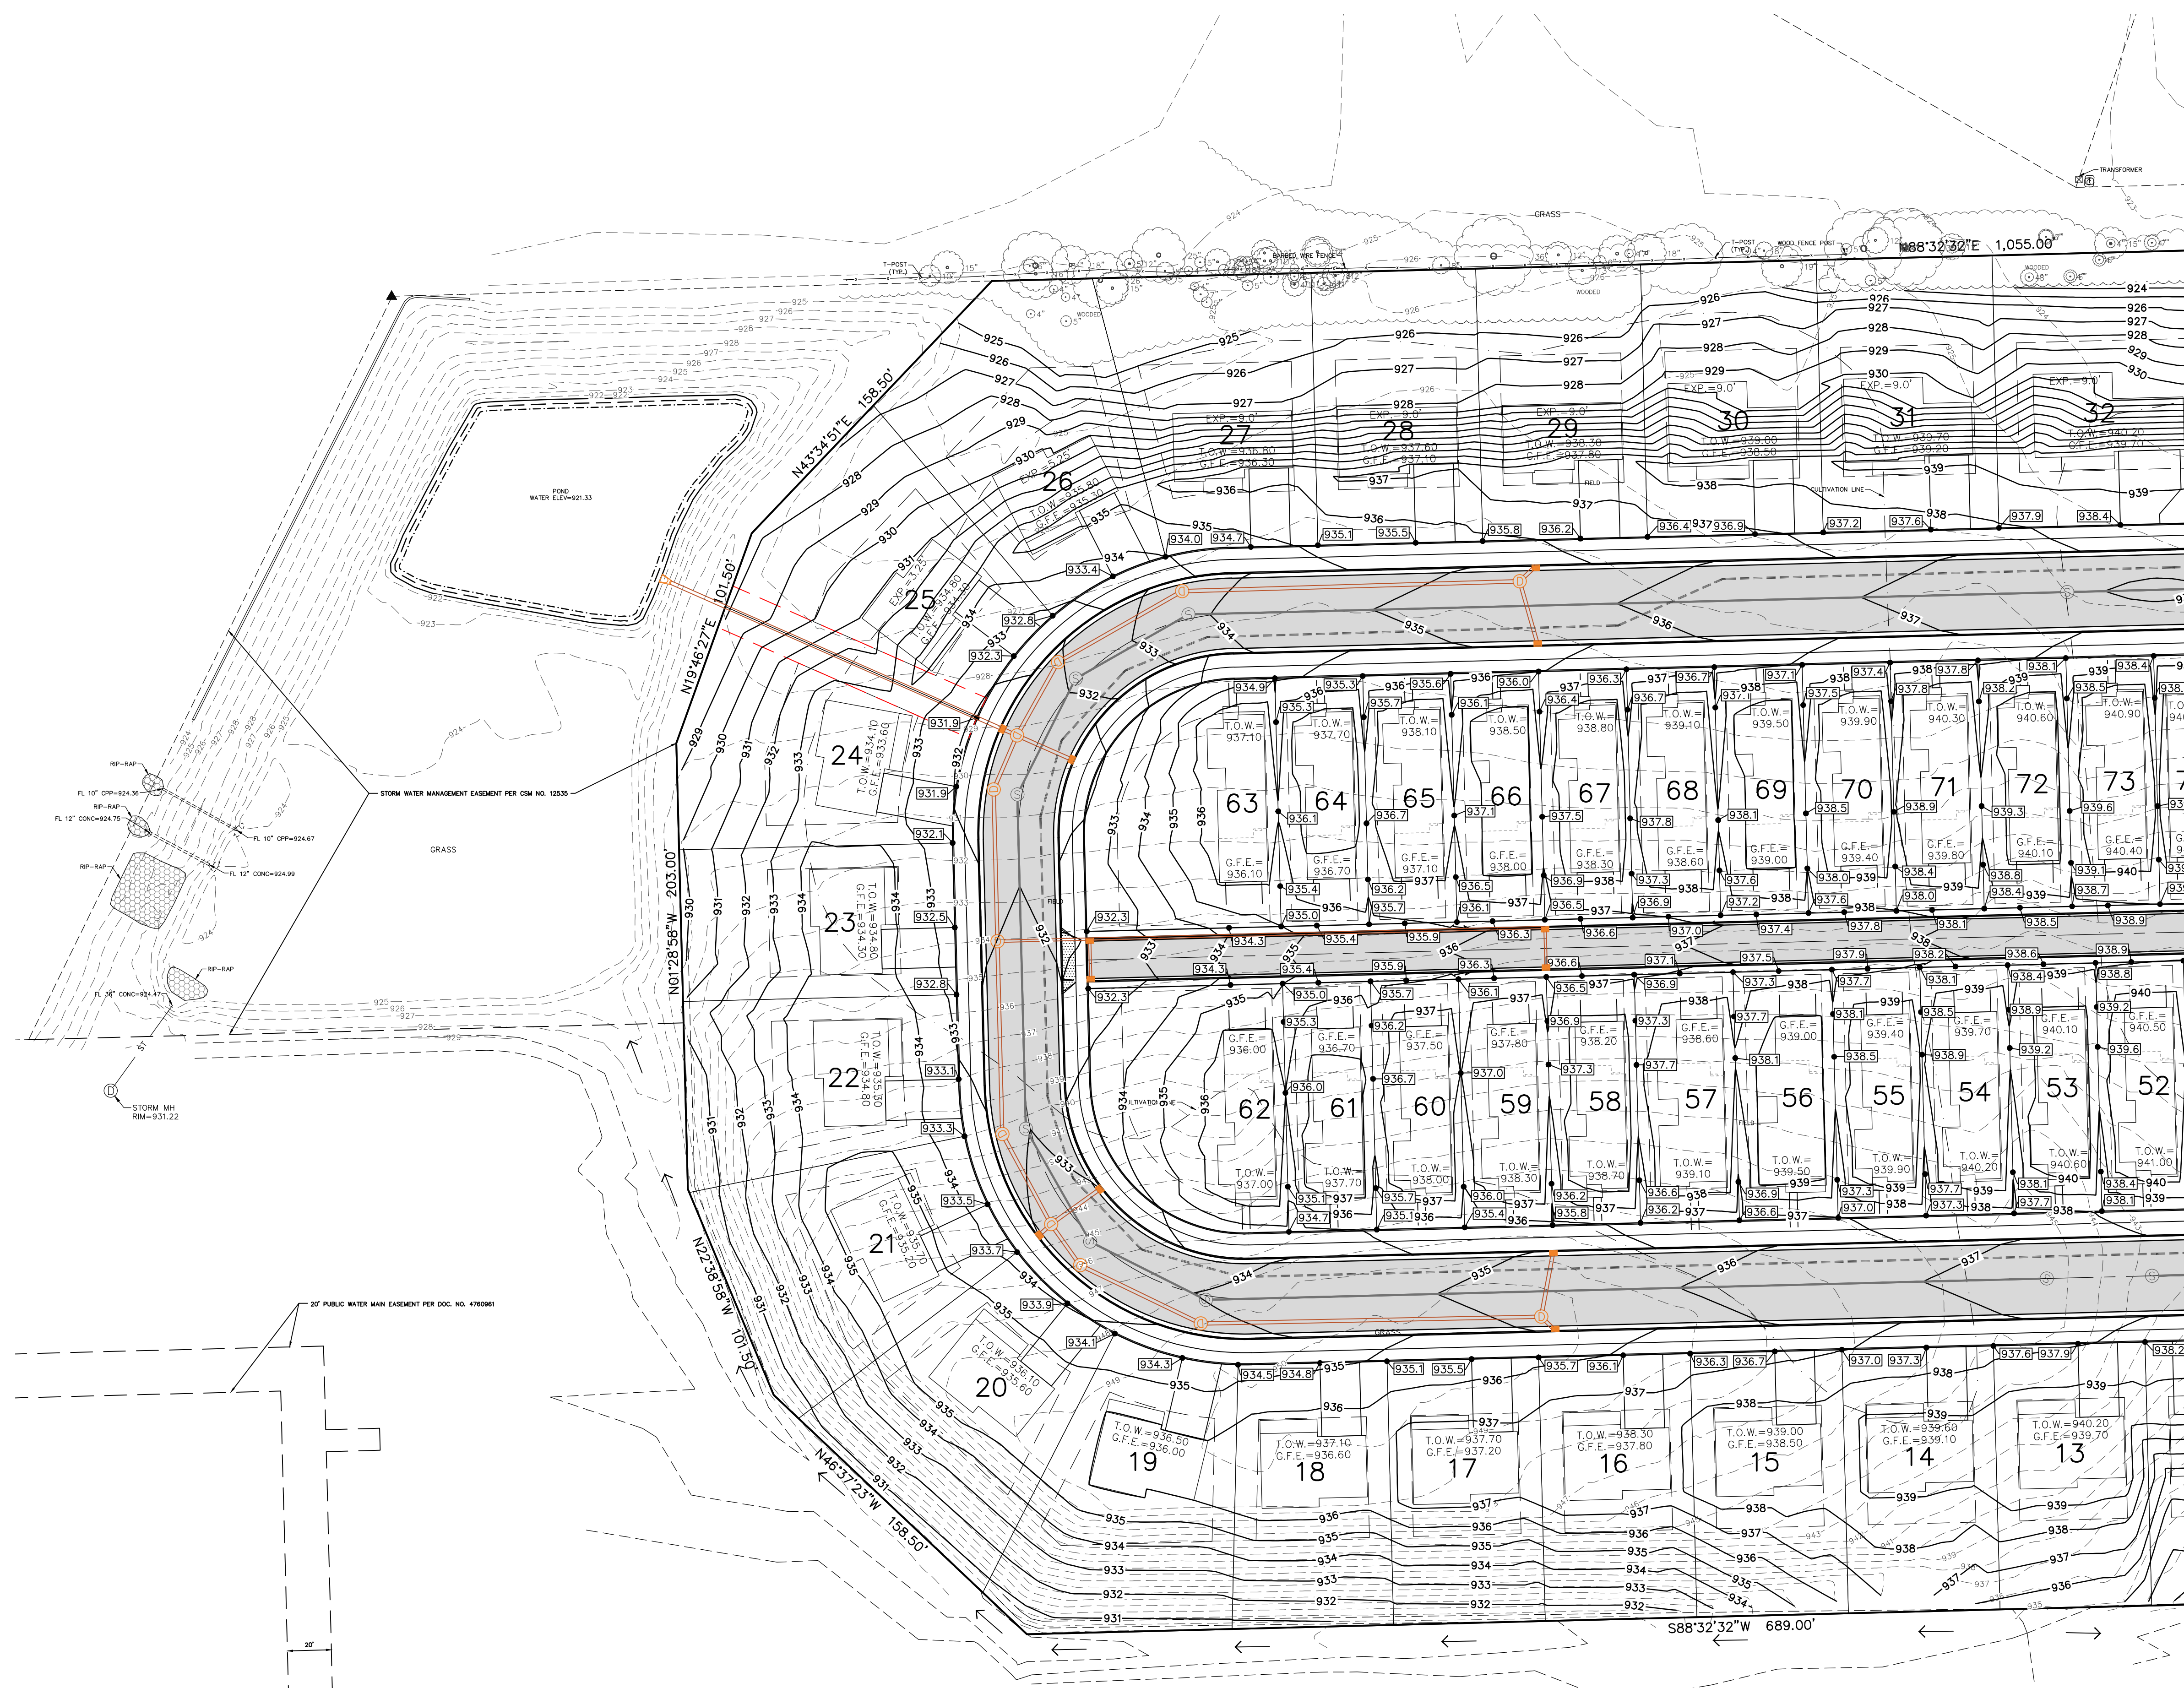

**EXCEL**  
 ARCHITECTS • ENGINEERS • SURVEYORS  
 Always a Better Plan  
 100 Camelot Drive  
 Fond Du Lac, WI 54935  
 Phone: (920) 926-9800  
 www.EXCELENGINEER.com

COLLABORATION

**VERIDIAN HOMES**

**PROJECT INFORMATION**

PROPOSED RESIDENTIAL SUBDIVISION  
**WINTERBERRY RESERVE**  
 WINTERBERRY DRIVE • WAUKESHA, WI 53188

PROFESSIONAL SEAL


**PRELIMINARY DATES**

JAN. 27, 2025



**NOT FOR CONSTRUCTION**

**JOB NUMBER**  
 230103400

**SHEET NUMBER**  
**C4.1**

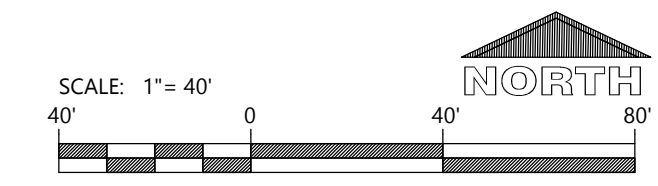

**NORTHWEST MASTER GRADING AND EROSION CONTROL PLAN**

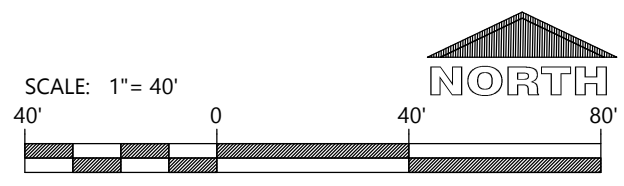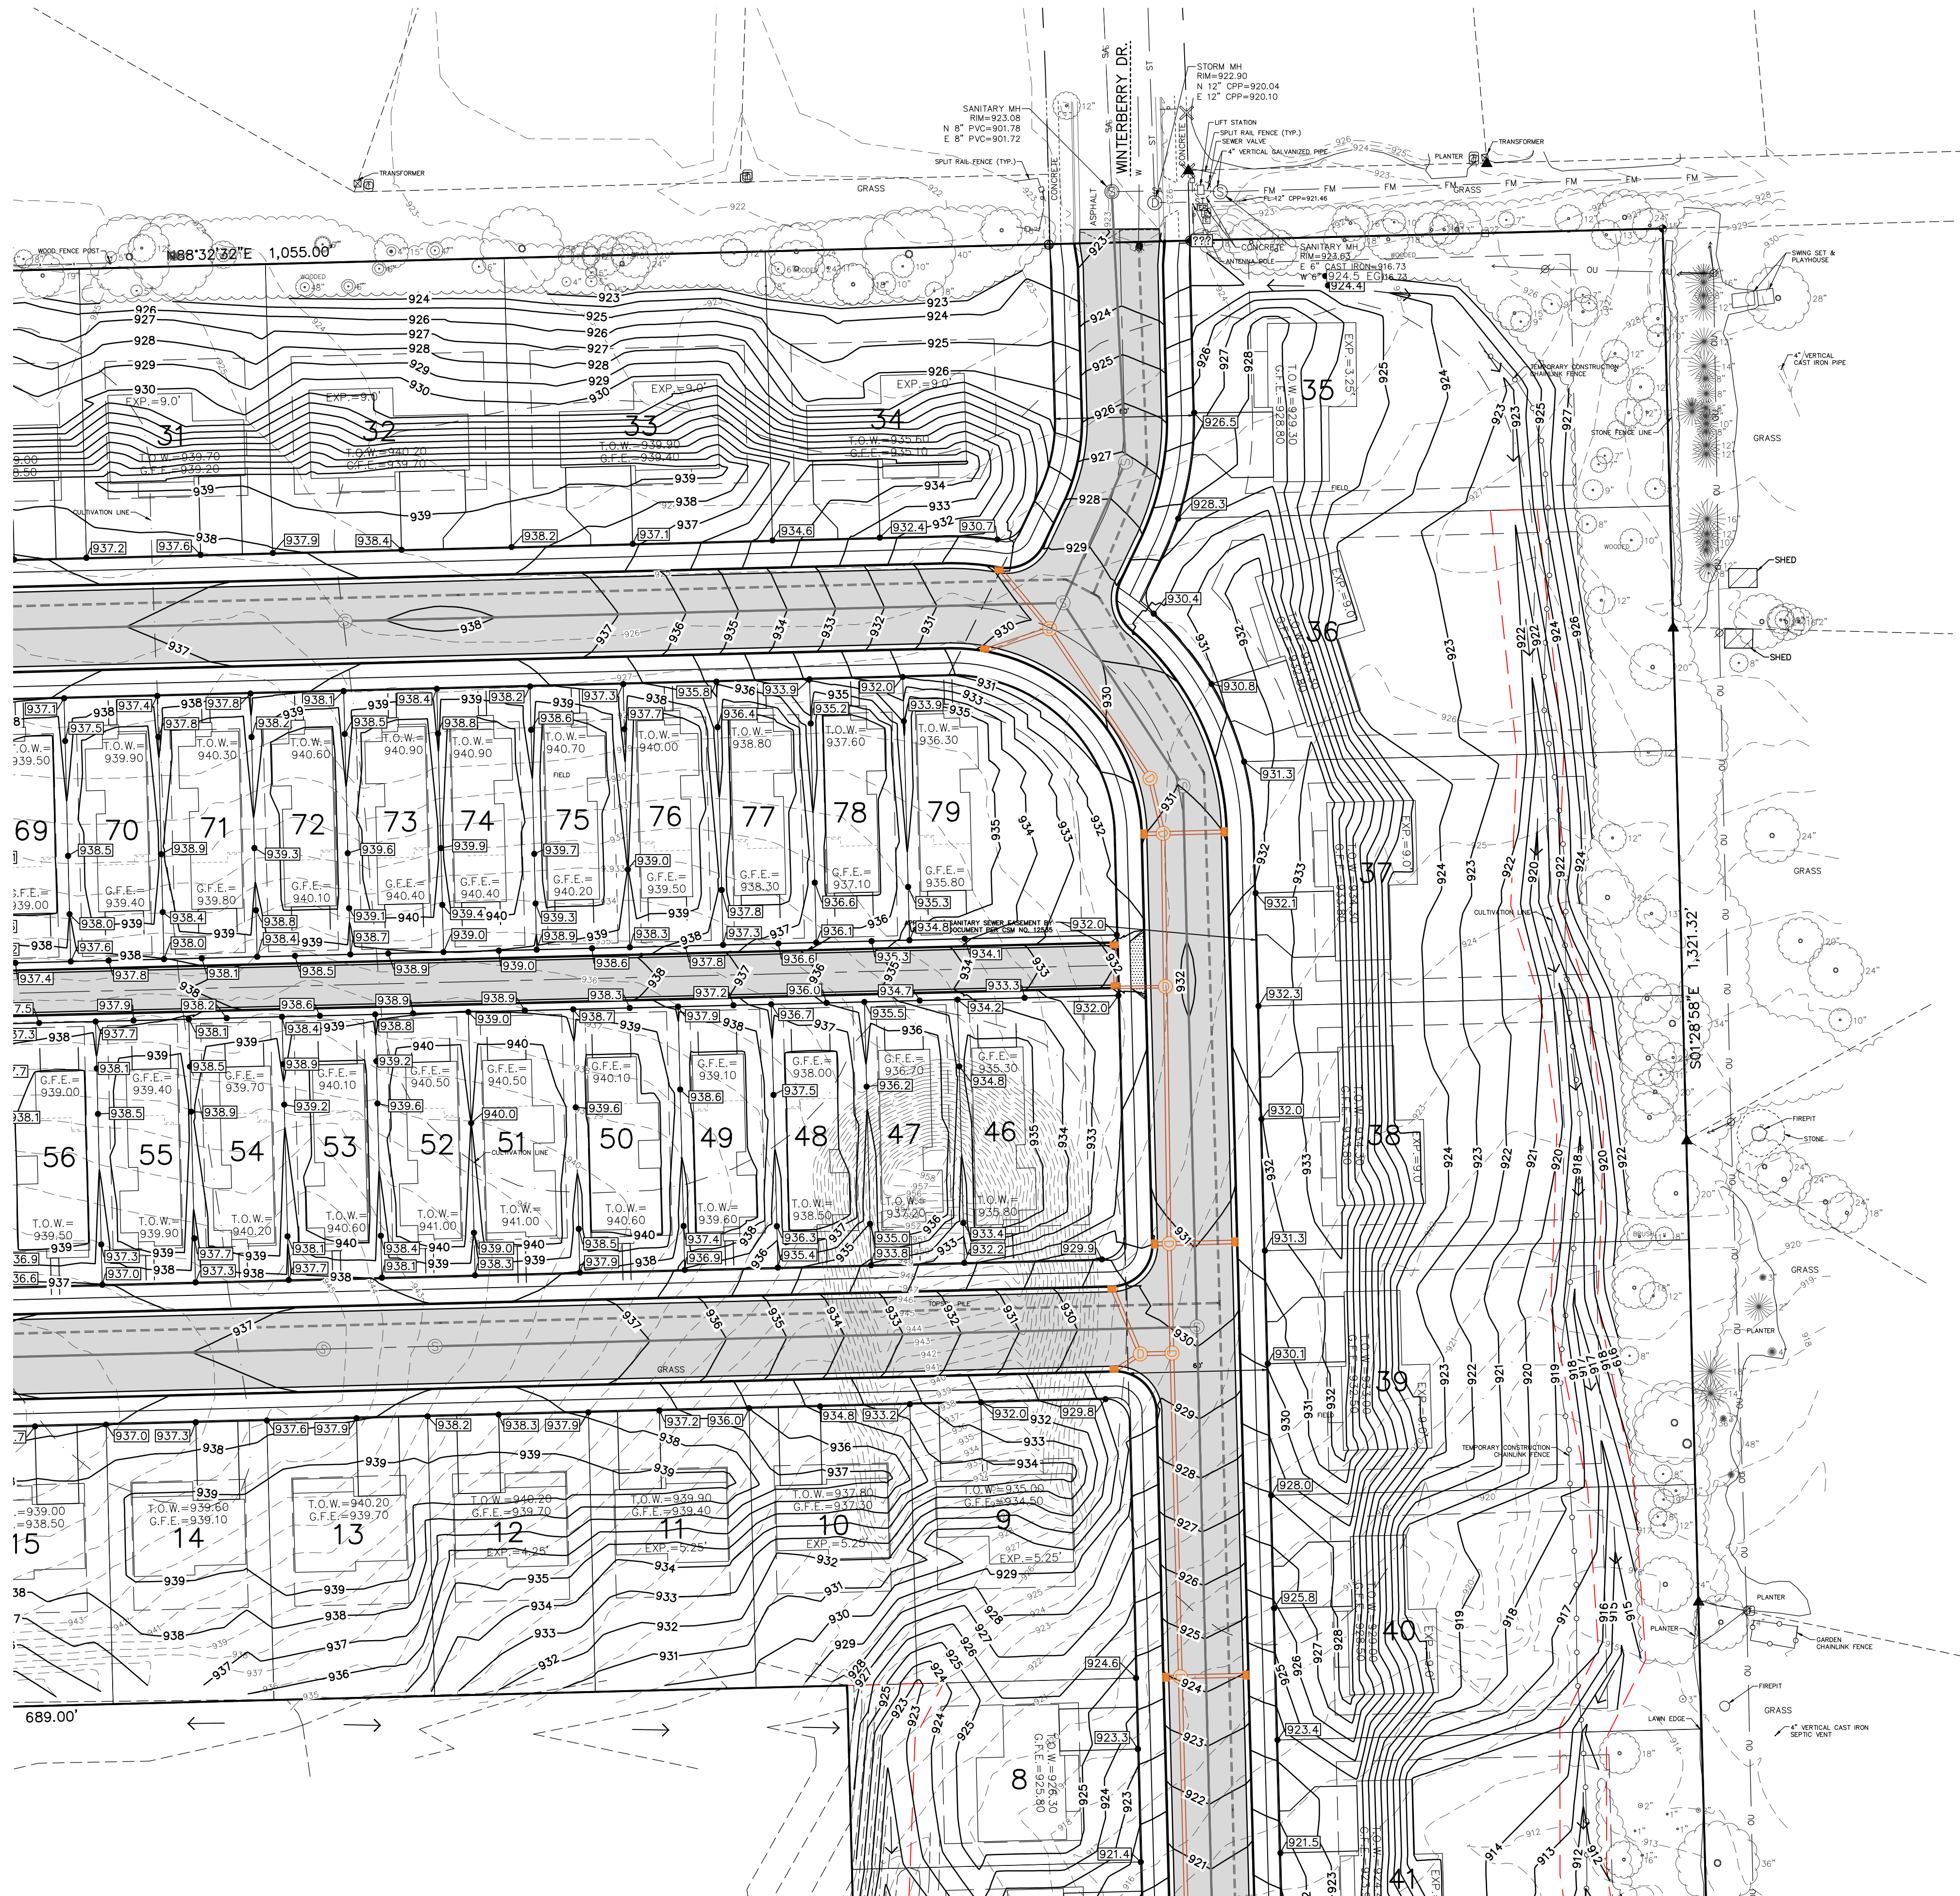

NORTHEAST MASTER GRADING AND EROSION CONTROL PLAN

**EXCEL**  
 ARCHITECTS • ENGINEERS • SURVEYORS  
 Always a Better Plan  
 100 Camelot Drive  
 Fond Du Lac, WI 54935  
 Phone: (920) 926-9800  
 www.EXCELENGINEER.com

COLLABORATION  
  
**VERIDIAN HOMES**

**PROJECT INFORMATION**

PROPOSED RESIDENTIAL SUBDIVISION  
**WINTERBERRY RESERVE**  
 WINTERBERRY DRIVE • WAUKESHA, WI 53188


PROFESSIONAL SEAL

**PRELIMINARY DATES**  
 JAN. 27, 2025

**NOT FOR CONSTRUCTION**

**JOB NUMBER**  
 230103400

**SHEET NUMBER**  
**C4.2**

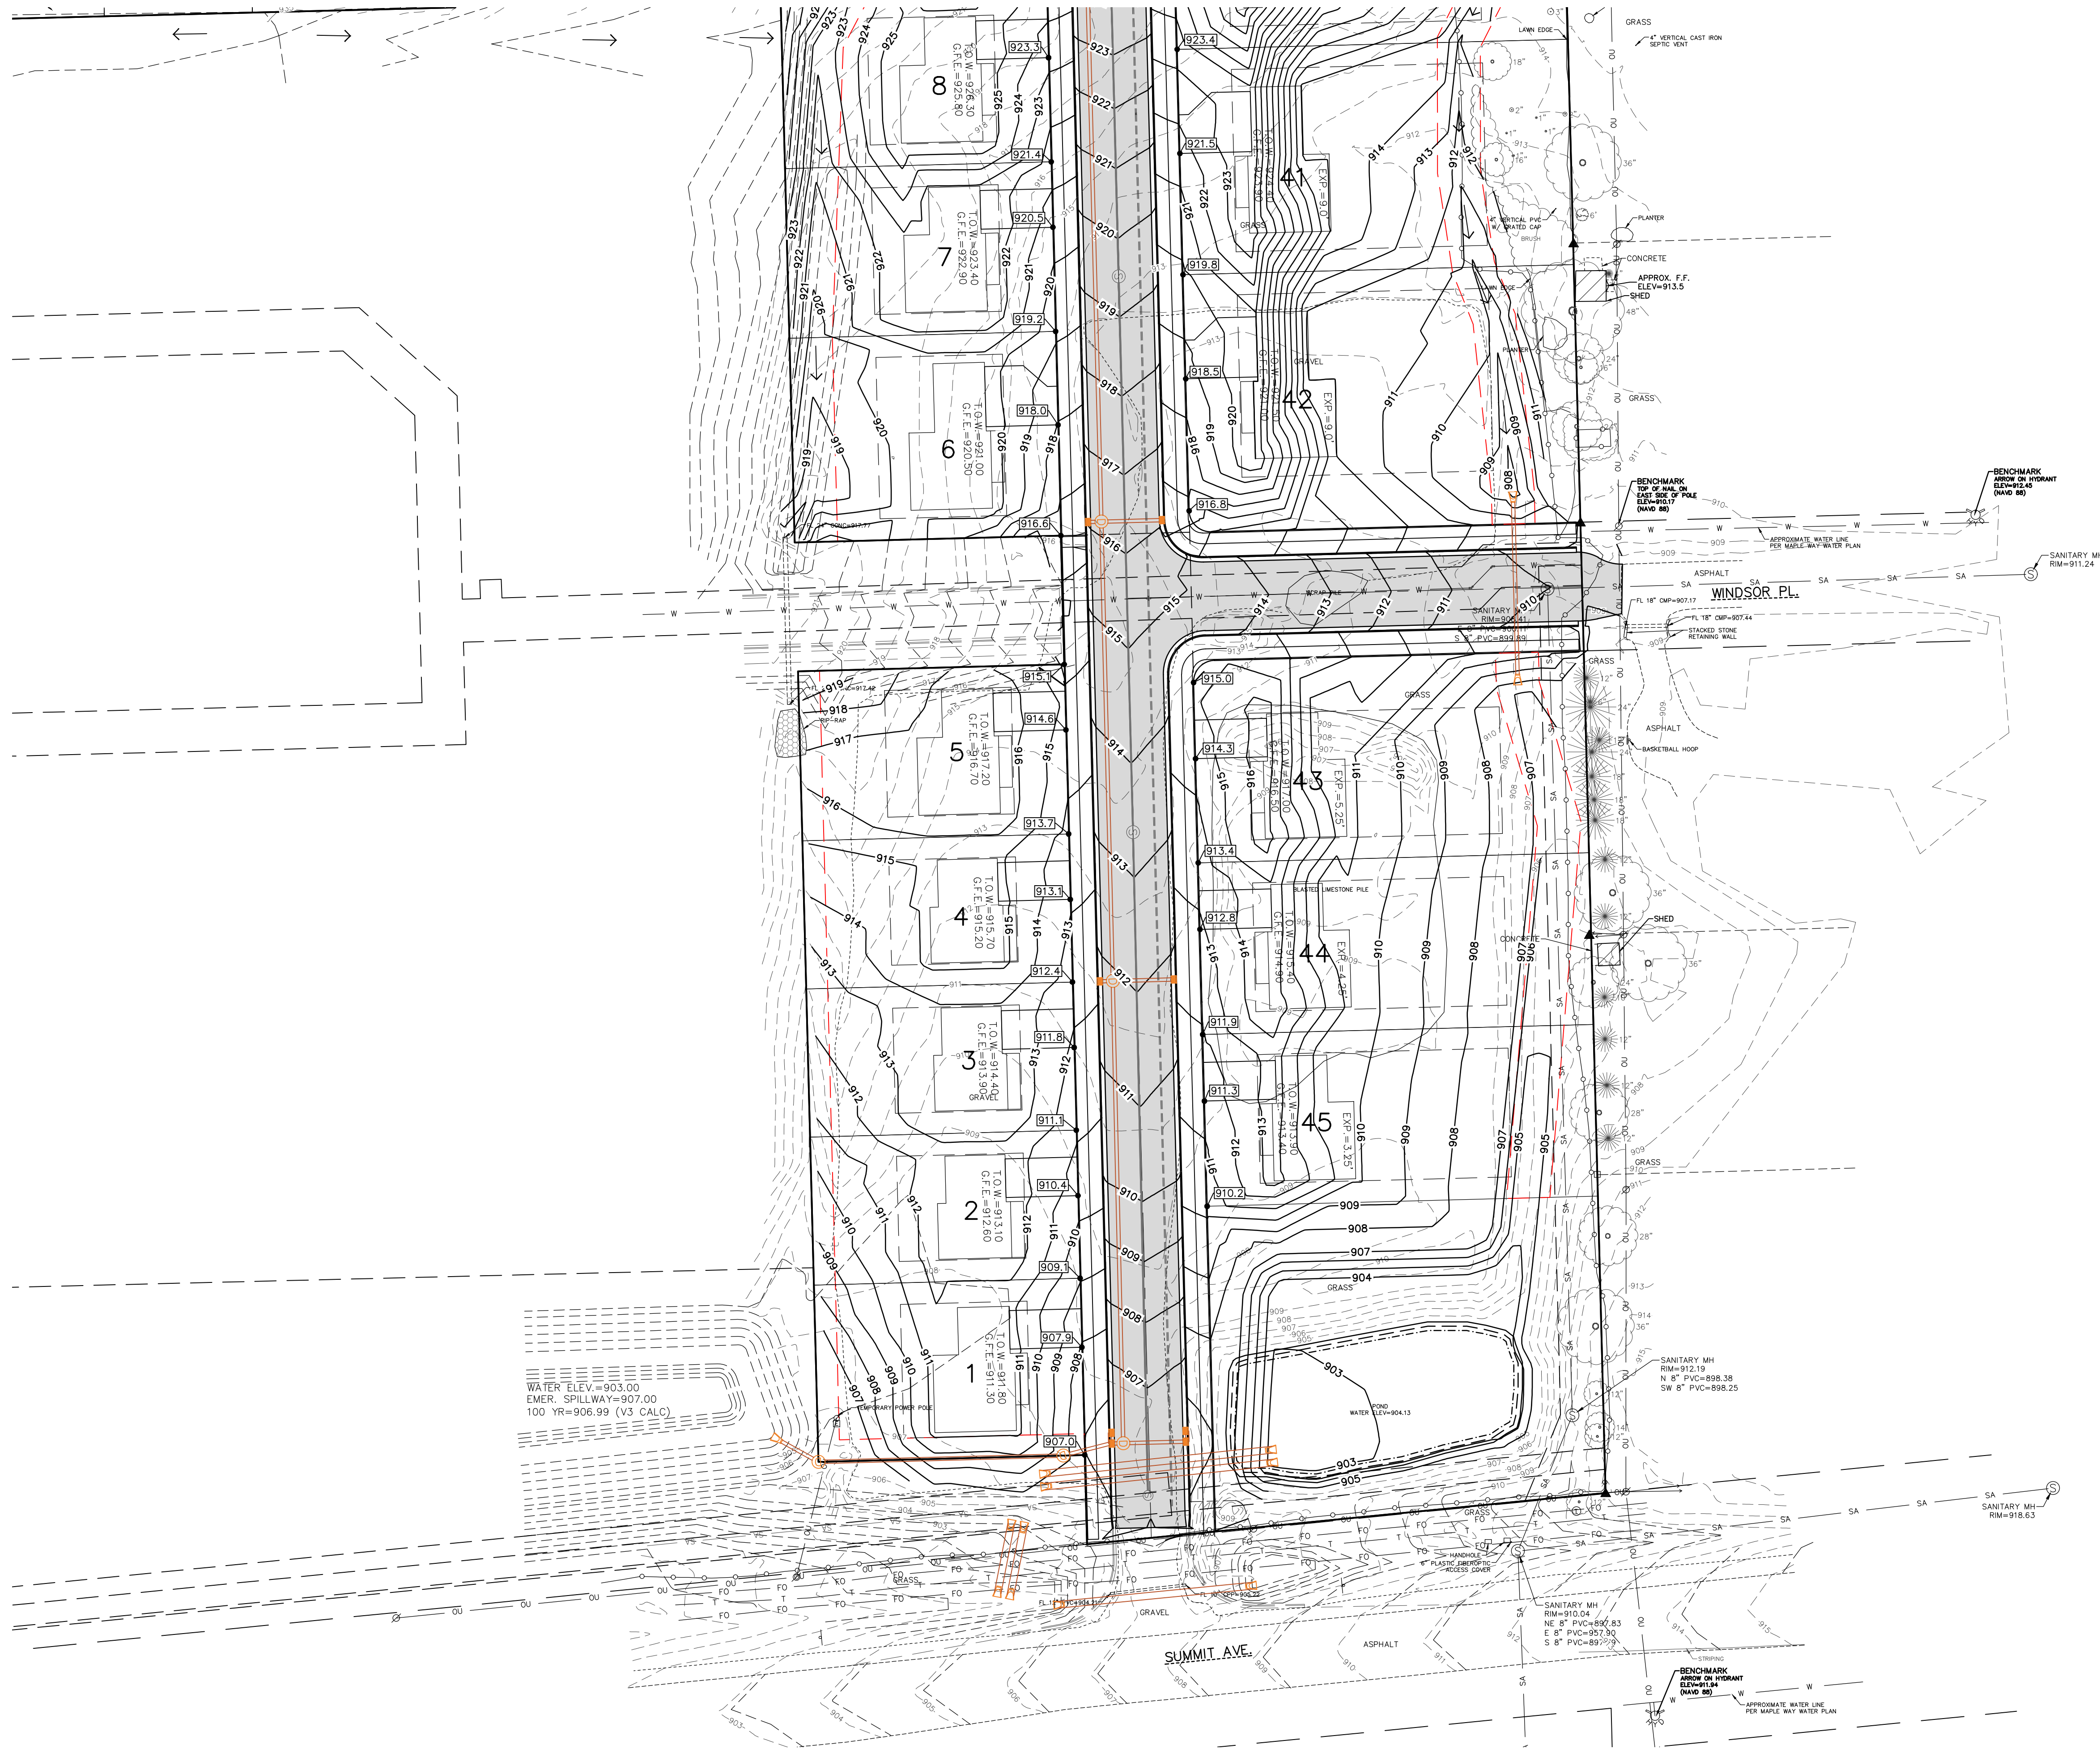

**PROJECT INFORMATION**

PROPOSED RESIDENTIAL SUBDIVISION  
**WINTERBERRY RESERVE**  
 WINTERBERRY DRIVE • WAUKESHA, WI 53188

PROFESSIONAL SEAL


**PRELIMINARY DATES**



JAN. 27, 2025

NOT FOR CONSTRUCTION

**JOB NUMBER**  
 230103400

**SHEET NUMBER**  
**C4.3**

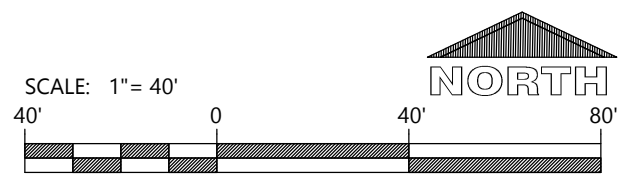

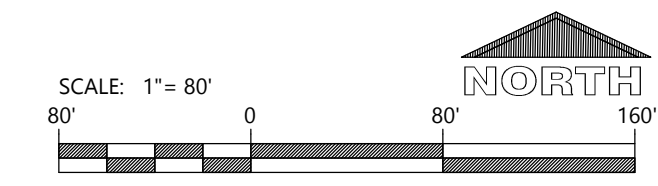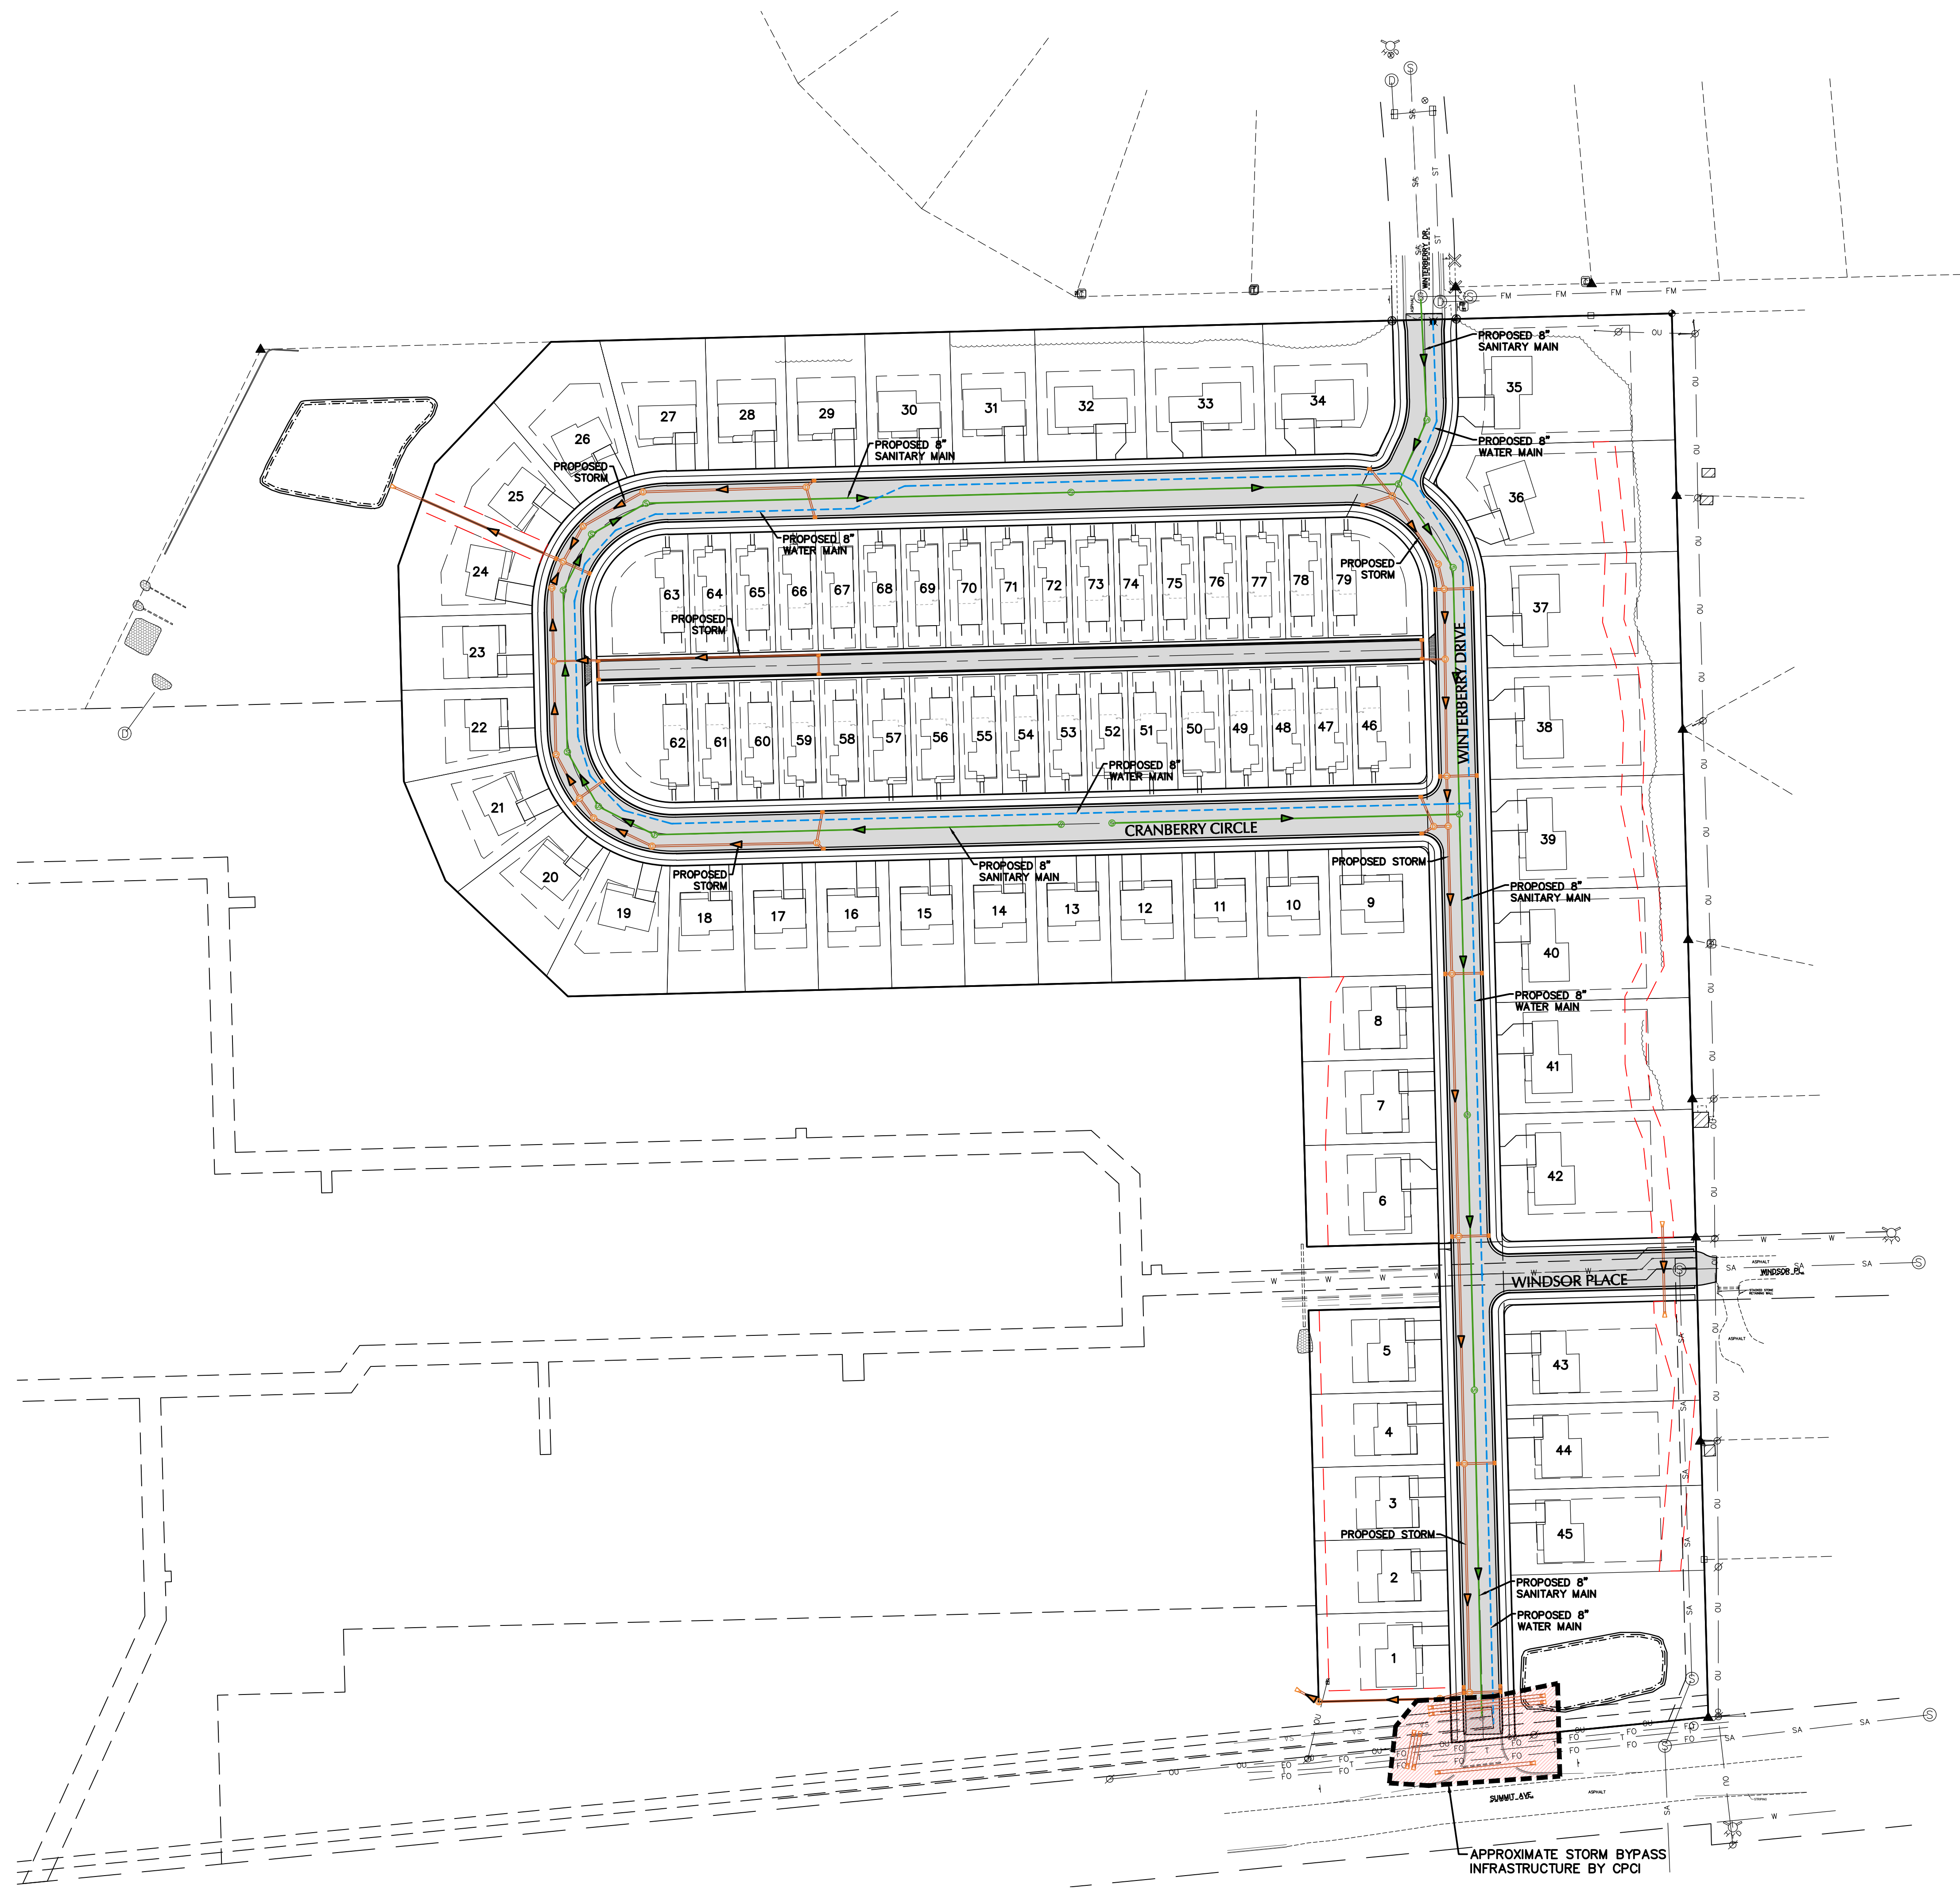

SYSTEM PLAN

**EXCEL**  
ARCHITECTS • ENGINEERS • SURVEYORS  
Always a Better Plan  
100 Camelot Drive  
Fond Du Lac, WI 54935  
Phone: (920) 926-9800  
www.EXCELENGINEER.com

COLLABORATION

**VERIDIAN HOMES**

PROJECT INFORMATION

PROPOSED RESIDENTIAL SUBDIVISION  
**WINTERBERRY RESERVE**  
WINTERBERRY DRIVE • WAUKESHA, WI 53188

PROFESSIONAL SEAL

PRELIMINARY DATES  
JAN. 27, 2025




NOT FOR CONSTRUCTION

JOB NUMBER  
230103400

SHEET NUMBER  
**C5.0**





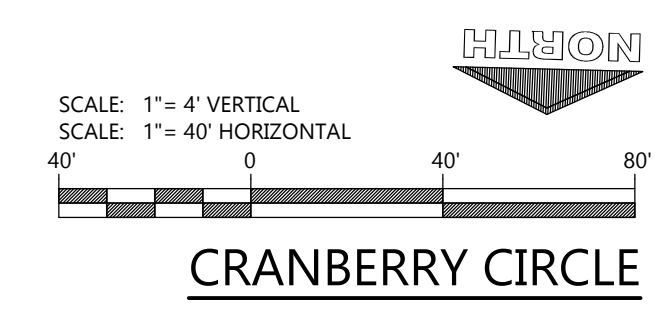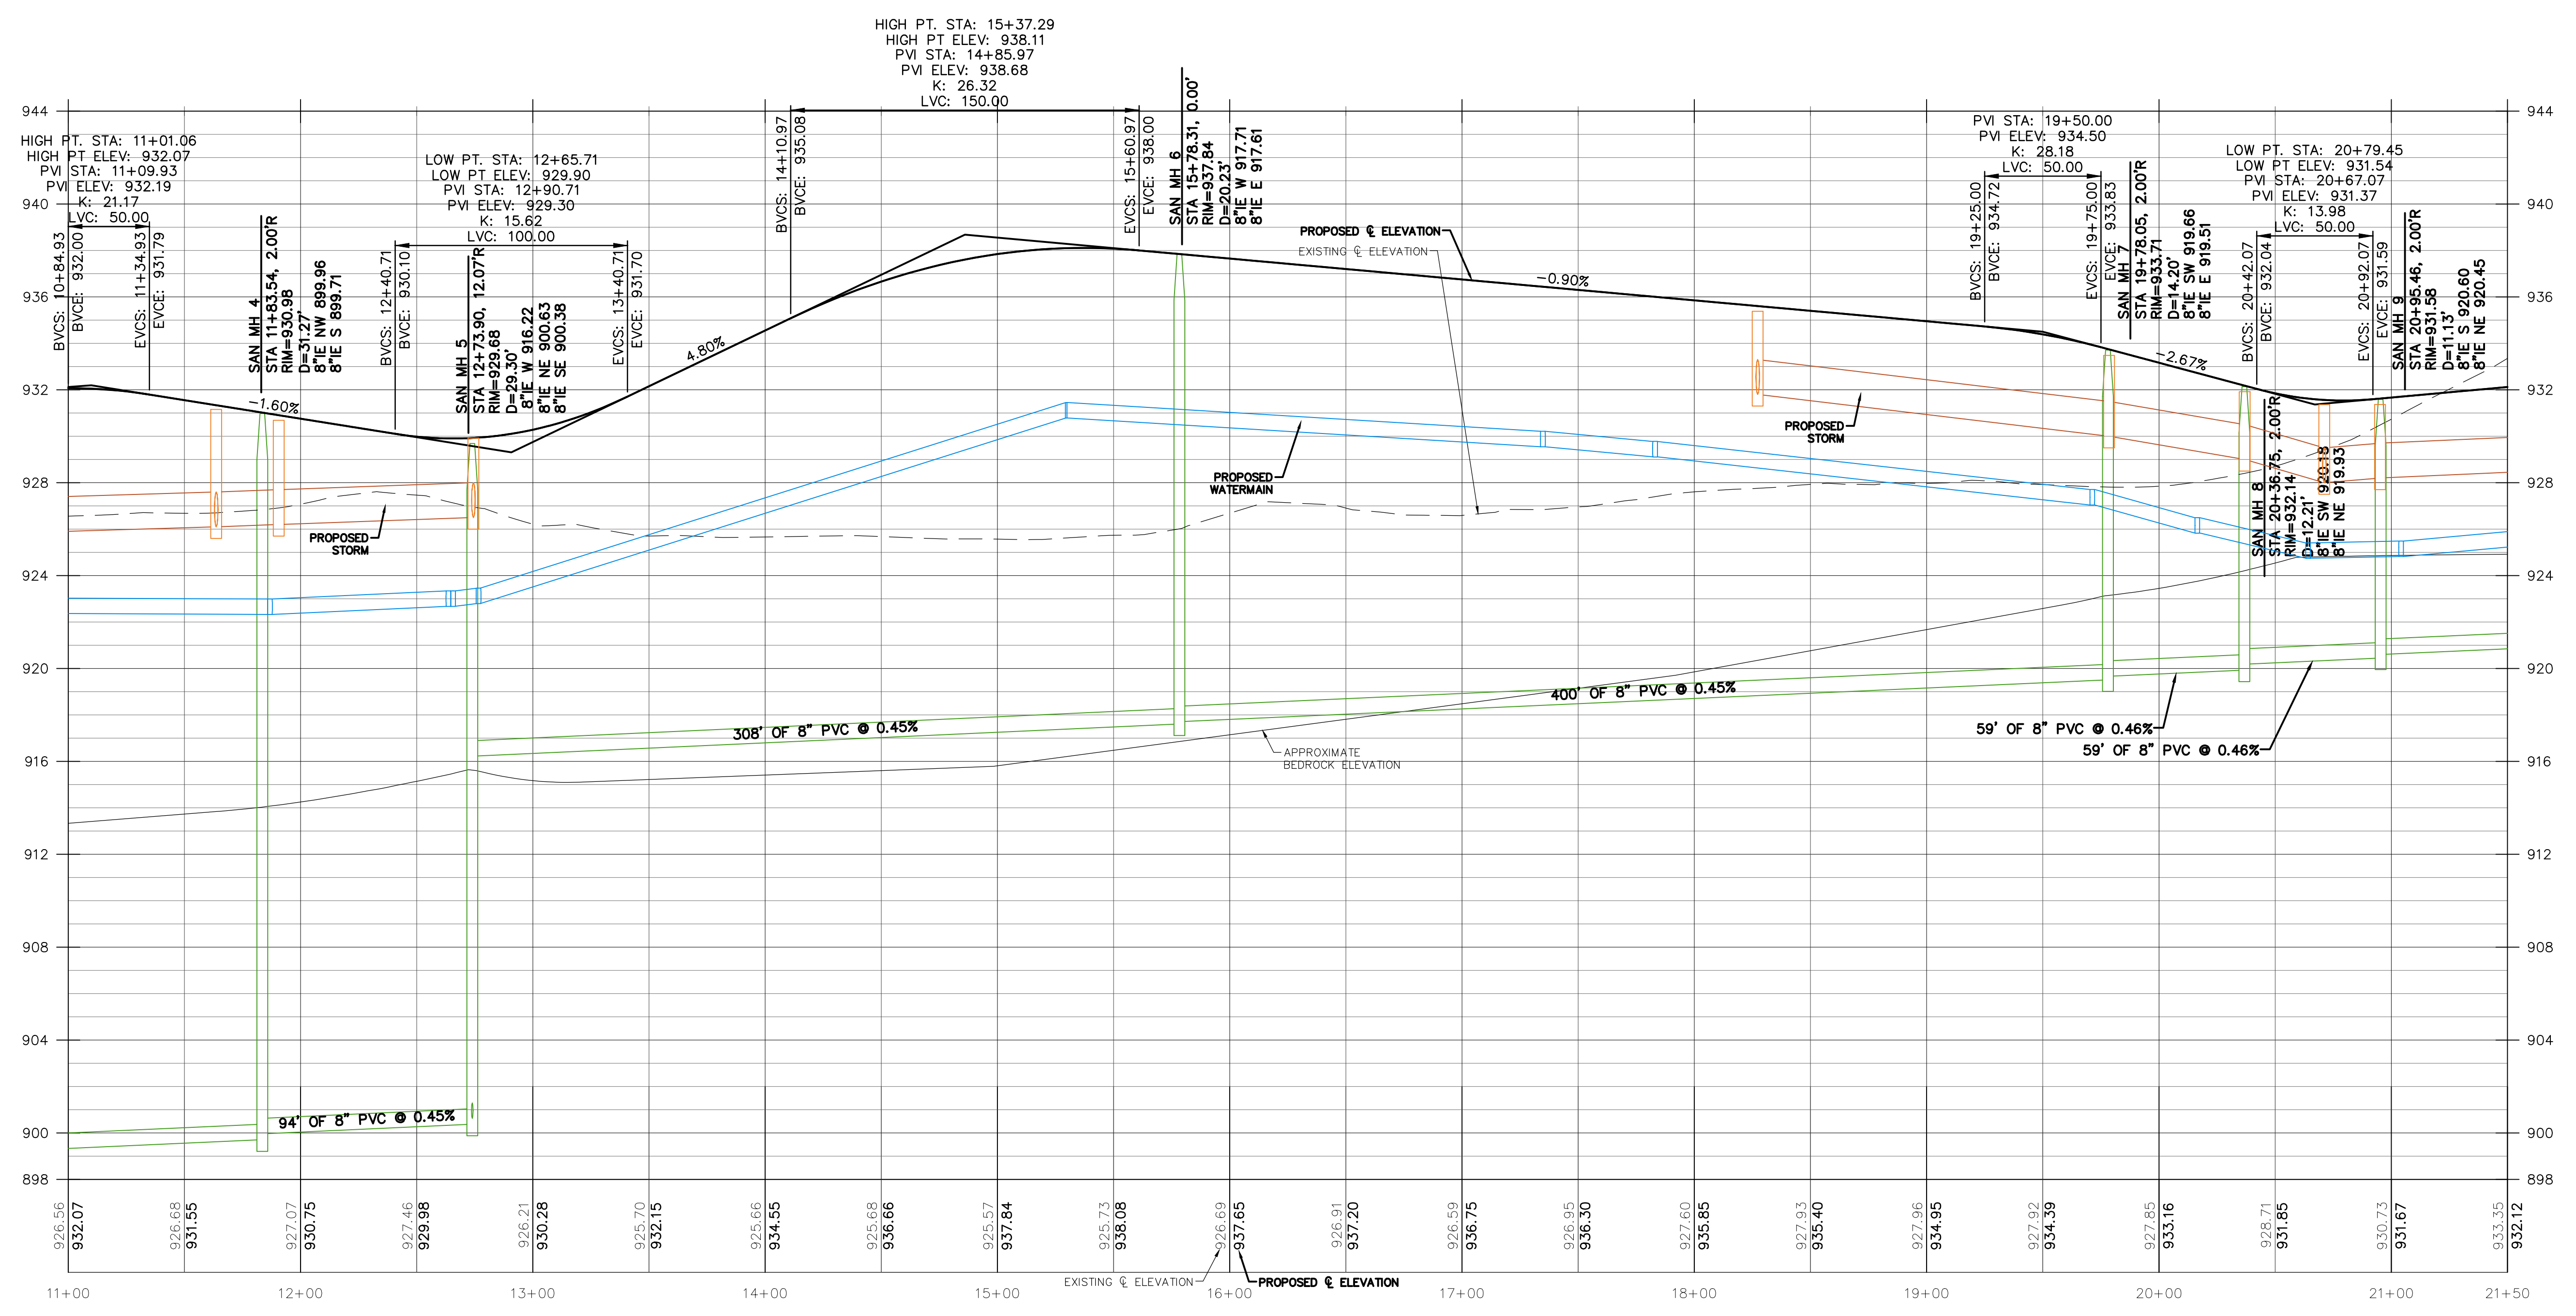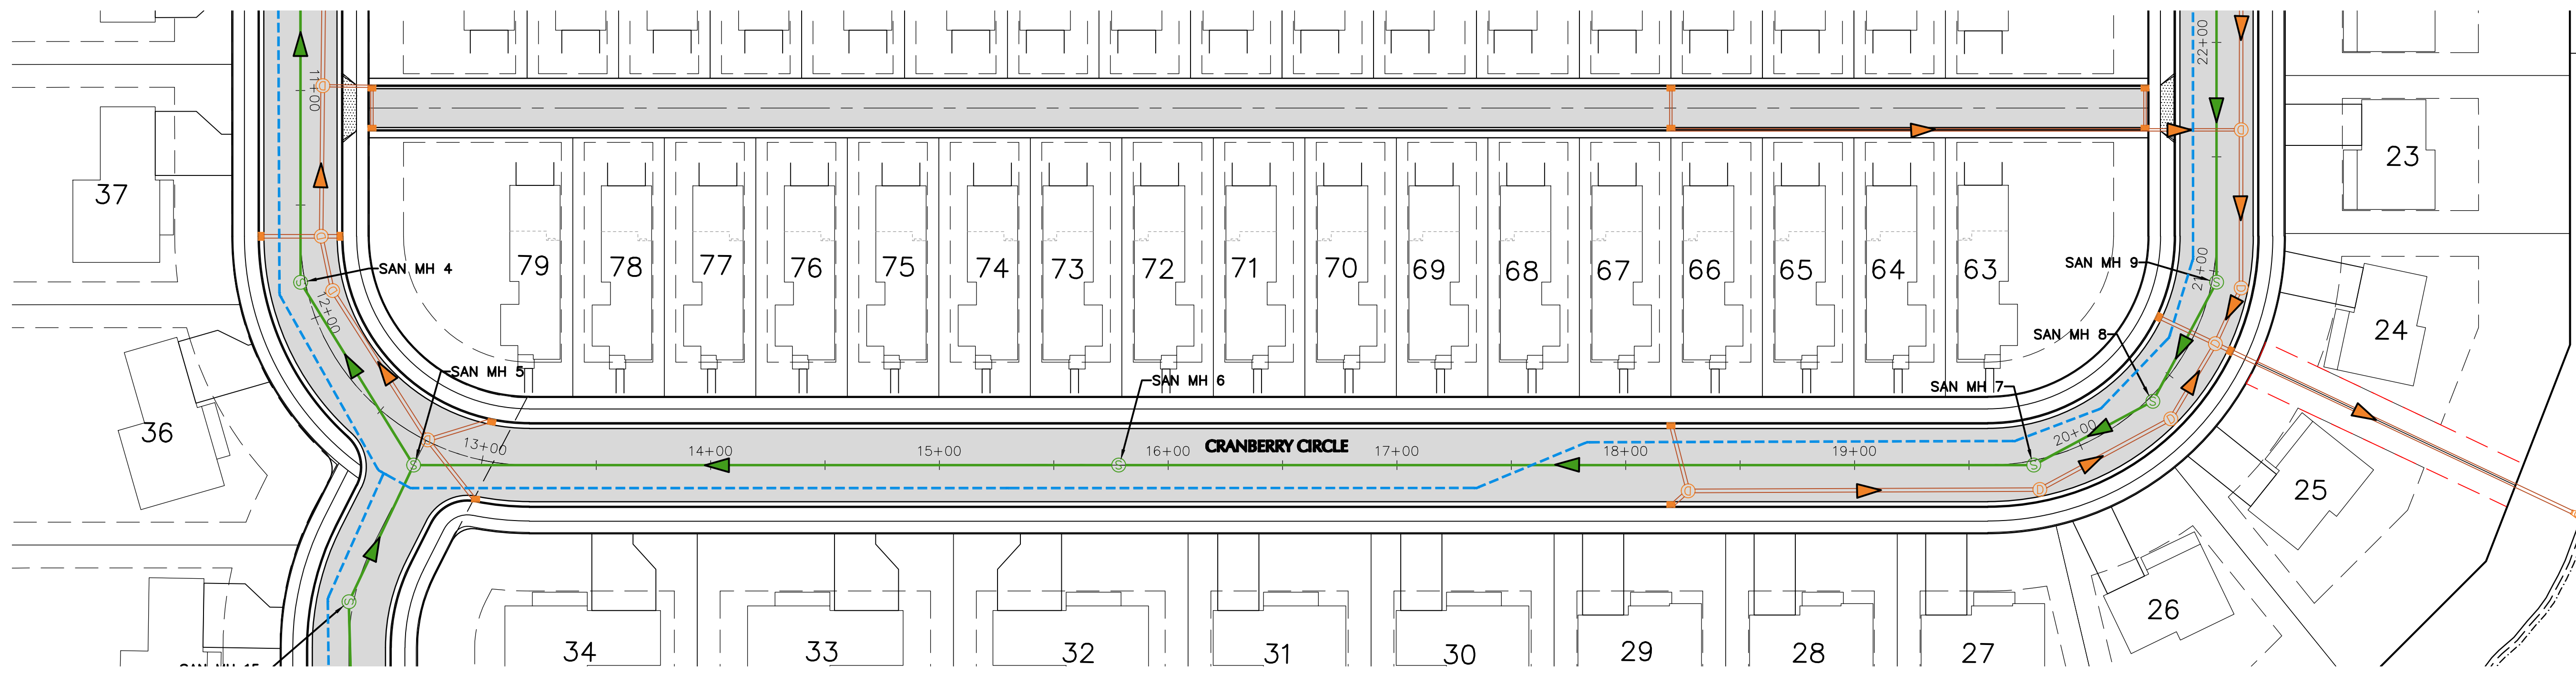

**EXCEL**  
 ARCHITECTS • ENGINEERS • SURVEYORS  
 Always a Better Plan  
 100 Camelot Drive  
 Fond Du Lac, WI 54935  
 Phone: (920) 926-9808  
 www.EXCELENGINEER.com

COLLABORATION  
**VERIDIAN HOMES**

PROJECT INFORMATION

PROPOSED RESIDENTIAL SUBDIVISION  
**WINTERBERRY RESERVE**  
 WINTERBERRY DRIVE • WAUKESHA, WI 53188

PROFESSIONAL SEAL

PRELIMINARY DATES  
 JAN. 27, 2025

**NOT FOR CONSTRUCTION**

JOB NUMBER  
 230103400

SHEET NUMBER  
**C6.1**

**PROJECT INFORMATION**

PROPOSED RESIDENTIAL SUBDIVISION  
**WINTERBERRY RESERVE**  
 WINTERBERRY DRIVE • WAUKESHA, WI 53188




PROFESSIONAL SEAL

PRELIMINARY DATES  
 JAN. 27, 2025






**NOT FOR CONSTRUCTION**

JOB NUMBER  
 230103400

SHEET NUMBER  
**C6.2**

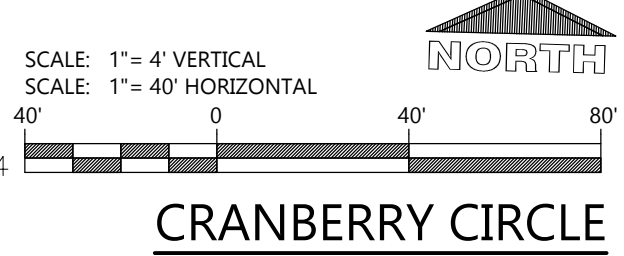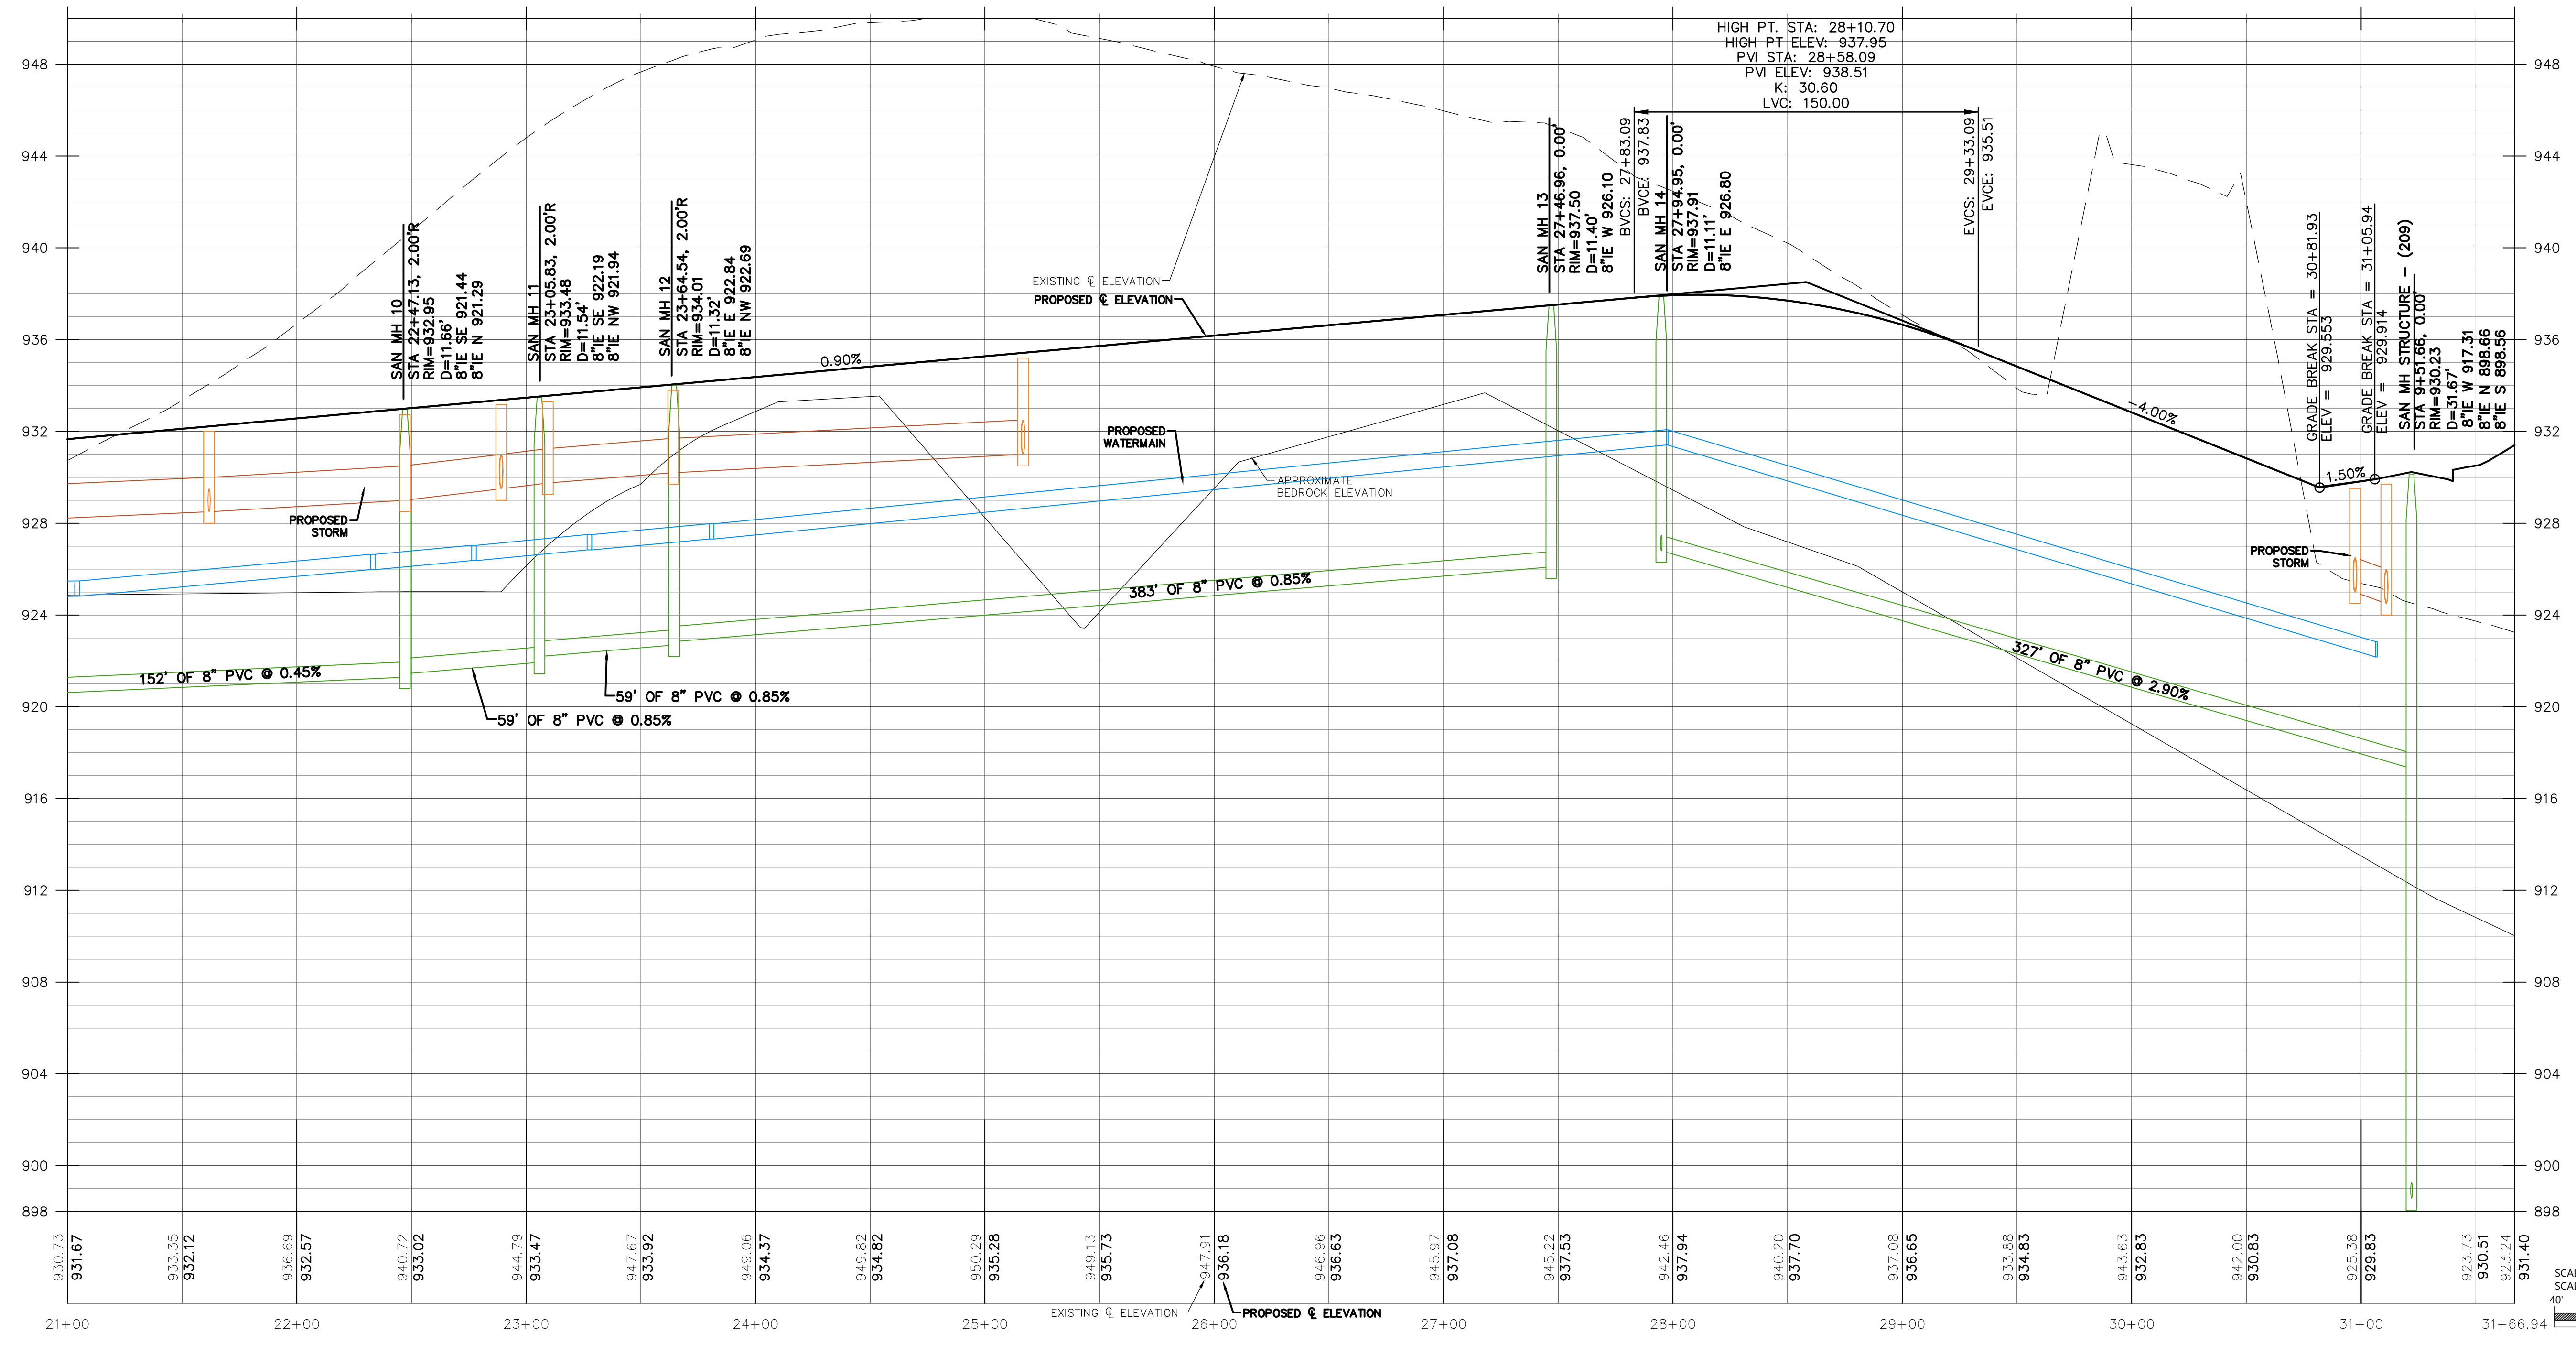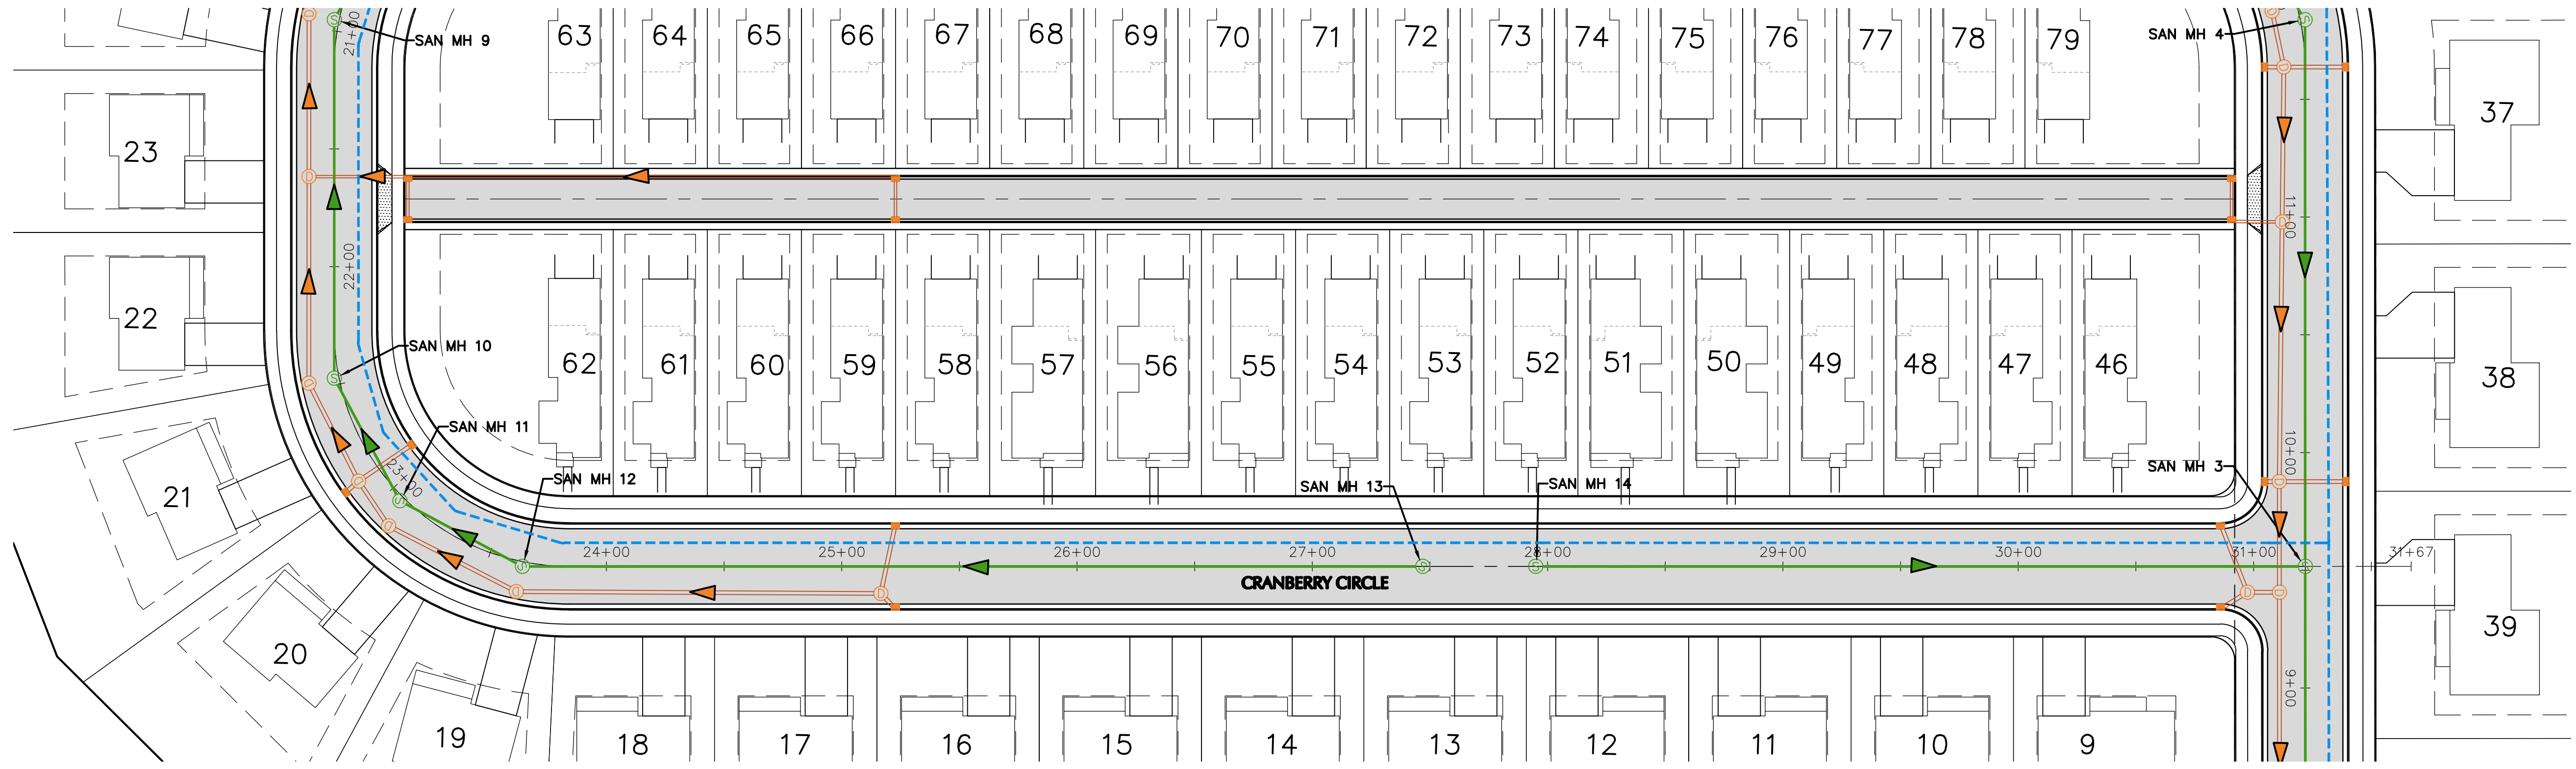

CRANBERRY CIRCLE

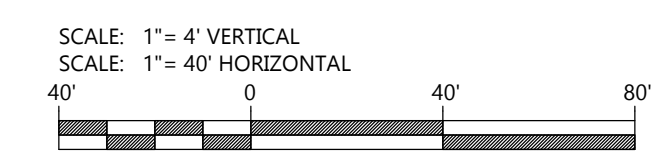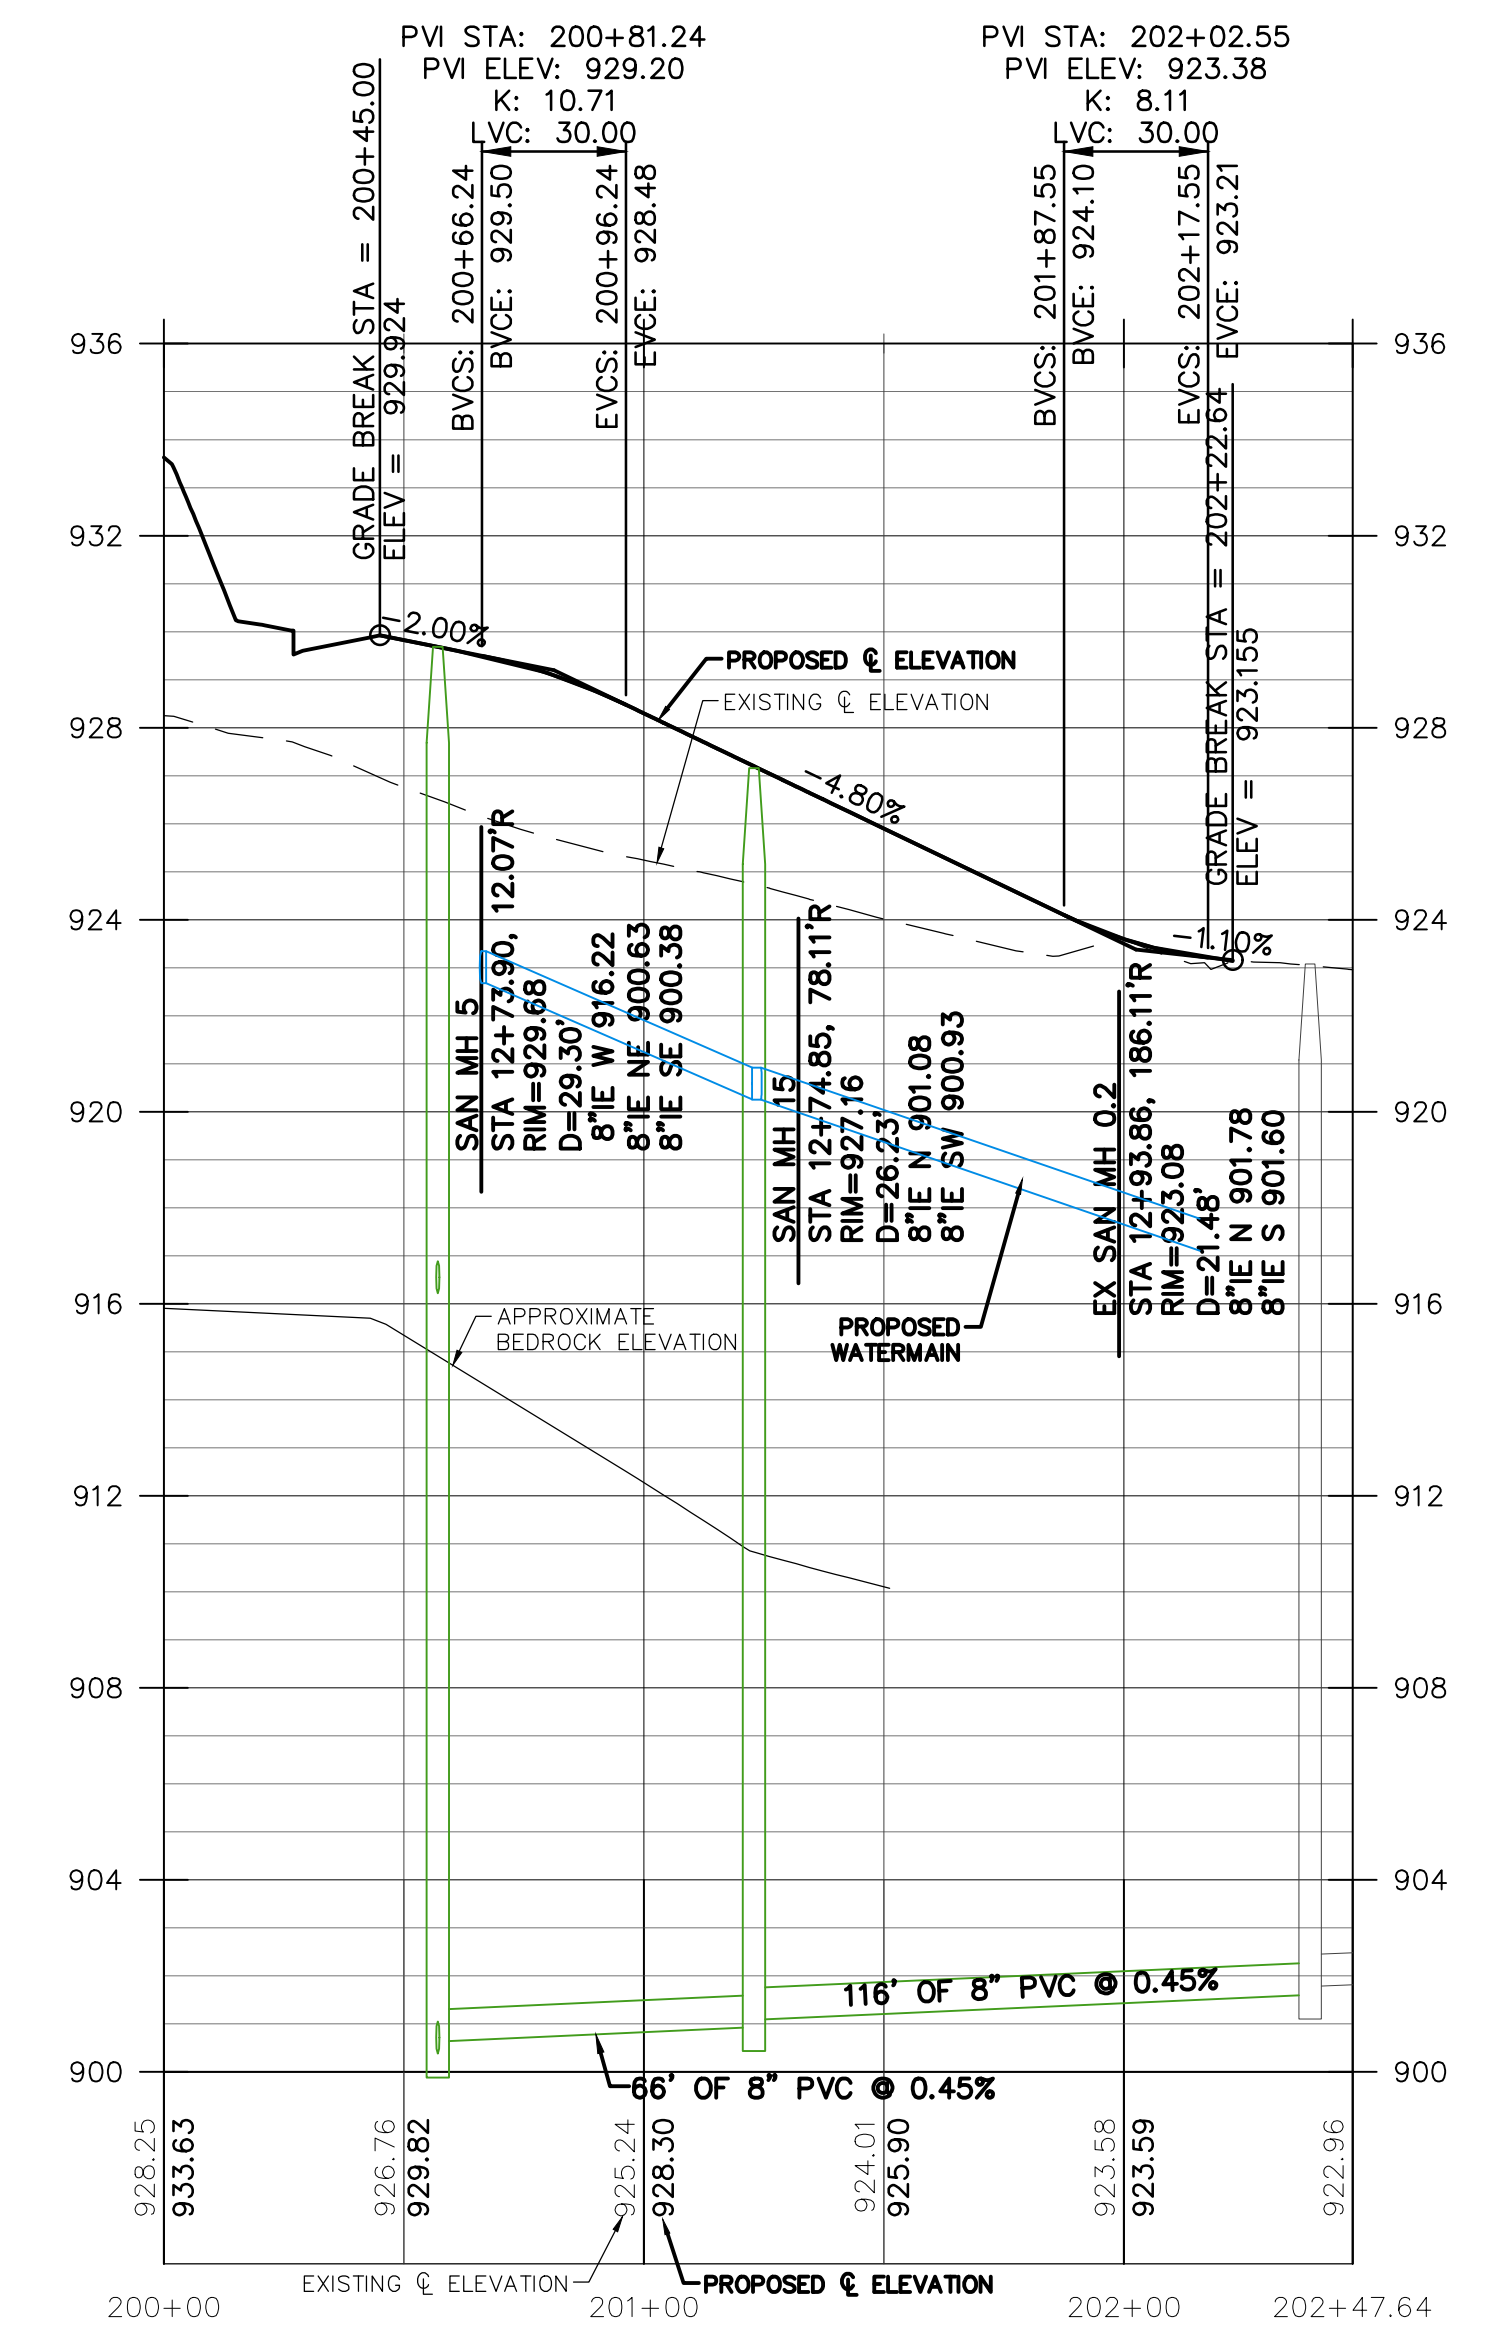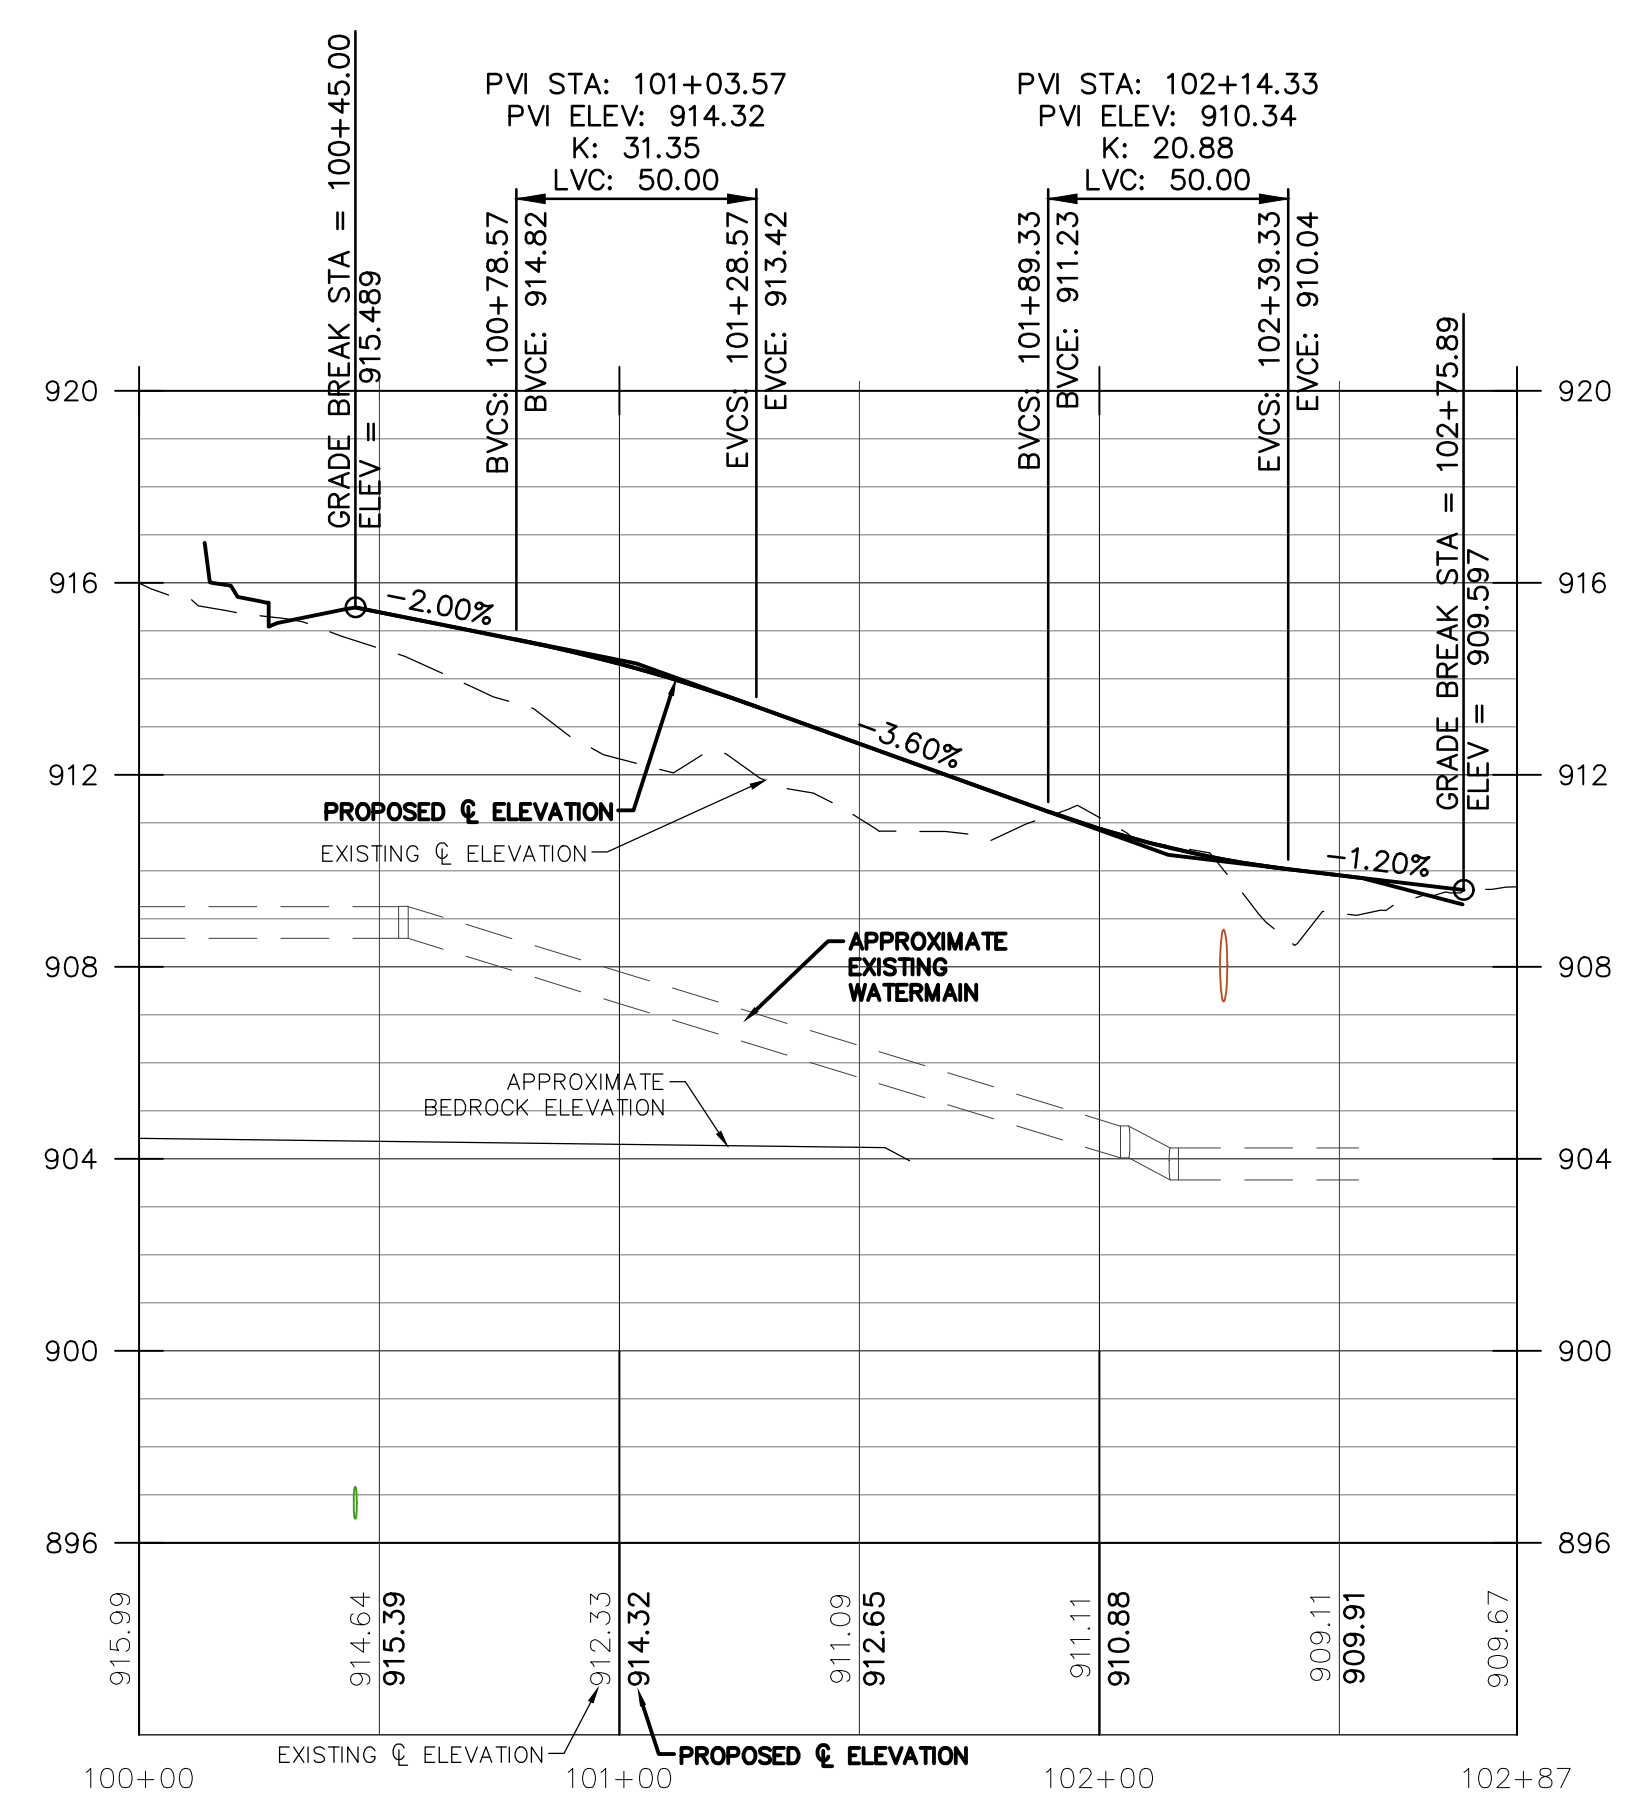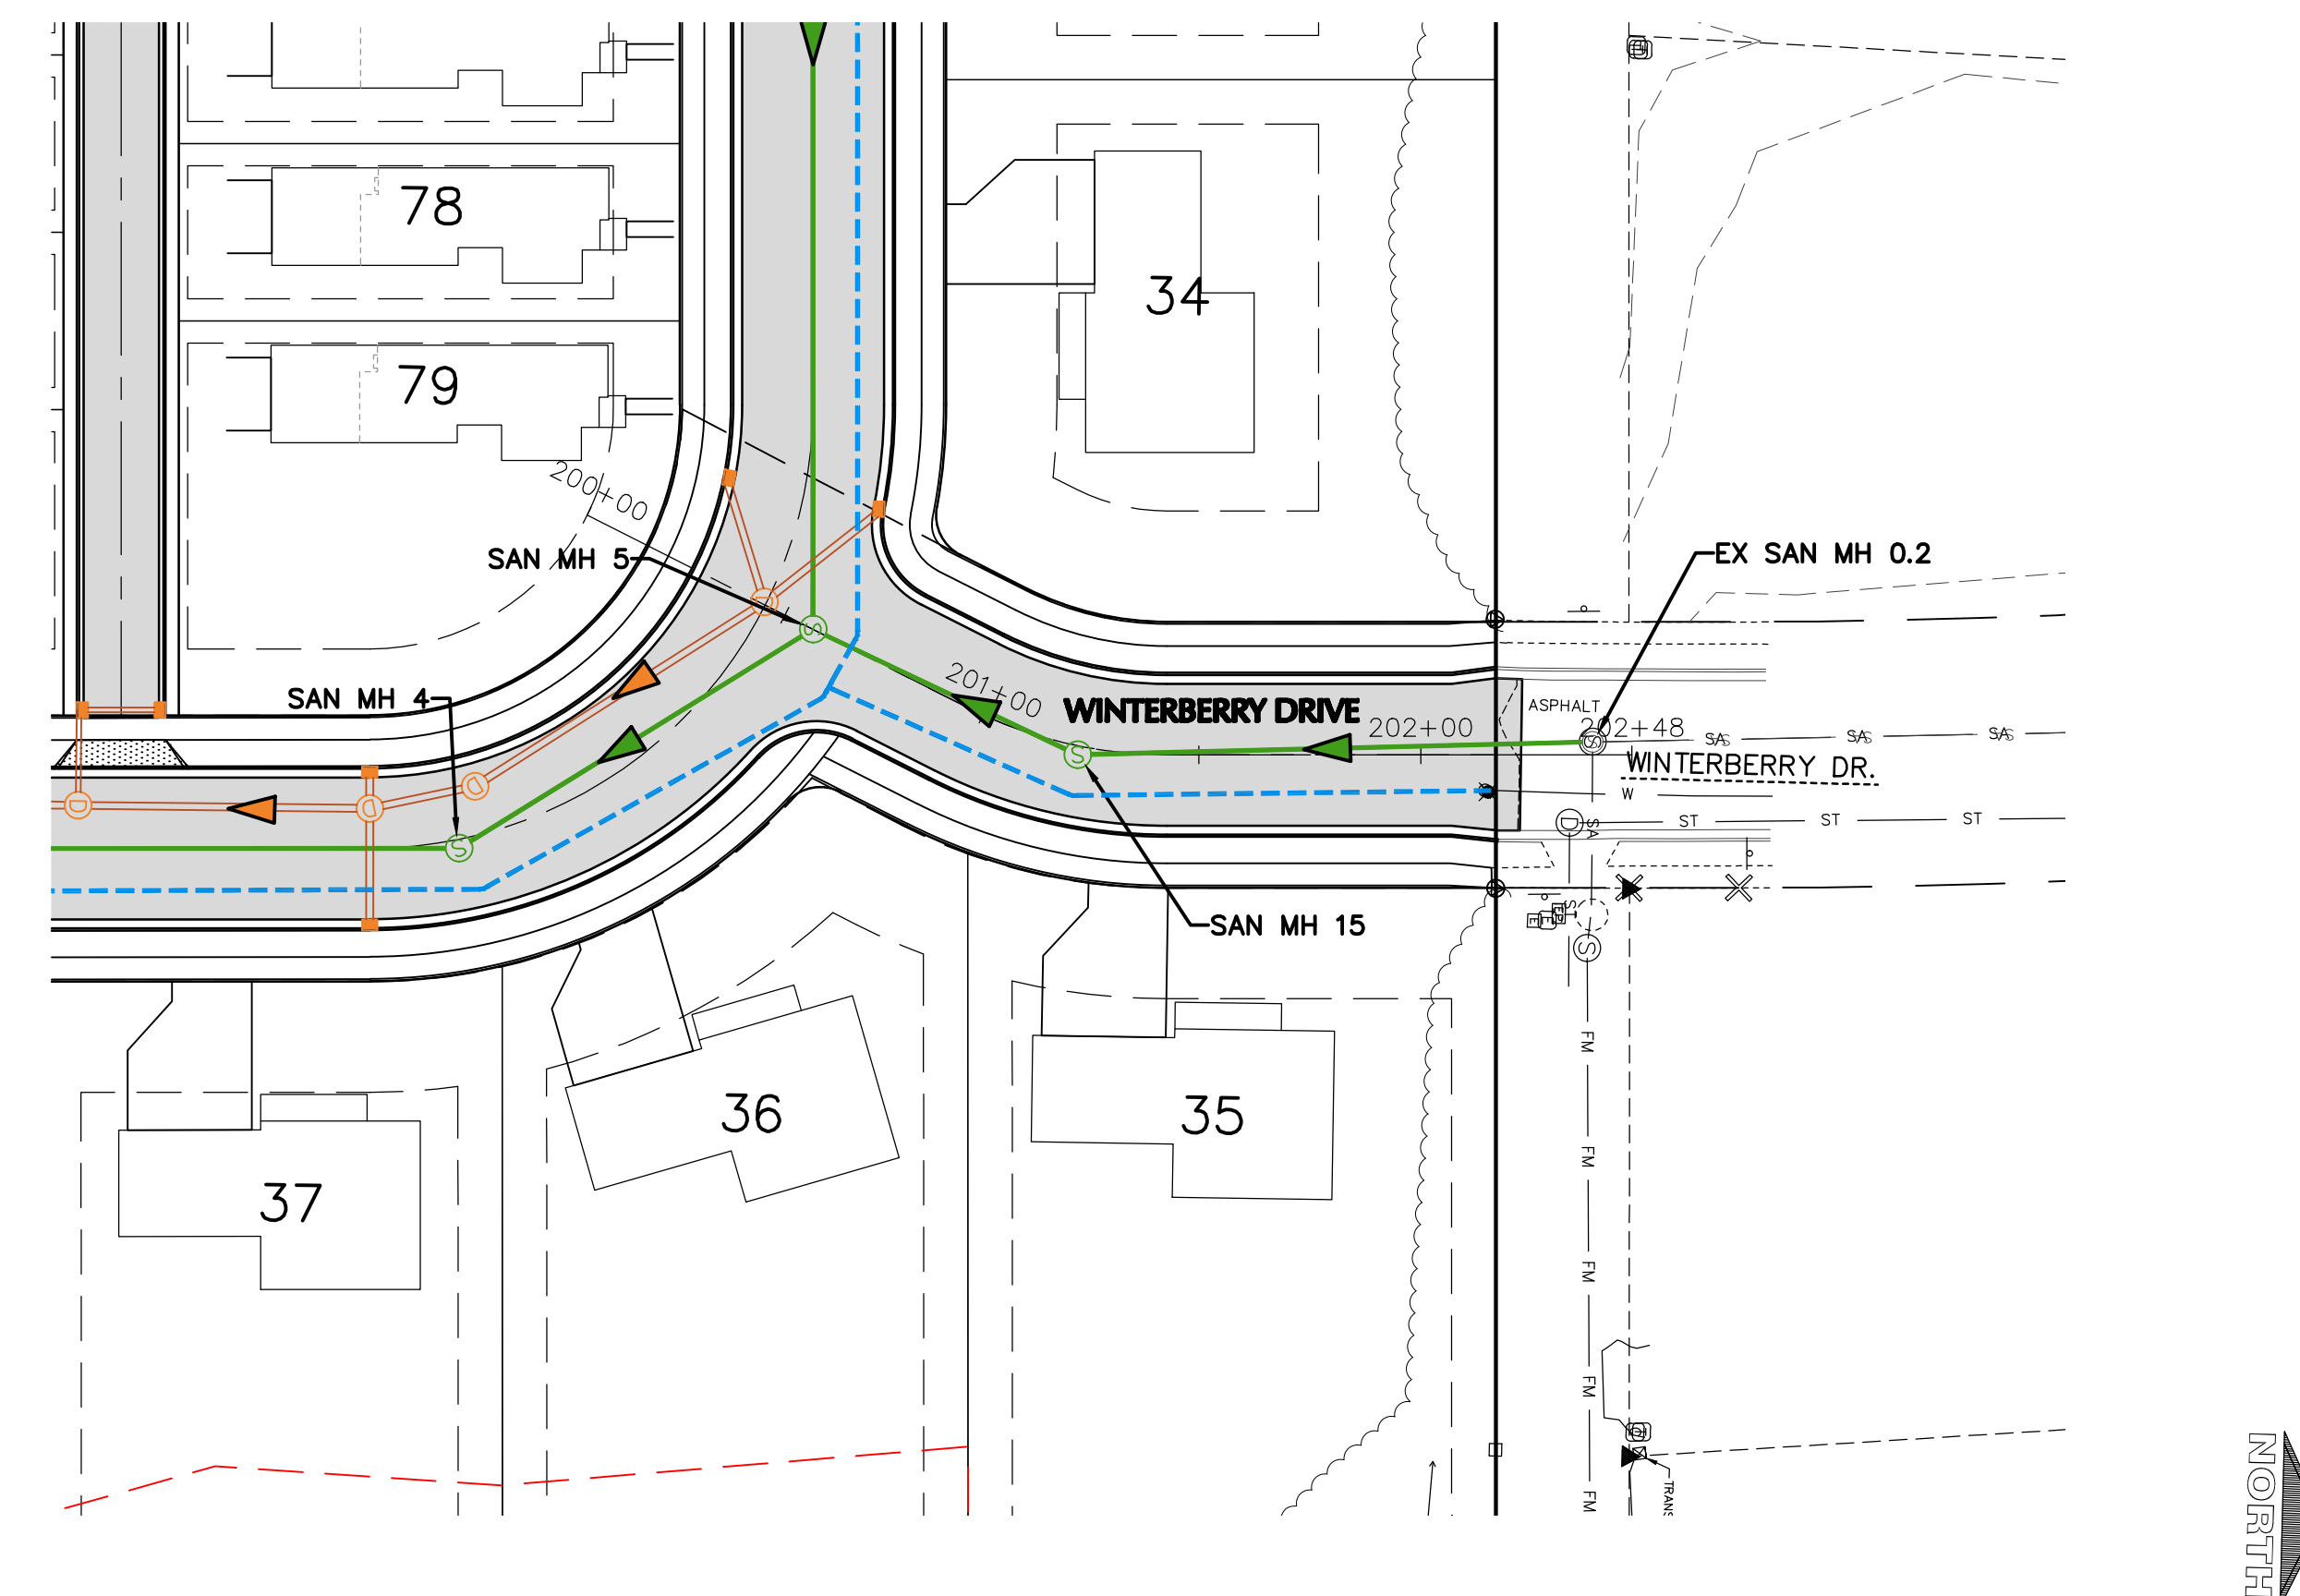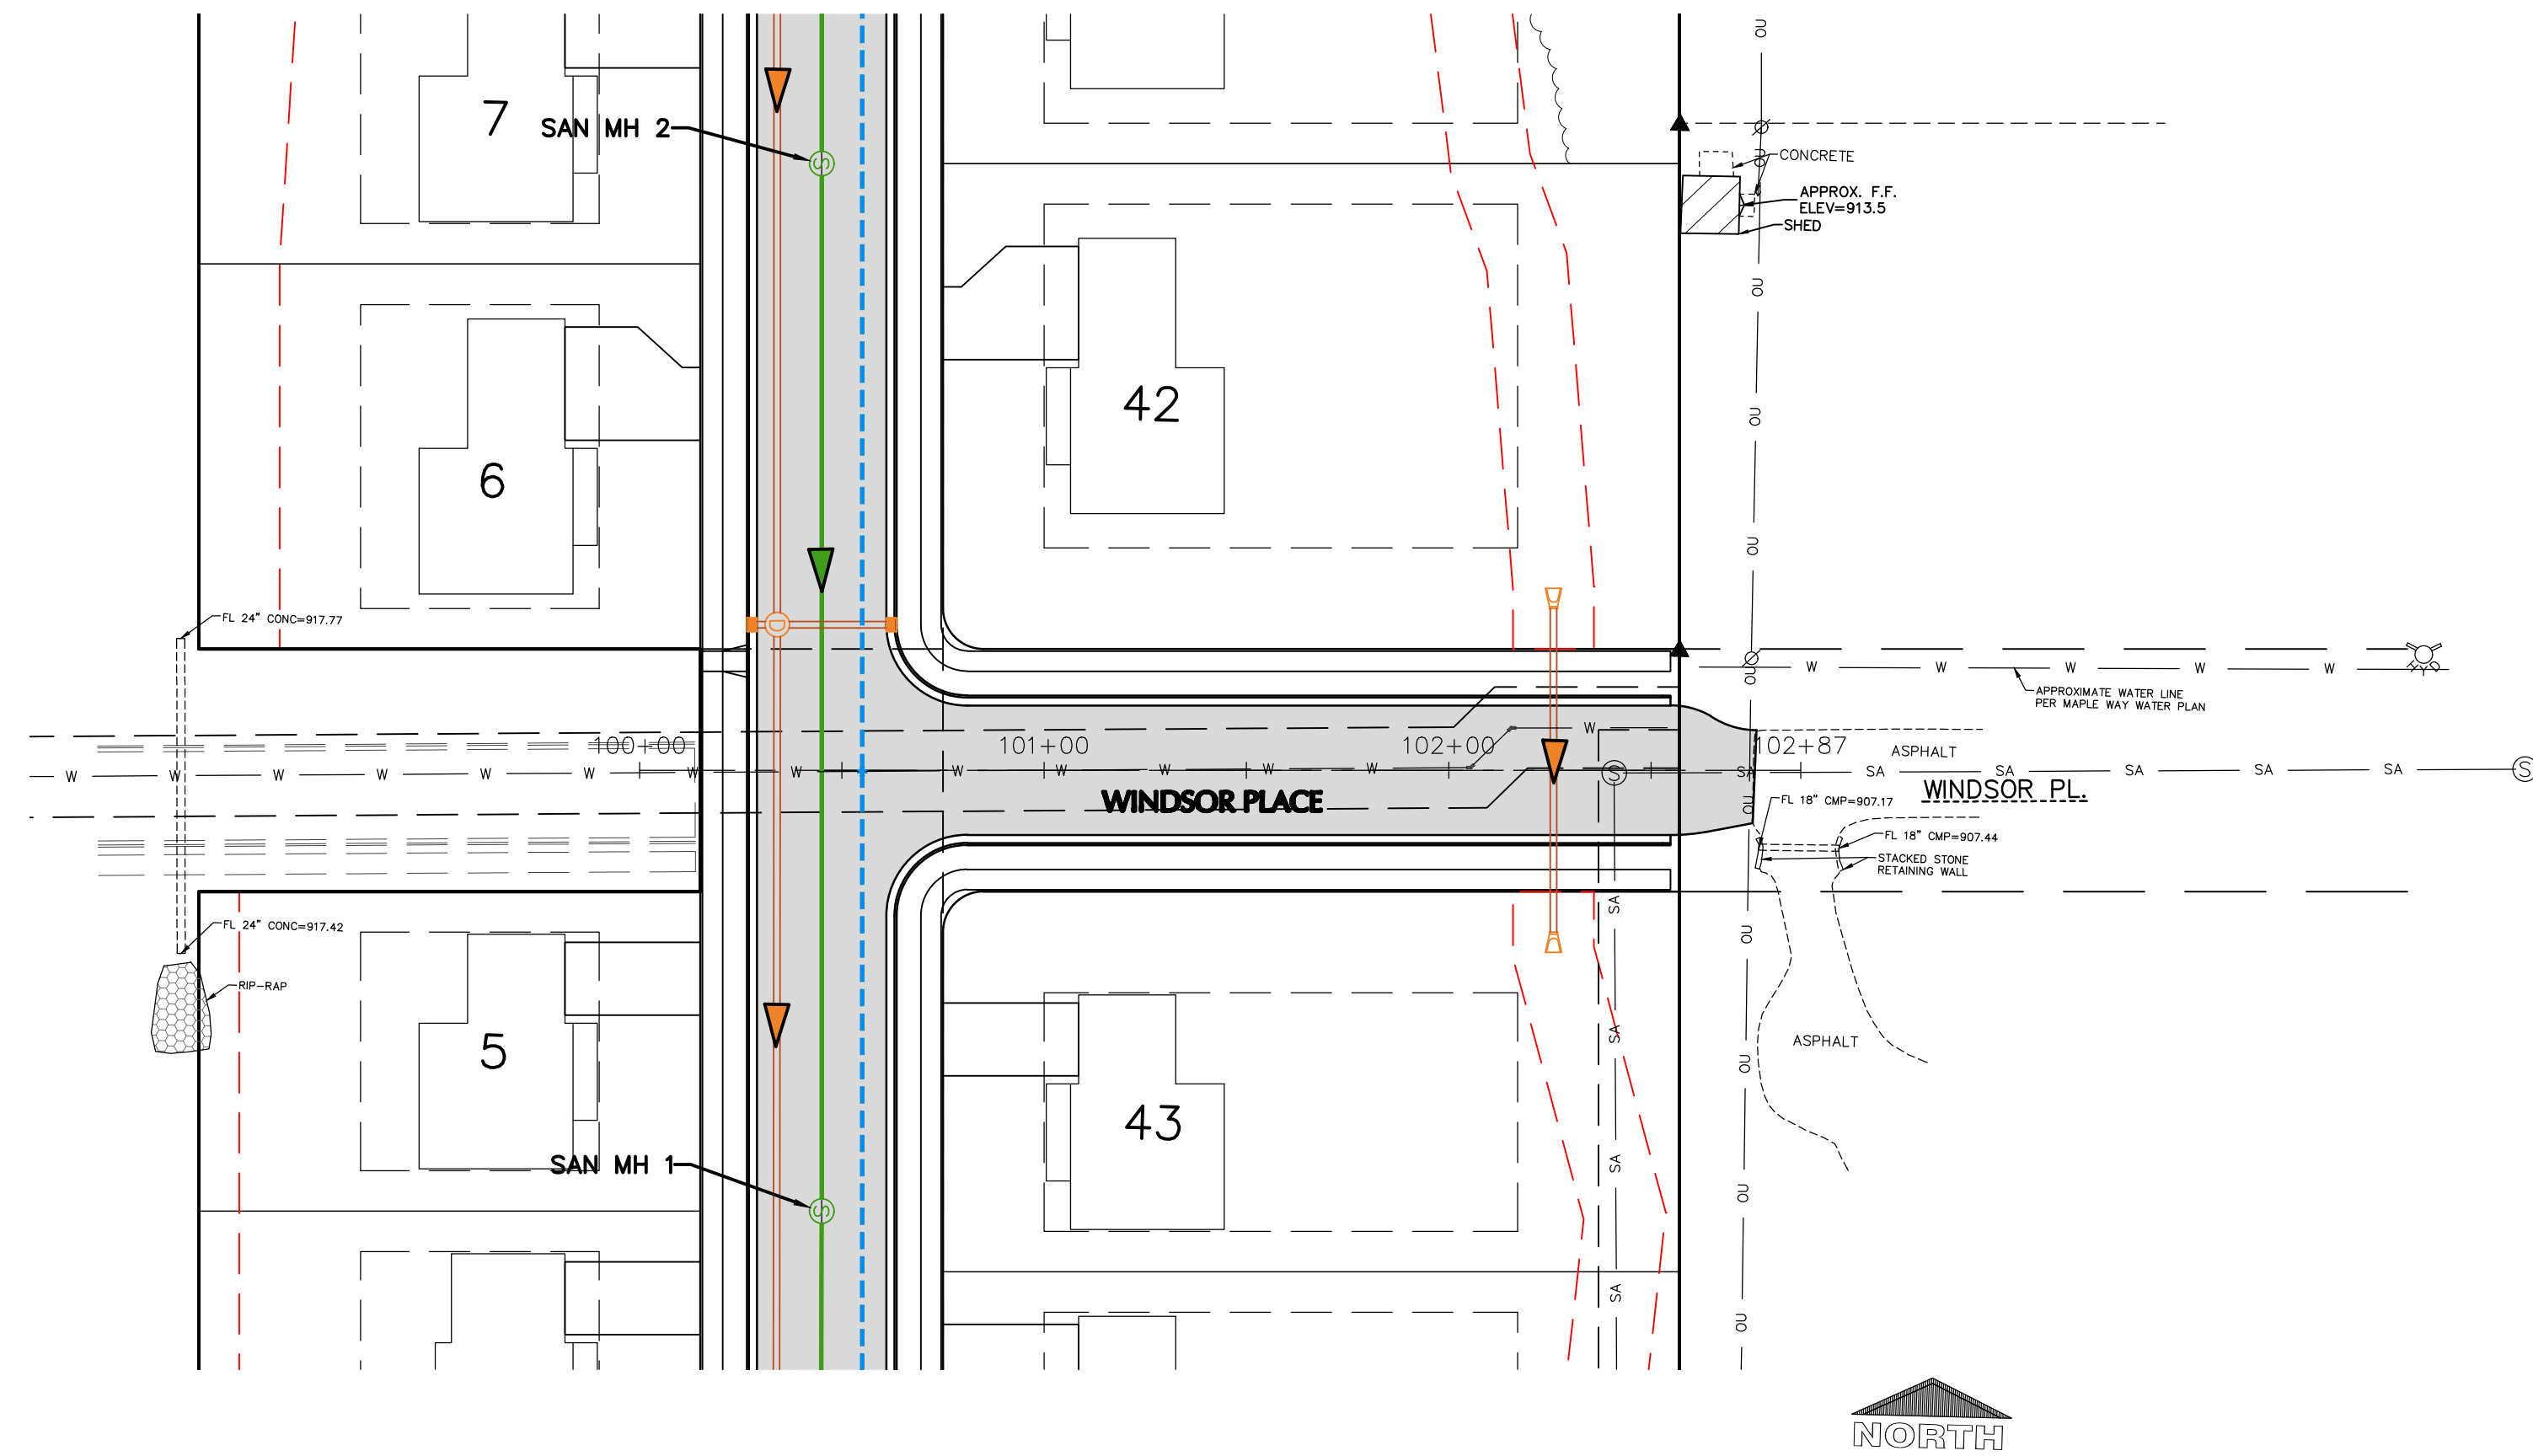

**EXCEL**  
ARCHITECTS • ENGINEERS • SURVEYORS  
Always a Better Plan  
100 Camelot Drive  
Fond Du Lac, WI 54935  
Phone: (920) 926-9800  
www.EXCELENGINEER.com

COLLABORATION

**VERIDIAN HOMES**

**PROJECT INFORMATION**

PROPOSED RESIDENTIAL SUBDIVISION  
**WINTERBERRY RESERVE**  
WINTERBERRY DRIVE • WAUKESHA, WI 53188

PROFESSIONAL SEAL

PRELIMINARY DATES  
JAN. 27, 2025

**NOT FOR CONSTRUCTION**

JOB NUMBER  
230103400

SHEET NUMBER  
**C6.3**

**PROJECT INFORMATION**

PROPOSED RESIDENTIAL SUBDIVISION  
**WINTERBERRY RESERVE**  
 WINTERBERRY DRIVE • WAUKESHA, WI 53188

PROFESSIONAL SEAL




PRELIMINARY DATES  
 JAN. 27, 2025


**NOT FOR CONSTRUCTION**

JOB NUMBER  
 230103400

SHEET NUMBER

**C6.4**

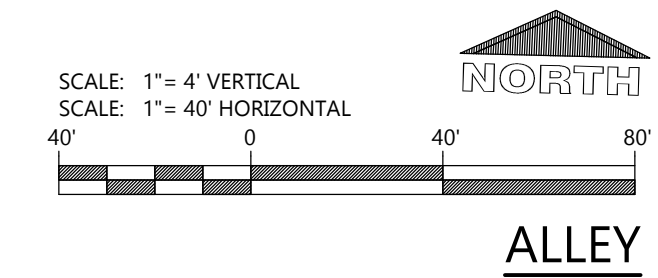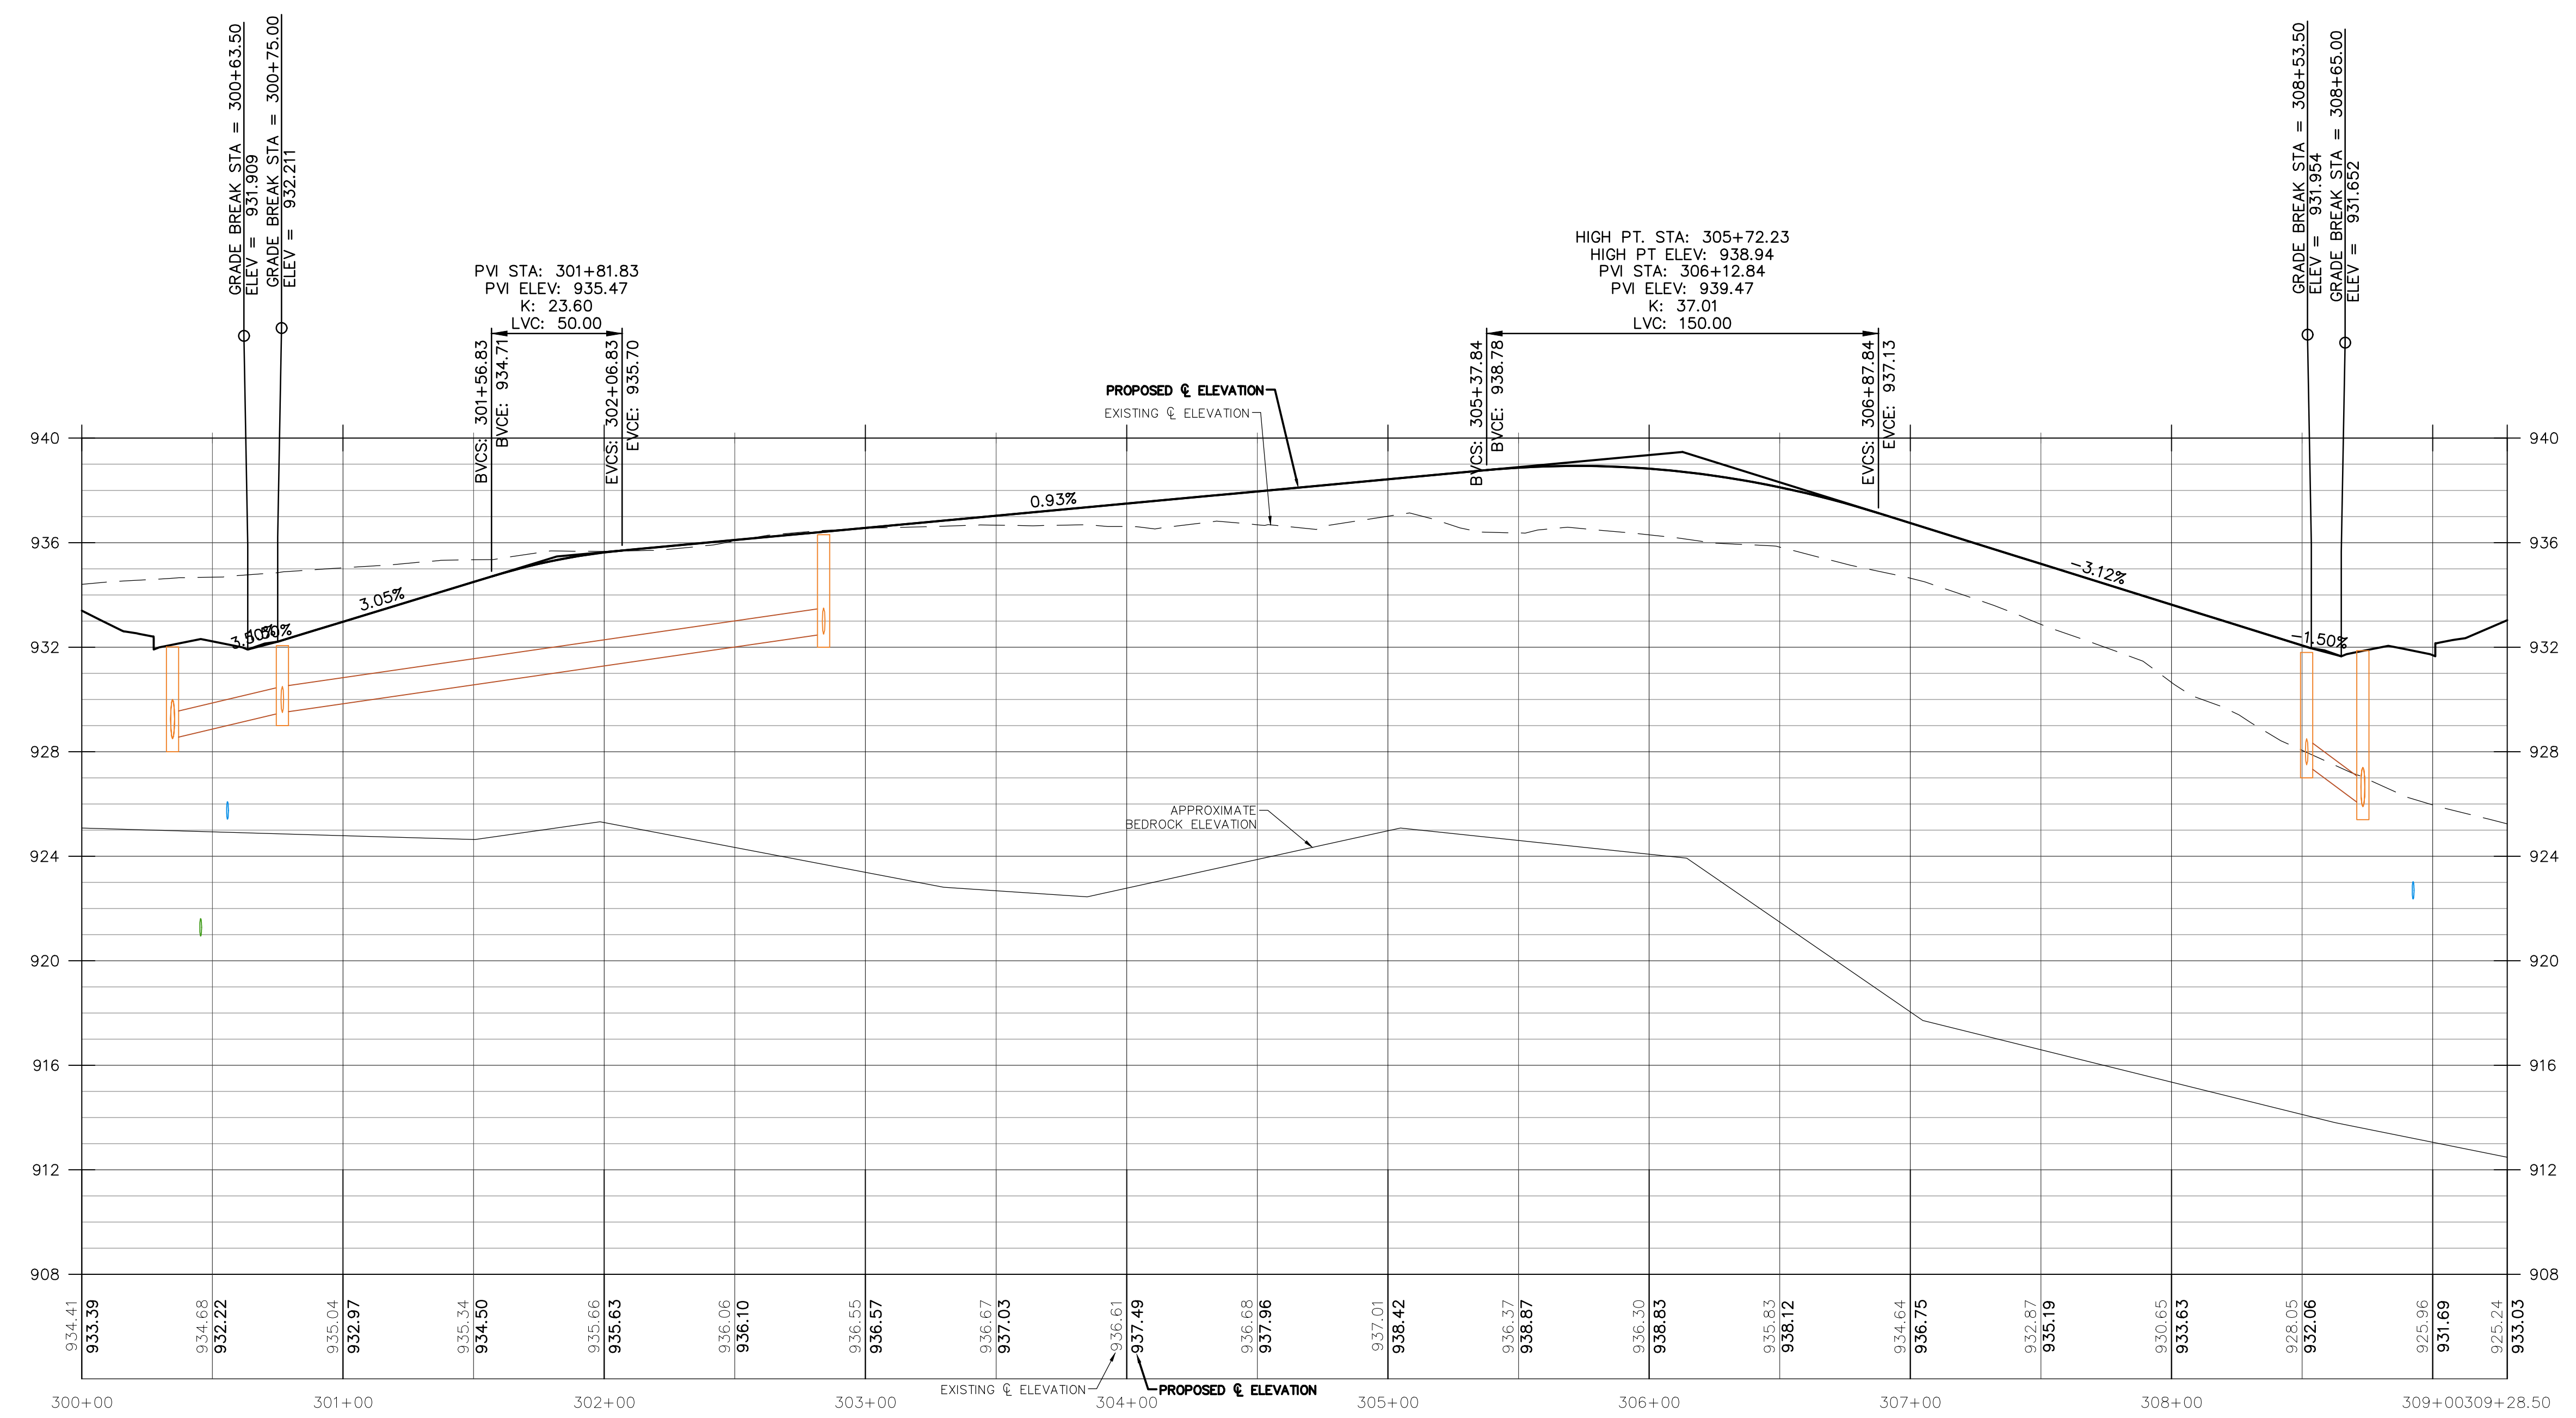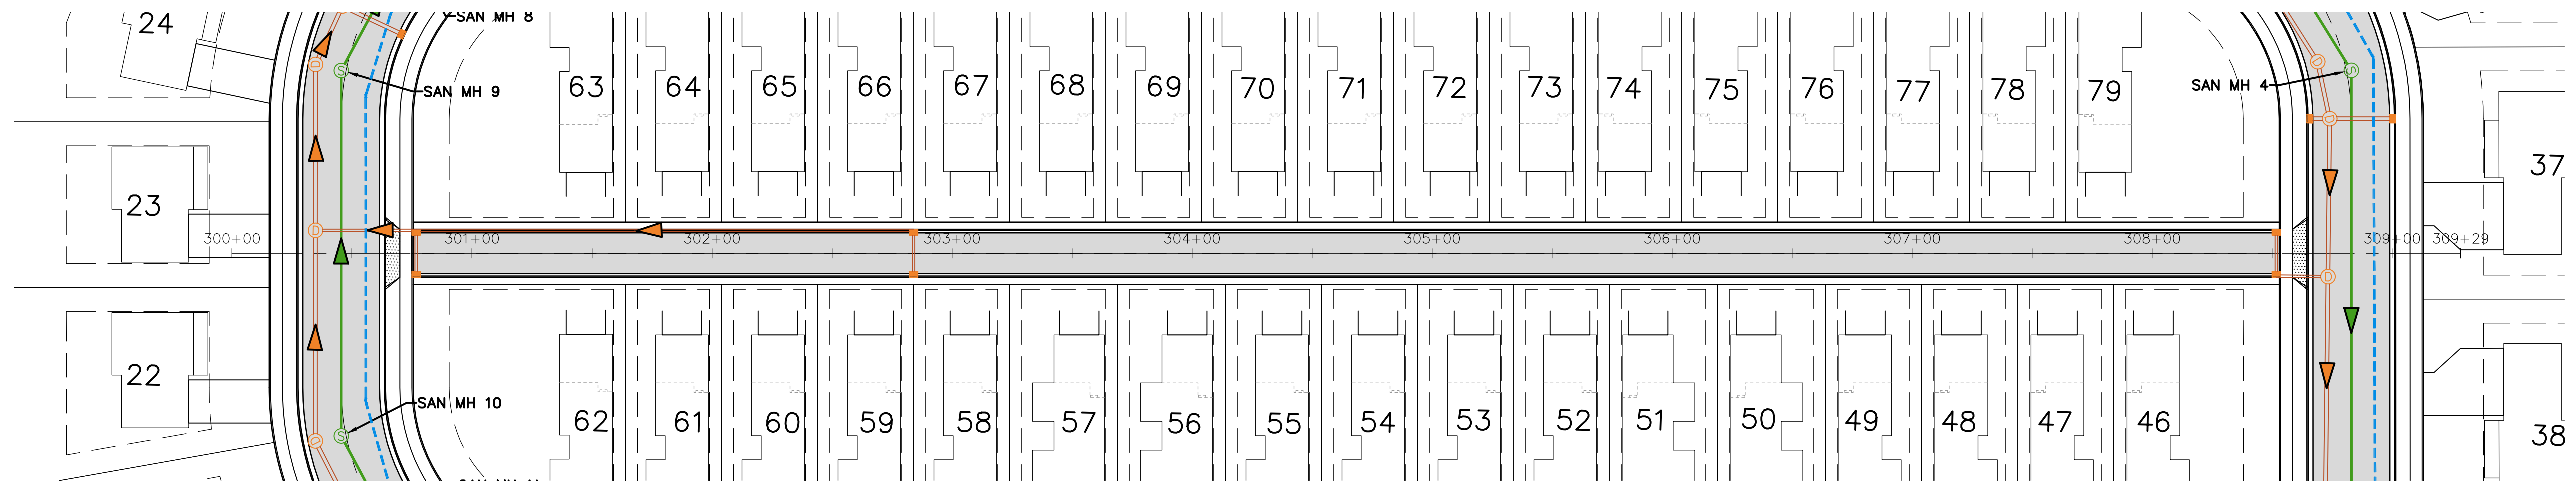

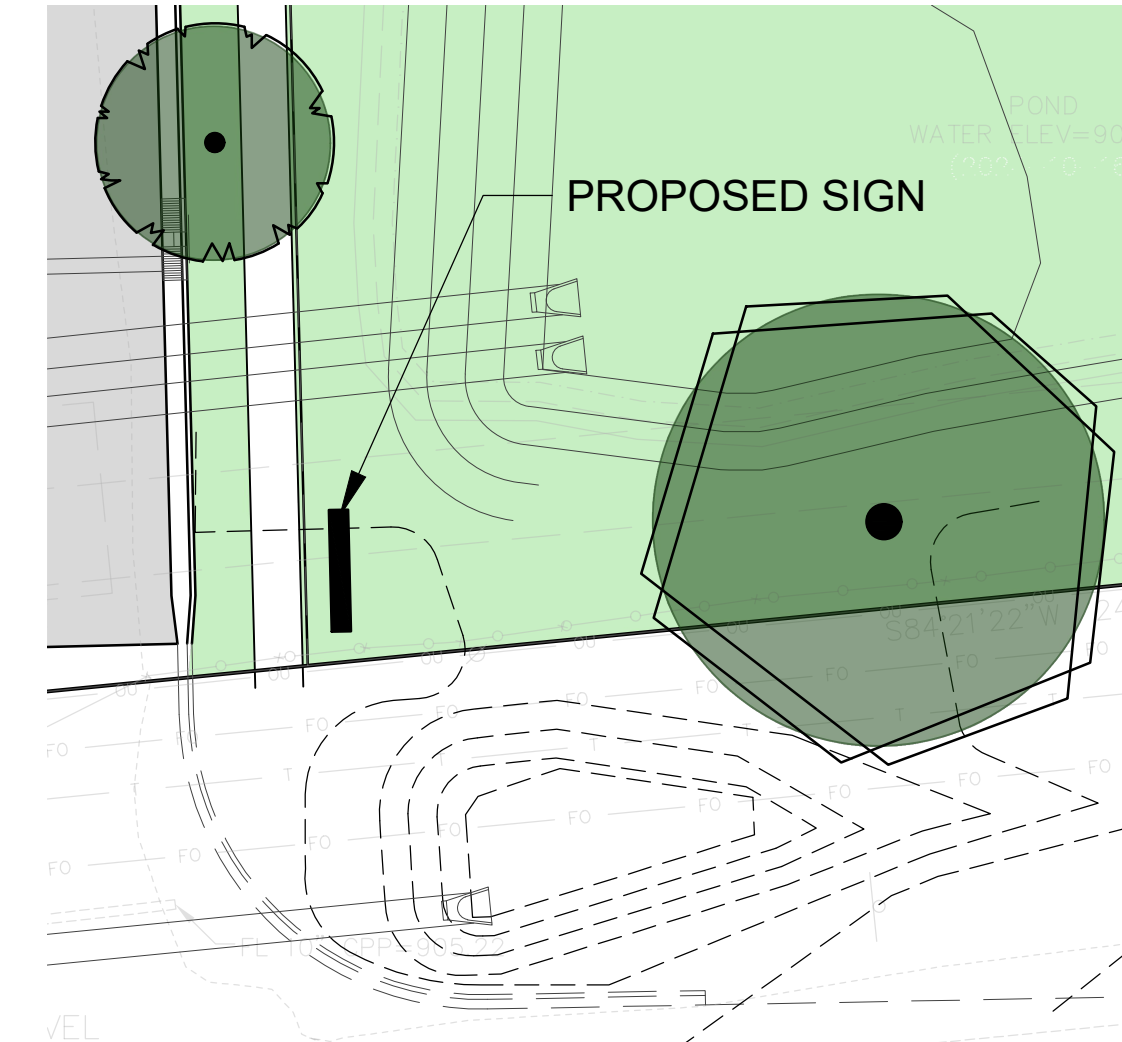

MONUMENT SIGN DETAIL - 20 SCALE


PLANT SCHEDULE					
SYMBOL	COMMON NAME	BOTANICAL NAME	QUANTITY	PLANTED SIZE	ROOT
<b>STREET TREES</b>					
●	Red Maple	<i>Acer rubrum</i>	18	2 1/2" CAL	B&B
●	Chicagoland Hackberry	<i>Celtis occidentalis</i> 'Chicagoland'	16	2 1/2" CAL	B&B
●	Princeton Sentry Ginkgo	<i>Ginkgo biloba</i> 'Princeton Sentry'	18	2 1/2" CAL	B&B
●	Shademaster Honeylocust	<i>Gleditsia triacanthos</i> 'Shademaster'	18	2 1/2" CAL	B&B
●	Swamp White Oak	<i>Quercus bicolor</i>	5	2 1/2" CAL	B&B
●	Redmond Linden	<i>Tilia americana</i> 'Redmond'	16	2 1/2" CAL	B&B
●	New Horizon Elm	<i>Ulmus</i> 'New Horizon'	16	2 1/2" CAL	B&B

EXISTING TREES	
SYMBOL	COMMON NAME
○	Deciduous Specimen Tree
●	Evergreen Specimen Tree


LEGEND	
HATCH	LANDSCAPE TYPE
	EXISTING TREES AND VEGETATION TO BE PROTECTED
	LAWN AREA

**GENERAL NOTES:**

- SWAMP WHITE OAK SHOWN AT FULLY MATURE SIZE. STREET TREES SHOWN 25" DIAMETER BASED ON LIKELIHOOD OF SLOWER GROWTH/SMALLER MATURE SIZE DUE TO GROWING WITHIN TERRACE

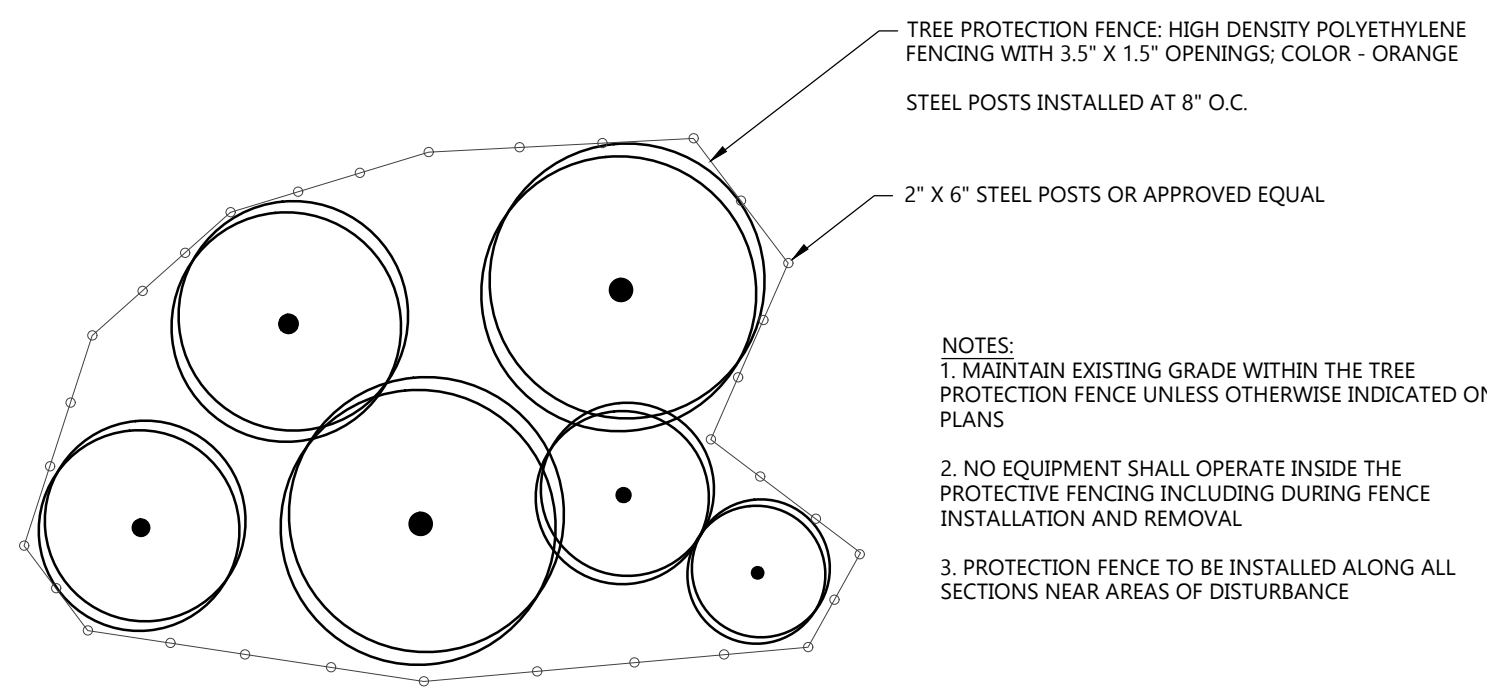

EXISTING TREE PROTECTION AREA DETAIL  
NOT TO SCALE

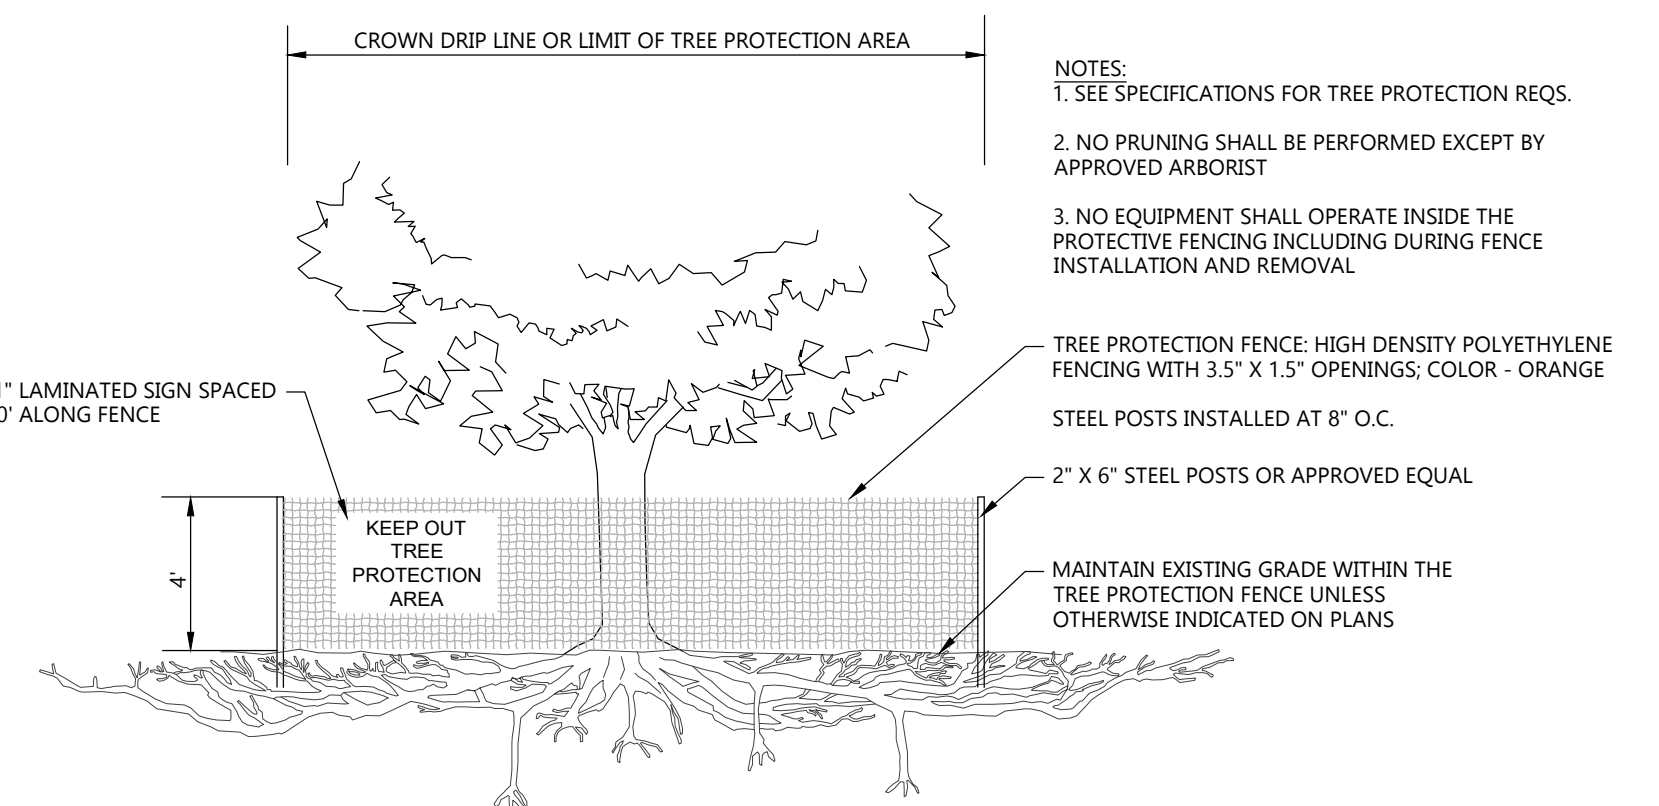

EXISTING TREE PROTECTION DETAIL  
NOT TO SCALE



PROPOSED LIGHT POLE  
SEE DETAIL - SAME SHEET



PROJECT INFORMATION

PROPOSED RESIDENTIAL SUBDIVISION  
**WINTERBERRY RESERVE**  
WINTERBERRY DRIVE • WAUKESHA, WI 53188

PROFESSIONAL SEAL

PRELIMINARY DATES

JAN. 27, 2025

NOT FOR CONSTRUCTION

JOB NUMBER

230103400

SHEET NUMBER

**C10.0**