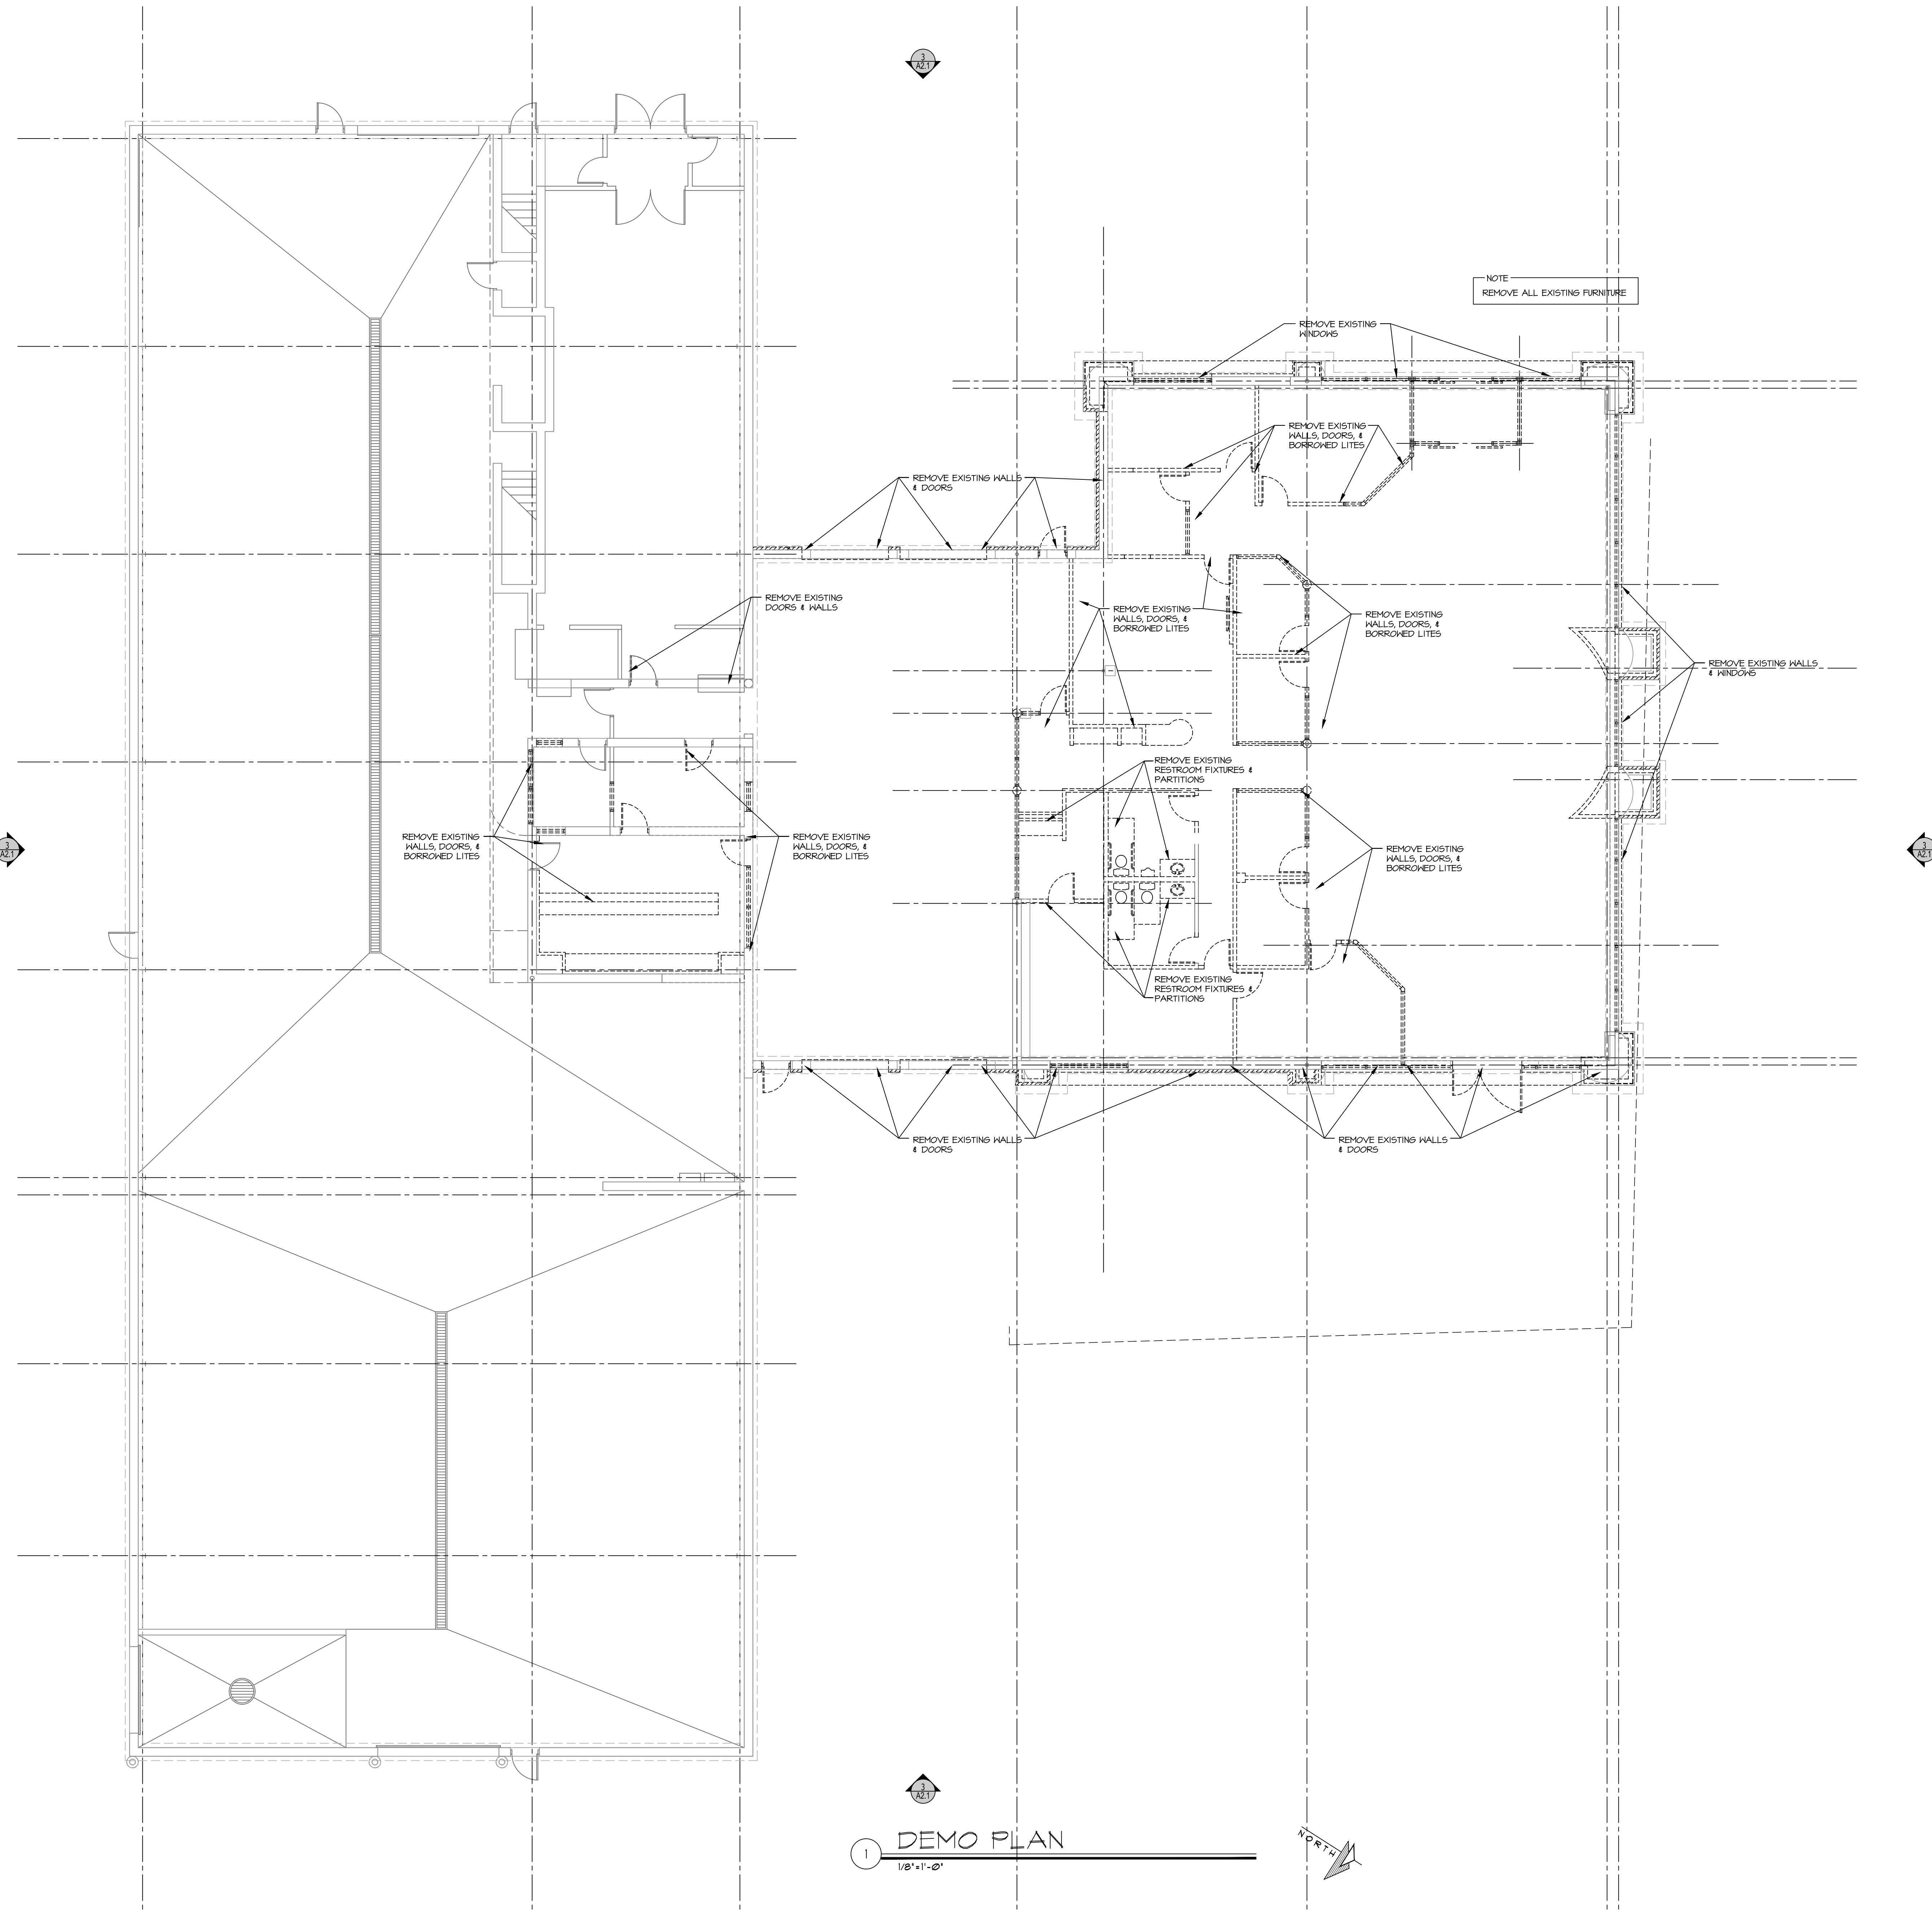
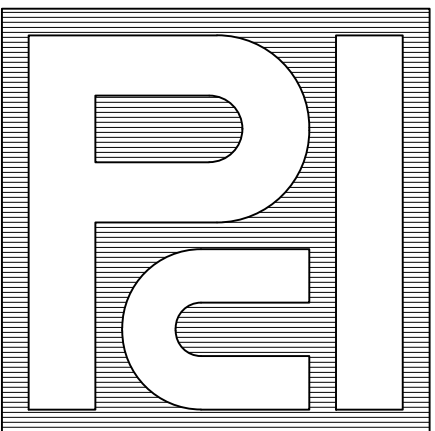




1 DEMO PLAN
1/8"=1'-0"



PROFESSIONAL
CONSULTANTS, INC.

133 HILL STREET
HARTLAND, WISCONSIN 53029
(262) 367-6080

BOUCHER CADILLAC
WAUKESHA

2145 EAST MORELAND BLVD.
WAUKESHA, WISCONSIN

©TDI ASSOCIATES, INC
All Rights Reserved

OWNERSHIP OF DOCUMENTS

This document, and the ideas and design incorporated herein, as an instrument of professional service, is the sole property of TDI Associates, Inc., and is not to be used in whole or in part for any other project or purpose without the expressed written authorization of TDI Associates, Inc.

Sheet Title
DEMO PLAN

Issued For: Date:

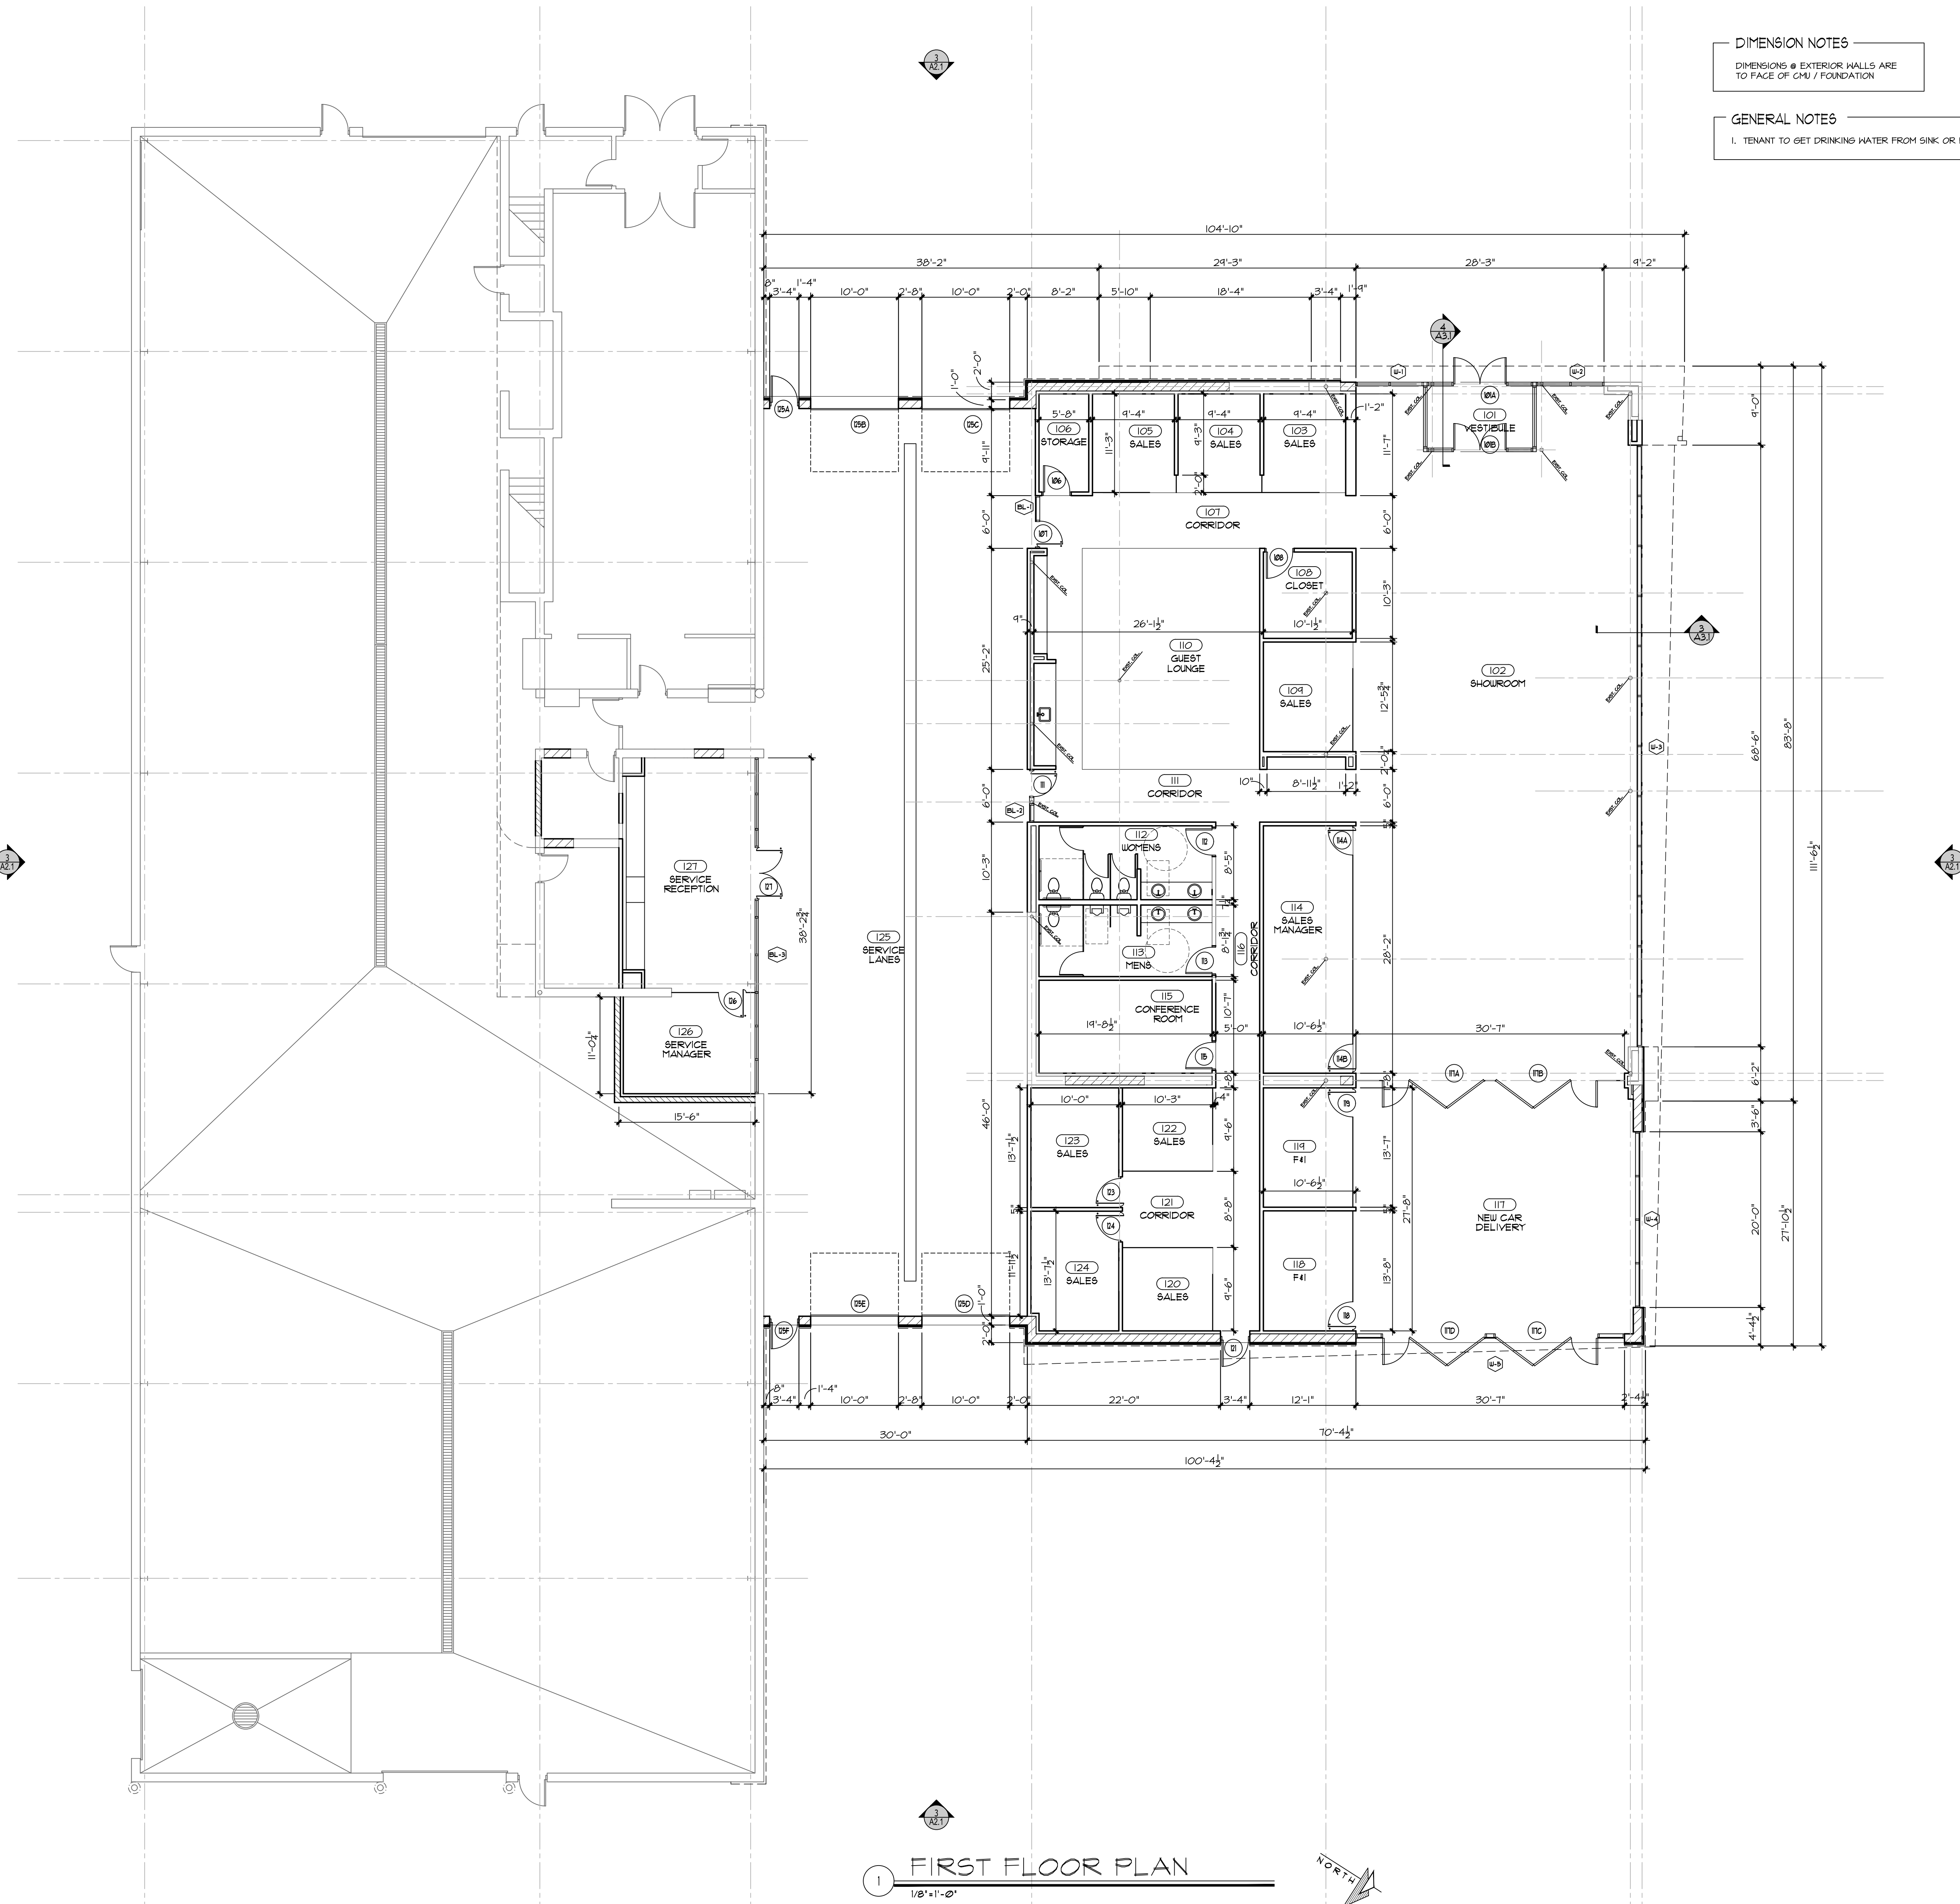
Date: 06-23-2025

Job NO.: 23129.000

Drawn By: Drawn By


Sheet No.

A1.1



DIMENSION NOTES
DIMENSIONS @ EXTERIOR WALLS ARE
TO FACE OF CMU / FOUNDATION

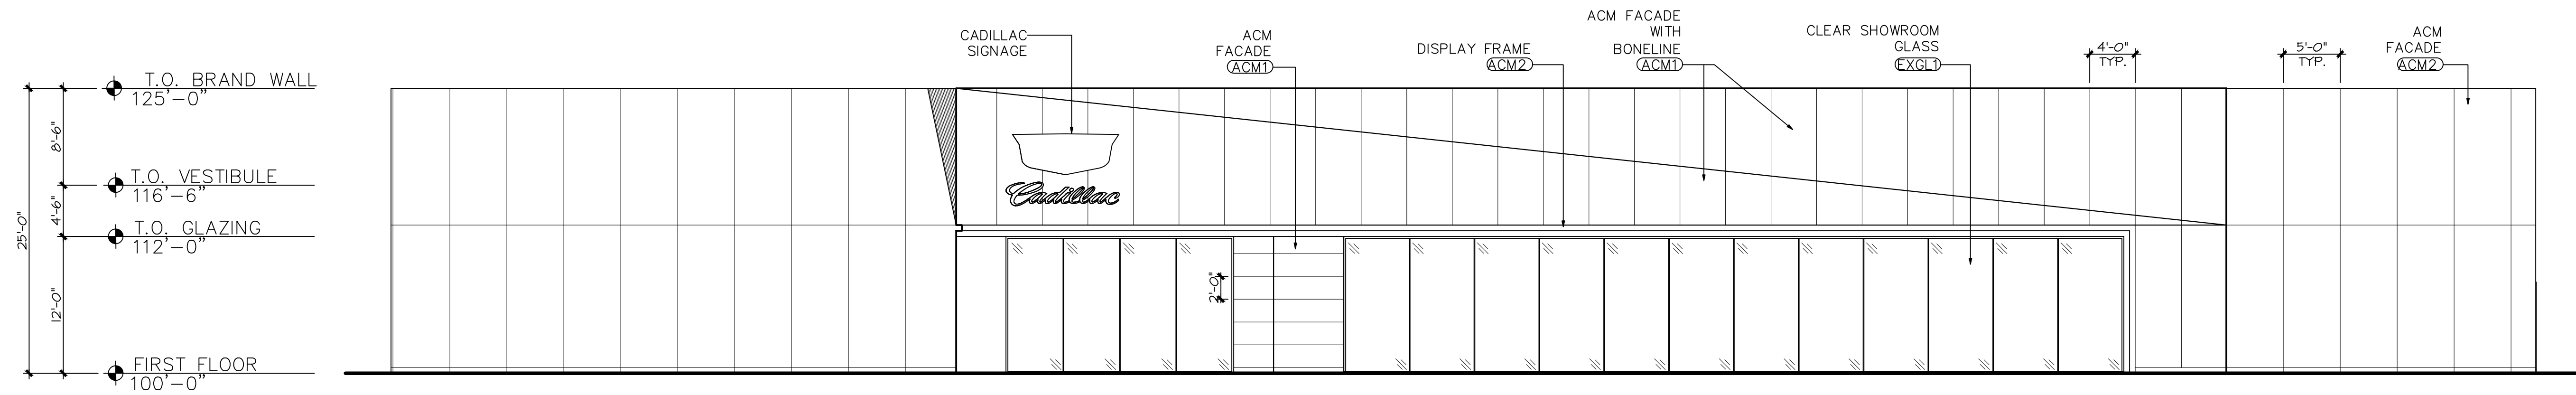
GENERAL NOTES
1. TENANT TO GET DRINKING WATER FROM SINK OR PROVIDE BOTTLED WATER.




1 SOUTH ELEVATION
1/8" = 1'-0"

EXTERIOR FINISH SCHEDULE	
FINISH CODE	COLOR & MATERIAL SPECIFICATIONS
ACM1	ALPOLIC COLOR: CPW WHITE 3MM4CPW8
ACM2	ALPOLIC COLOR: MICA MNC 4MM 4MNC8
ACM3	ALPOLIC COLOR: CNC CHARCOAL 4MM 4CNC8
EPT1	TO MATCH ALPOLIC COLOR: MICA MNC 4MM 4MNC8
EXGL1	SINGLE STORY: KAWNEER 2-SIDED 1620 SSG SYSTEM OR EQUAL TWO-STORY: KAWNEER 4-SIDED 1620 SSG C/W SYSTEM OR EQUAL CLEAR ANODIZED APPEARANCE VERTICAL BUTTJOINT W/ MULLION BACK-UP

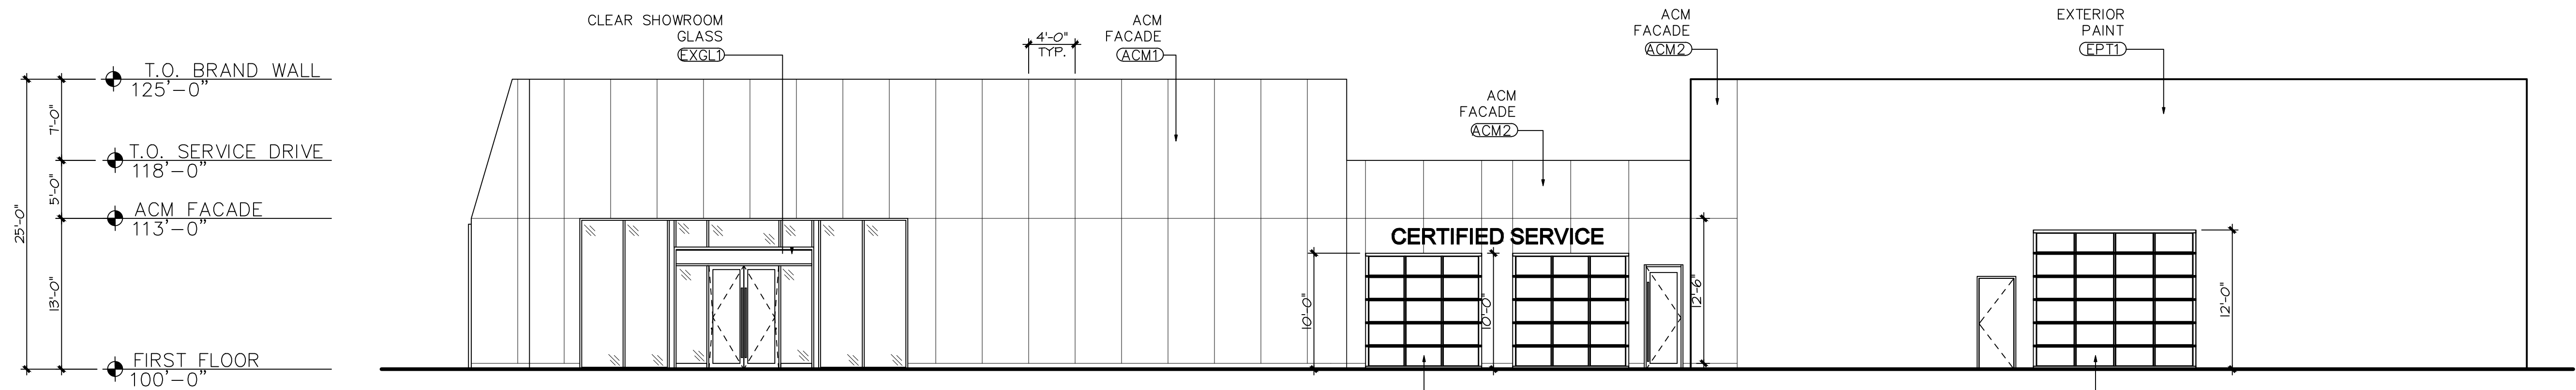
NOTE: REFER TO SIGNAGE VENDOR FOR PROCUREMENT AND INSTALLATION REQUIREMENTS.




2 EAST ELEVATION
1/8" = 1'-0"

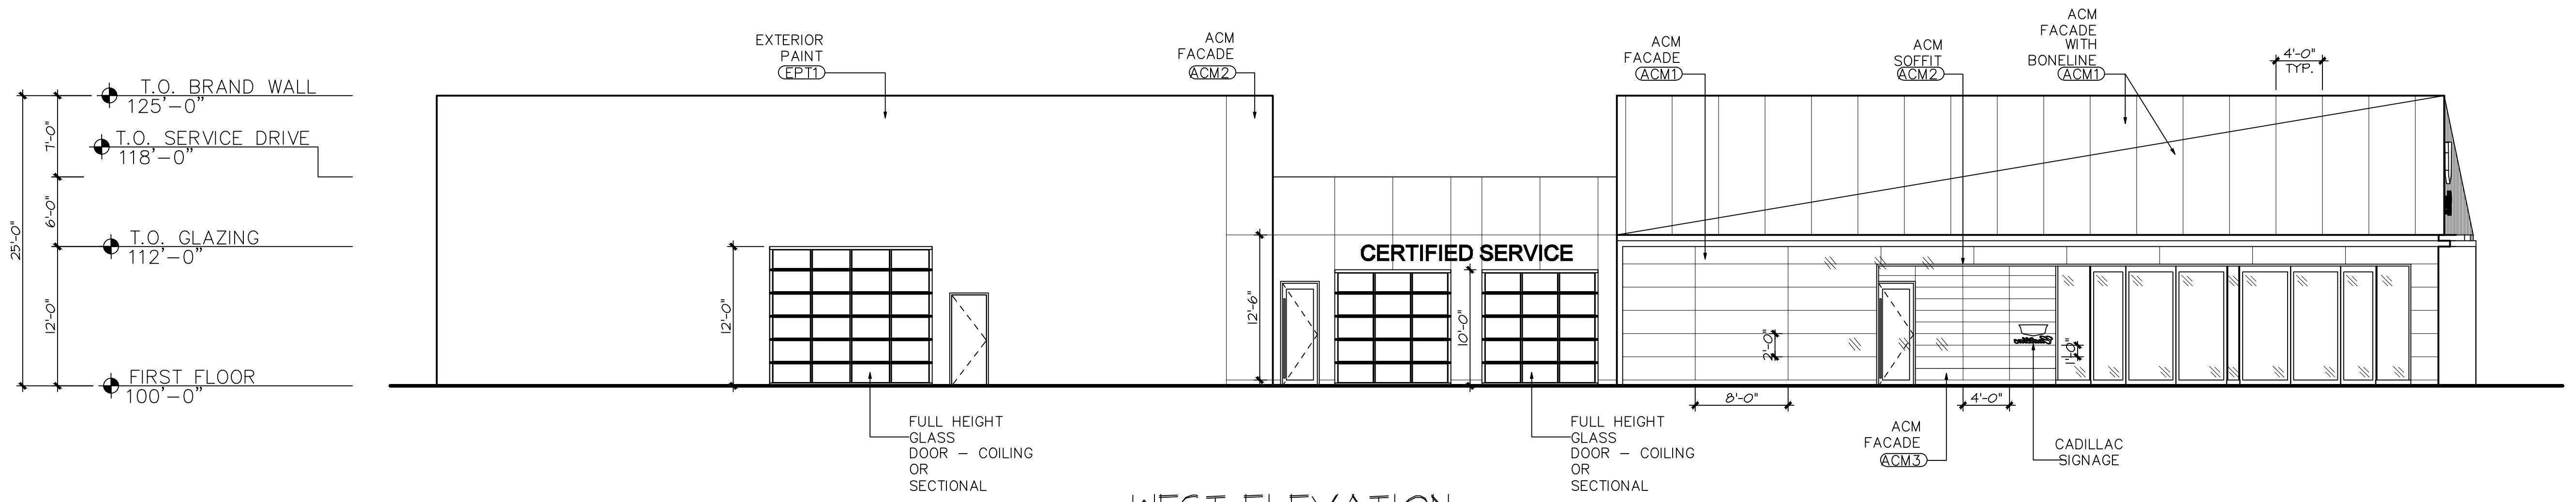


3 WEST ELEVATION
1/8" = 1'-0"

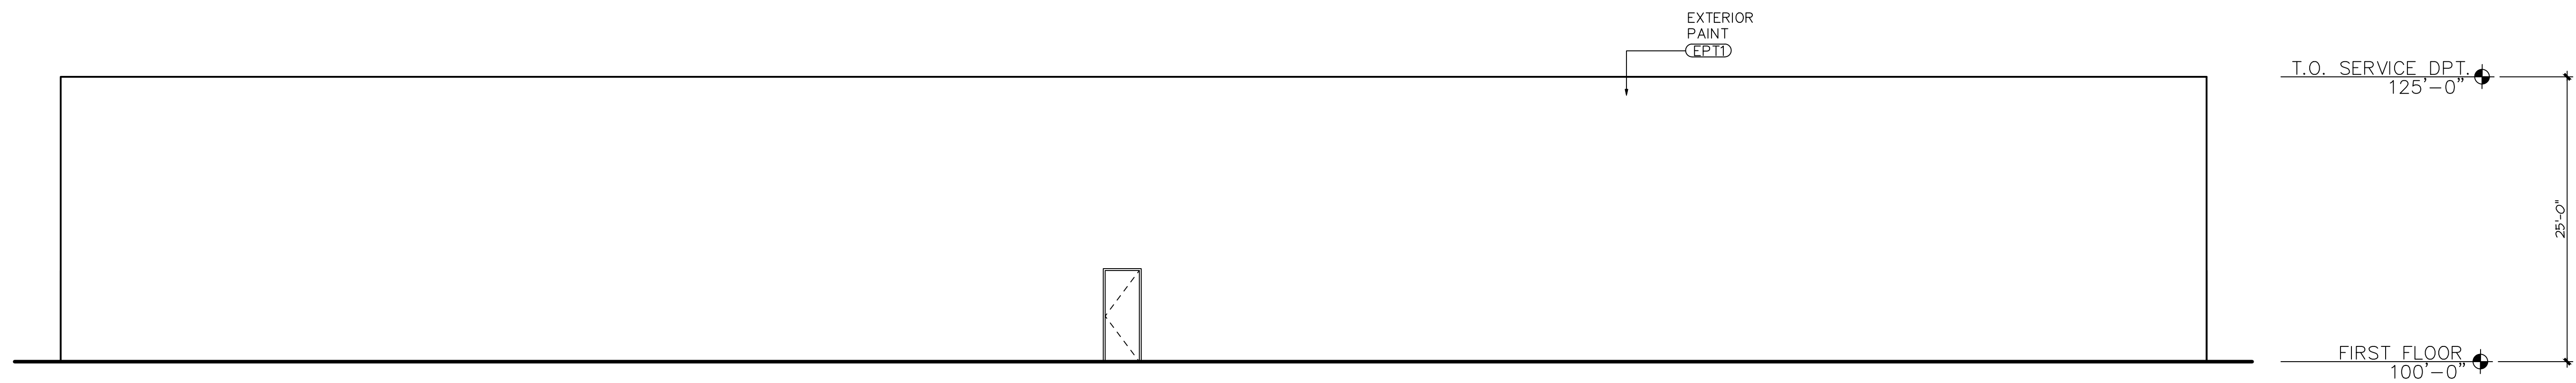


4 NORTH ELEVATION
1/8" = 1'-0"

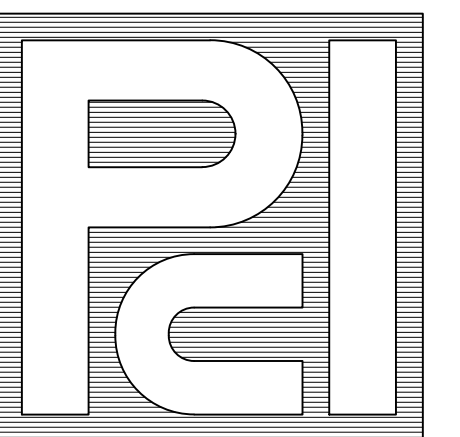

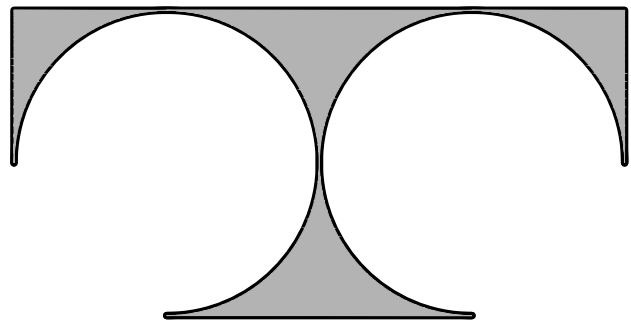

TDI ASSOCIATES, INC.
ARCHITECTURE & PLANNING

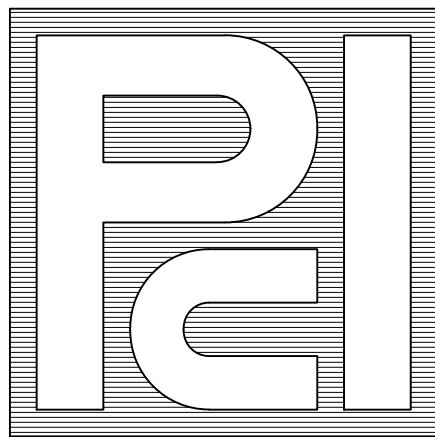25217 SOUTH WIND LAKE ROAD
WIND LAKE, WISCONSIN 53185
PHONE 262-409-2530



PROFESSIONAL
CONSULTANTS, INC.

133 HILL STREET
HARTLAND, WISCONSIN 53029
(262) 367-6080

BOUCHER CADILLAC
WAUKESHA
2145 EAST MORELAND BLVD.
WAUKESHA, WISCONSIN

©TDI ASSOCIATES, INC
All Rights Reserved

OWNERSHIP OF DOCUMENTS

This document, and the ideas and design incorporated herein, as an instrument of professional service, is the sole property of TDI Associates, Inc., and is not to be used in whole or in part for any other project or purpose without the expressed written authorization of TDI Associates, Inc.

Sheet Title
SECTIONS

Issued For: Date:

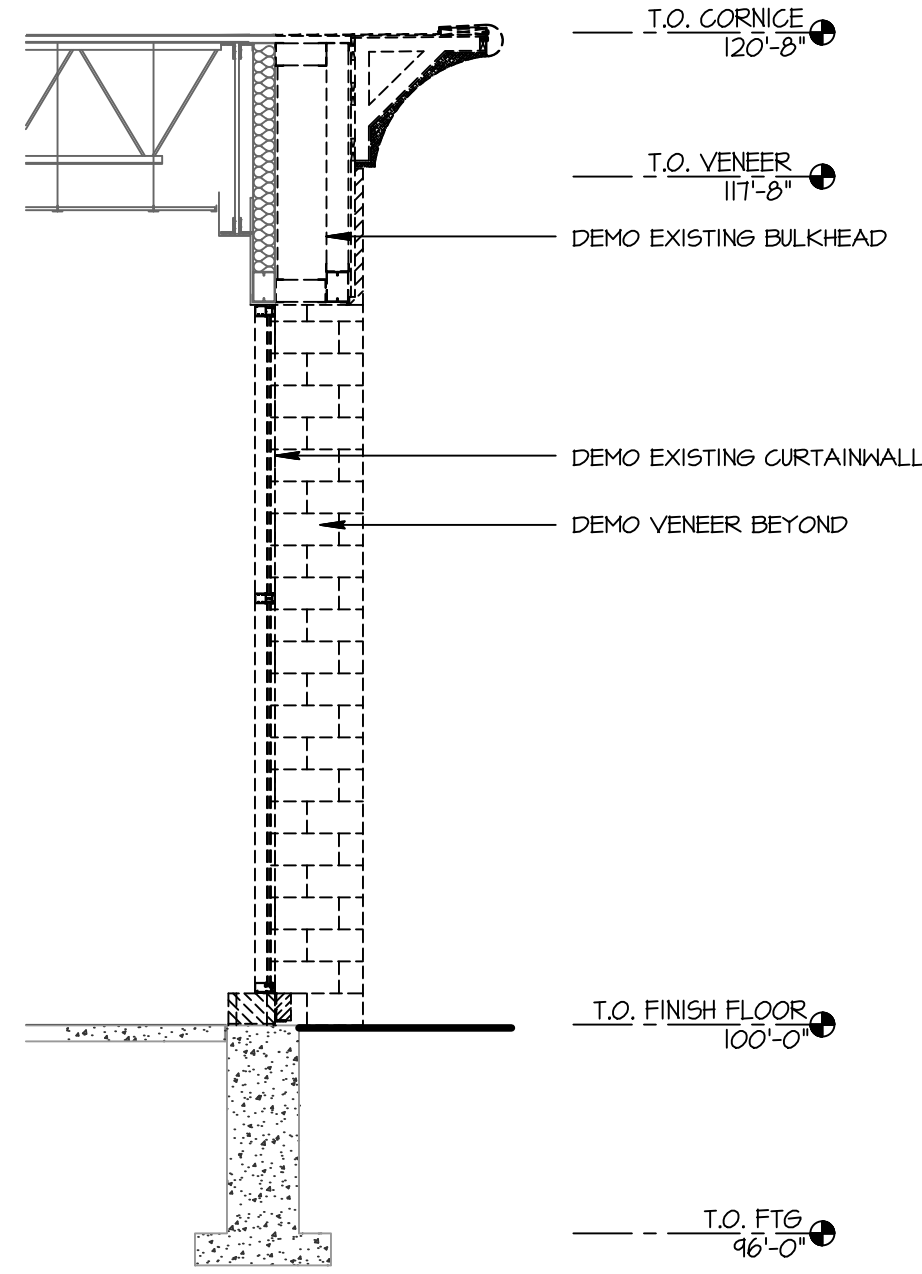
Date: 06-23-2025

Job NO.: 23129.000


Drawn By: Drawn By

Sheet No.


A3.1




1 DEMO WALL SECTION
1/4" = 1'-0"

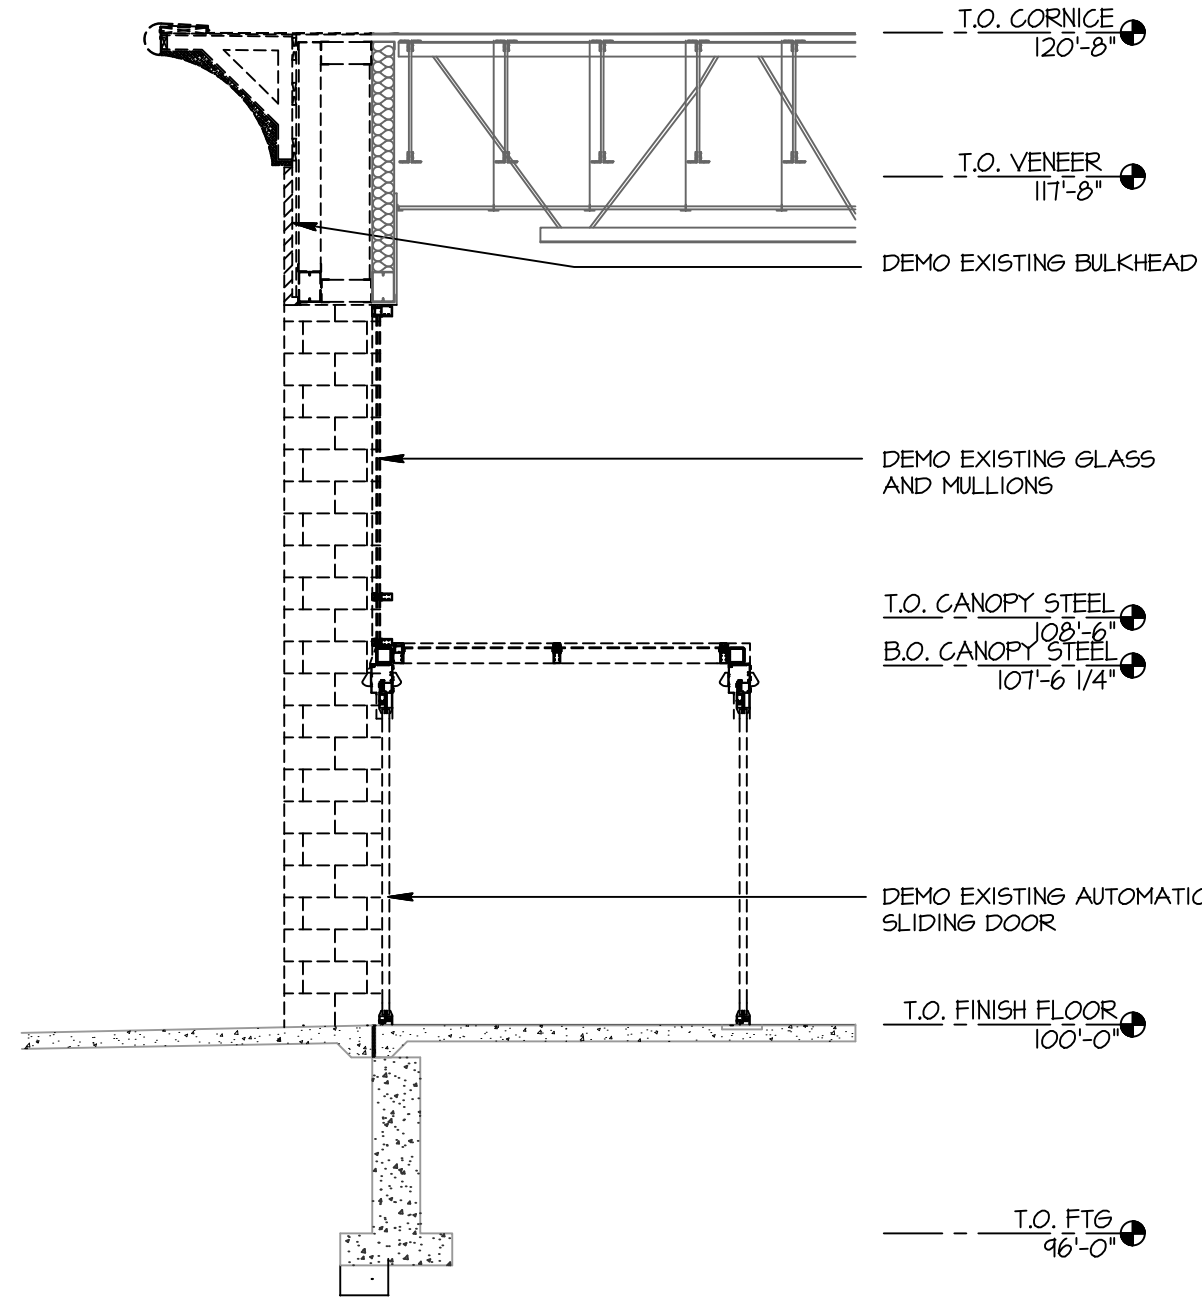

2 DEMO WALL SECTION
1/4" = 1'-0"

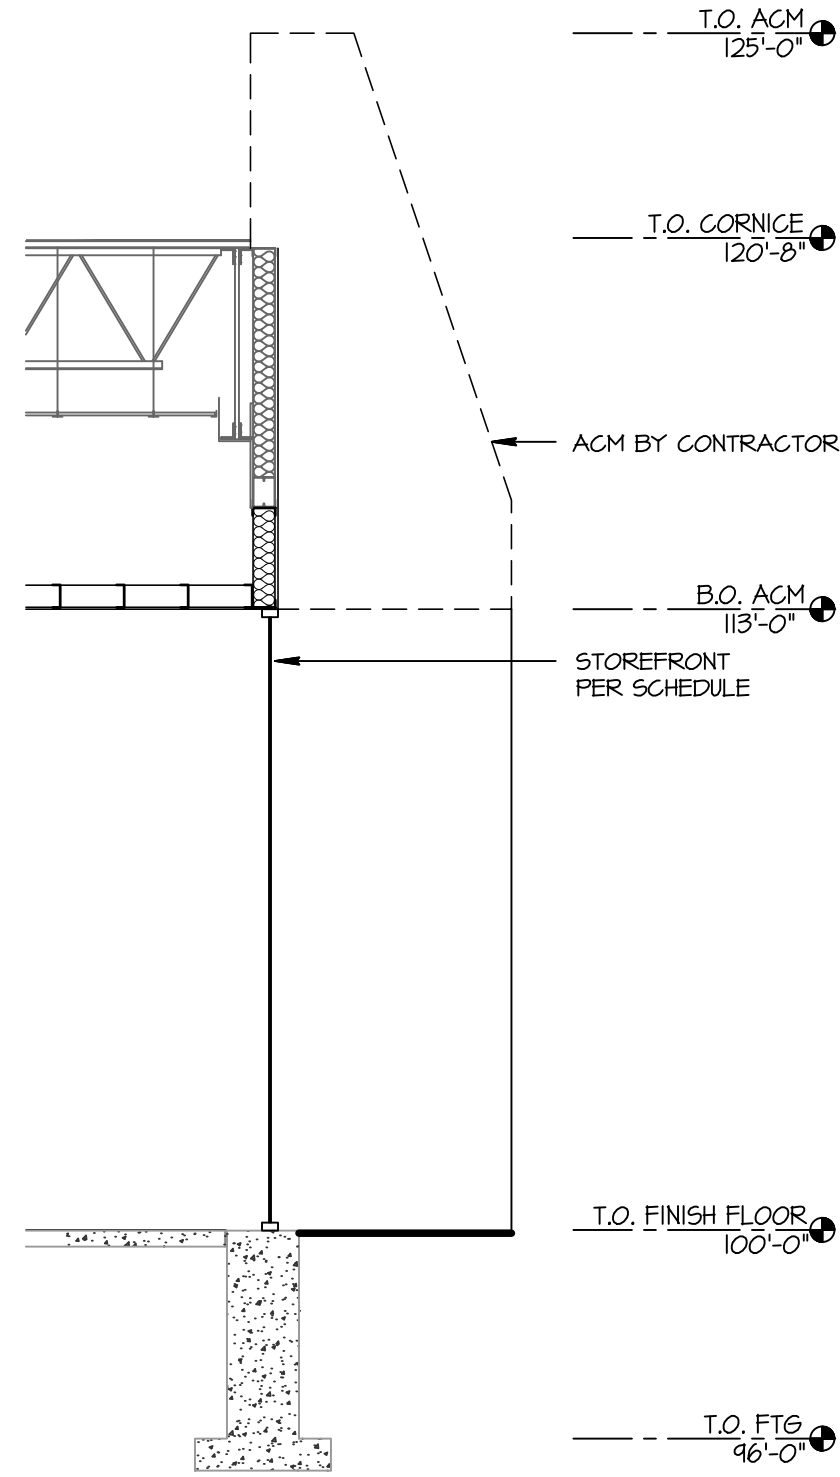

3 WALL SECTION
1/4" = 1'-0"

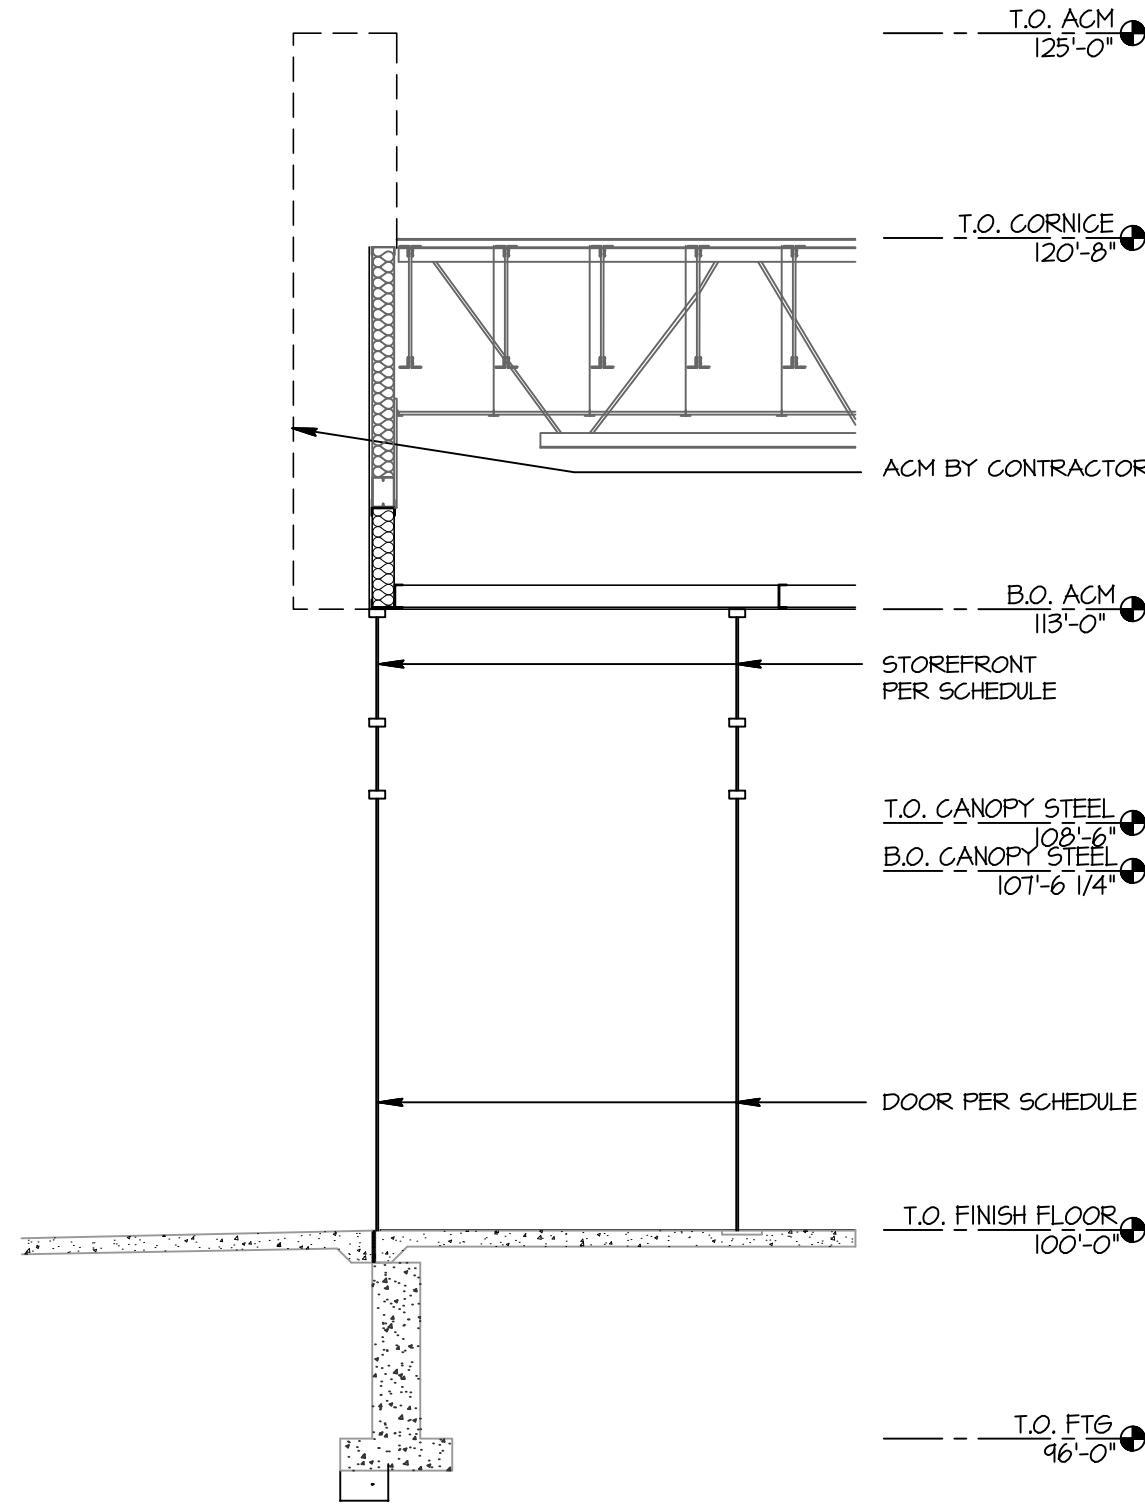

4 WALL SECTION
1/4" = 1'-0"



FINISH SYMBOLS	
SYMBOL	DESCRIPTION
	WALL FINISH
	BASE MATERIAL
	FLOOR MATERIAL
	FINISH DESIGNATION

GENERAL NOTES

- A. REFER TO WALL FINISH SCHEDULE FOR WALL FINISH INFORMATION.
- B. REFER TO SHEET A6.1 FOR CEILING FINISHES.
- C. PROVIDE THRESHOLDS AT ALL EXTERIOR MAIN DOORS.
- D. REFER TO SHEET A7.1 FOR DOOR FINISHES

OWNERSHIP OF DOCUMENTS

This document, and the ideas and design incorporated herein, as an instrument of professional service, is the sole property of TDI Associates, Inc., and is not to be used in whole or in part for any other project or purpose without the expressed written authorization of TDI Associates, Inc.

Sheet Title
FIRST FLOOR
FINISH PLAN

Issued For: Date:

Date: 06-23-2025

Job NO.: 23129.000

Drawn By: Drawn By


Sheet No.

A4.1

Materials + Finishes Schedule


NO.	LOCATION	COLOR & MATERIAL SPECIFICATIONS	DESCRIPTIONS	MANUFACTURER/ SUPPLIER	LEAD TIME
EXTERIOR					
ACM1	EXTERIOR CLADDING FOR PRIMARY SHOWROOM AND NEW CAR DELIVERY	ALPOLIC COLOR: CPW WHITE 4MM 4CPW8	PRIMARY WALL CLADDING	ALPOLIC ALPOLIC-AMERICAS.COM 800-422-7270	6 Weeks
ACM2	EXTERIOR WINDOW FRAME FINISH FIXED OPERATIONS	ALPOLIC COLOR: MICA MNC 4MM 4MNC3	EXTERIOR FRAME FINISH	ALPOLIC ALPOLIC-AMERICAS.COM 800-422-7270	6 Weeks
ACM3	SIDE ENTRY ONLY	ALPOLIC COLOR: CNC CHARCOAL 4MM 4CNC8	EXTERIOR ACCENT WALL @ SIDE ENTRY	ALPOLIC ALPOLIC-AMERICAS.COM 800-422-7270	6 Weeks
EXGL1	EXTERIOR GLAZING - SHOWROOM	KAWNEER TRIFAB 601 OR EQUAL STOREFRONT CLEAR ANODIZED APPEARANCE VERTICAL BUTT JOINT W/ MULLION BACK-UP	SHOWROOM GLAZING	KAWNEER COMPANY, INC. CHERYL.WILKERSON@ALCOA.COM	6 Weeks
EXGL2	EXTERIOR GLAZING - ALL OTHER AREAS	KAWNEER TRIFAB 601 OR EQUAL STOREFRONT CLEAR ANODIZED APPEARANCE ELI LION BRONZE EXTRUDED ALUM. DOORS CLEAR ANODIZED APPEARANCE	STOREFRONT GLAZING, DOORS	KAWNEER COMPANY, INC. CHERYL.WILKERSON@ALCOA.COM	6 Weeks
	METAL TRIMS	US 303 STAINLESS STEEL TO MATCH ALUCOBOND NATURAL BRUSHED 50	METAL COPING, BASE, LARGE-SCALE REVEALS	OPEN	
EPT-1	EXTERIOR PAINT FINISH	TO MATCH: BENJAMIN MOORE MARINA GRAY 1599	PRIMARY PAINT FINISH FOR ALL AREAS NOT REQUIRING PRIMARY CLADDING	OPEN	
EPT-2	EXTERIOR PAINT FINISH	TO MATCH: BENJAMIN MOORE SNOW WHITE OC-66	PRIMARY PAINT FINISH FOR ALL AREAS NOT REQUIRING PRIMARY CLADDING	OPEN	
FLOORS					
T1	SHOWROOM PATTERN - ALL CUSTOMER AREAS	LEA CERAMICHE BASALTINA STONE PROJECT COLOR: NATURALE SIZE: 12 X 24 NUMBER: LGVBSR1-1330 TEC POWER GROUT 929	SHOWROOM, CUSTOMER TOUCH POINT, INCLUDING RESTROOMS PRIMARY FLOOR TILE	VIRGINIA TILE STEVE REINING CADILLACTILE@VIRGINIATILE.COM 248-388-6940	8 WEEKS
T1 ALT.	SHOWROOM PATTERN - ALL CUSTOMER AREAS	VIRGINIA TILE COLLECTION COLOR: VCO K203 1224R SIZE: 12 X 24	SHOWROOM, CUSTOMER TOUCH POINT, INCLUDING RESTROOMS PRIMARY FLOOR TILE	VIRGINIA TILE STEVE REINING CADILLACTILE@VIRGINIATILE.COM 248-388-6940	8 WEEKS
T2	SHOWROOM RUNWAY PATTERN	LEA CERAMICHE BASALTINA STONE PROJECT COLOR: SABBIA TA SIZE: 12 X 24 NUMBER: LGVBSR0-1290 TEC POWER GROUT 934	SHOWROOM RUNWAY FLOOR TILE	VIRGINIA TILE STEVE REINING CADILLACTILE@VIRGINIATILE.COM 248-388-6940	8 WEEKS
T2 ALT.	SHOWROOM RUNWAY PATTERN	VIRGINIA TILE COLLECTION COLOR: VCO K248 1224R SIZE: 12 X 24	SHOWROOM RUNWAY FLOOR TILE	VIRGINIA TILE STEVE REINING CADILLACTILE@VIRGINIATILE.COM 248-388-6940	8 WEEKS
T3	RESTROOM WALLS	CERAMIC TILE INTERNATIONAL COLOR: 90201 UNEN SIZE: 12 X 24 TEC POWER GROUT 931	RESTROOM WET WALLS (OPTIONAL) ALL OTHER WALLS - APPLIED IN RUNNING BOND	VIRGINIA TILE STEVE REINING CADILLACTILE@VIRGINIATILE.COM 248-388-6940	2-3 WEEKS
T4	SERVICE DRIVE LANE	CROSSVILLE CROSS-TECH COLOR: ONYX A880CTS SIZE: 8 X 8 TEC POWER GROUT 929	TRACTION TILE FOR SERVICE DRIVE-IN	VIRGINIA TILE STEVE REINING CADILLACTILE@VIRGINIATILE.COM 248-388-6940	2-6 WEEKS
T5	SERVICE DRIVE LANE ACCENT	CROSSVILLE CROSS-TECH COLOR: GRAY WHITE A880CTS SIZE: 8 X 8 TEC POWER GROUT 934	TRACTION TILE FOR SERVICE DRIVE-IN	VIRGINIA TILE STEVE REINING CADILLACTILE@VIRGINIATILE.COM 248-388-6940	2-6 WEEKS
T6	SERVICE DEPARTMENT FLOOR SURFACES AND ALL TECH SUPPORT SPACES	CROSSVILLE CROSS - COLORS MINGLES COLOR: GREY MINGLE R001 CTS SIZE: 8 X 8 TEC POWER GROUT 934	TRACTION TILE FOR SERVICE DRIVE-IN	VIRGINIA TILE STEVE REINING CADILLACTILE@VIRGINIATILE.COM 248-388-6940	2-6 WEEKS
T7 T7B	SERVICE DEPARTMENT RESTROOMS	CROSSVILLE CROSS - COLORS MINGLES COLOR: GREY MINGLE R001 UPS SIZE: 8' X 8' TEC POWER GROUT 934 WITH COVE BASE	RESTROOM TILE	VIRGINIA TILE STEVE REINING CADILLACTILE@VIRGINIATILE.COM 248-388-6940	
EPX1	SERVICE DEPARTMENT EPOXY FLOOR ALTERNATE	SHERWIN WILLIAMS ARMORSEAL 1000 HS NON-SKID EPOXY COLOR TO MATCH BENJAMIN MOORE 2121-30 PEWTER	EPOXY FLOOR COVERING	LOCAL SHERWIN WILLIAMS PAINT SUPPLY STORE WWW.SHERWIN-WILLIAMS.COM OR EQUAL	
CF1	SERVICE WORKSHOP AND PARTS STORAGE AREA	CONCRETE WITH ASHFORD FORMULA CHEMICALLY PROCESSED CONCRETE	SEALER	CURECRETE DISTRIBUTION 800-698-5904	
VT1	FILE STORAGE, PRINT/COPY ROOMS, LUNCHROOM, TECH PARTS, NON CUSTOMER TOUCH POINTS	SHAW CONTRACT GROUP STRAND 0616V COLOR: SLT 1699S SIZE: 18 X 36	RESILIENT FLOOR AT NON CUSTOMER TOUCH POINTS	SHAW MATT HODGES@SHAWINC.COM	LIKELY IN STOCK, 12 WEEKS IF NOT
CPT1	CASUAL SALES AREAS, ENCLOSED OFFICES, HOSPITALITY	SHAW CONTRACT GROUP ARTISAN LCOM COLOR: ANGOR 86500	CARPET (TILE OR BROADLOOM) AT CLOSED OFFICES AND HOSPITALITY CARPET INSET	SHAW MATT HODGES@SHAWINC.COM	4-6 WEEKS
CPT2	NON CUSTOMER TOUCH POINTS	SHAW CONTRACT GROUP EMBARK TILE ST000 COLOR: MYTH 37505	CARPET AT NON CUSTOMER TOUCH POINTS SHAW	MATT HODGES MATTHEW.HODGES@SHAWINC.COM	2 WEEKS FOR 2550 BT OR LESS
WALLS					
PT1	INTERIOR WALLS IN SHOWROOM, CORRIDORS, AND DOORS EXCEPT WHERE ACCENT COLORS ARE USED	TO MATCH: BENJAMIN MOORE 2124-70 DISTANT GRAY R: 243 G: 244 B: 240	ECO SPEC WB INTERIOR GRADE LATEX PAINT, EGGSHELL FINISH ON WALLS, SEMI-GLOSS ON DOORS & WALL BASES	LOCAL BENJAMIN MOORE PAINT SUPPLY STORE WWW.BENJAMINMOORE.COM 1-866-708-9181	
PT2	PAINT ON RESTROOM ACCENT WALL (TYP. OPPOSITE WET WALL)	TO MATCH: BENJAMIN MOORE 1475 GRAYSTONE R: 153 G: 148 B: 240	ECO SPEC WB INTERIOR GRADE LATEX PAINT, EGGSHELL FINISH ON WALLS, SEMI-GLOSS ON DOORS	LOCAL BENJAMIN MOORE PAINT SUPPLY STORE WWW.BENJAMINMOORE.COM 1-866-708-9181	
PT3	SERVICE DEPARTMENT ACCENT PAINT	TO MATCH: BENJAMIN MOORE 2121-30 PEWTER R: 151 G: 156 B: 92	ECO SPEC WB INTERIOR GRADE LATEX PAINT, EGGSHELL FINISH ON WALLS, SEMI-GLOSS ON DOORS	LOCAL BENJAMIN MOORE PAINT SUPPLY STORE WWW.BENJAMINMOORE.COM 1-866-708-9181	
PT4	SERVICE DEPARTMENT ACCENT PAINT	TO MATCH: BENJAMIN MOORE 2124-30 IRON MOUNTAIN R: 86 G: 84 B: 92	ECO SPEC WB INTERIOR GRADE LATEX PAINT, EGGSHELL FINISH ON WALLS, SEMI-GLOSS ON DOORS	LOCAL BENJAMIN MOORE PAINT SUPPLY STORE WWW.BENJAMINMOORE.COM 1-866-708-9181	
WC1	WALL COVERING @ CUSTOMER TOUCH POINT AREAS AND OFFICES	MAHARAM TEK WALL PATTERN BRACE COLOR: 004	POLYOLEFIN, POLYESTER AND VINYL WALL COVERING WITH ACRYLIC BACKING AND PFDA-FREE STAIN RESISTANT FINISH	MICHELLE SCOTT MSCOTT@MAHARAM.COM 1-800-645-3543	9 WEEKS
WD1	SHOWROOM FEATURE WALL	RECONSTITUTED WALNUT VENEER LOG #73579 FSC (SEE CONTROL SAMPLE)	WOOD PANELING - WOOD GRAIN TO RUN IN HORIZONTAL ORIENTATION	ROB GIBSON RGIBSON@DOGOVEENEERS.COM (616) 971-5345	5 DAYS FOR IN STOCK RECON VENEER
CC1	EXPOSED COLUMNS IN CUSTOMER TOUCHPOINT AREAS	CFRG COLUMN COVERS MATCH COLOR TO PT1	EXPOSED COLUMN COVERING	FORMGLAS WWW.FORMGLAS.COM 1-866-635-8030	

NO.	LOCATION	COLOR & MATERIAL SPECIFICATIONS	DESCRIPTIONS	MANUFACTURER/ SUPPLIER	LEAD TIME
WB1	WALL BASE WHERE CUSTOMER TOUCHPOINT CARPET IS USED	CUSTOMER TOUCH POINTS WHERE PT01 OCCURS	WOOD WALL BASE TO MATCH ADJACENT WALL	OPEN	
VB1	NON-CUSTOMER TOUCH POINTS WHERE IS USED	JOHNSONITE 08 ICICLE	VINYL WALL BASE	JOHNSONITE WWW.JOHNSONITE.COM 1-800-699-8916	
GL1	NOT USED	N/A	N/A		
GL2	SHOWROOM AND SALES GLASS FRONT	FRAMELESS CLEAR GLASS W/ TOP & BOTTOM RECESSED CHANNEL ONLY	OFFICE STOREFRONT GLASS	OPEN	
GL3	SERVICE WRITER BACK WALL	MCGRORY GLASS DIGITALLY PRINTED WITH BACK COATING - GSDT - 178 COLOR: WHITE, 70% OPACITY	PRECISION PATTERN FILM AND BACKPAINTED TO MATCH PT2	MCGRORY GLASS - BRIANNA NASTASI (856) 579-3235 BRIANNA@MCGRORY.COM	5-6 WEEKS
GF-1	OFFICE GLASS FRONT FILM	3M DUSTED CRYSTAL	GLASS FILM	3M 3M.EUARCHITECTURALMARKETS 1-(888) 650-3497	
CEILINGS					
ACT1	ALL CUSTOMER TOUCHPOINT AREAS EXCEPT SHOWROOM AND SERVICE DRIVE	ULTIMA BEVELED TEGULAR 916 INTERLUDE GRID 2' x 2'	ACOUSTICAL PLANK CEILING	ARMSTRONG LISA CAVATAIO LYCAVATAIO@ARMSTRONGCEILINGS.COM (773) 882-0299	4 WEEKS
ACT2	NON-CUSTOMER AREAS OFFICES, NON-CUSTOMER TOUCH POINT AREAS	ULTIMA BEVELED TEGULAR 916 INTERLUDE GRID 2' x 2'	ACOUSTICAL TILE CEILING	ARMSTRONG LISA CAVATAIO LYCAVATAIO@ARMSTRONGCEILINGS.COM (773) 882-0299	5-7 DAYS
ACT3	SERVICE DRIVE	METAL 2X2 SNAP IN METAL PERFORATED CEILING 6285 COTTON WHITE FINISH WITH PERF 103 PATTERN 20% OPEN EXTERIOR CONDITION	2X2 SNAP IN APPLICATION	HUNTER DOUGLAS GAIL SALOFF 800-366-4327 X006	
GW6	SHOWROOM LOUNGE, MISCELLANEOUS CUSTOMER TOUCH POINT CEILINGS	GYPSUM WALL BOARD PAINTED P1	GYPSUM WALL BOARD	OPEN	
MILLWORK					
PL1	NON CUSTOMER TOUCH POINTS	FORMICA COLOR: 912-58 STORM MATTE FINISH	PLASTIC LAMINATE	(GLOBAL) DUNCAN BANKS DUNCAN.BANKS@FORMICA.COM (NATIONAL) MICHAEL HERTENSTEINER MICHAEL.HERTENSTEINER@FORMICA.COM	2 WEEKS (US)
PL2	BREAK ROOM CABINETS	FORMICA COLOR: 919-58 DOVER WHITE GLOSS FINISH	PLASTIC LAMINATE	(GLOBAL) DUNCAN BANKS DUNCAN.BANKS@FORMICA.COM (NATIONAL) MICHAEL HERTENSTEINER MICHAEL.HERTENSTEINER@FORMICA.COM	2 WEEKS (US)
PL3	BREAK ROOM COUNTER	FORMICA COLOR: 928-58 MOUSE MATTE FINISH	PLASTIC LAMINATE	(GLOBAL) DUNCAN BANKS DUNCAN.BANKS@FORMICA.COM (NATIONAL) MICHAEL HERTENSTEINER MICHAEL.HERTENSTEINER@FORMICA.COM	2 WEEKS (US)
PL4	RESTROOM COUNTER PANEL	FORMICA COLOR: 934-58 PEARL MATTE FINISH	PLASTIC LAMINATE	(GLOBAL) DUNCAN BANKS DUNCAN.BANKS@FORMICA.COM (NATIONAL) MICHAEL HERTENSTEINER MICHAEL.HERTENSTEINER@FORMICA.COM	2 WEEKS (US)
S82	BATHROOM COUNTER	CAMBRIA COLOR: FIELDSTONE	QUARTZ COUNTER AND BACKSPLASH	CAMBRIA KEVIN KEMP (231) 638-9546 KEMP@KEMPSURFACING.COM	#IN STOCK
WD1	MILLWORK	RECONSTITUTED WALNUT VENEER LOG #25146 FSC (SEE CONTROL SAMPLE)	MILLWORK - WOOD GRAIN TO RUN IN HORIZONTAL ORIENTATION	DOGOE VENEERS, INC. WWW.DOGOEVENEERS.COM 1-616-698-6450	5 DAYS FOR IN STOCK RECON VENEER
MISCELLANEOUS					
SS11	RESTROOMS	STAINLESS STEEL PARTITIONS	BATHROOM PARTITIONS	WWW.BOBIRICK.COM OR EQUAL	
MR1	RESTROOMS	MIRROR WITH EDGE LIGHT	RESTROOM MIRROR		
DPT1	CUSTOMER FACING DOOR PULLS	ROCKWOOD - LINEAMAX 96 LOCKABLE STRAIGHT PULL US 303 STAINLESS STEEL	DOOR PULLS	ROCKWOOD MANUFACTURING COMPANY WWW.ROCKWOODMFG.COM 1-814-626-2026	
FB3	NEW CAR DELIVERY	EDELMAN LUX-A-BULL COLOR: DARKEST BLUE LVB09	CUSHIONS	EDELMAN LEATHER GAIL CORCORAN GAIL@EDELMANLEATHER.COM (513) 404-7896	8-10 WEEKS IF NOT IN STOCK
FB4	NEW CAR DELIVERY	EDELMAN ROYAL HIDE COLOR: WAGON RED RH101	CUSHIONS	EDELMAN LEATHER GAIL CORCORAN GAIL@EDELMANLEATHER.COM (513) 404-7896	3-4 WEEKS IF NOT IN STOCK
FB5	NEW CAR DELIVERY	EDELMAN ROYAL HIDE COLOR: SUN BAKED RH126	CUSHIONS	EDELMAN LEATHER GAIL CORCORAN GAIL@EDELMANLEATHER.COM (513) 404-7896	3-4 WEEKS IF NOT IN STOCK
FG1	SHOWROOM, SERVICE DRIVE ENTRY	KD SERIES STAINLESS STEEL FLOOR GRATE K058	STAINLESS STEEL FLOOR GRATE	KADEE INDUSTRIES- WWW.KADEEINDUSTRIES.COM MIKE SCOTT (440) 639-8650 SALES@KADEEINDUSTRIES.COM	
RS1	SHOWROOM, OFFICES AT PERIMETER	THERMOVEX 2100 SERIES OPENNESS FACTOR 10%-15% DEPENDING ON LOCAL CONDITIONS TO MATCH 'SHADOW GREY'	MOTORIZED ROLLER SHADES	MECHOSHADE WWW.MECHOSHADE.COM	
PS1	SHOWROOM / LOUNGE DIVIDER	CUSTOM SYSTEM BY CPNY COMMERCIAL FILE OF NEW YORK	PRECISION SCREEN	COMMERCIAL FILE OF NEW YORK BRIAN DUNN BOUNN@COMMERCIALFILE.COM	

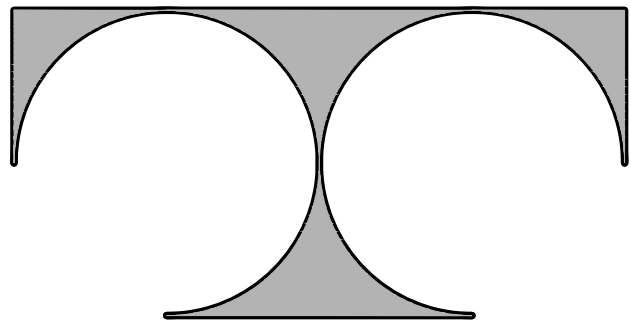

TDI ASSOCIATES, INC.
ARCHITECTURE & PLANNING

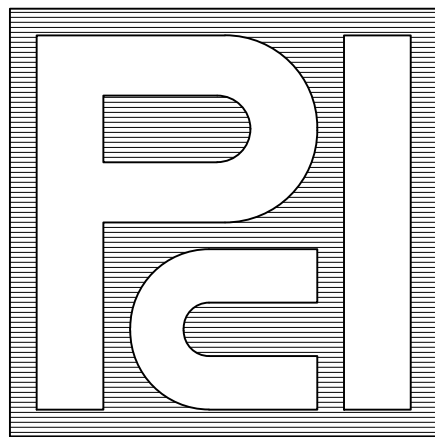25217 SOUTH WIND LAKE ROAD
WIND LAKE, WISCONSIN 53185
PHONE 262-409-2530



PROFESSIONAL
CONSULTANTS, INC.

133 HILL STREET
HARTLAND, WISCONSIN 53029
(262) 367-6080

BOUCHER CADILLAC
WAUKESHA

2145 EAST MORELAND BLVD.
WAUKESHA, WISCONSIN

©TDI ASSOCIATES, INC
All Rights Reserved

OWNERSHIP OF DOCUMENTS

This document, and the ideas and design incorporated herein, as an instrument of professional service, is the sole property of TDI Associates, Inc., and is not to be used in whole or in part for any other project or purpose without the expressed written authorization of TDI Associates, Inc.

Sheet Title
FINISH SCHEDULE

Issued For: Date:

Date: 06-23-2025

Job NO.: 23129.000

Drawn By: Draun By


Sheet No.

A4.2

Equipment Schedule


IMAGE	ITEM	LOCATION	MANUFACTURER / SUPPLIER	COLOR & MATERIAL SPECIFICATIONS	NOTES
PLUMBING FIXTURES & ACCESSORIES					
	TOP / UNDERMOUNT SINK	REFRESHMENT COUNTER	ELKAY	ELUHAD141455	SINGLE BOWL OPTION
	FAUCET	REFRESHMENT COUNTER	KOHLER	PURIST, K-7505 POLISHED CHROME	
	UNDERMOUNT SINK	RESTROOMS	KOHLER	VERTICAL, K-2882 WHITE FINISH	UNDERMOUNT SINK OPTION. SPECIFY COORDINATING FAUCET
	LAVATORY FAUCET	RESTROOMS	KOHLER	LOURE, K14661-4	FOR UNDERMOUNT SINK
	RESTROOM SOAP DISPENSER	RESTROOMS	KOHLER	K-1995	
	TOILET	RESTROOMS	KOHLER	SAN SOUCK, K-5172 WHITE FINISH	ONE-PIECE, TANK TOILET
	TOILET	RESTROOMS	KOHLER	KINGSTON, K-4325	WALL MOUNTED, FLUSH VALVE TOILET
	TOILET	RESTROOMS	KOHLER	HIGHLINE, K-4405	FLOOR MOUNTED, FLUSH VALVE TOILET
	URINAL	RESTROOMS	KOHLER	BARDON, K-4991-ET	WALL MOUNTED, FLUSH VALVE URINAL
	TOILET FLUSH VALVE	RESTROOMS	KOHLER	TRIPPOINT, K-7535-CP	AUTOMATIC FLUSH VALVE FOR TOILETS
	URINAL FLUSH VALVE	RESTROOMS	KOHLER	TRIPPOINT, K-7546	AUTOMATIC FLUSH VALVE FOR URINALS
	TOWEL DISPENSER / WASTE RECEPTACLE	RESTROOMS	BOBRICK	B-3603 FINISH STAINLESS STEEL	SATIN-
	TOWEL DISPENSER / WASTE RECEPTACLE	RESTROOMS	BOBRICK	B-36903 FINISH STAINLESS STEEL	SATIN-
	TOWEL DISPENSER / WASTE RECEPTACLE WITH AUTOMATIC HAND DRYER	RESTROOMS	BOBRICK	B-36030 FINISH STAINLESS STEEL	SATIN-
	WALL MOUNTED TOILET TISSUE DISPENSER	RESTROOMS	BOBRICK	B-3688 FINISH STAINLESS STEEL	SATIN-
	WALL MOUNTED TOILET TISSUE DISPENSER	RESTROOMS	BOBRICK	B-3688 FINISH STAINLESS STEEL	SATIN-
	RECESSED BABY CHANGING STATION	RESTROOMS	BOBRICK	KB110-SGR FINISH STAINLESS STEEL	SATIN-
	TOILET PARTITIONS	RESTROOMS	BRADLEY	SERIES 500 FINISH STAINLESS STEEL	SATIN-

IMAGE	ITEM	LOCATION	MANUFACTURER / SUPPLIER	COLOR & MATERIAL SPECIFICATIONS	NOTES
APPLIANCES					
	ADA COMPLIANT UNDERCOUNTER REFRIGERATOR	REFRESHMENT COUNTER	SUMMIT	SCR600BLBHVADA	COORDINATE INSTALLATION WITH ADJACENT MILLWORK
	ADA COMPLIANT PANEL READY UNDER-COUNTER DISHWASHER	REFRESHMENT COUNTER			PANEL TO MATCH WD-1 ADJACENT CABINETRY
	COFFEE MAKER	REFRESHMENT COUNTER			STAINLESS STEEL TO MATCH LOOK OF IMAGE
	BOTTLE FILLING STATION		ELKAY	LZW5-EDFPBM1J7K STAINLESS STEEL	STAINLESS STEEL TO MATCH LOOK OF IMAGE
DOOR & CABINET HARDWARE					
	DOOR PULL	ENTRY DOORS	ROCKWOOD ASSA ABL0Y	LINEAMAX STRAIGHT PULLS - SOLID FLAT ENDS 96" LENGTH	
	DOOR PULL	OFFICE DOORS	ROCKWOOD ASSA ABL0Y	LINEAMAX STRAIGHT PULLS - SOLID FLAT ENDS 96" LENGTH	
	DOOR PULL	STORAGE, NON CUSTOMER TOUCH POINT	SCHLAGE	LATITUDE LEVER	LOCKABLE WHERE NEEDED
	PUSH AND PULL PLATES	RESTROOM DOORS	ROCKWOOD ASSA ABL0Y	STAINLESS STEEL	
	CABINET PULL	REFRESHMENT COUNTER MILLWORK	DOUG MOCKET	8" ELEGANT BAR PULL POLISHED CHROME	
	TRASH GROMMET	REFRESHMENT COUNTER	DOUG MOCKET	SQUARE STAINLESS STEEL TRASH GROMMET	
MISCELLANEOUS					
	OUTLET COVERS	CUSTOMER TOUCHPOINT AREAS		FINISHED TO MATCH ADJACENT WALL SURFACE	
	OUTLET COVERS	REFRESHMENT COUNTER		BRUSHED STAINLESS STEEL FINISH	
	DOWNSPOUT COVER	EXTERIOR WALL	ZURN	Z199-DC STAINLESS STEEL FINISH	

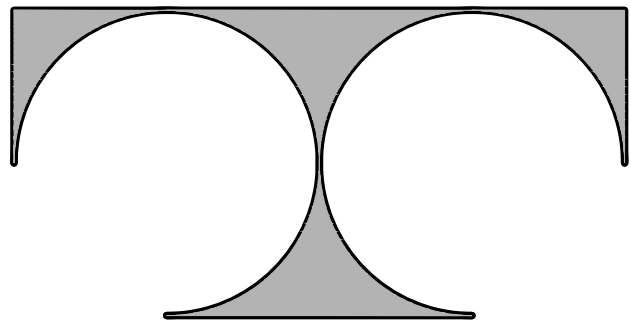

TDI ASSOCIATES, INC.
ARCHITECTURE & PLANNING

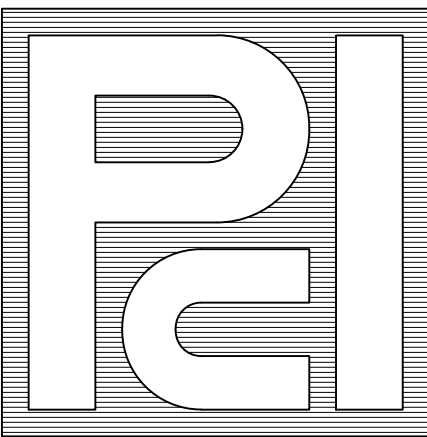25217 SOUTH WIND LAKE ROAD
WIND LAKE, WISCONSIN 53185
PHONE 262-409-2530



PROFESSIONAL
CONSULTANTS, INC.

133 HILL STREET
HARTLAND, WISCONSIN 53029
(262) 367-6080

BOUCHER CADILLAC
WAUKESHA

2145 EAST MORELAND BLVD.
WAUKESHA, WISCONSIN

©TDI ASSOCIATES, INC
All Rights Reserved

OWNERSHIP OF DOCUMENTS

This document, and the ideas and design incorporated herein, as an instrument of professional service, is the sole property of TDI Associates, Inc., and is not to be used in whole or in part for any other project or purpose without the expressed written authorization of TDI Associates, Inc.

Sheet Title
EQUIPMENT
SCHEDULE

Issued For: Date:

Date: 06-23-2025

Job NO.: 23129.000

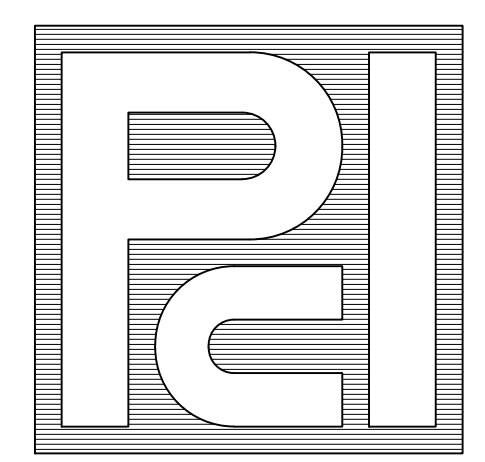
Drawn By: Draun By

Sheet No.

A4.3



1 FIRST FLOOR FURNITURE PLAN
1/8"=1'-0"



**BOUCHER CADILLAC
WAUKESHA**
2145 EAST MORELAND BLVD.
WAUKESHA, WISCONSIN

©TDI ASSOCIATES, INC
All Rights Reserved
OWNERSHIP OF DOCUMENTS

This document, and the ideas and design incorporated herein, as an instrument of professional service, is the sole property of TDI Associates, Inc., and is not to be used in whole or in part for any other project or purpose without the expressed written authorization of TDI Associates, Inc.

Sheet Title
**FIRST FLOOR
FURNITURE PLAN**

Issued For: _____ Date: _____

Date: **06-23-2025**














Job NO.: **23129.000**

Drawn By: _____ Drawn By











Sheet No.


A4.4

Furniture Schedule

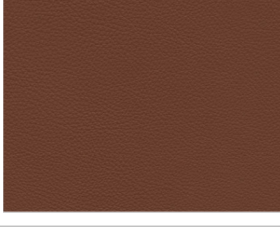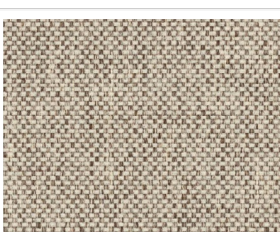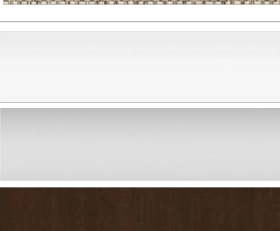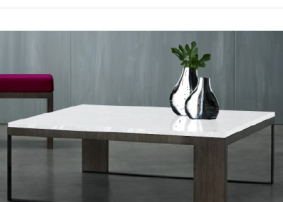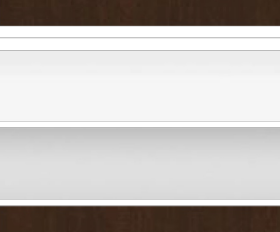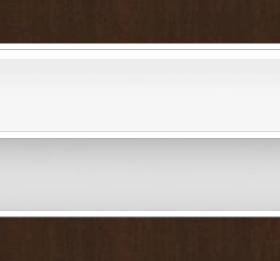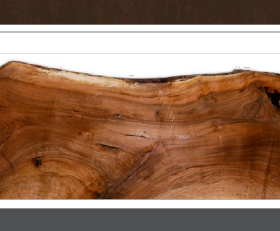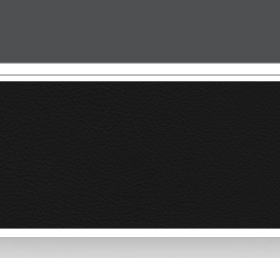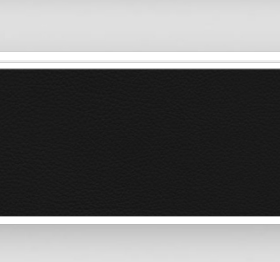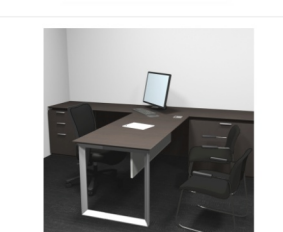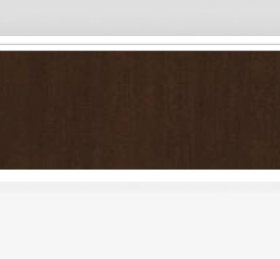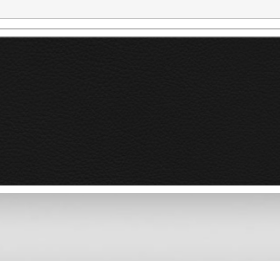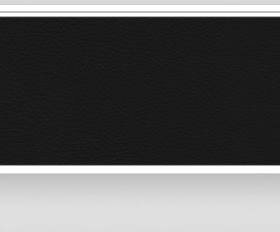PHOTO*	ITEM	DESIGNATION	LOCATION	FINISH		NAME	MANUFACTURER	SPECIFICATION
PREFERRED OPTIONS								
	SOFA (L OR STRAIGHT CONFIGURATION)	SF1	DISPLAY HOSPITALITY	FORDHAM LEATHER CARMEL #FORD-1100 (SEAT AND BACK) BRUSHED NICKEL BASE (LEGS)		B.1	BERNHARDT CONTACT: BONNIE BOBRICH STELLAGROUP@STELLAGROUPINC.COM (734) 558-1075	PROPRIETARY
	SOFA PILLOWS		DISPLAY HOSPITALITY (FOR USE WITH SF1 ONLY)	30969 GYPSOS JACQUARD RUBELLI VENEZIA		PILLOW UPHOLSTERED WITH RUBELLI VENEZIA GYPSOS-ORO	FABRICATOR OF DEALER'S CHOOSING USING SPECIFIED FABRIC	PROPRIETARY
	LOUNGE CHAIR	CH1 (ALT)	DISPLAY CONCIERGE HOSPITALITY	STINSON DUET 63733 SUGAR AND SPICE DARK OAK (FRAME AND LEGS)		CRUISE CHAIR 6305	CABOT WRENN CONTACT: RYAN STITES RSTITES@CABOTWRENN.COM	PROPRIETARY
	COFFEE TABLE	TB1	DISPLAY CONCIERGE HOSPITALITY	WHITE GLASS (TOP) POLISHED STAINLESS (LEGS) WALNUT M33 MOCHA		EMME COFFEE TABLE 42" X 42" X 14"	NUCRAFT CONTACT: JEFF LARSON JEFF@FACILITECHSOLUTIONS.COM	PROPRIETARY
	COFFEE TABLE	TB2	DISPLAY CONCIERGE HOSPITALITY	WHITE GLASS (TOP) POLISHED STAINLESS (LEGS) WALNUT M33 MOCHA (ACCENT)		EMME COFFEE TABLE 36" X 36" X 14"	NUCRAFT CONTACT: JEFF LARSON JEFF@FACILITECHSOLUTIONS.COM	PROPRIETARY
	SIDE TABLE	TB3	DISPLAY CONCIERGE HOSPITALITY	WHITE GLASS (TOP) POLISHED STAINLESS (LEGS) WALNUT M33 MOCHA (ACCENT)		EMME SIDE TABLE 20" X 20" X 20"	NUCRAFT CONTACT: JEFF LARSON JEFF@FACILITECHSOLUTIONS.COM	PROPRIETARY
	STANDING HEIGHT TABLE INCLUDES UNDERMOUNT POWER/DATA	TB4	HOSPITALITY	LIVE EDGE SOLID WALNUT WOOD (TOP) STEEL PAINTED BLACK (LEGS)		DARRAN GROVE LIVE EDGE TABLE 120" LENGTH (UNLESS OTHERWISE NOTED ON THE DRAWINGS) (2) POWER/USB MODULES PER TABLE - BLACK VERTICAL / HORIZONTAL WIRE MANAGEMENT - BLACK	MCREADY & ASSOCIATES CONTACT: NICK PICCIONE PICCIONE1011@GMAIL.COM (313) 701-3300	PROPRIETARY
	BAR HEIGHT STOOL	CH2	HOSPITALITY	POLISHED FULL GRAIN BLACK LEATHER (UPHOLSTERY) POLISHED CHROME (LEGS)		LINEAL COMFORT STOOL (30" SEAT HEIGHT)	ANDREU WORLD BQ-0599 CONTACT: MICHAEL PAYNE MPAYNE@6427@AOL.COM	PROPRIETARY
	CONCIERGE CHAIR	CH3	CONCIERGE	POLISHED FULL GRAIN BLACK LEATHER (UPHOLSTERY) POLISHED CHROME (LEGS)		LINEAL COMFORT CHAIR (26" SEAT HEIGHT)	ANDREU WORLD BQ-0604 CONTACT: MICHAEL PAYNE MPAYNE@6427@AOL.COM	PROPRIETARY
	OFFICE DESK WITH CLEAR ANODIZED GROMMET AND CONCEALED WIRE MANAGEMENT	DSK1	DISPLAY NEW CAR DELIVERY	WALNUT M33 MOCHA MODESTY PANEL - CLOUD PAINT		CAMBUM	NUCRAFT CONTACT: J JEFF LARSON JEFF@FACILITECHSOLUTIONS.COM	PROPRIETARY
	OFFICE CHAIR	CH4	DISPLAY NEW CAR DELIVERY	POLISHED FULL GRAIN BLACK LEATHER (UPHOLSTERY) POLISHED ALUMINUM (LEGS)		EAMES ALUMINUM GROUP EXECUTIVE CHAIR	HERMAN MILLER	PROPRIETARY
	GUEST CHAIR	CH5	DISPLAY NEW CAR DELIVERY	FINESSE-BLACK LEATHER (UPHOLSTERY) POLISHED STAINLESS STEEL (LEGS)		CELON	BERNHARDT DESIGN CONTACT: BONNIE BOBRICH STELLAGROUP@STELLAGROUPINC.COM (734) 558-1075	PROPRIETARY


*NOTE: PHOTOS ILLUSTRATE THE FORM AND SHAPE OF THE FURNITURE ONLY. REFER TO THE FINISH COLUMN FOR REQUIRED FINISH MATERIALS. FURNITURE PACKAGE TO BE SUBMITTED TO CADILLAC FOR REVIEW AND APPROVAL PRIOR TO ORDERING FURNITURE.

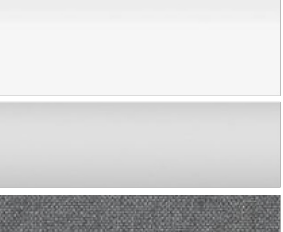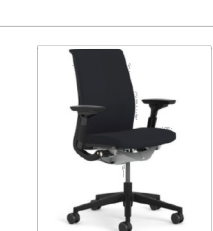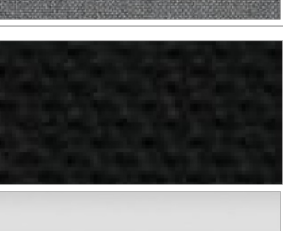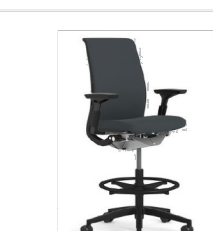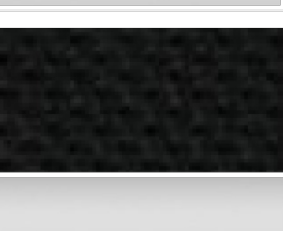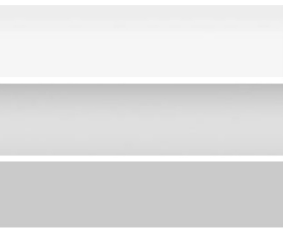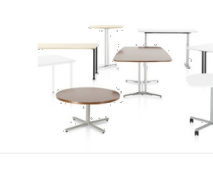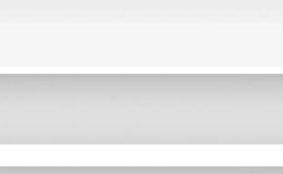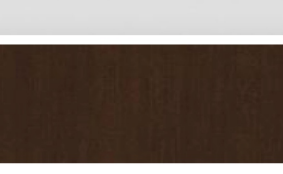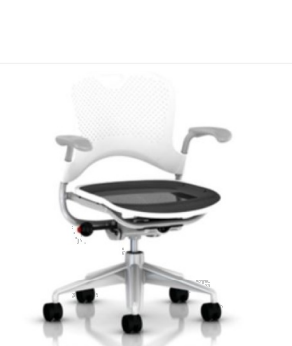PHOTO*	ITEM	DESIGNATION	LOCATION	FINISH		NAME	MANUFACTURER	SPECIFICATION
BACK OF HOUSE FURNITURE								
	OPEN WORKSTATIONS 6'X6' L-SHAPE	DSK2	NON-CUSTOMER OPEN AREAS	WHITE LAMINATE (SURFACE) FROSTED ACRYLIC (MODESTY PANEL) METALLIC SILVER (LEGS) GREY (CENTER FABRIC PANEL)		CANVAS DESKING	HERMAN MILLER	**OPEN
	TASK CHAIR	CH6	NON-CUSTOMER OPEN AREAS	BLACK UPHOLSTERY SILVER FRAME		THINK CHAIR	STEELCASE	**OPEN
	TASK STOOL	CH7	SERVICE WRITER STATIONS AND NON-CUSTOMER OPEN AREAS	BLACK UPHOLSTERY POLISHED ALUMINUM		THINK STOOL	STEELCASE	**OPEN
	CAFÉ CHAIR	CH8	BREAK ROOM, PANTRY AREA	STUDIO WHITE (MOLDED SEAT AND BACK) METALLIC SILVER (FRAME) FOG (ARM AND PLUG)		CAPER CHAIR	HERMAN MILLER	**OPEN
	SQUARE TOP CAFÉ TABLE WITH SINGLE COLUMN BASE AND GLIDES	TB5	BREAK/PANTRY AREA	STUDIO WHITE LAMINATE (TOP) METALLIC SILVER M5 (BASE)		EVERYWHERE TABLE	HERMAN MILLER	**OPEN
	CONFERENCE TABLE	TB6	CONFERENCE ROOM	POLISHED ALUMINUM (FOOT AND BRIDGE) PLATINUM METALLIC (COLUMN) MIDTOWN WALNUT (TOP)		DOCK MEETING TABLE	KIMBALL	**OPEN
	TRAINING TABLE WITH GLACIER RESIN MODESTY PANEL WHITE AND GREY CASTERS	TB7	TRAINING ROOM	STUDIO WHITE OR COOL GREY NATURAL (TOP) METALLIC SILVER (BASE) WARM GREY NEUTRAL LAMINATE (MODESTY PANEL)		EVERYWHERE TRAINING TABLE	HERMAN MILLER	**OPEN
	TRAINING CHAIR ON CASTERS WITH ARMS FLENNET SEAT	CH9	TRAINING ROOM	STUDIO WHITE OR BLACK (SEAT AND BACK) FLENNET SILVER GREY (BEAT) METALLIC SILVER (FRAME) FOG (ARM)		CAPER CHAIR	HERMAN MILLER	**OPEN
	GUEST CHAIR	CH10	NON CUSTOMER TOUCH POINT WORKSTATIONS	WALNUT FRAME MAHARAM MESSENGER - CLOUD 458840-031		NESSERLARMCHAIR	HERMAN MILLER	**OPEN

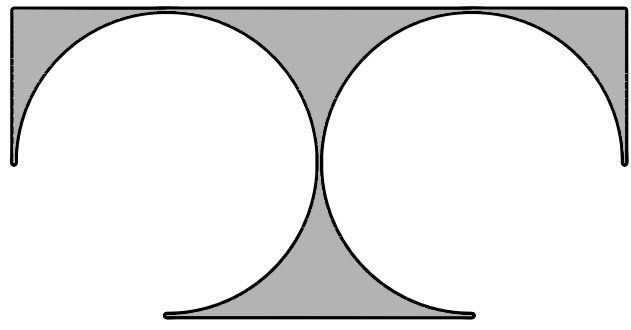

TDI ASSOCIATES, INC.
ARCHITECTURE & PLANNING

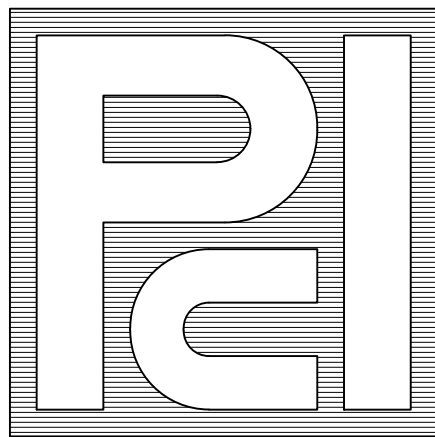25217 SOUTH WIND LAKE ROAD
WIND LAKE, WISCONSIN 53185
PHONE 262-409-2530



PROFESSIONAL
CONSULTANTS, INC.

133 HILL STREET
HARTLAND, WISCONSIN 53029
(262) 367-6080

BOUCHER CADILLAC
WAUKESHA

2145 EAST MORELAND BLVD.
WAUKESHA, WISCONSIN

©TDI ASSOCIATES, INC
All Rights Reserved

OWNERSHIP OF DOCUMENTS

This document, and the ideas and design incorporated herein, as an instrument of professional service, is the sole property of TDI Associates, Inc., and is not to be used in whole or in part for any other project or purpose without the expressed written authorization of TDI Associates, Inc.

Sheet Title
FURNITURE
SCHEDULE

Issued For: Date:

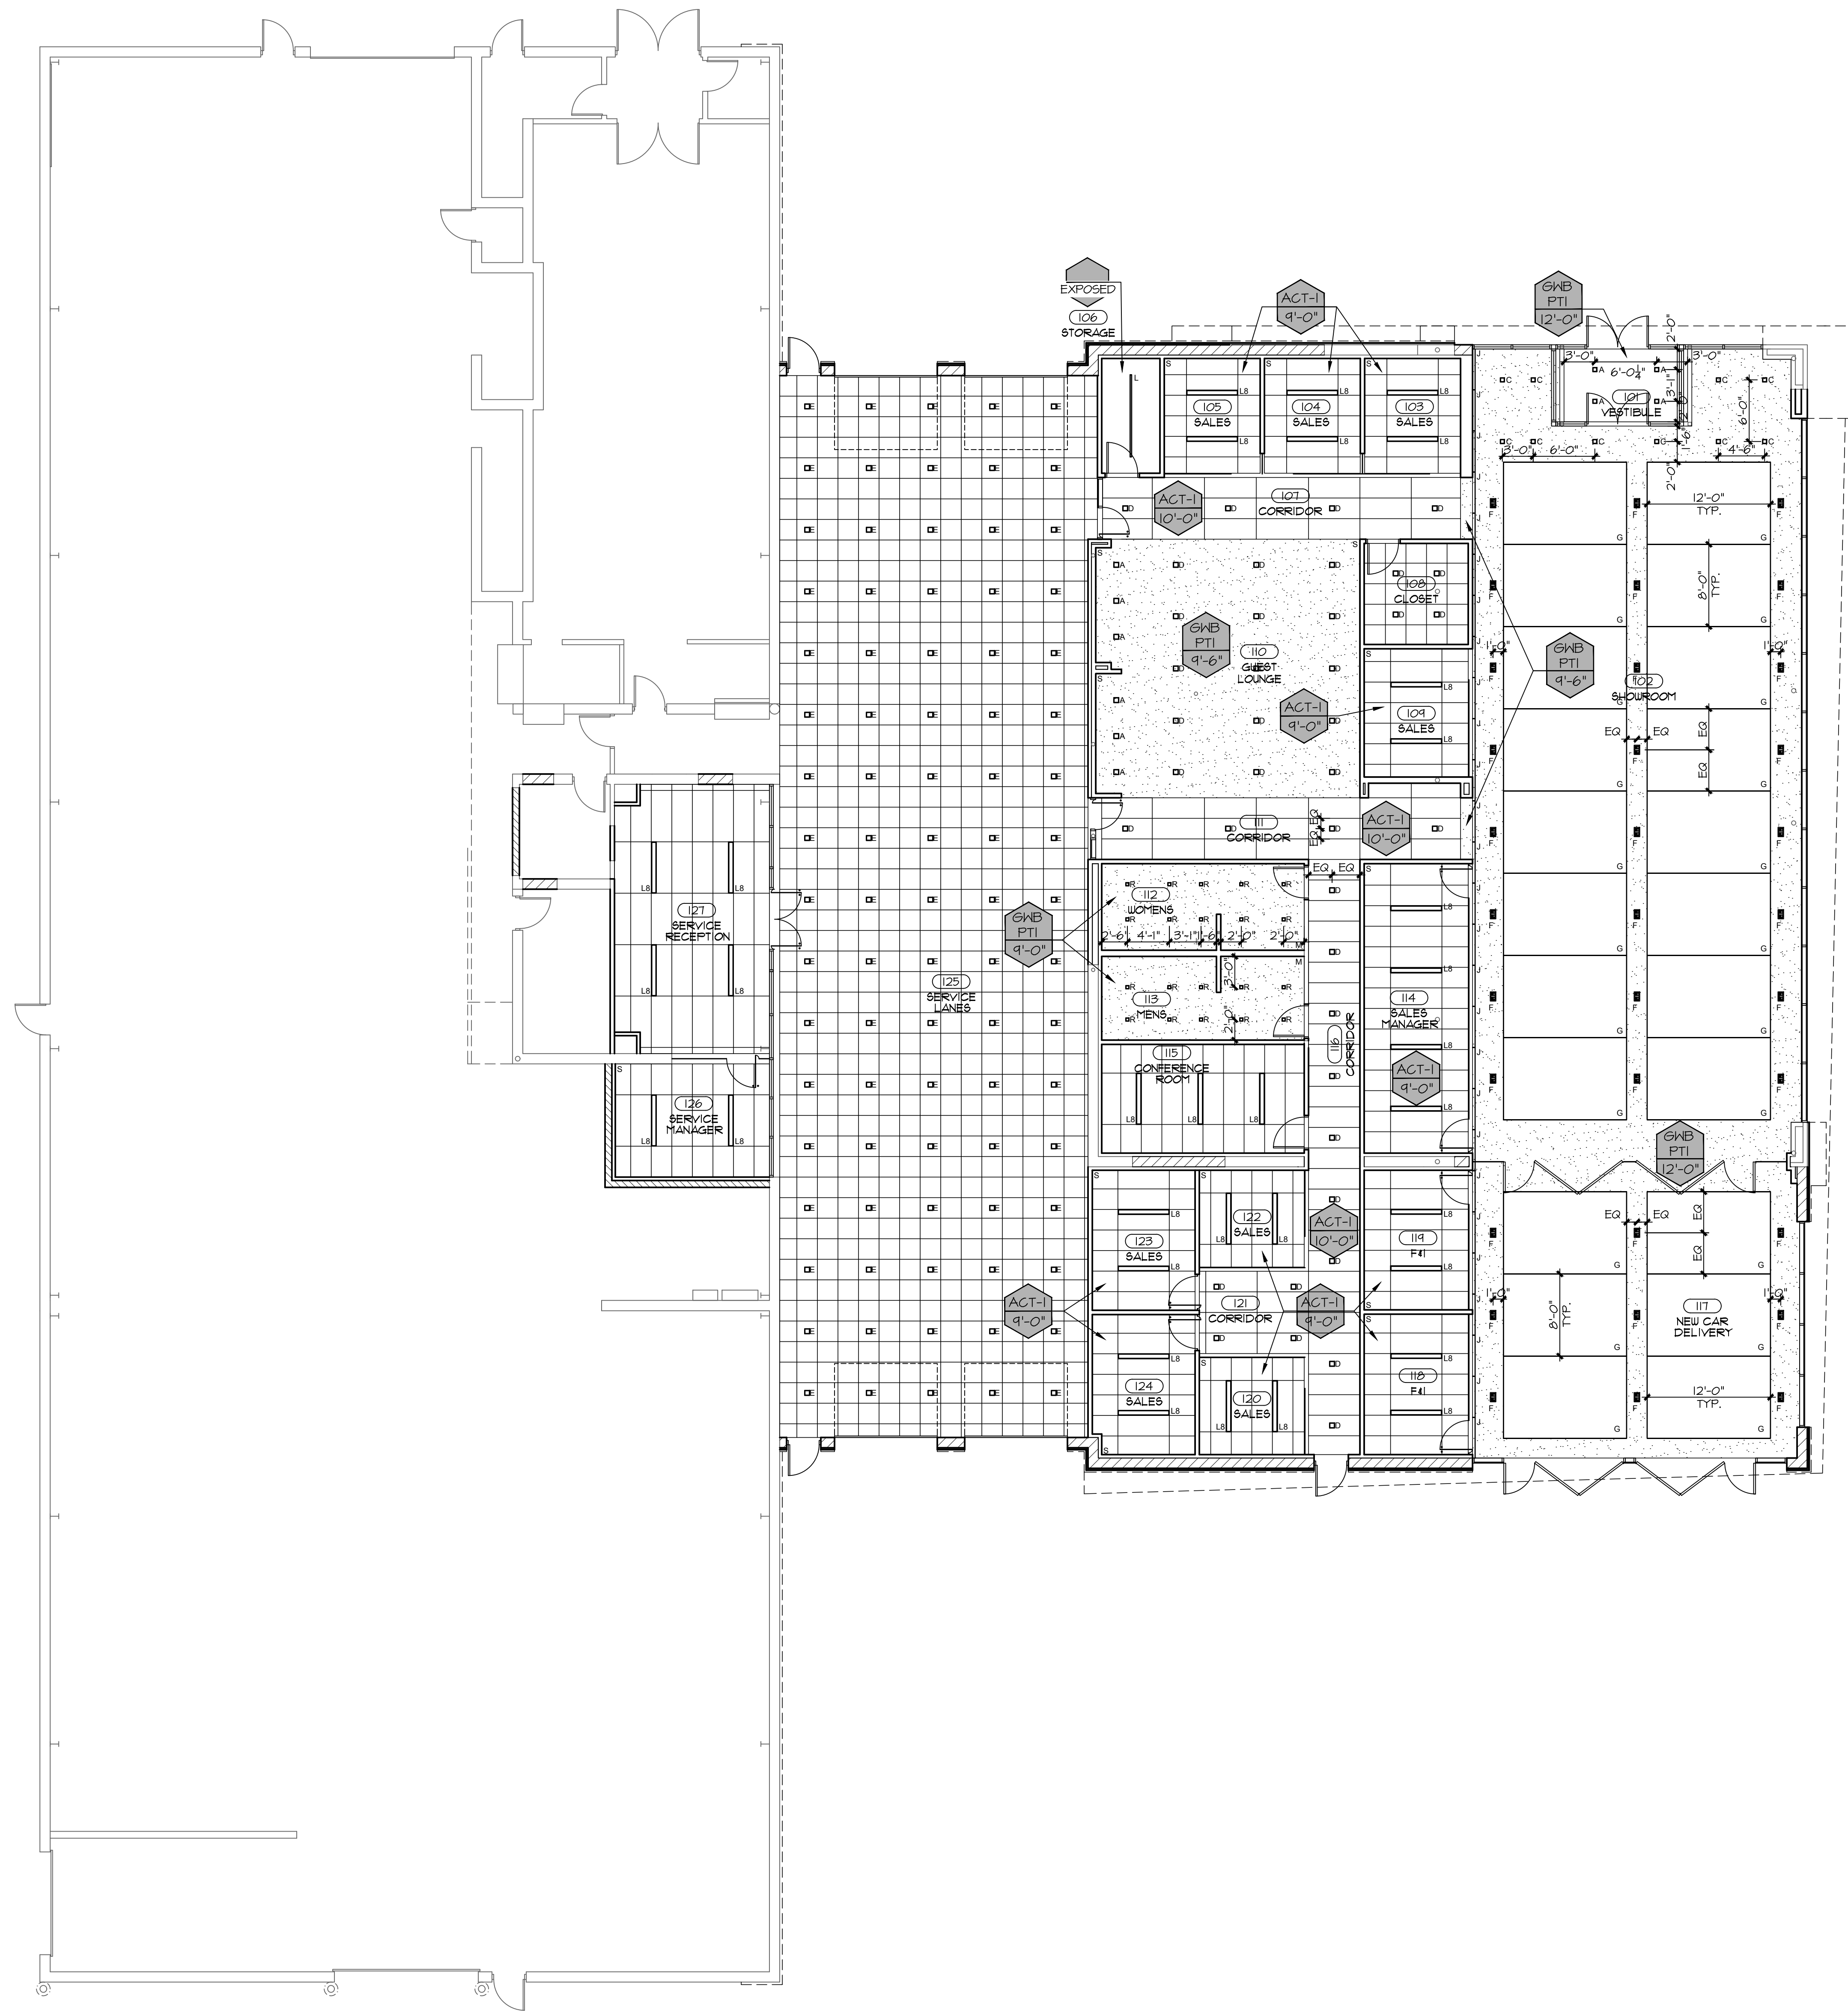
Date: 06-23-2025

Job NO.: 23129.000

Drawn By: Draun By

Sheet No.

A4.5



1 FIRST FLOOR
REFLECTED CEILING PLAN
1/8"=1'-0" NORTH

CEILING KEY		
TAG	DESCRIPTION	SYMBOL
ACT-1 HGT.	ACT-1 2'x5' ACOUSTICAL PLANK CEILING REFER TO INTERIOR FINISH SCHEDULE FOR SPECIFICS	
ACT-2 HGT.	ACT-2 2'x2' ACOUSTICAL CEILING TILE REFER TO INTERIOR FINISH SCHEDULE FOR SPECIFICS	
ACT-3 HGT.	ACT-3 2'x2' METAL SNAP IN PERFORATED CEILING REFER TO INTERIOR FINISH SCHEDULE FOR SPECIFICS	
GWB PAINT HGT.	5/8" GWB REFER TO INTERIOR FINISH SCHEDULE FOR PAINT SPECIFICS	
EXPOSED	EXPOSED STRUCTURE	



BOUCHER CADILLAC
WAUKESHA

2145 EAST MORELAND BLVD
WAUKESHA, WISCONSIN

©TDI ASSOCIATES, INC
All Rights Reserved

OWNERSHIP OF DOCUMENTS

This document, and the ideas and design incorporated herein, as an instrument of professional service, is the sole property of TDI Associates, Inc., and is not to be used in whole or in part for any other project or purpose without the expressed written authorization of TDI Associates, Inc.

Issued For: _____ Date: _____

Sheet No.

A6.2

Image	Label	Description	Location	Manufacturer	Lighting Source	Source Type	Integrated Optics	Optics Type	Optic Orientation	CRI	CCT	Driver	Wiring	Finish	Mounting	Aesthetics	Electrical Listing(s)	Surge Endurance	Potential Alternate
	A	RECESSED DOWNLIGHT	MAIN ENTRY + SHOWROOM	DMF LIGHTING	SOLID STATE	LED	YES	FIXED DISCRETE	ZENITH	90 MIN - 2 STEP SDCM	4100K	DEDICATED	MODULAR	WHITE	RECESSED FLUSH	DISCRETE NO VISIBLE GASKETS OR SEAMS	UL, CEC LISTED, U.L. VET LISTED FOR EXTERIOR	IEEE C62.41	SOLAIS
	B	EXTERIOR LINEAR LED	FRONT FAÇADE	ORGANIC LIGHTING SYSTEMS	SOLID STATE	LED	YES	FIXED PER SPECIFIC DESIGN	11 DEGREES	90 MIN - 2 STEP SDCM	4100K	DEDICATED	MODULAR	WHITE	SURFACE MOUNT CONCEALED	CONCEALED ASYMETRIC CONTINUOUS	UL, TITLE 24 COMPLIANT, CEC LISTED, U.L. VET FOR EXTERIOR REQUIRED	IEEE C62.41	AXIS
	C	RECESSED DOWNLIGHT	SHOWROOM	DMF LIGHTING	SOLID STATE	LED	YES	FIXED DISCRETE	ZENITH	90 MIN - 2 STEP SDCM	4100K	DEDICATED	MODULAR	WHITE	RECESSED FLUSH	DISCRETE NO VISIBLE GASKETS OR SEAMS	UL, TITLE 24 COMPLIANT, CEC LISTED	IEEE C62.41	SOLAIS
	D	RECESSED DOWNLIGHT	CIRCULATION AND CASHIER	DMF LIGHTING	SOLID STATE	LED	YES	FIXED DISCRETE	ZENITH	90 MIN - 2 STEP SDCM	4100K	DEDICATED	MODULAR	WHITE	RECESSED FLUSH	DISCRETE NO VISIBLE GASKETS OR SEAMS	UL, TITLE 24 COMPLIANT, CEC LISTED, U.L. VET FOR EXTERIOR REQUIRED	IEEE C62.41	SOLAIS
	E	RECESSED DOWNLIGHT	SERVICE DRIVE	DMF LIGHTING	SOLID STATE	LED	YES	FIXED DISCRETE	ZENITH	90 MIN - 2 STEP SDCM	4100K	DEDICATED	MODULAR	WHITE	RECESSED FLUSH	DISCRETE NO VISIBLE GASKETS OR SEAMS	UL, TITLE 24 COMPLIANT, CEC LISTED	IEEE C62.41	
	F	RECESSED ADJUSTABLE MULTI OPTIC	SHOWROOM CAR RUNWAY	SPECTRUM	SOLID STATE	LED	YES	PROGRAM ADJUSTABLE 18	MULTIPLE TRI-AXIS	90 MIN - 2 STEP SDCM	4100K	DEDICATED	MODULAR	WHITE	RECESSED FLUSH	RECESSED MULTI ACCENT DISCRETE RECTALINEAR	UL, TITLE 24 COMPLIANT, CEC LISTED	IEEE C62.41	JUNO LIGHTING
	G	AMBIENT MODULAR DESIGNER EDGE (SIZE 12 X 8 UNLESS OTHERWISE INDICATED ON FINAL DESIGN PACKAGE)	SHOWROOM + NEW CAR DELIVERY	BITRO + AXIONNOVA	SOLID STATE	LED	YES	FIXED	AMBIENT ZENITH	90 MIN - 2 STEP SDCM	4100K	DEDICATED	MODULAR	WHITE	RECESSED MICRO FLUSH	INTERNAL AMBIENT WITH ACYLIC DIFFUSION	UL, TITLE 24 COMPLIANT, CEC LISTED	IEEE C62.41	NONE (MANDATED SPEC)
		COOLEEDGE SPECIALTY ILLUMINATION SOLUTION - SIZE TO FIT	SHOWROOM + NEW CAR DELIVERY	COOLEEDGE LIGHTING INC.	SOLID STATE	LED	YES	FIXED	AMBIENT ZENITH	90 MIN - 2 STEP SDCM	4100K	DEDICATED	MODULAR	WHITE	FLUSH MOUNT	ILLUMINATED STRETCHED FABRIC	UL, TITLE 24 COMPLIANT, CEC LISTED	IEEE C62.41	
	H	MULTI OPTIC INTEGRATED MODULE OUTBOARD	SHOWROOM	SPECTRUM	SOLID STATE	LED	YES	PROGRAM ADJUSTABLE LINEAR	MULTIPLE TRI-AXIS	90 MIN - 2 STEP SDCM	4100K	DEDICATED	MODULAR	WHITE	RECESSED FLUSH	ARCHITECTURAL PERFORATED PANEL WITH INDEX	UL, TITLE 24 COMPLIANT, CEC LISTED	IEEE C62.41	AMERLUX
	I	MULTI OPTIC INTEGRATED MODULE INBOARD	SHOWROOM	AMERLUX LIGHTING	SOLID STATE	LED	YES	PROGRAM ADJUSTABLE	MULTIPLE TRI-AXIS	90 MIN - 2 STEP SDCM	4100K	DEDICATED	MODULAR	WHITE	RECESSED FLUSH	ARCHITECTURAL PERFORATED PANEL WITH INDEX	UL, TITLE 24 COMPLIANT, CEC LISTED	IEEE C62.41	AMERLUX
	J	CONCEALED, SOFT GLOW OPTIC	SHOWROOM WOOD WALL COVE	AXIS LIGHTING	SOLID STATE	LED	YES	FIXED	FIXED 11 DEGREES	90 MIN - 2 STEP SDCM	4100K	DEDICATED	MODULAR	WHITE	SURFACE CONCEALED	CONCEALED WITH BEAM CONDITIONER	UL, TITLE 24 COMPLIANT, CEC LISTED	IEEE C62.41	FAHRENHEIT
	K	SUSPENDED LINEAR	SERVICE AREA	VISIONAIRE LIGHTING	SOLID STATE	LED	YES	FIXED	FIXED X 11 DEGREES	90 MIN - 2 STEP SDCM	4100K	DEDICATED	MODULAR	WHITE	SUSPENDED / SURFACE	DIE CAST ARCHITECTURAL ALUMINUM	UL, TITLE 24 COMPLIANT, CEC LISTED	IEEE C62.41	SOLAIS
	L	SUSPENDED LINEAR TASK	SERVICE AREA, TASK	LAMAR LIGHTING	SOLID STATE	LED	YES	FIXED	FIXED X 10 DEGREES	90 MIN - 2 STEP SDCM	4100K	DEDICATED	MODULAR	WHITE	SUSPENDED	FABRICATED STEEL LINEAR LENS	UL, TITLE 24 COMPLIANT, CEC LISTED	IEEE C62.41	DMF LIGHTING
	LA	RECESSED DOWNLIGHT	BOH	DMF LIGHTING	SOLID STATE	LED	YES	FIXED	ZENITH	90 MIN - 2 STEP SDCM	4100K	DEDICATED	MODULAR	WHITE	RECESSED	DISCRETE NO VISIBLE GASKETS OR SEAMS	UL, TITLE 24 COMPLIANT, CEC LISTED	IEEE C62.41	SOLAIS
	LB	RECESSED GRID, SOFT GLOW OPTIC	SALES OFFICES	AXIS LIGHTING	SOLID STATE	LED	YES	FIXED AMBIENT	ZENITH	90 MIN - 2 STEP SDCM	4100K	DEDICATED	MODULAR	WHITE	RECESSED	INTERIOR AMBIENT SEAMLESS	UL, TITLE 24 COMPLIANT, CEC LISTED	IEEE C62.41	FAHRENHEIT
	M	RECESSED CONCEALED WALL SLOT	RESTROOMS	AXIS LIGHTING	SOLID STATE	LED	YES	FIXED	ZENITH	90 MIN - 2 STEP SDCM	4100K	DEDICATED	MODULAR	WHITE	RECESSED	RECESSED CONTINUOUS LINEAR SOFT FLOW	UL, TITLE 24 COMPLIANT, CEC LISTED	IEEE C62.41	LITECONTROL
	N	RECESSED DOWNLIGHT, DISCREET OPTIC	SERVICE WRITERS + RETAIL PARTS	DMF LIGHTING	SOLID STATE	LED	YES	FIXED	ZENITH	90 MIN - 2 STEP SDCM	4100K	DEDICATED	MODULAR	WHITE	RECESSED	DISCRETE NO VISIBLE GASKETS OR SEAMS	UL, TITLE 24 COMPLIANT, CEC LISTED	IEEE C62.41	SOLAIS
	O	INTEGRATED ELECTRIC BACKLIGHT MIRROR	RESTROOMS	ELECTRIC MIRROR	SOLID STATE	LED	YES	N/A	N/A	90 MIN	4100K	DEDICATED	STANDARD	PAINTED WHITE PAF	SURFACE	SURFACE MOUNT NO VISIBLE HARDWARE	UL LISTED	IEEE C62.41	

* NOTE: WITH THE EXCEPTION OF ITEM G (WHICH IS A MANDATED SPECIFICATION), ALTERNATE MANUFACTURERS MAY BE USED PROVIDED EQUIPMENT MEETS ALL THE PERFORMANCE CRITERIA SPECIFIED IN THIS SCHEDULE.
LIGHT SCHEDULE TO BE SUBMITTED TO CADILLAC FOR REVIEW AND APPROVAL PRIOR TO ORDERING LIGHT FIXTURES.