


NOT FOR CONSTRUCTION

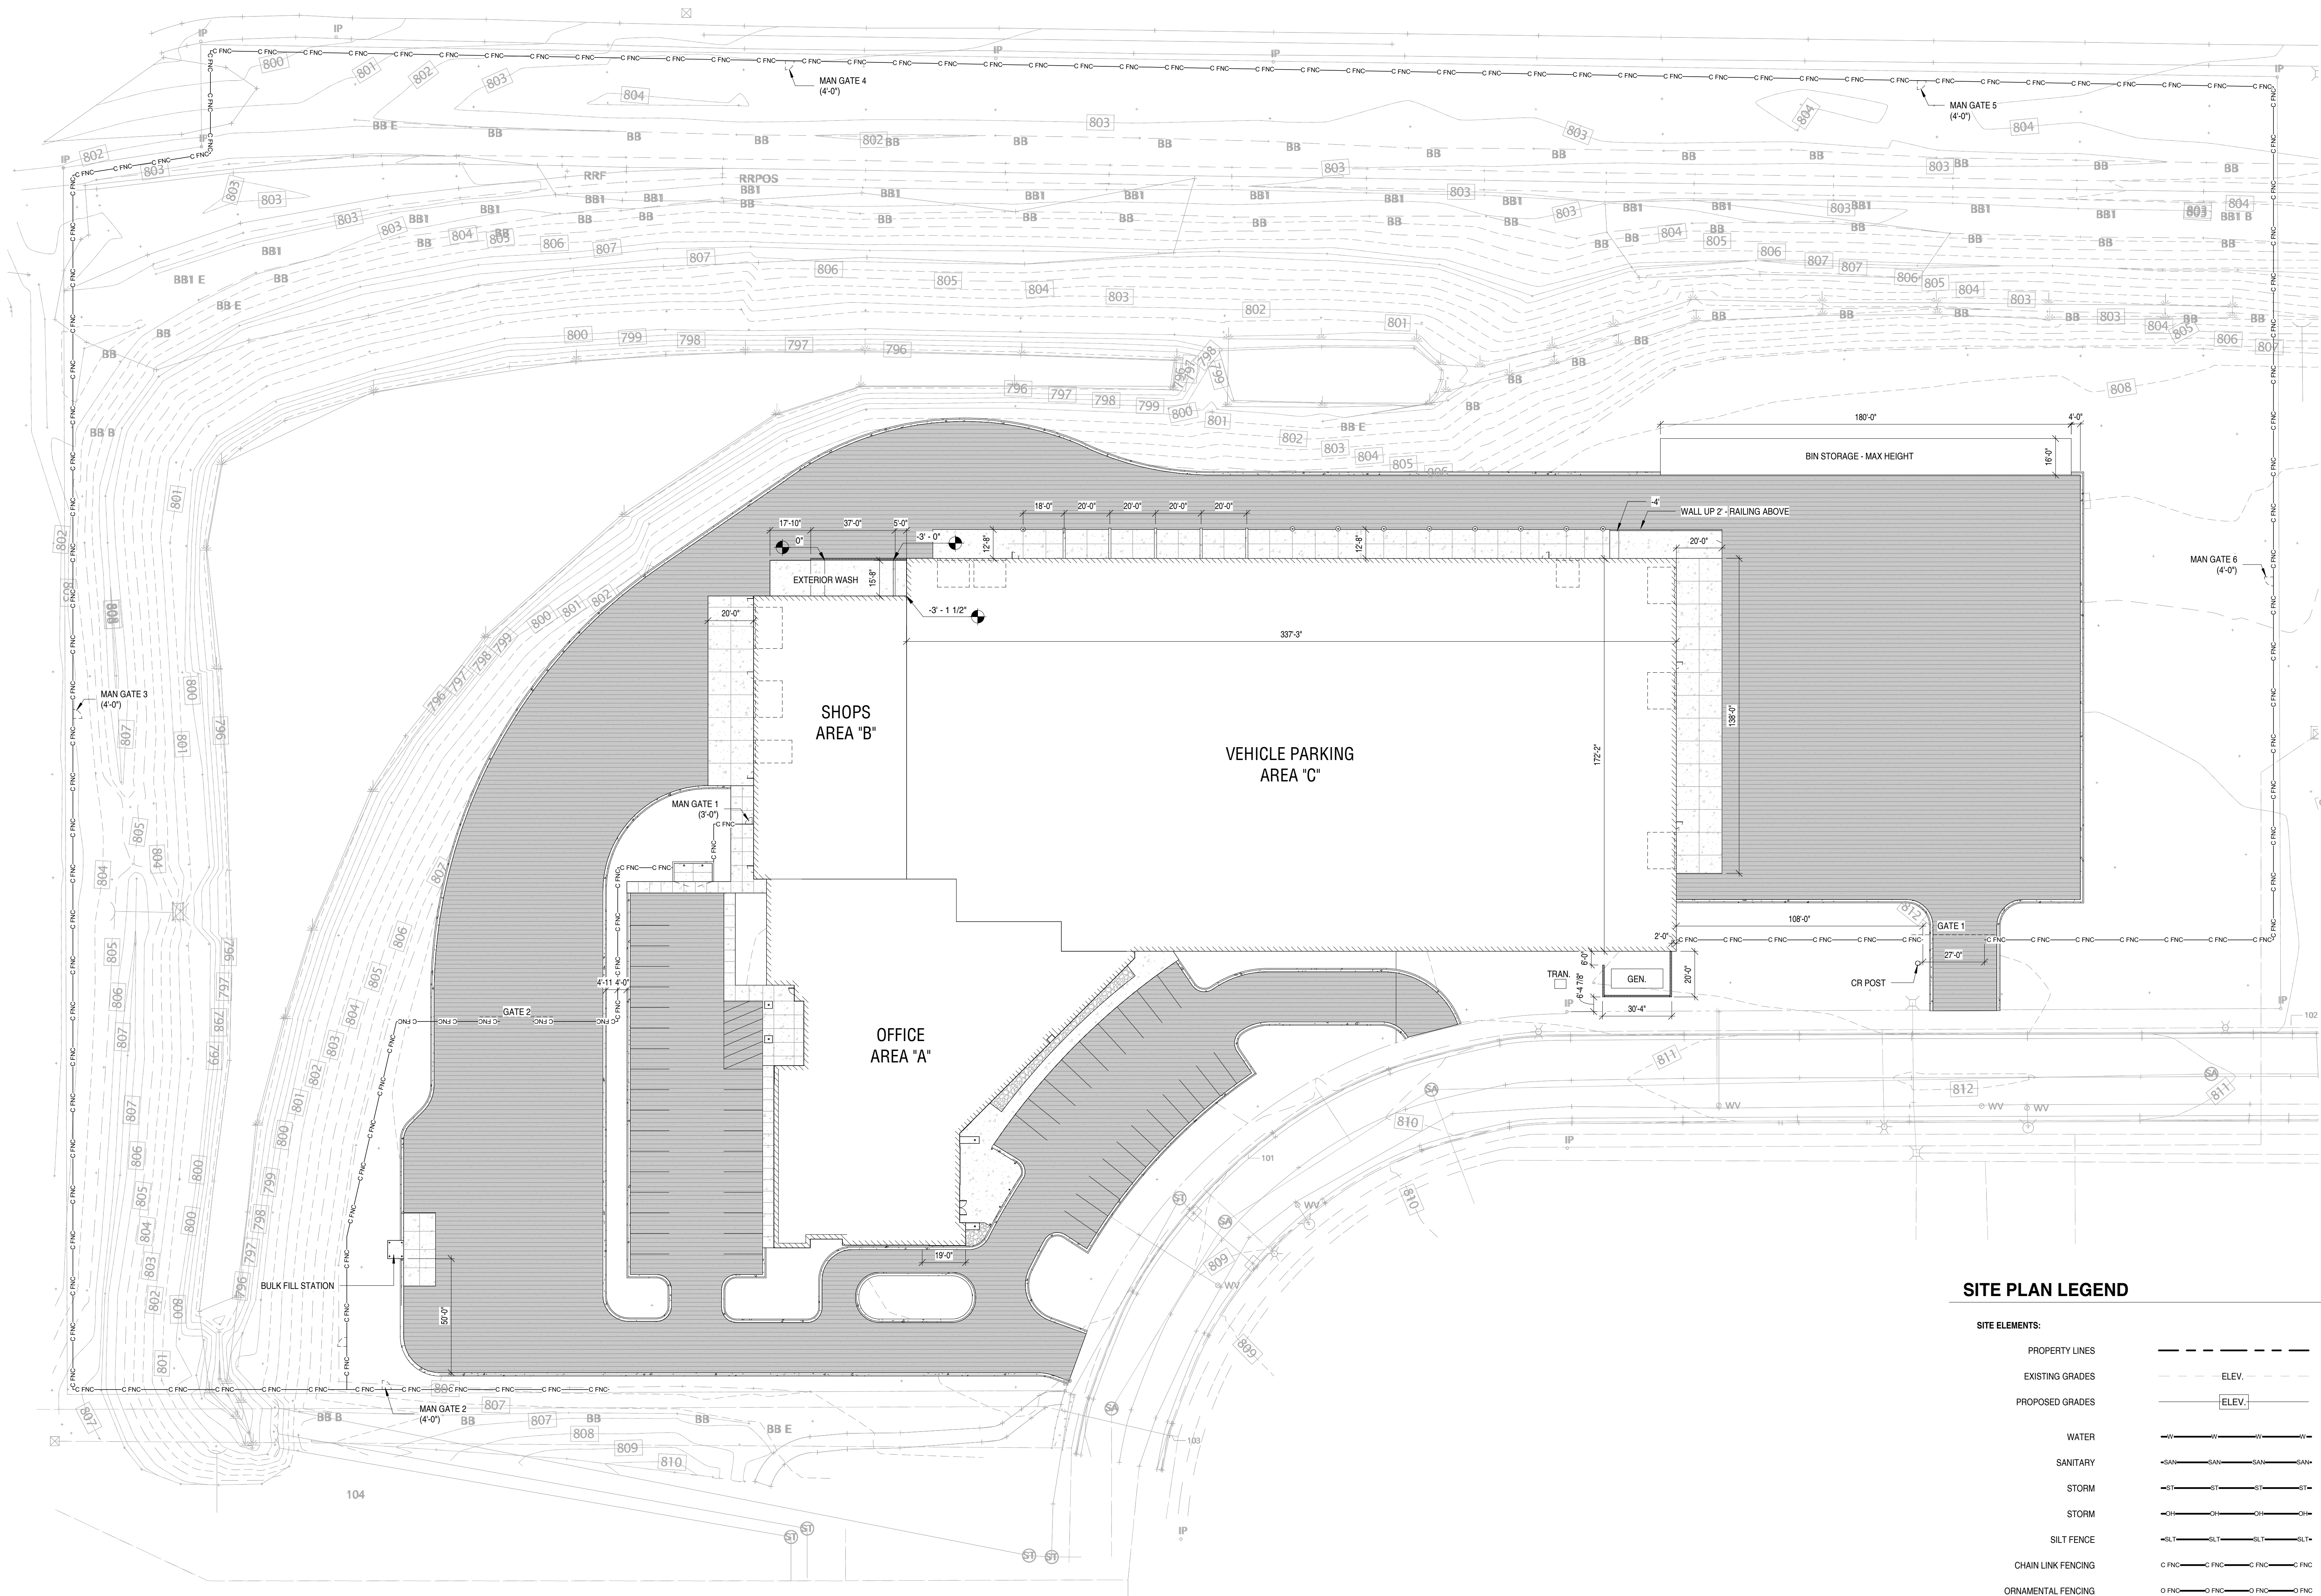

1 Site Plan - Architectural
1" = 30'-0"

PROJECT

PROJECT:

Waukesha Water Utility Operations Center
Chapman Road

OWNER:

Waukesha Water Utility

PROJECT ISSUE DATE:

November 5, 2024

KUENY
ARCHITECTS

10505 Corporate Drive, Pleasant Prairie, WI 53158
phone: 262.857.8101 web: www.kuenyarch.com

©2025 Kueny Architects L.L.C. - All Rights Reserved

CONSULTANTS

ARCHITECT

Kueny Architects

Phone: 262.857.8101

Address: 10505 Corporate Drive, Suite 100

Pleasant Prairie, Wisconsin 53158

Architect of Record - Jon P. Wallenkamp

P:414.690.3197

Project Manager - Lee Anderson

P:262.945.7709

CIVIL

TerraTec Engineering

Phone: 262.377.9905

Address: W67N222 Evergreen Blvd., Suite 205

Cedarburg, WI 53012

Engineer of Record - Linda Johnson

MEP

RTM Engineering Consultants

Phone: 414.273.1432

Address: 316 N. Milwaukee Street, Suite 560


Milwaukee, WI 53202

Engineer of Record - Timothy Larsen, PE

REVISIONS

REV #	DESCRIPTION	DATE

KEY PLAN

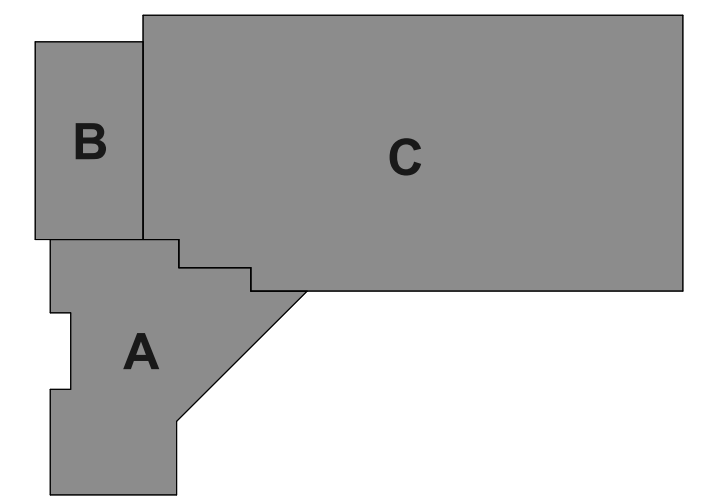

PLAN NORTH
SCALE: As Indicated

SHEET

SHEET TITLE:

Architectural Site Plan

A101